


GENERAL NOTES

1. SEE COVER NOTES FOR ADDITIONAL INFORMATION.
2. ALL MECHANICAL, ELECTRICAL, & PLUMBING FIXTURES ARE SHOWN TO INDICATE LOCATION ONLY. SEE MEP DRAWINGS FOR ADDITIONAL INFORMATION.
3. BASE BUILDING PARTITION TYPES ARE PROVIDED ON A101.
4. REFER TO A401 & STRUCTURAL DWGS. FOR OPENING SIZES.

CONSTRUCTION NOTES

1. LINE OF PANEL ABOVE
2. 42" HIGH GUARD RAILING
3. ROOF ACCESS HATCH AND LADDER
4. REMOVABLE SECURITY GUARD
5. RATED CEILING ASSEMBLY ABOVE - 1 HR HORIZONTAL SHAFT WALL BASED UPON TEST NO. WH-495, PSF 054/067 - LISTING SPANS - PER TEST REQUIREMENTS. SEE RATED ASSEMBLIES SHEET A401 FOR ADD'L INFO.
6. ROOF DRAINS - SEE PLUMBING DWGS.

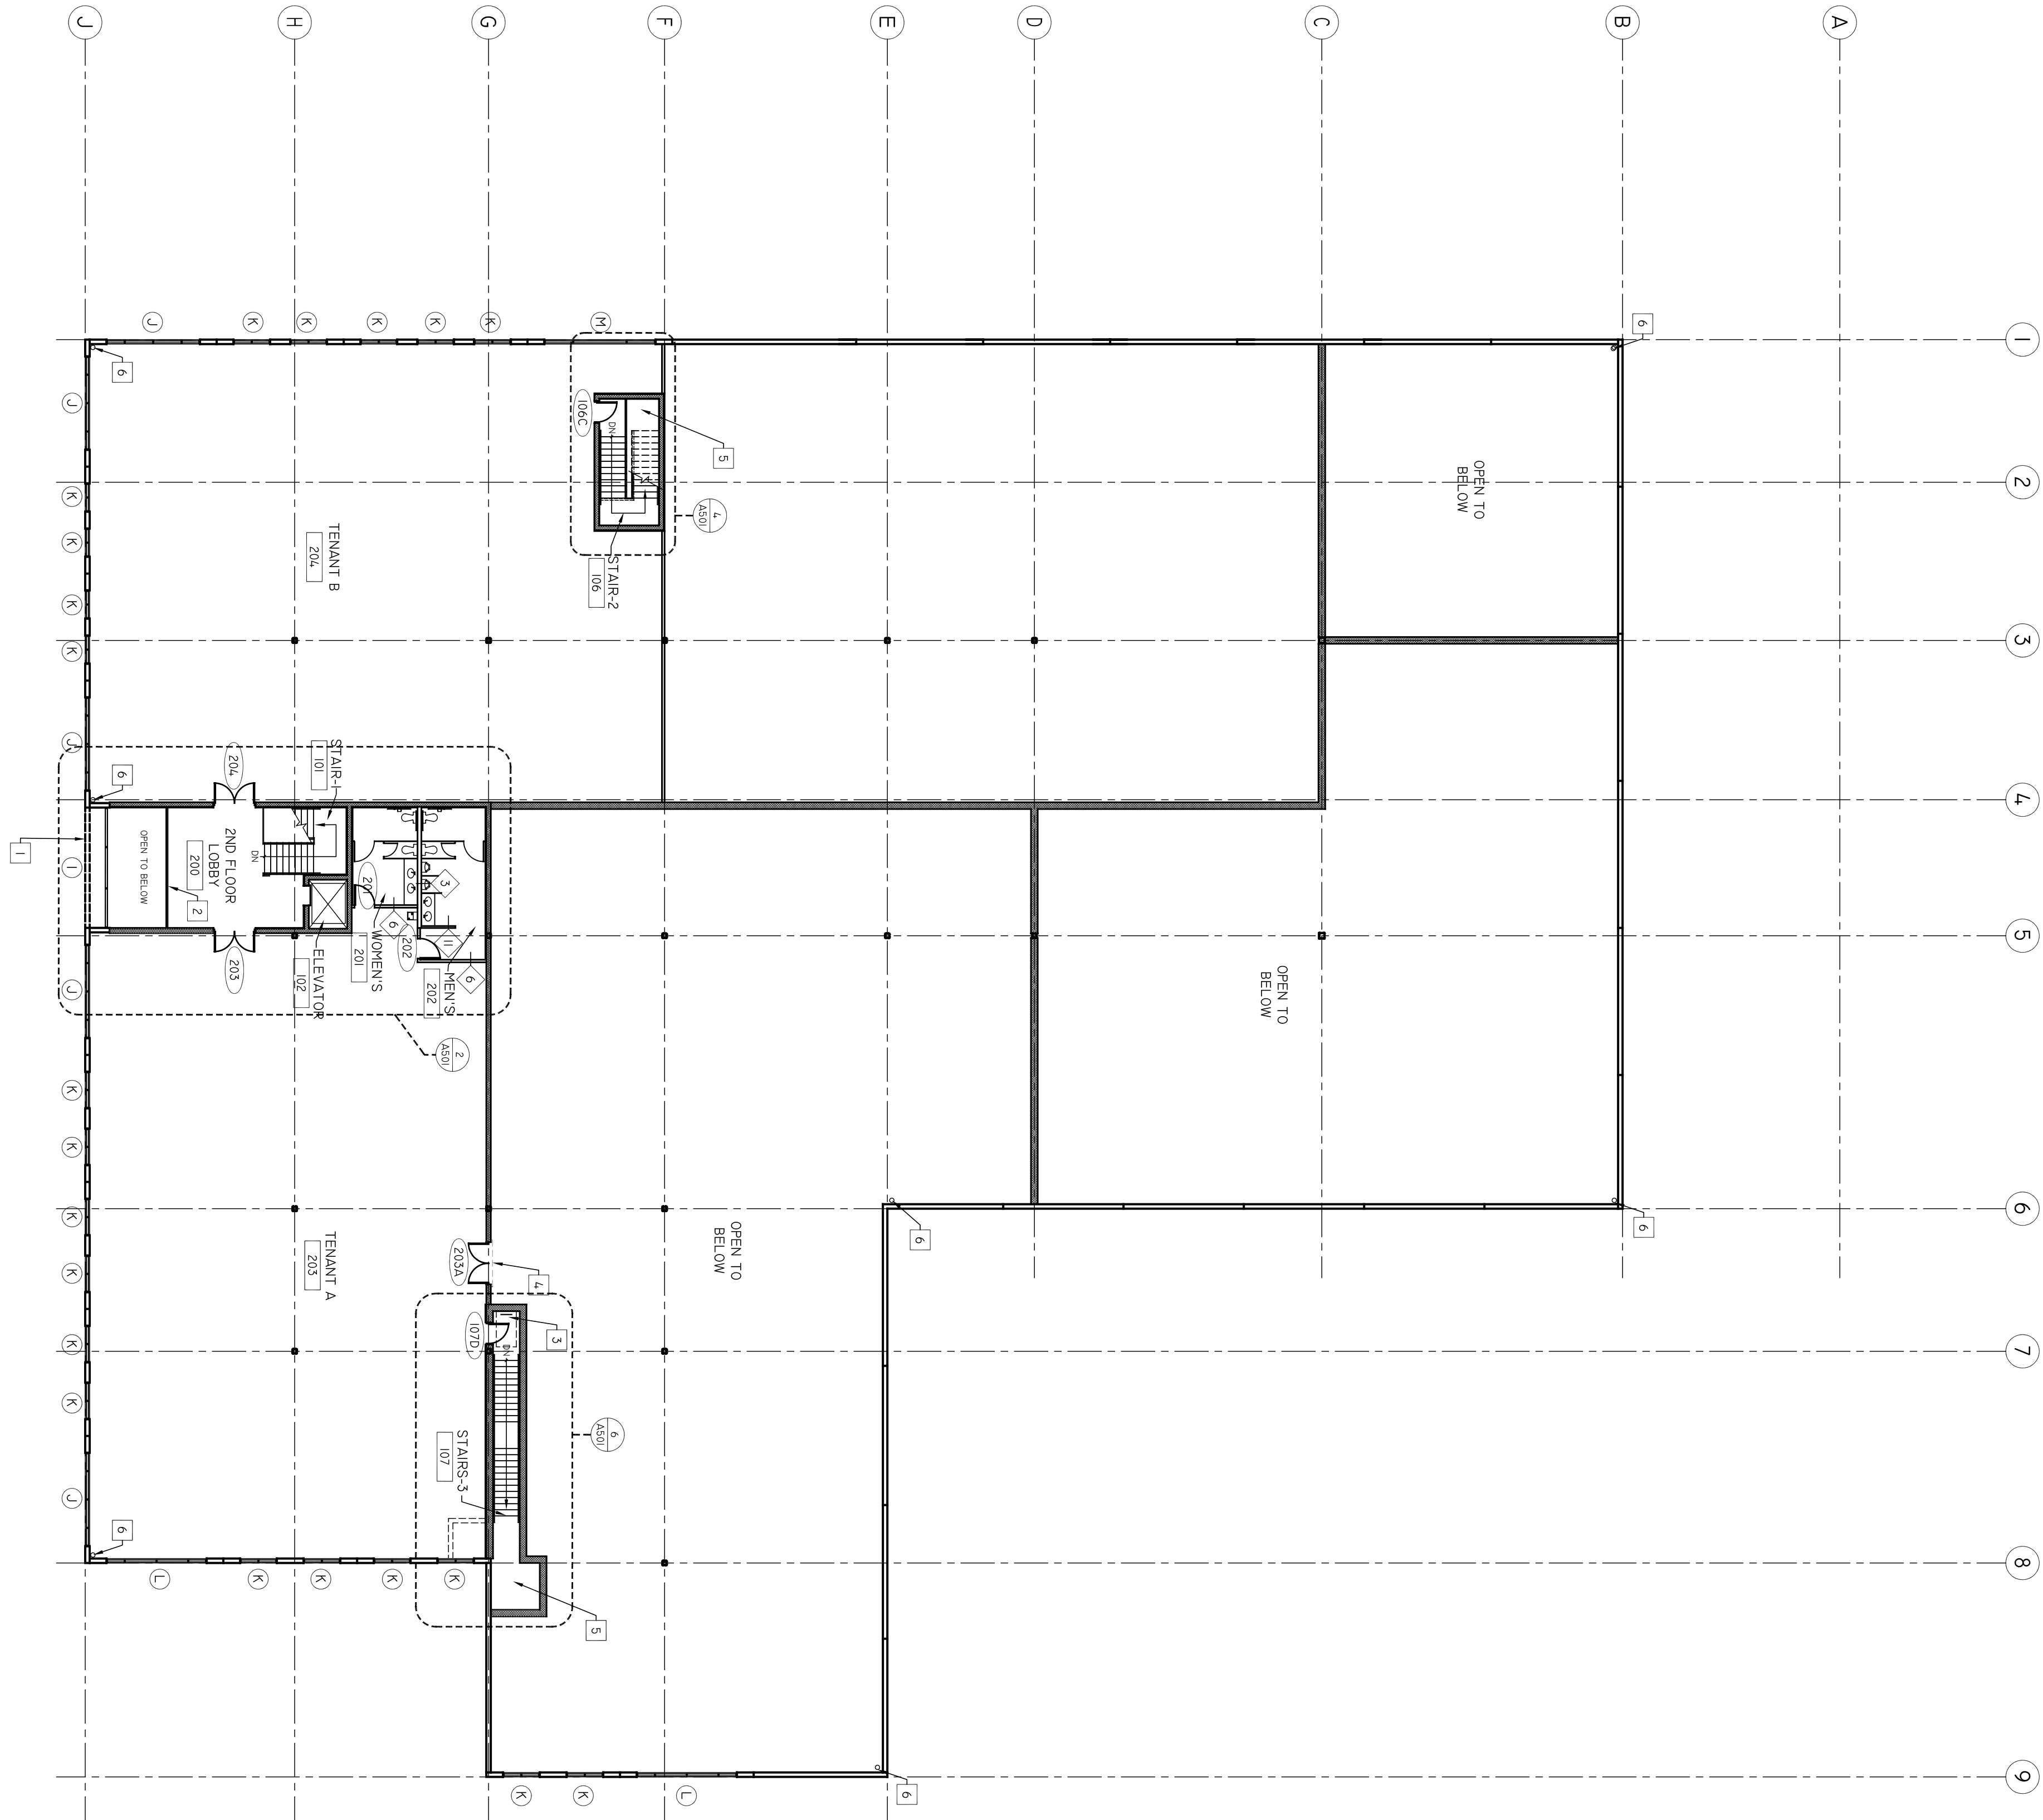

1 2ND FLOOR PLAN
A102 1/16" = 1'-0"

LEGEND

- CHU CONSTRUCTION
NEW DOOR
NEW CONSTRUCTION KEY NOTE
PARTITION TYPE
DOOR TAG
WINDOW TAG
ROOM NUMBER