


FIXTURE SCHEDULE

- F1 2x2 LAY-IN FLUORESCENT DOWNLIGHT
- F2 2x4 LAY-IN FLUORESCENT DOWNLIGHT
- F3 DECORATIVE FLUORESCENT PENDANT
- F4 DECORATIVE HALOGEN PENDANT
- F5 EXHAUST FAN
- F6 6" RECESSED FLUORESCENT DOWNLIGHT

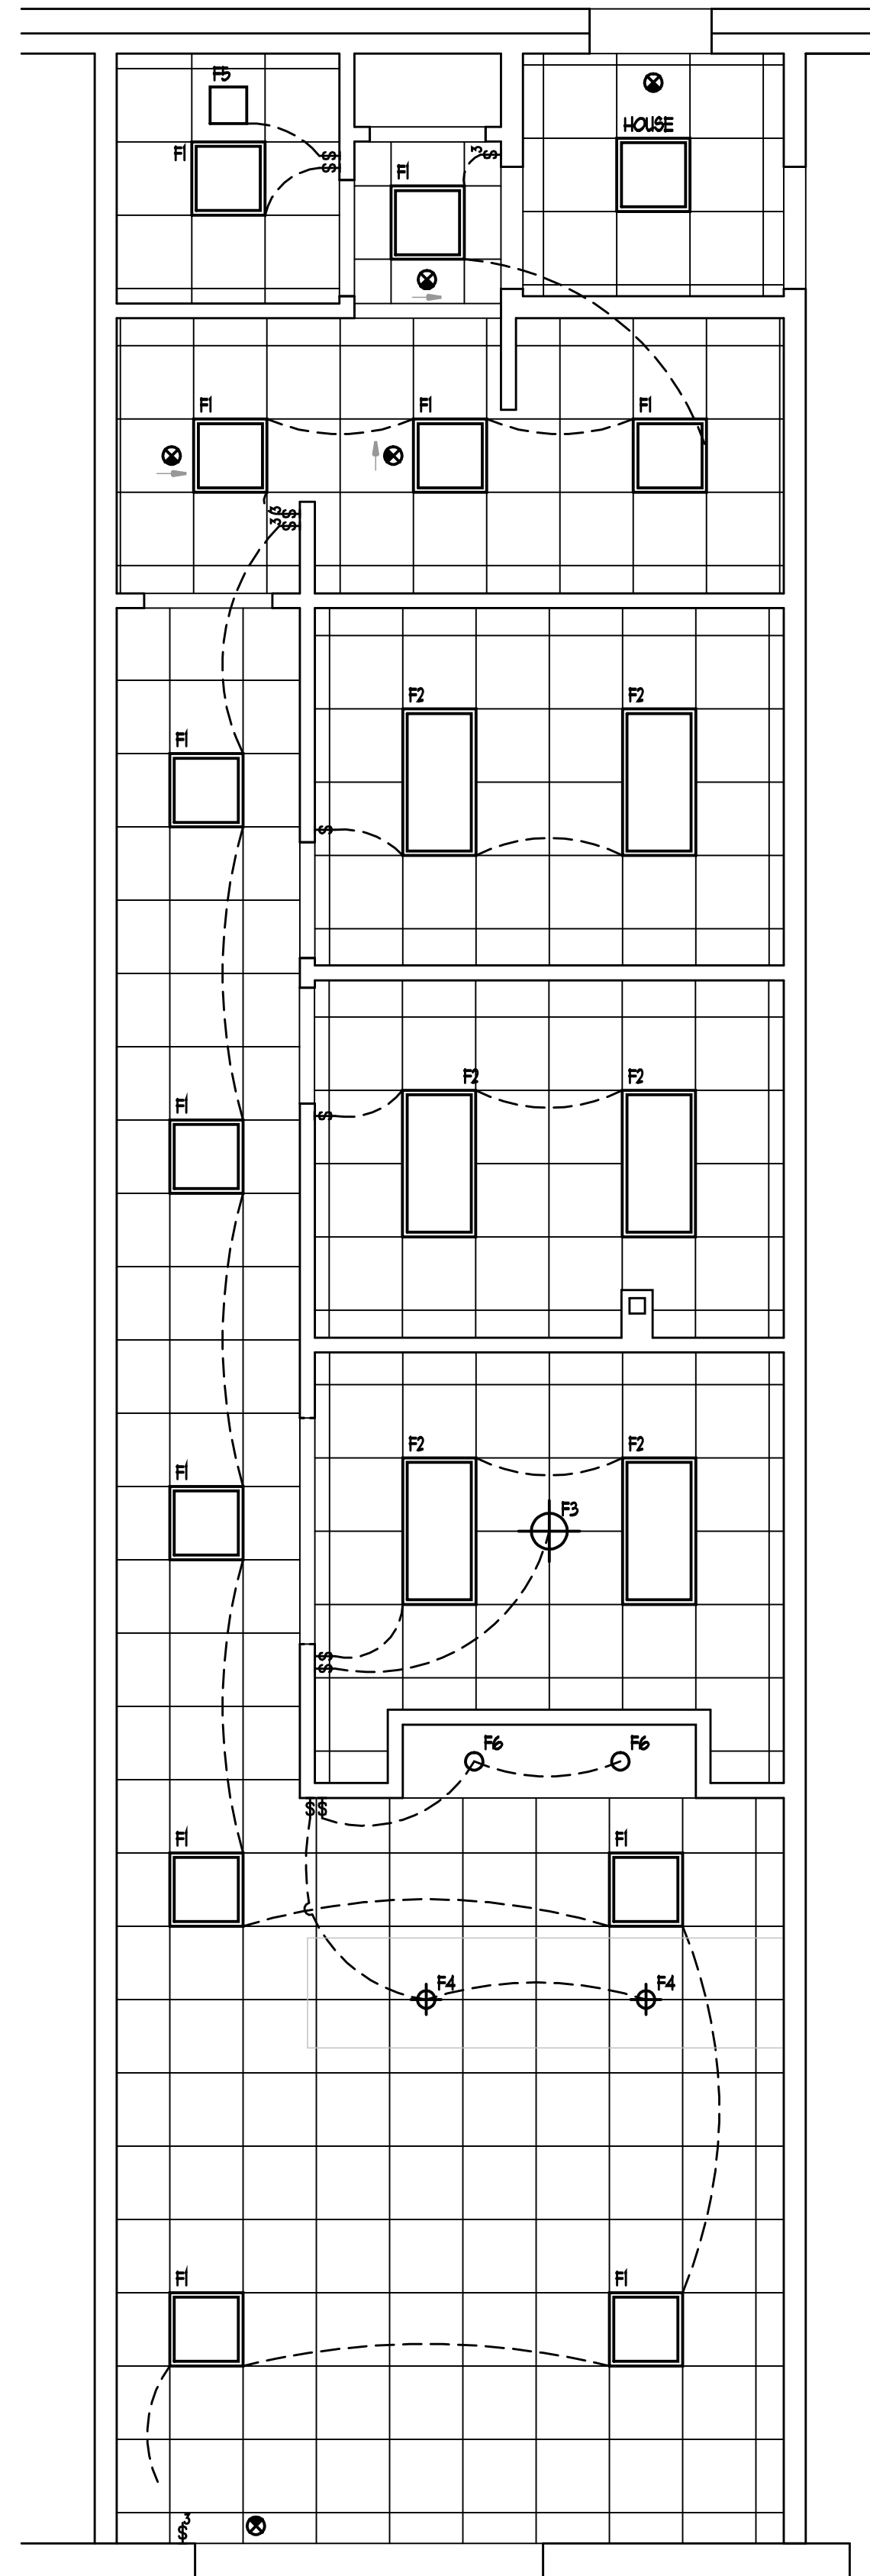

4 LIGHTING PLAN
A3 SCALE: 1/4" = 1'-0"




ELECTRICAL SYMBOL LIST

- THERMOSTATIC EMERGENCY LIGHT. PROVIDES MIN. 90 MINUTES OF ILLUMINATION. HIGH IMPACT THERMOPLASTIC HOUSING. MAINTENANCE FREE LEAD CALCIUM BATTERY. SIMILAR TO LITHONIA ELMZ.
- SINGLE POLE SWITCH - MOUNT 1/4" 48" AFF.
- THREE WAY SWITCH - MOUNT 1/4" 48" AFF.
- 20 AMP DUPLEX RECEPTACLE - MOUNT 1/4" 14" AFF. NOTE: IN KITCHEN, GF - MOUNT 1/4" 48" AFF.
- TELEPHONE OUTLET AND JACK - MOUNT 1/4" 14" AFF.
- DATA PORT WITH COVER - MOUNT 1/4" 14" AFF.
- SMOKE/CARBON MONOXIDE DETECTOR, A.C. "HARD WIRED" W/BATTERY BACKUP CEILING MOUNTED
- LED EXIT SIGN THERMOPLASTIC HOUSING, IMPACT AND SCRATCH RESISTANT, UV STABILIZED, REPLACEABLE CHEVRONS, AUTOMATIC RECHARGE - SIMILAR TO LITHONIA L2180R200 ELN.

Panel Schedule			
Lobby / Reception / Hall lights	20 A	Coffee Bar GFCI	20 A
Lobby / Reception / Hall outlets	20 A	Refrigerator	20 A
Leasing Room / Manager Office lights	20 A	Restroom GFCI	20 A
Leasing Room / Manager Office outlets	20 A	Heat Pump	60 A
Model Office / Storage / Bathroom lights	20 A	Air Handler	20 A
Model Office / Storage / Bathroom outlets	20 A	Water Heater	20 A
Spare		Spare	
Spare		Spare	
Spare		Spare	
Spare		Spare	

200 Amp Single Phase panel

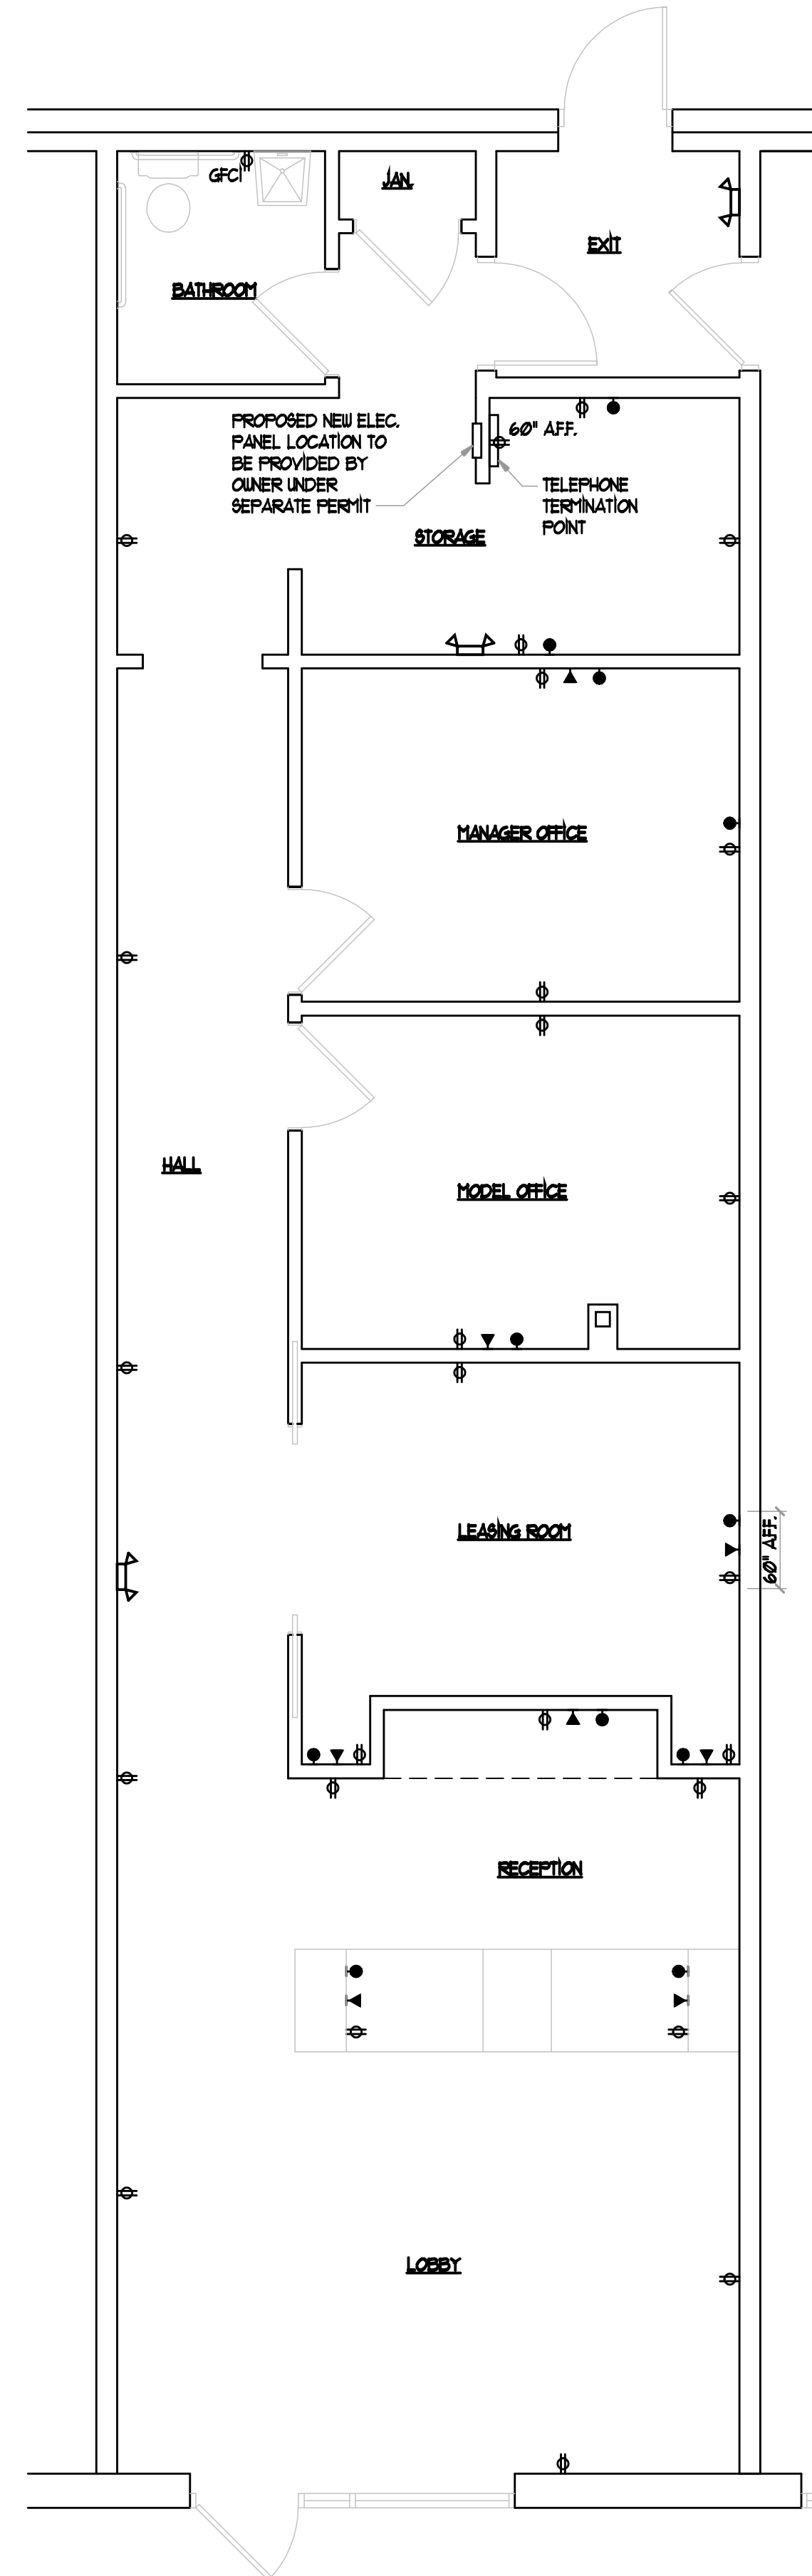

12 ELECTRICAL PLAN
A3 SCALE: 1/4" = 1'-0"



PROJECT # DATE: 06/11/12 REV/NOV:

ANDREW FELL
ARCHITECTURE AND DESIGN

302 WEST HILL, SUITE 201
CHAMPAIGN, ILLINOIS 61820
PHONE: 217-353-2890
FAX: 217-353-8493
EMAIL: andrewfell@comcast.net

These drawings and specifications are the property and copyright of Andrew Fell, Architecture and Design and shall not be used on any other work except by written permission of the architect. Copying without the architect's consent is prohibited. Dimensions shall be verified on the job site. Any discrepancy shall be brought to the notice of the Architect prior to the commencement of any work.

COMMERCIAL BUILDING
UNIT BUILD-OUT
512 SOUTH WELLS STREET
CHAMPAIGN, ILLINOIS 61820