

 = AVAILABLE SUITES

ADG

ARCHITECTURAL DESIGN GROUP, LLC
 1717 EDGEMOND AVENUE
 SUITE 100
 FARMERS BRANCH, GA 30204
 TEL: 770-521-1818
 FAX: 770-521-1875

DATE: 09/22/2020
 TIME: 10:00 AM
 PROJECT: EAST OF MAIN RETAIL
 SHEET: ARCHITECTURAL FLOOR PLAN
 DRAWN BY: [Name]
 CHECKED BY: [Name]
 APPROVED BY: [Name]




ISSUED FOR CONSTRUCTION
 DATE: 09/22/2020
 REVISED 04/16/2020

EAST OF MAIN RETAIL
 ARCHITECTURAL FLOOR PLAN

ARCHITECTURAL FLOOR PLAN

DATE: 09/22/2020
 TIME: 10:00 AM
 SCALE: 1/8" = 1'-0"

A-1

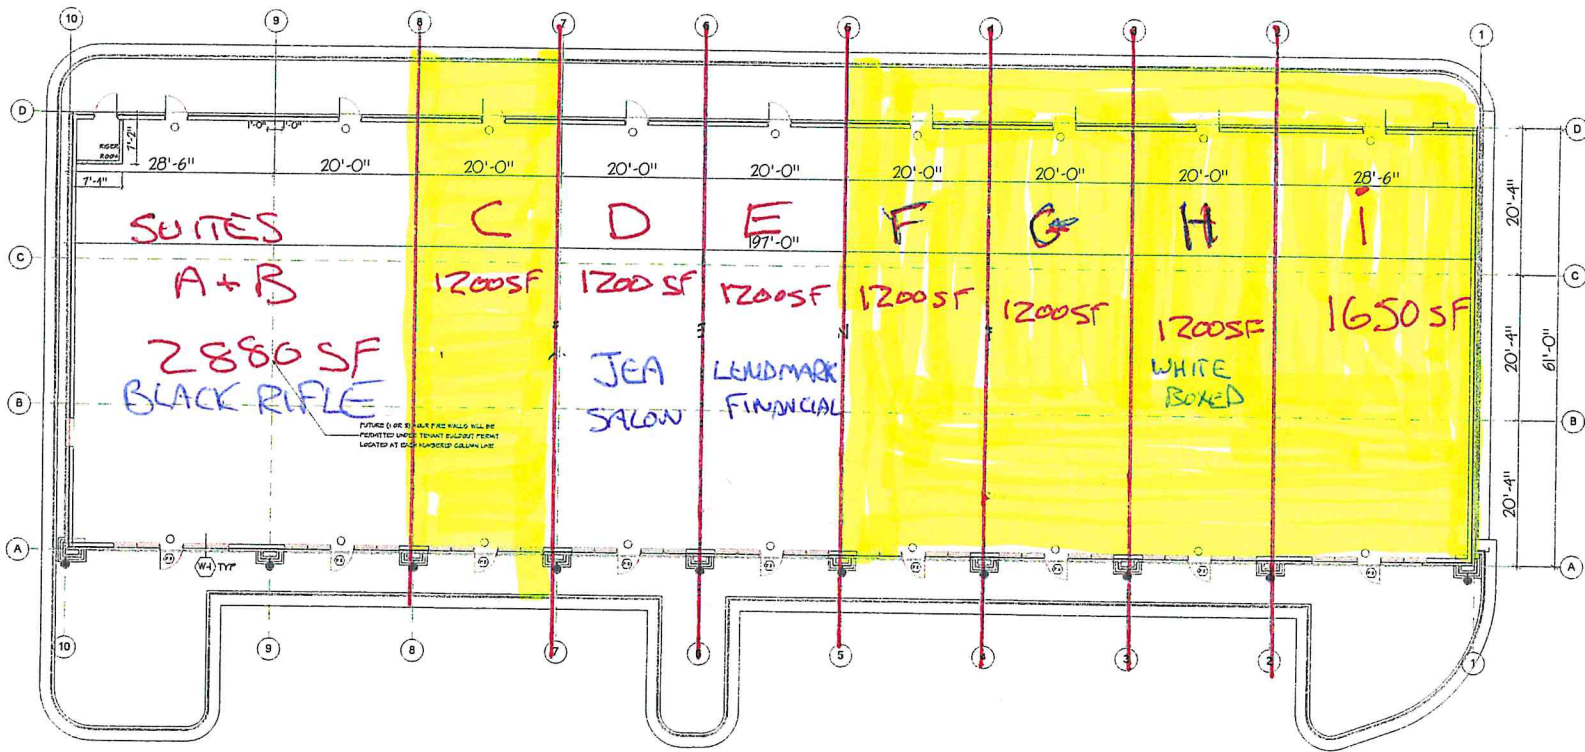

FUTURE D OR B BLACK PAZE WALLS WILL BE
 PAINTED UNLESS TENDANT REQUEST PERMIT
 LOCATED AT GRID NUMBERED COLUMN LINE

- GENERAL NOTES:
- PROVIDE ADDRESS NUMBERS ON THE BUILDING. THEY MUST BE VISIBLE FROM THE STREET AN DA MINIMUM OF 6" CONTRASTING IN COLOR. PROVIDE SUITE NUMBERS ON BOTH FRONT AND REAR DOORS OF ALL SUITES WITH SIGNAGE ON THE SPRINKLER RISER ROOM.
 - FURNISH AND INSTALL FIRE ALARM PER NFPA 13 FOR SPRINKLER SYSTEM.
 - PROVIDE FIRE EXTINGUISHERS DURING CONSTRUCTION.
 - PROVIDE KNOX BOX AT THE RISER ROOM.

Story

1/8" = 1'-0"