


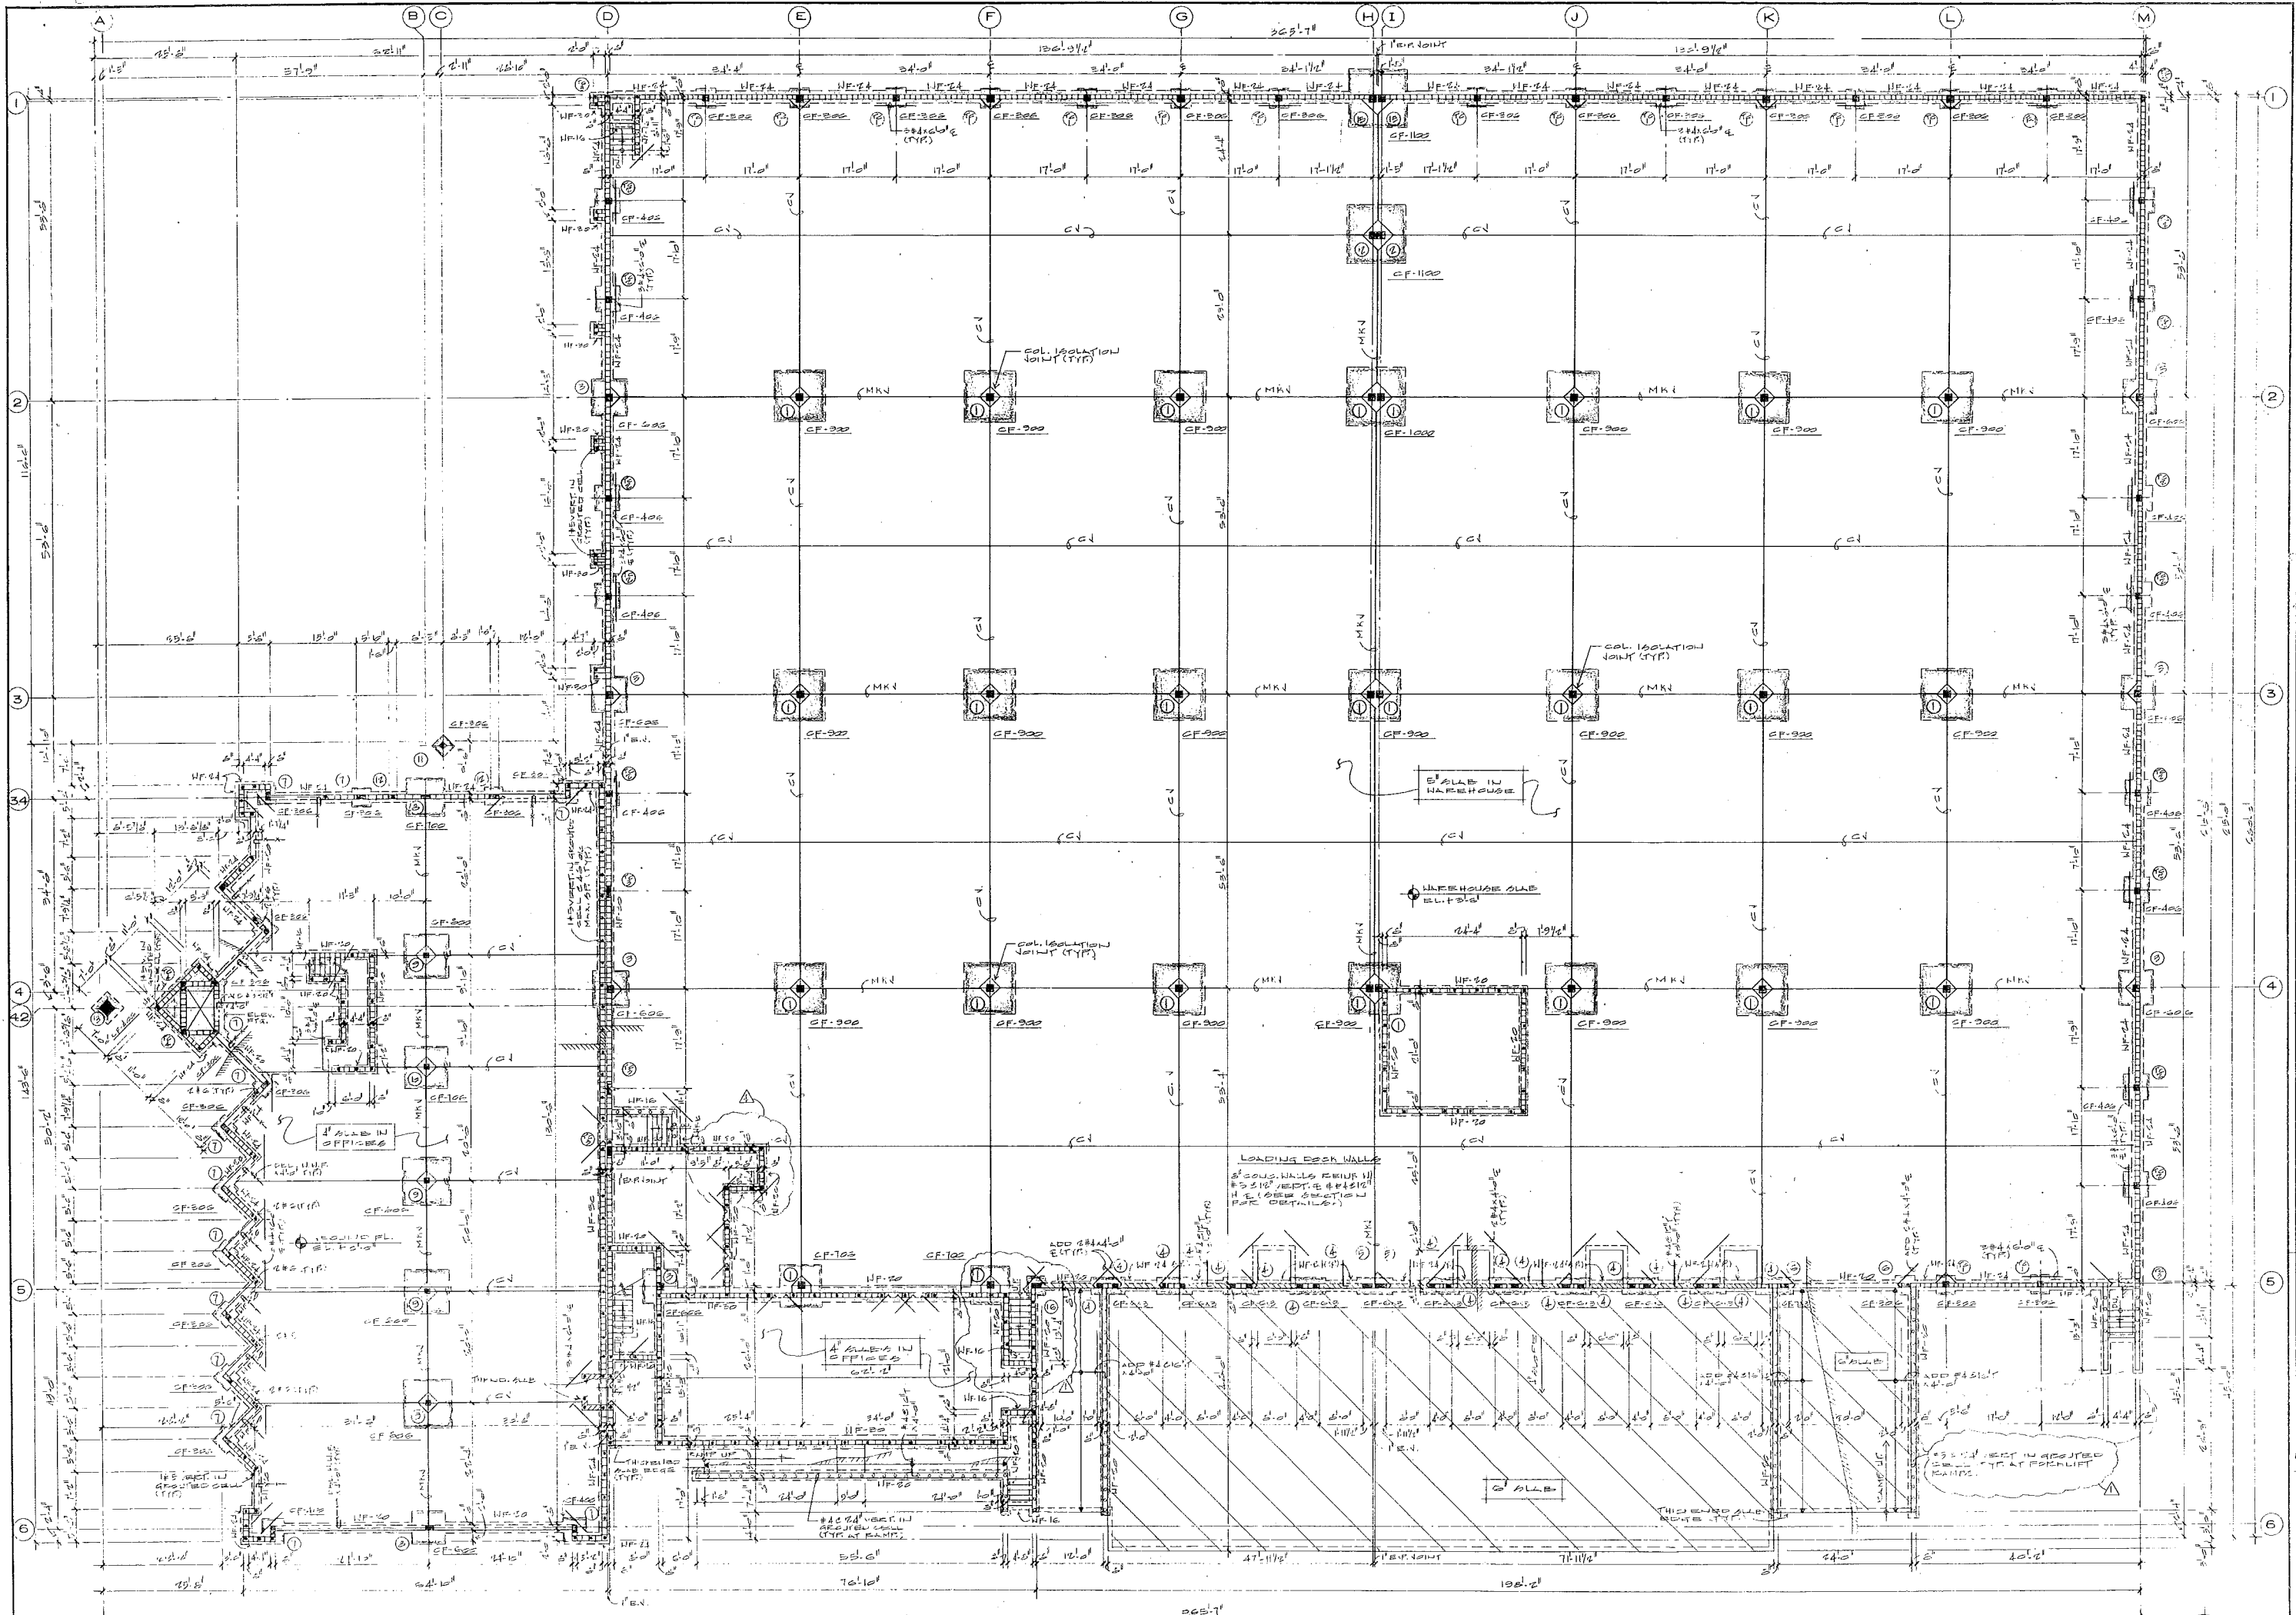

STAIR REIN.
 REIN. TO BE SUPPLIED BY OTHERS. SEE REIN. DETAIL. W/ 3/4" x 10' x 10' TYP.
 REIN. TO BE SUPPLIED BY OTHERS. SEE REIN. DETAIL. W/ 3/4" x 10' x 10' TYP.
 REIN. TO BE SUPPLIED BY OTHERS. SEE REIN. DETAIL. W/ 3/4" x 10' x 10' TYP.

MASONRY NOTE: ALL MASONRY WALLS TO HAVE #2 REIN. TYP. PER 2" WALL HOR. MASONRY REIN. @ 16" O.C.
 NOTE: FOR ALL VERTICAL REIN. PROVIDE FOOTING COV. & STANDARD 90° HOOKS AT TOP BEAM OR TIE BEAM.

FOUNDATION & GROUND FLOOR FRAMING PLAN
 SCALE: 3/32" = 1'-0"
 FOR SYSTEM NOTES SEE DWG. S-5


C & A engineers, inc.
 10810 N. W. 27th Ave.
 Fort Lauderdale, FL 33322
 (305) 582-1500
 (305) 582-1501
 (305) 582-1502

REVISIONS	
1	ISSUED FOR PERMITS
2	FOR REVIEW
3	FOR REVIEW
4	FOR REVIEW
5	FOR REVIEW
6	FOR REVIEW

Architect
 Interior Design
 Structural Engineering
 License No. 44-000884
 (305) 582-3045
 10540 NW 26th St. Suite 201 Fort Lauderdale, FL 33322

RODRIGUEZ PEREIRA ARCHITECTS, INC.

Corporate Headquarters
 Pharmed Group Corp.
 10000 NW 26th St. Suite 201 Fort Lauderdale, FL 33322

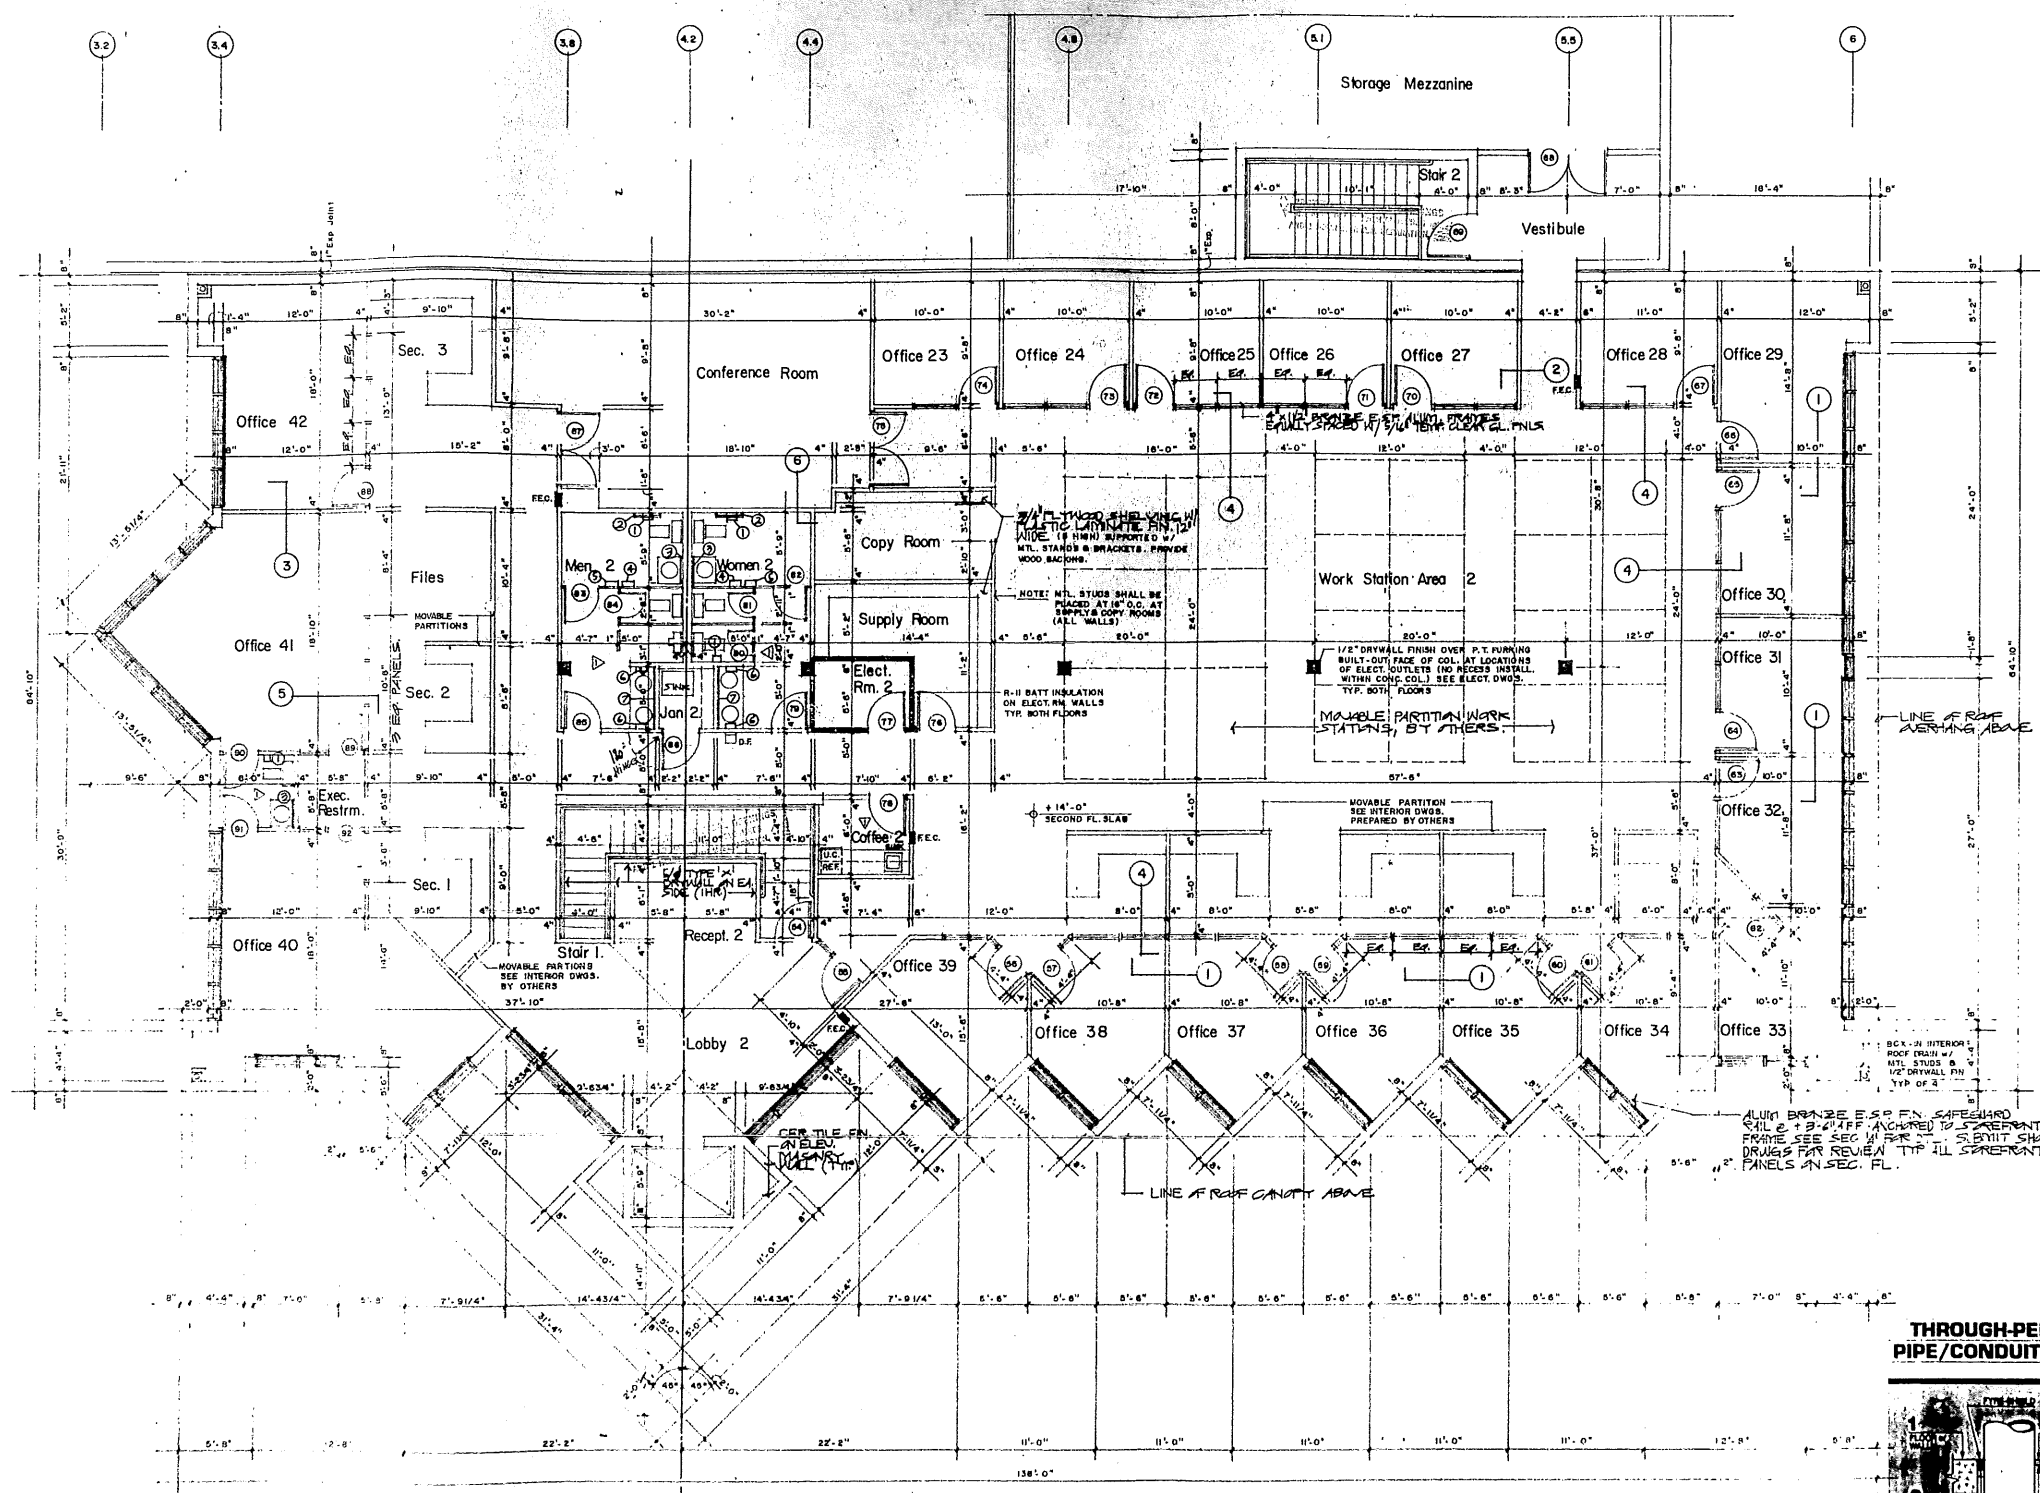

Second Floor Office Plan

3/16" = 1'-0"

REVISIONS	BY
2-18-94	

Architect
Rodríguez
Perera
Architects, Inc.
10540 N.W. 20th St., Suite 101, Miami, FL 33172
(305) 582-8045




Signature
Date: 2-18-94

15

Corporate Headquarters for:
Pharmed Group Corp.
Dade County, Florida

Date	2-18-94
Scale	
Drawn	
Job	9301
Sheet	A-7
Of	Sheets

THROUGH-PENETRATION FIRESTOP SYSTEM for PIPE/CONDUIT THROUGH CONCRETE FLOOR/WALL

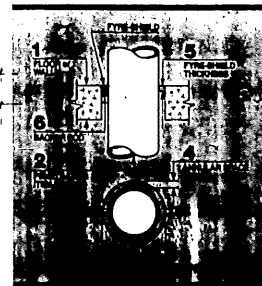

- COMMENTS:**
- Clean and dry substrate surfaces.
 - Install damming material to proper depth.
 - Install FYRE-SHIELD and tool to insure intimate contact to all surfaces.
 - IMMEDIATE FIRE RATING ACHIEVED!
- These comments are based on FYRE-SHIELD's performance per ASTM-E814 (UL 1479) Fire Test and UL Through Penetration Firestop System No. 208.

SYSTEM CHARACTERISTICS

1. PENETRATION TYPE	2. PENETRATION SIZE	3. PENETRATION MATERIAL	4. PENETRATION METHOD	5. PENETRATION RATING	6. PENETRATION COMMENTS
CONCRETE FLOOR/WALL	4" - 12"	Steel Pipe, Conduit, etc.	Hand-applied	1, 2, 3	See Notes
CONCRETE FLOOR/WALL	12" - 16"	Steel Pipe, Conduit, etc.	Hand-applied	1, 2, 3	See Notes
CONCRETE FLOOR/WALL	16" - 24"	Steel Pipe, Conduit, etc.	Hand-applied	1, 2, 3	See Notes

