




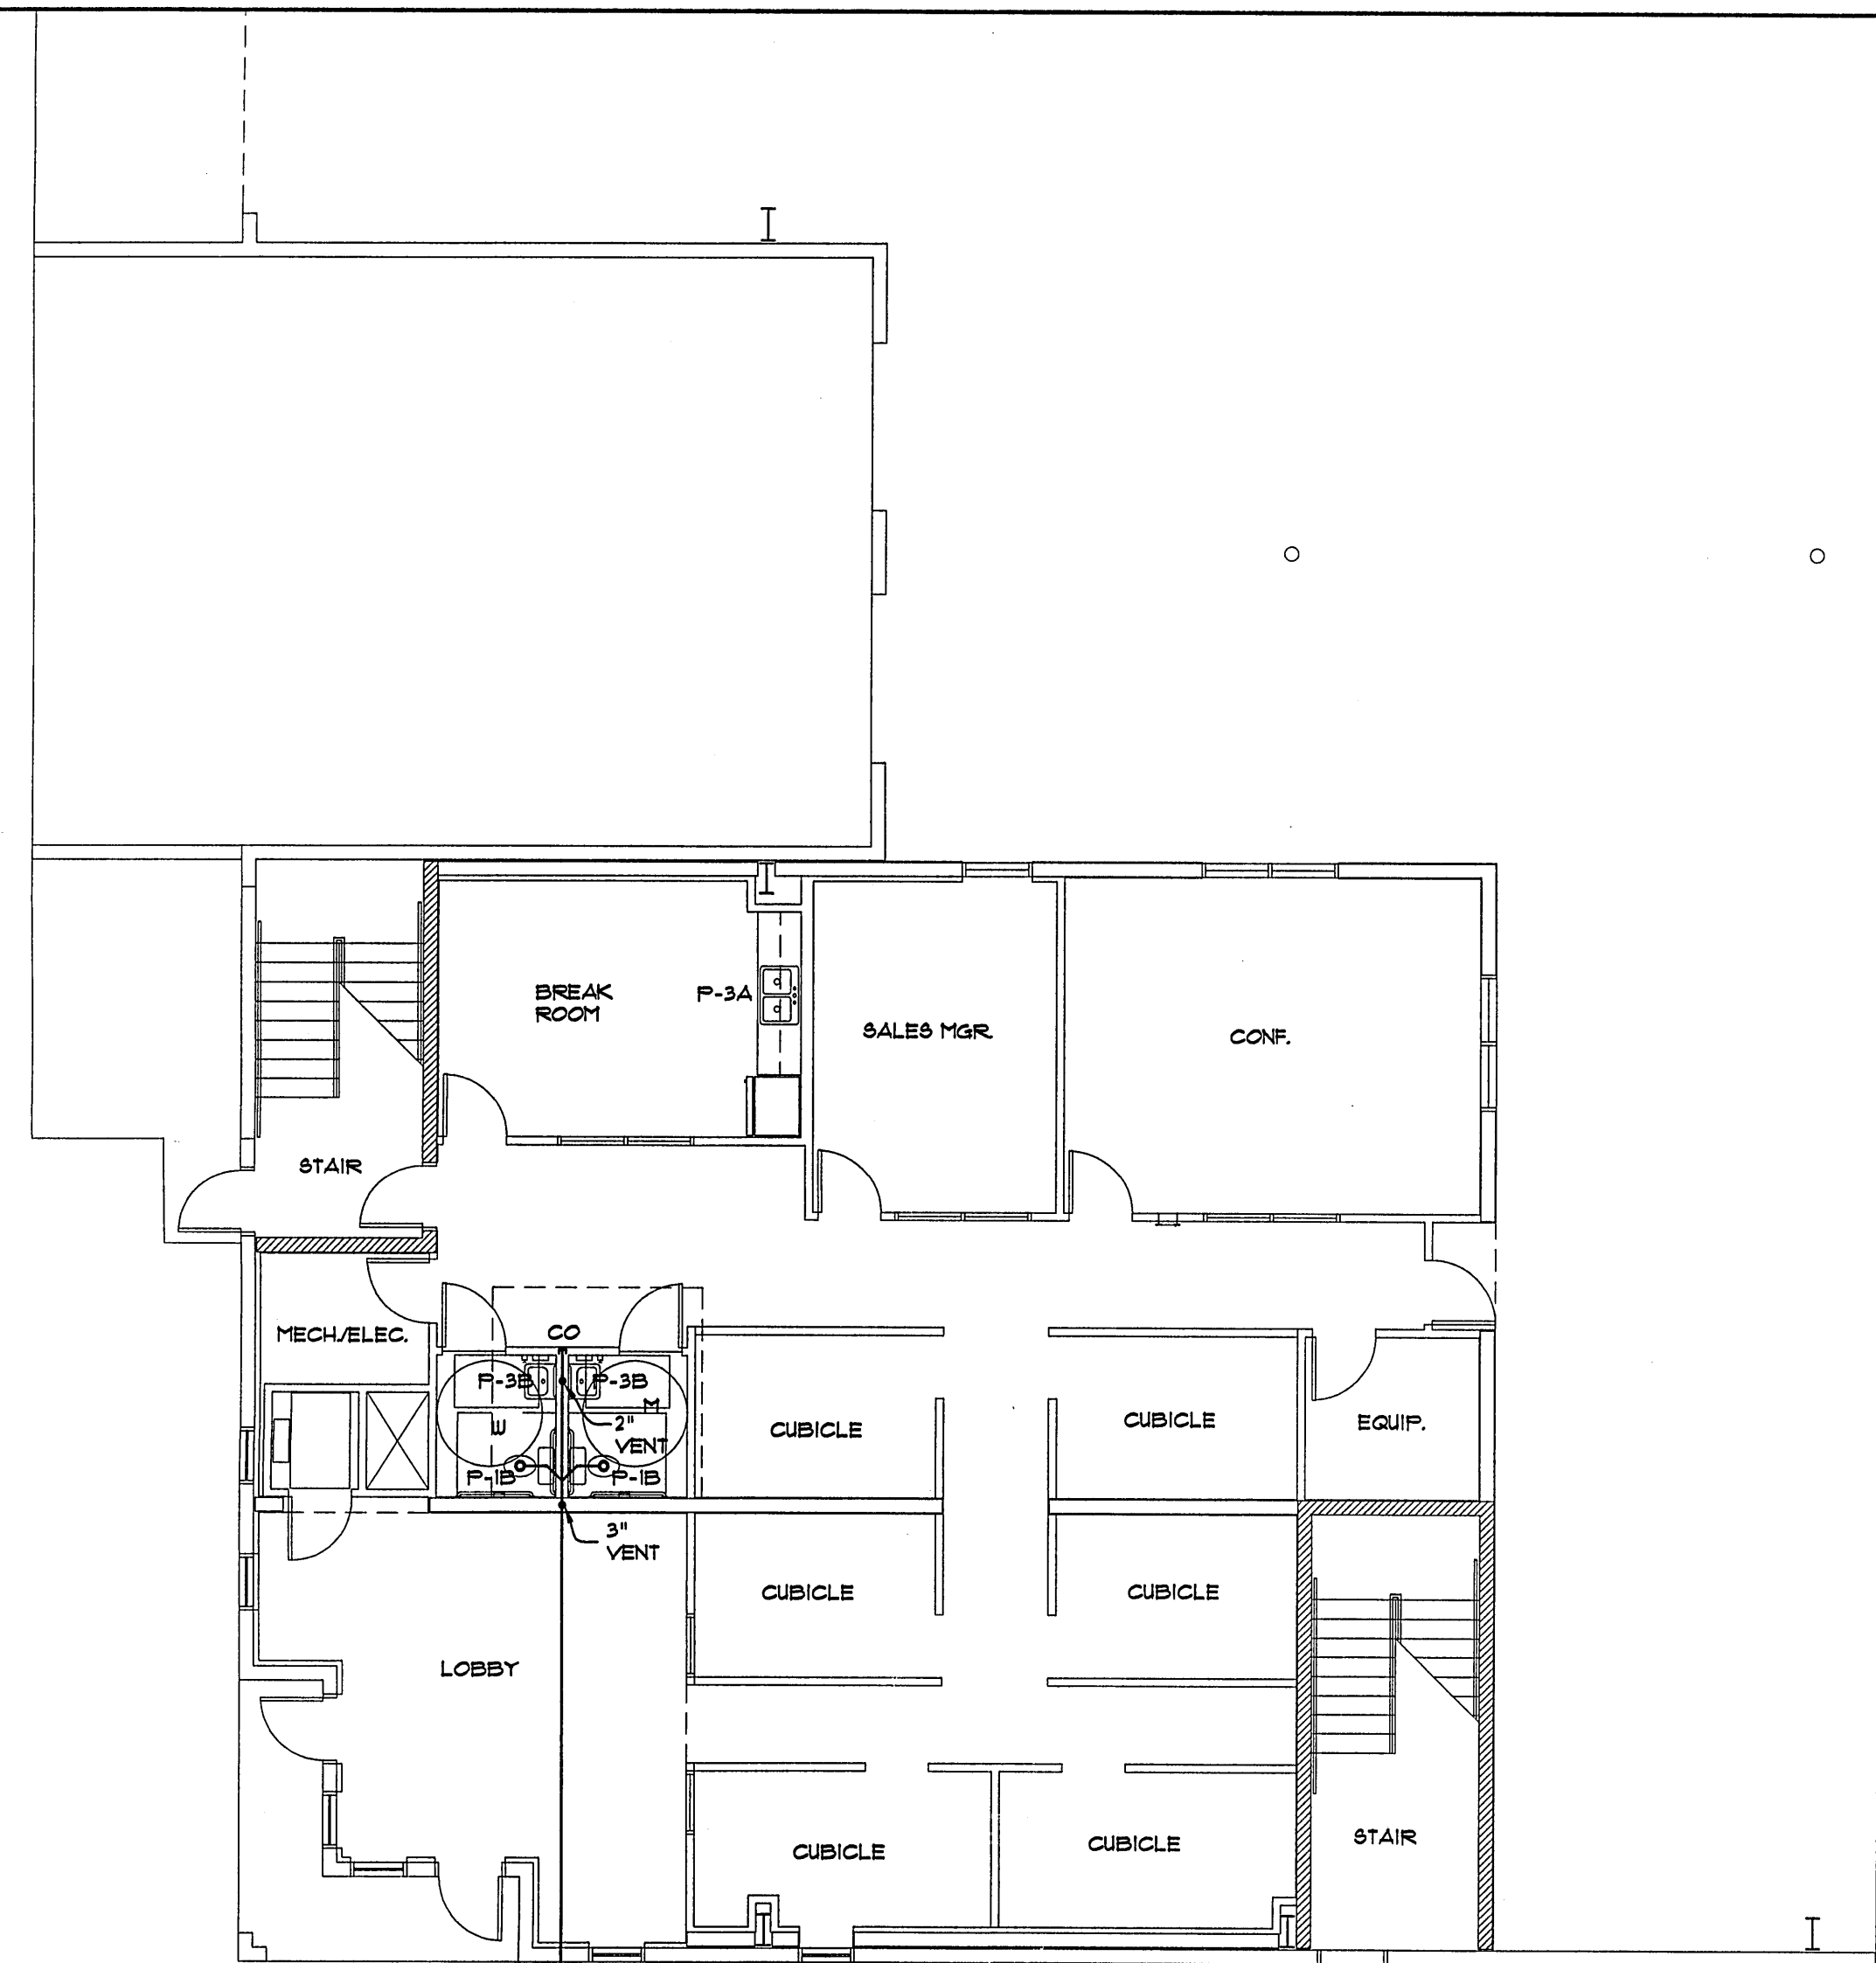


ENLARGED PLAN 'A'
SCALE: 1/8"=1'-0"

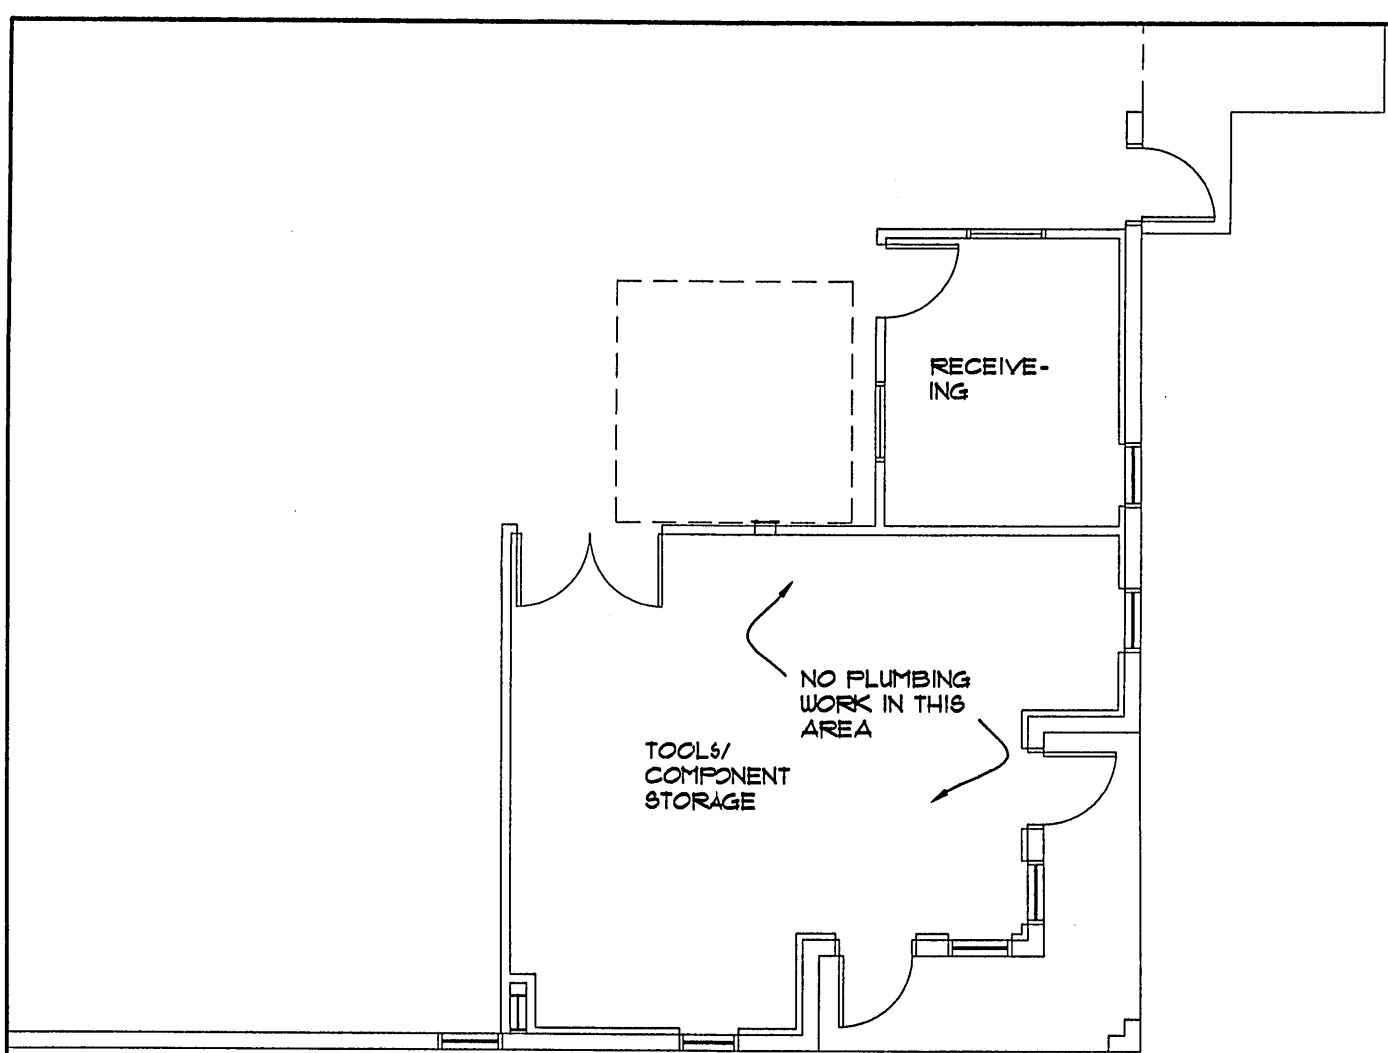

ENLARGED PLAN 'C'
SCALE: 1/8"=1'-0"

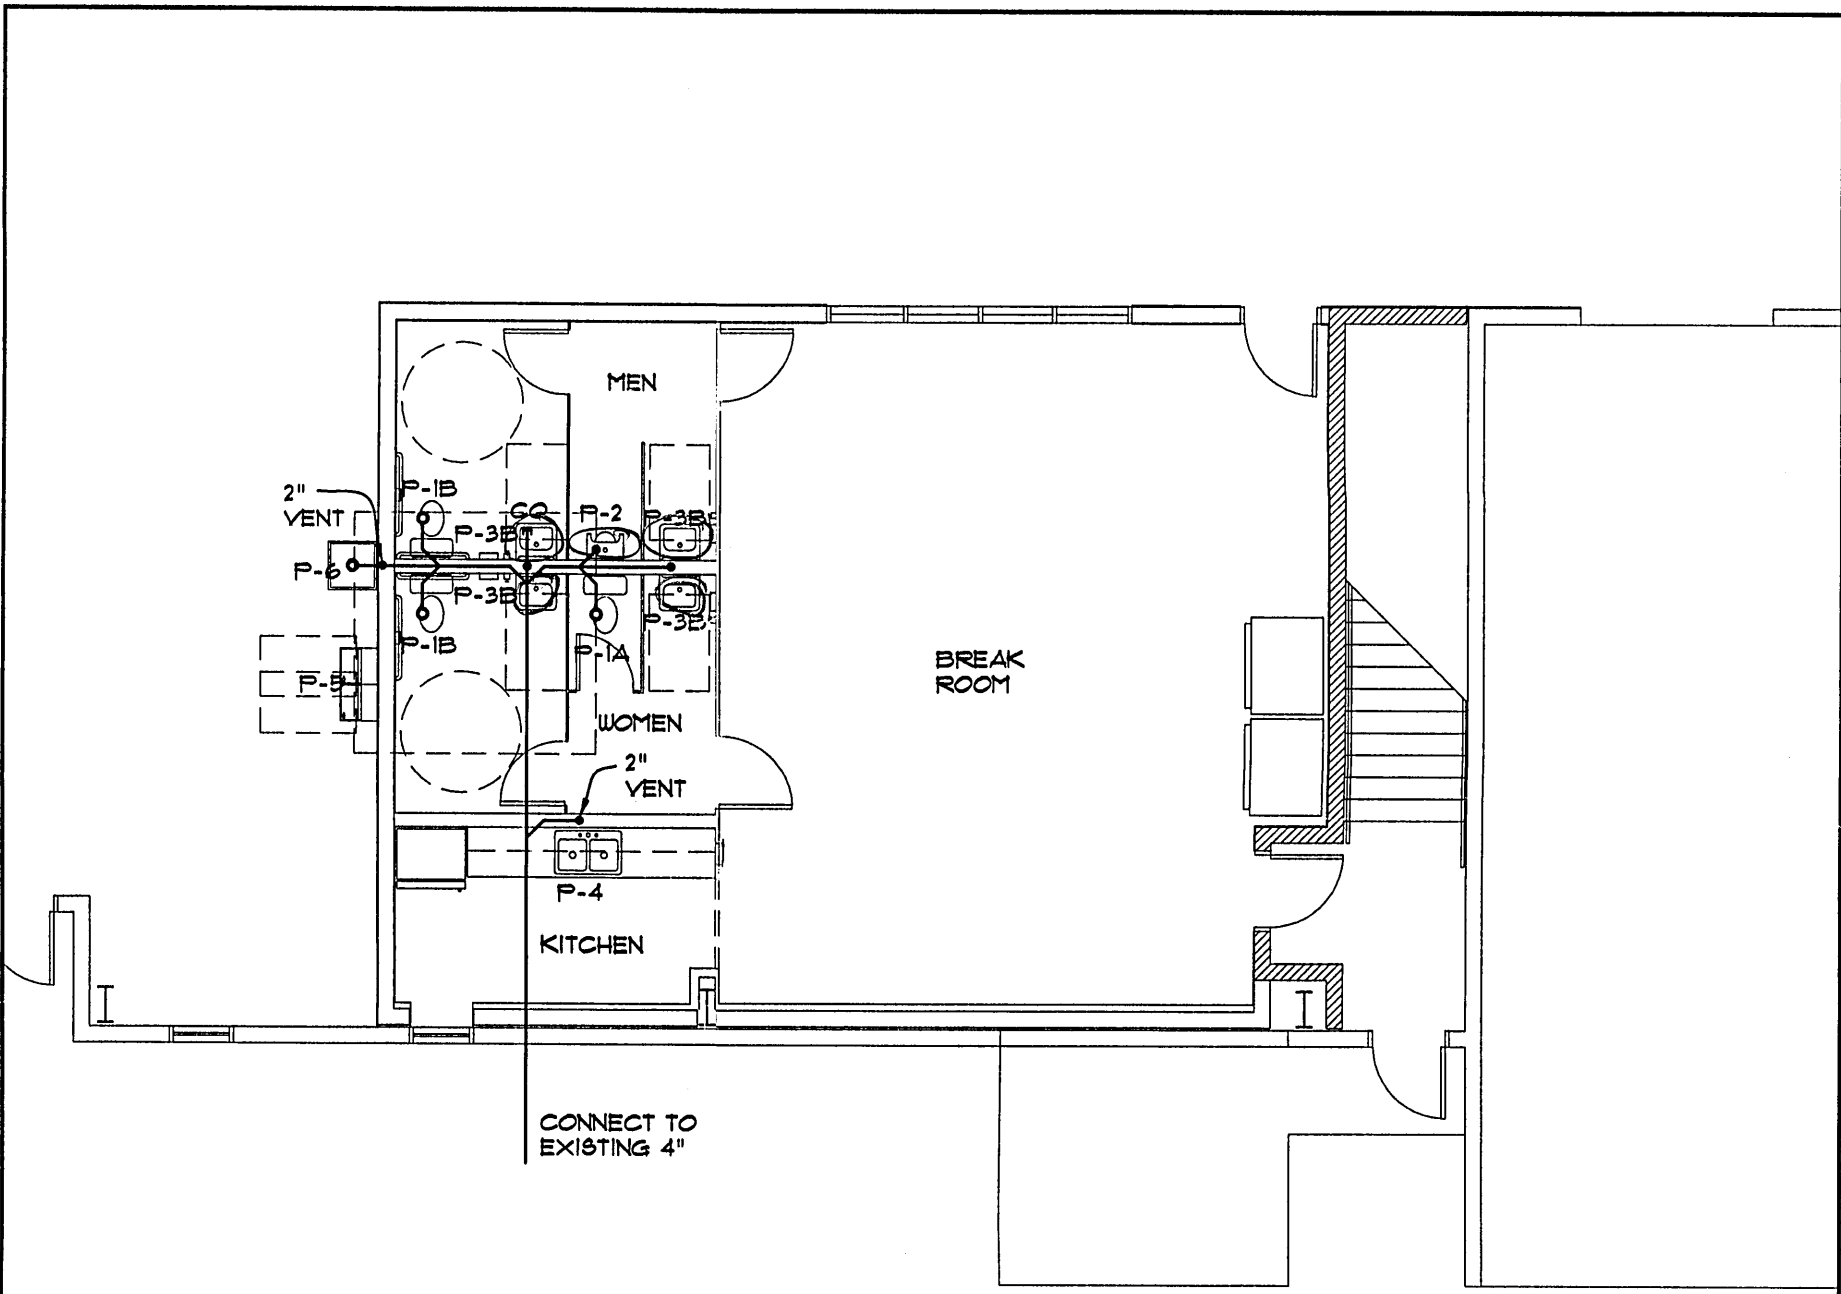

ENLARGED PLAN 'B'
SCALE: 1/8"=1'-0"

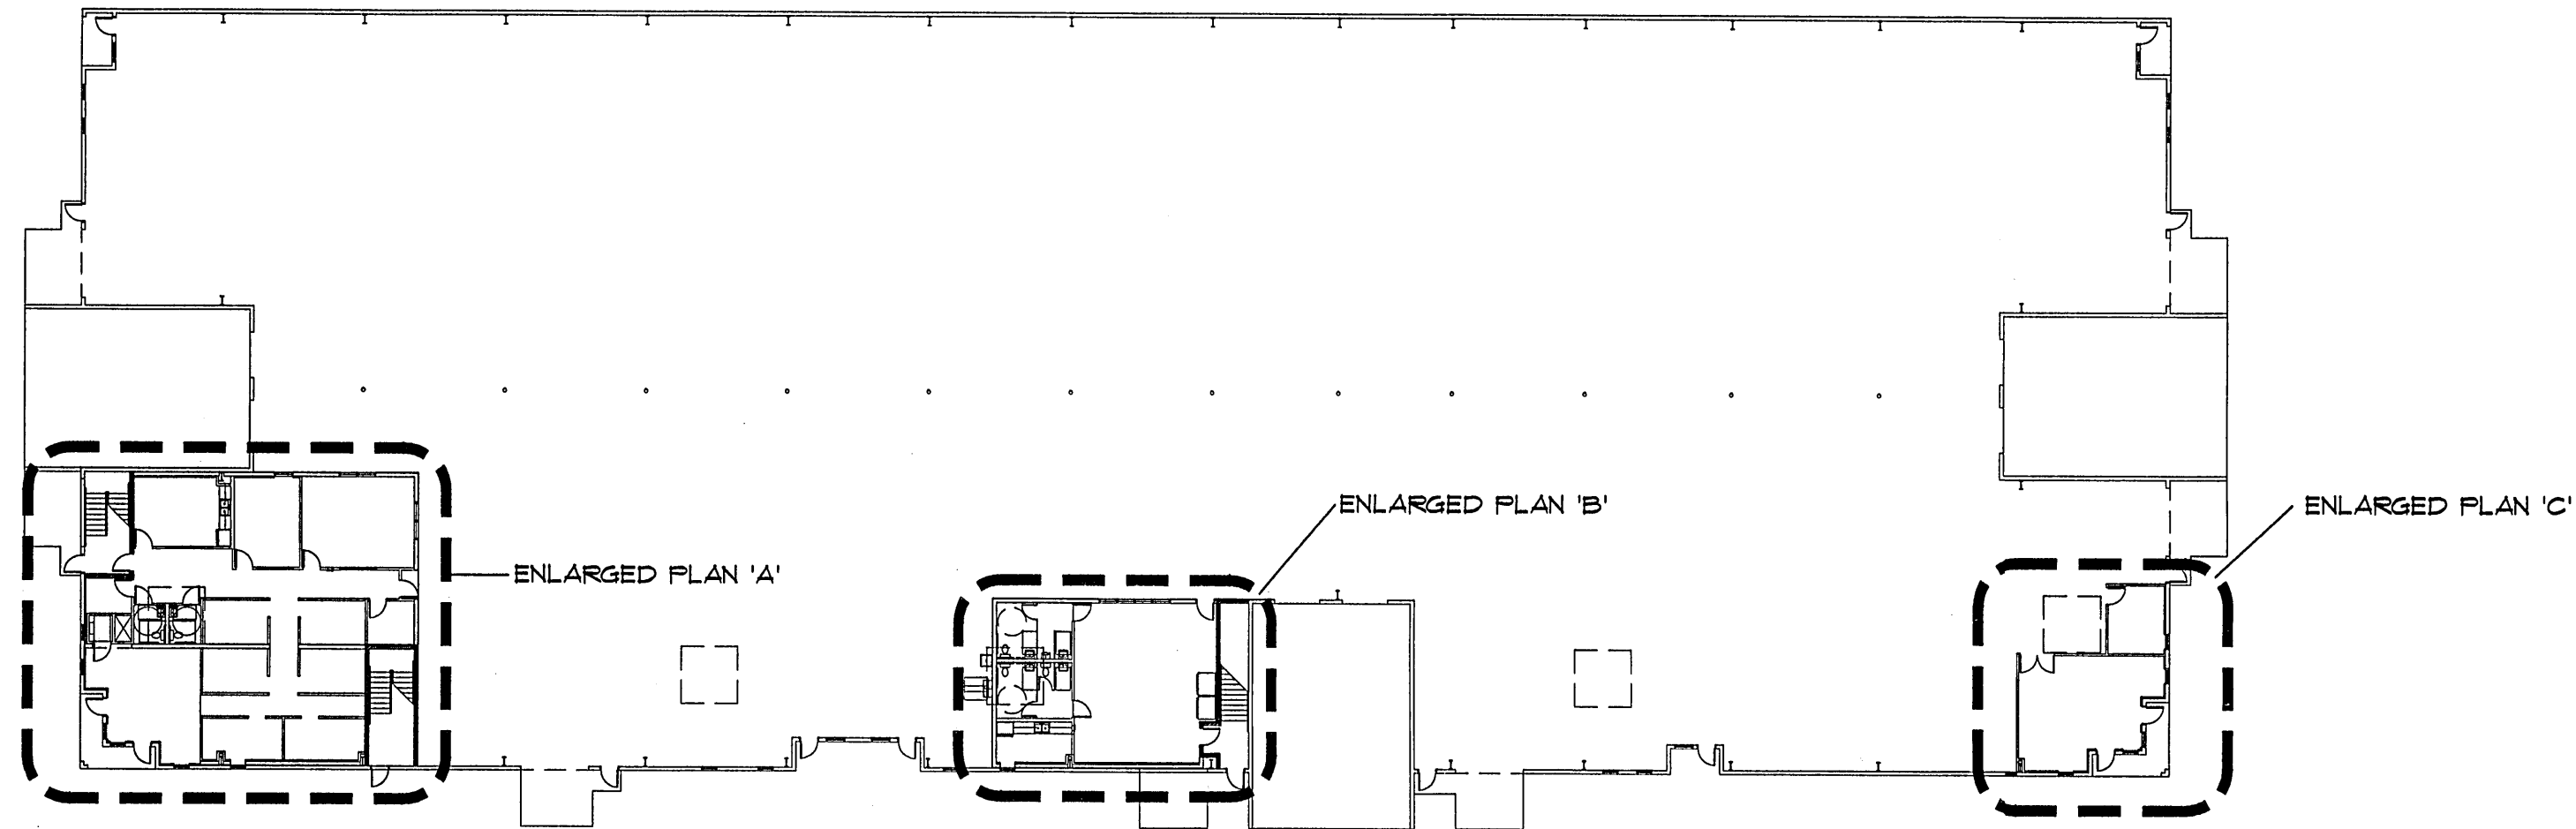


1ST FLOOR
BUILDING PLAN
SCALE: 1"=30'-0"

GENERAL PLUMBING NOTES


1. PLUMBING PIPING SHALL BE SCHEDULE 40 PVC EXCEPT WHERE NOTED.
2. INSTALL ALL PLUMBING AS PER APPLICABLE CODE AND LOCAL AUTHORITY HAVING JURISDICTION.
3. ALL WATER PIPING ABOVE GROUND SHALL BY TYPE L HARD DRAIN COPPER PIPE.

PLUMBING FIXTURE & CONNECTION SCHEDULE


MARK NO.	DESCRIPTION	MIN. CONNECTION			MOUNTING HEIGHT	MODEL NUMBERS (KOHLER OR ELJER EQUAL IS ACCEPTABLE)		
		W	CW	HW		MANUF.	FIXTURE NO.	TRIM NUMBERS
P-1A	WATER CLOSET FLUSH TANK	3"	1/2"		15"	AM. STD.	2838/012	NA
P-1B	WATER CLOSET FLUSH TANK HANDICAPPED	3"	1/2"		17-19"	AM. STD.	2938/012	NA
P-2	URINAL WALL HUNG	2"	3/4"		17 MAX"	AM. STD.	6501/010	SLOAN #86
P-3A	COUNTER LAVATORY	1 1/2"	1/2"	1/2"	34"	AM. STD.	0491/020	MOEN L4601
P-3B	WALL HUNG LAVATORY HANDICAPPED	1 1/2"	1/2"	1/2"	34"	AM. STD.	0355/012	MOEN L4601
P-4	KITCHEN SINK HANDICAPPED	1 1/2"	1/2"	1/2"	34"	DAYTON MOEN	33X22 0.5.	MOEN T841
P-5	ELECTRIC WATER COOLER HANDICAPPED	1 1/2"	1/2"		36"	ELKAY	HI-LO 8GPM	NA
P-6	MOP SINK	3"	1/2"	1/2"	FLOOR MOUNT	FIAT	M8B2424	TSS BRASS BSTR 665

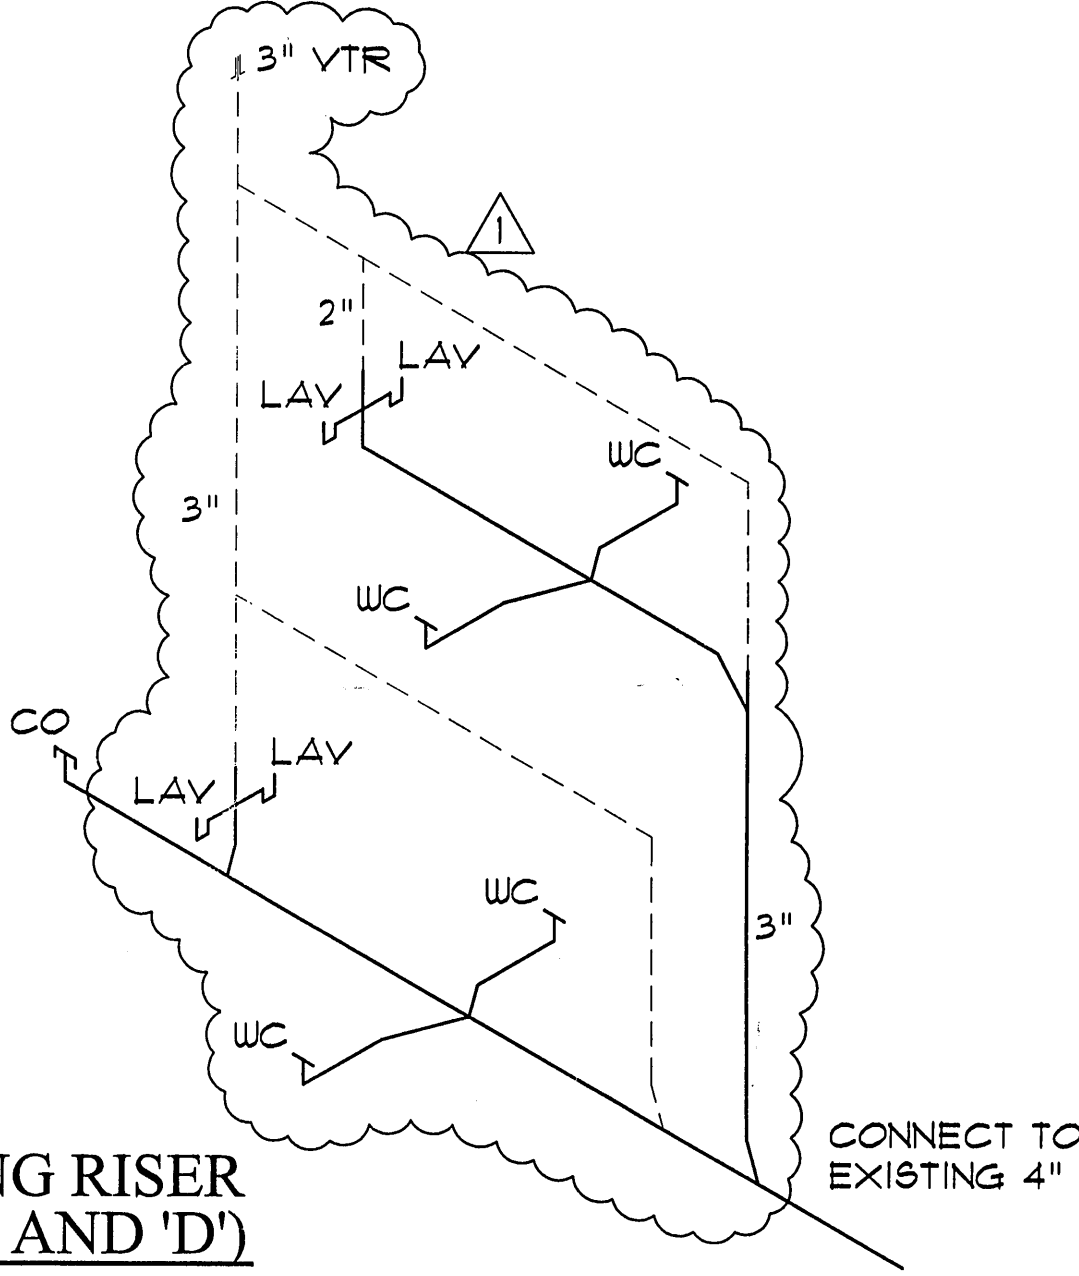



PLUMBING RISER
(PLAN 'A' AND 'D')
NOT TO SCALE

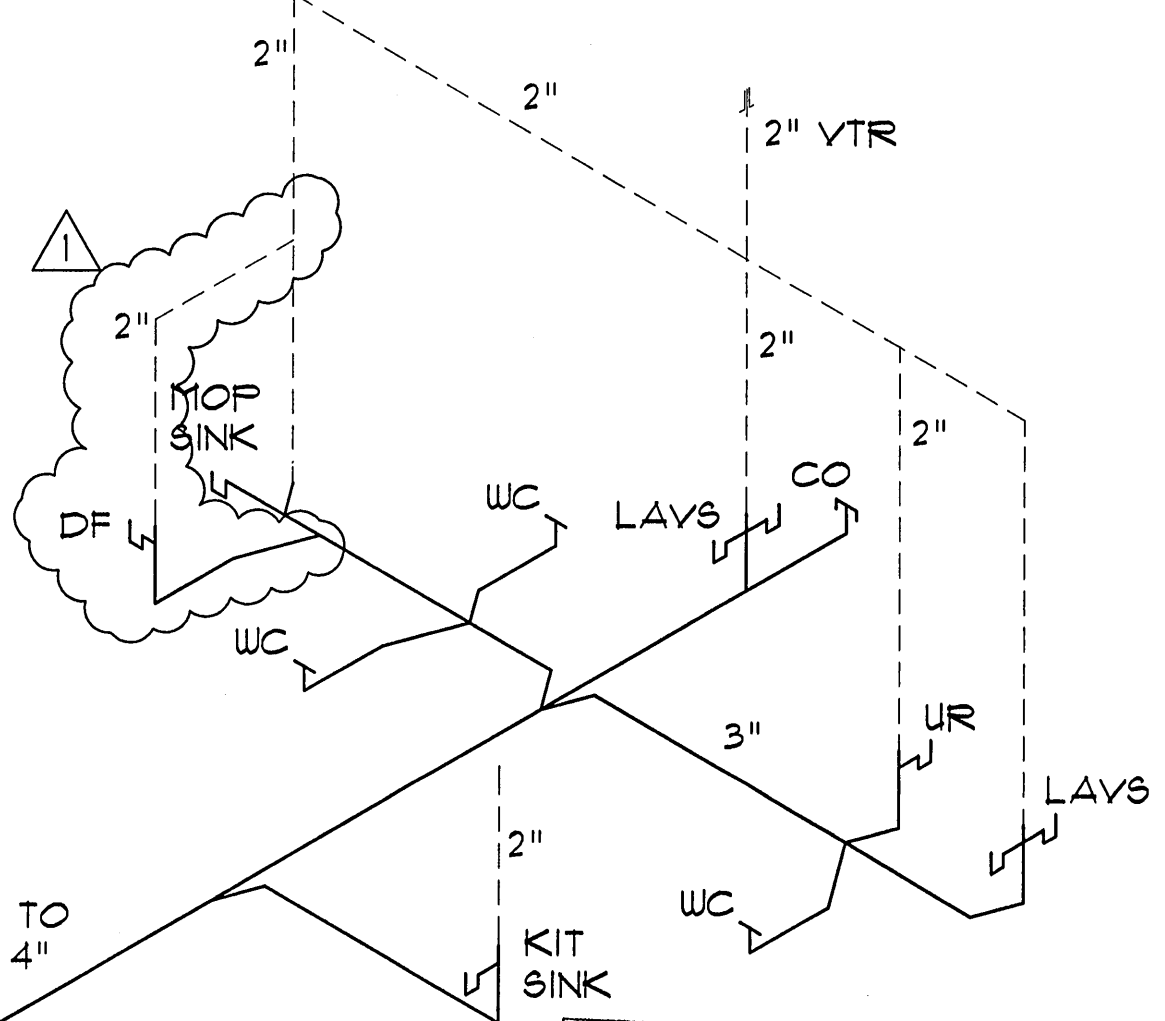

PLUMBING RISER
(PLAN 'B' AND 'E')
NOT TO SCALE

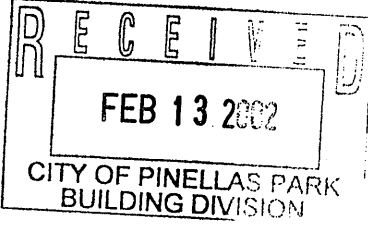

RPB
2-12-02

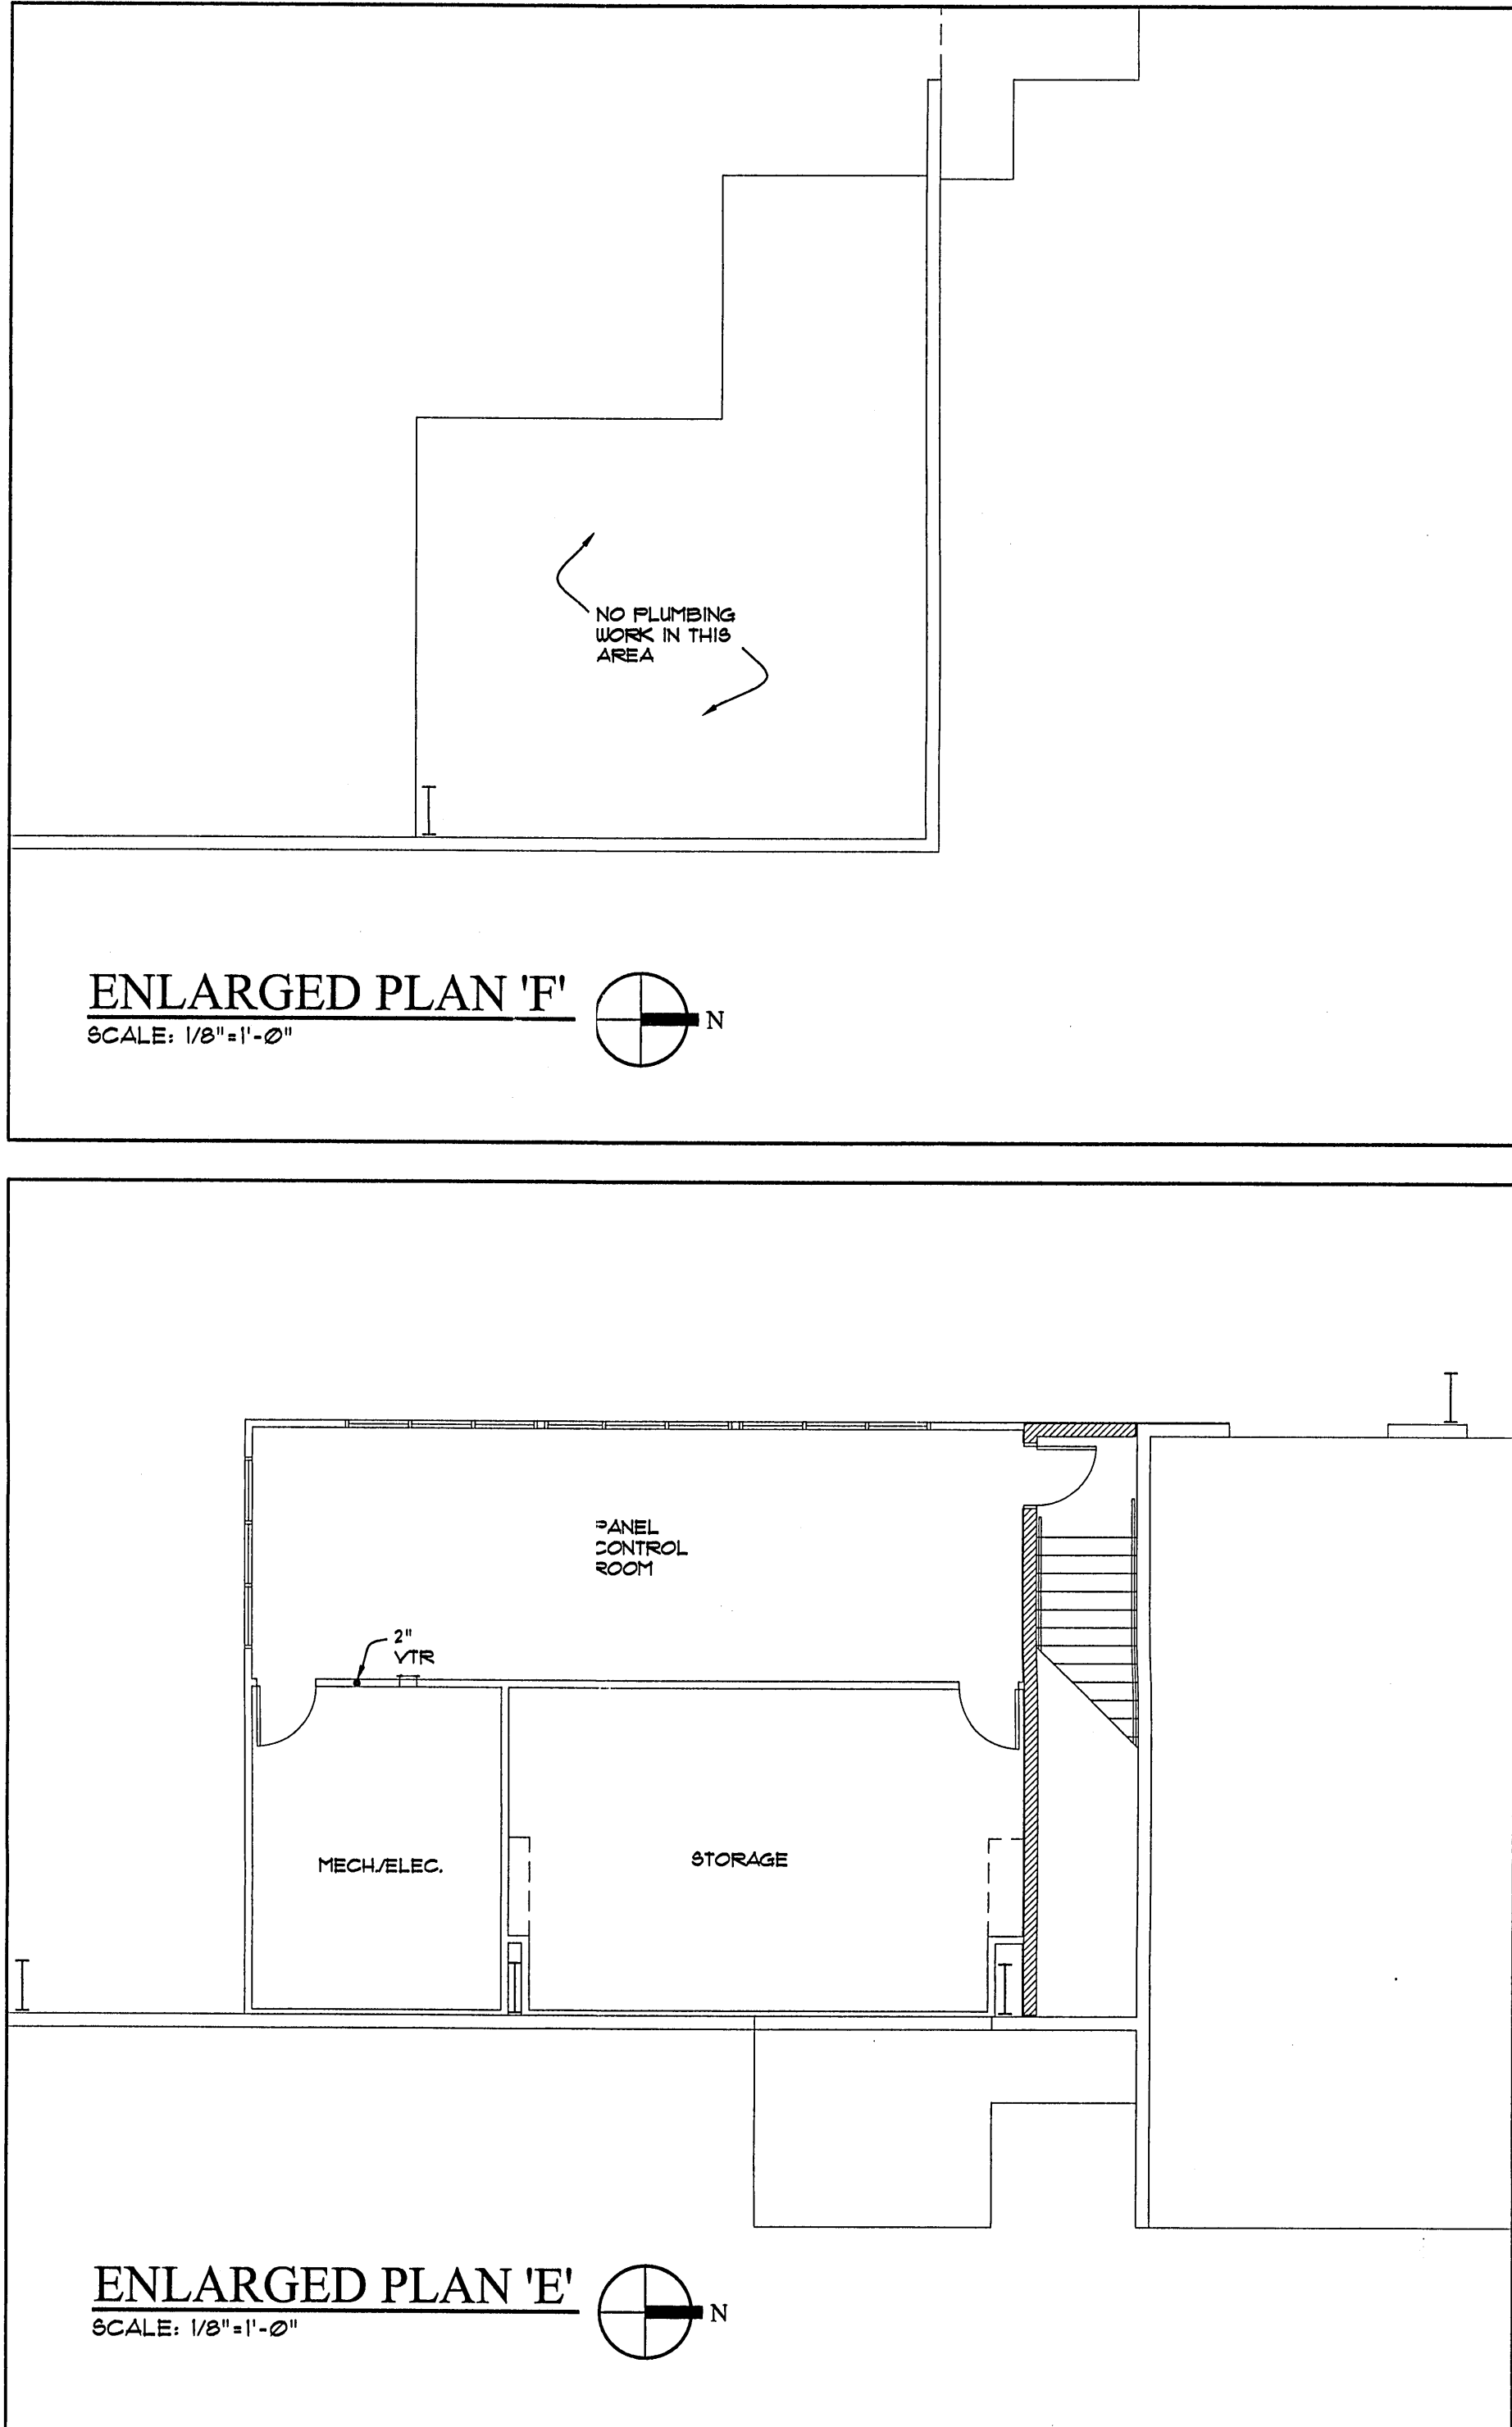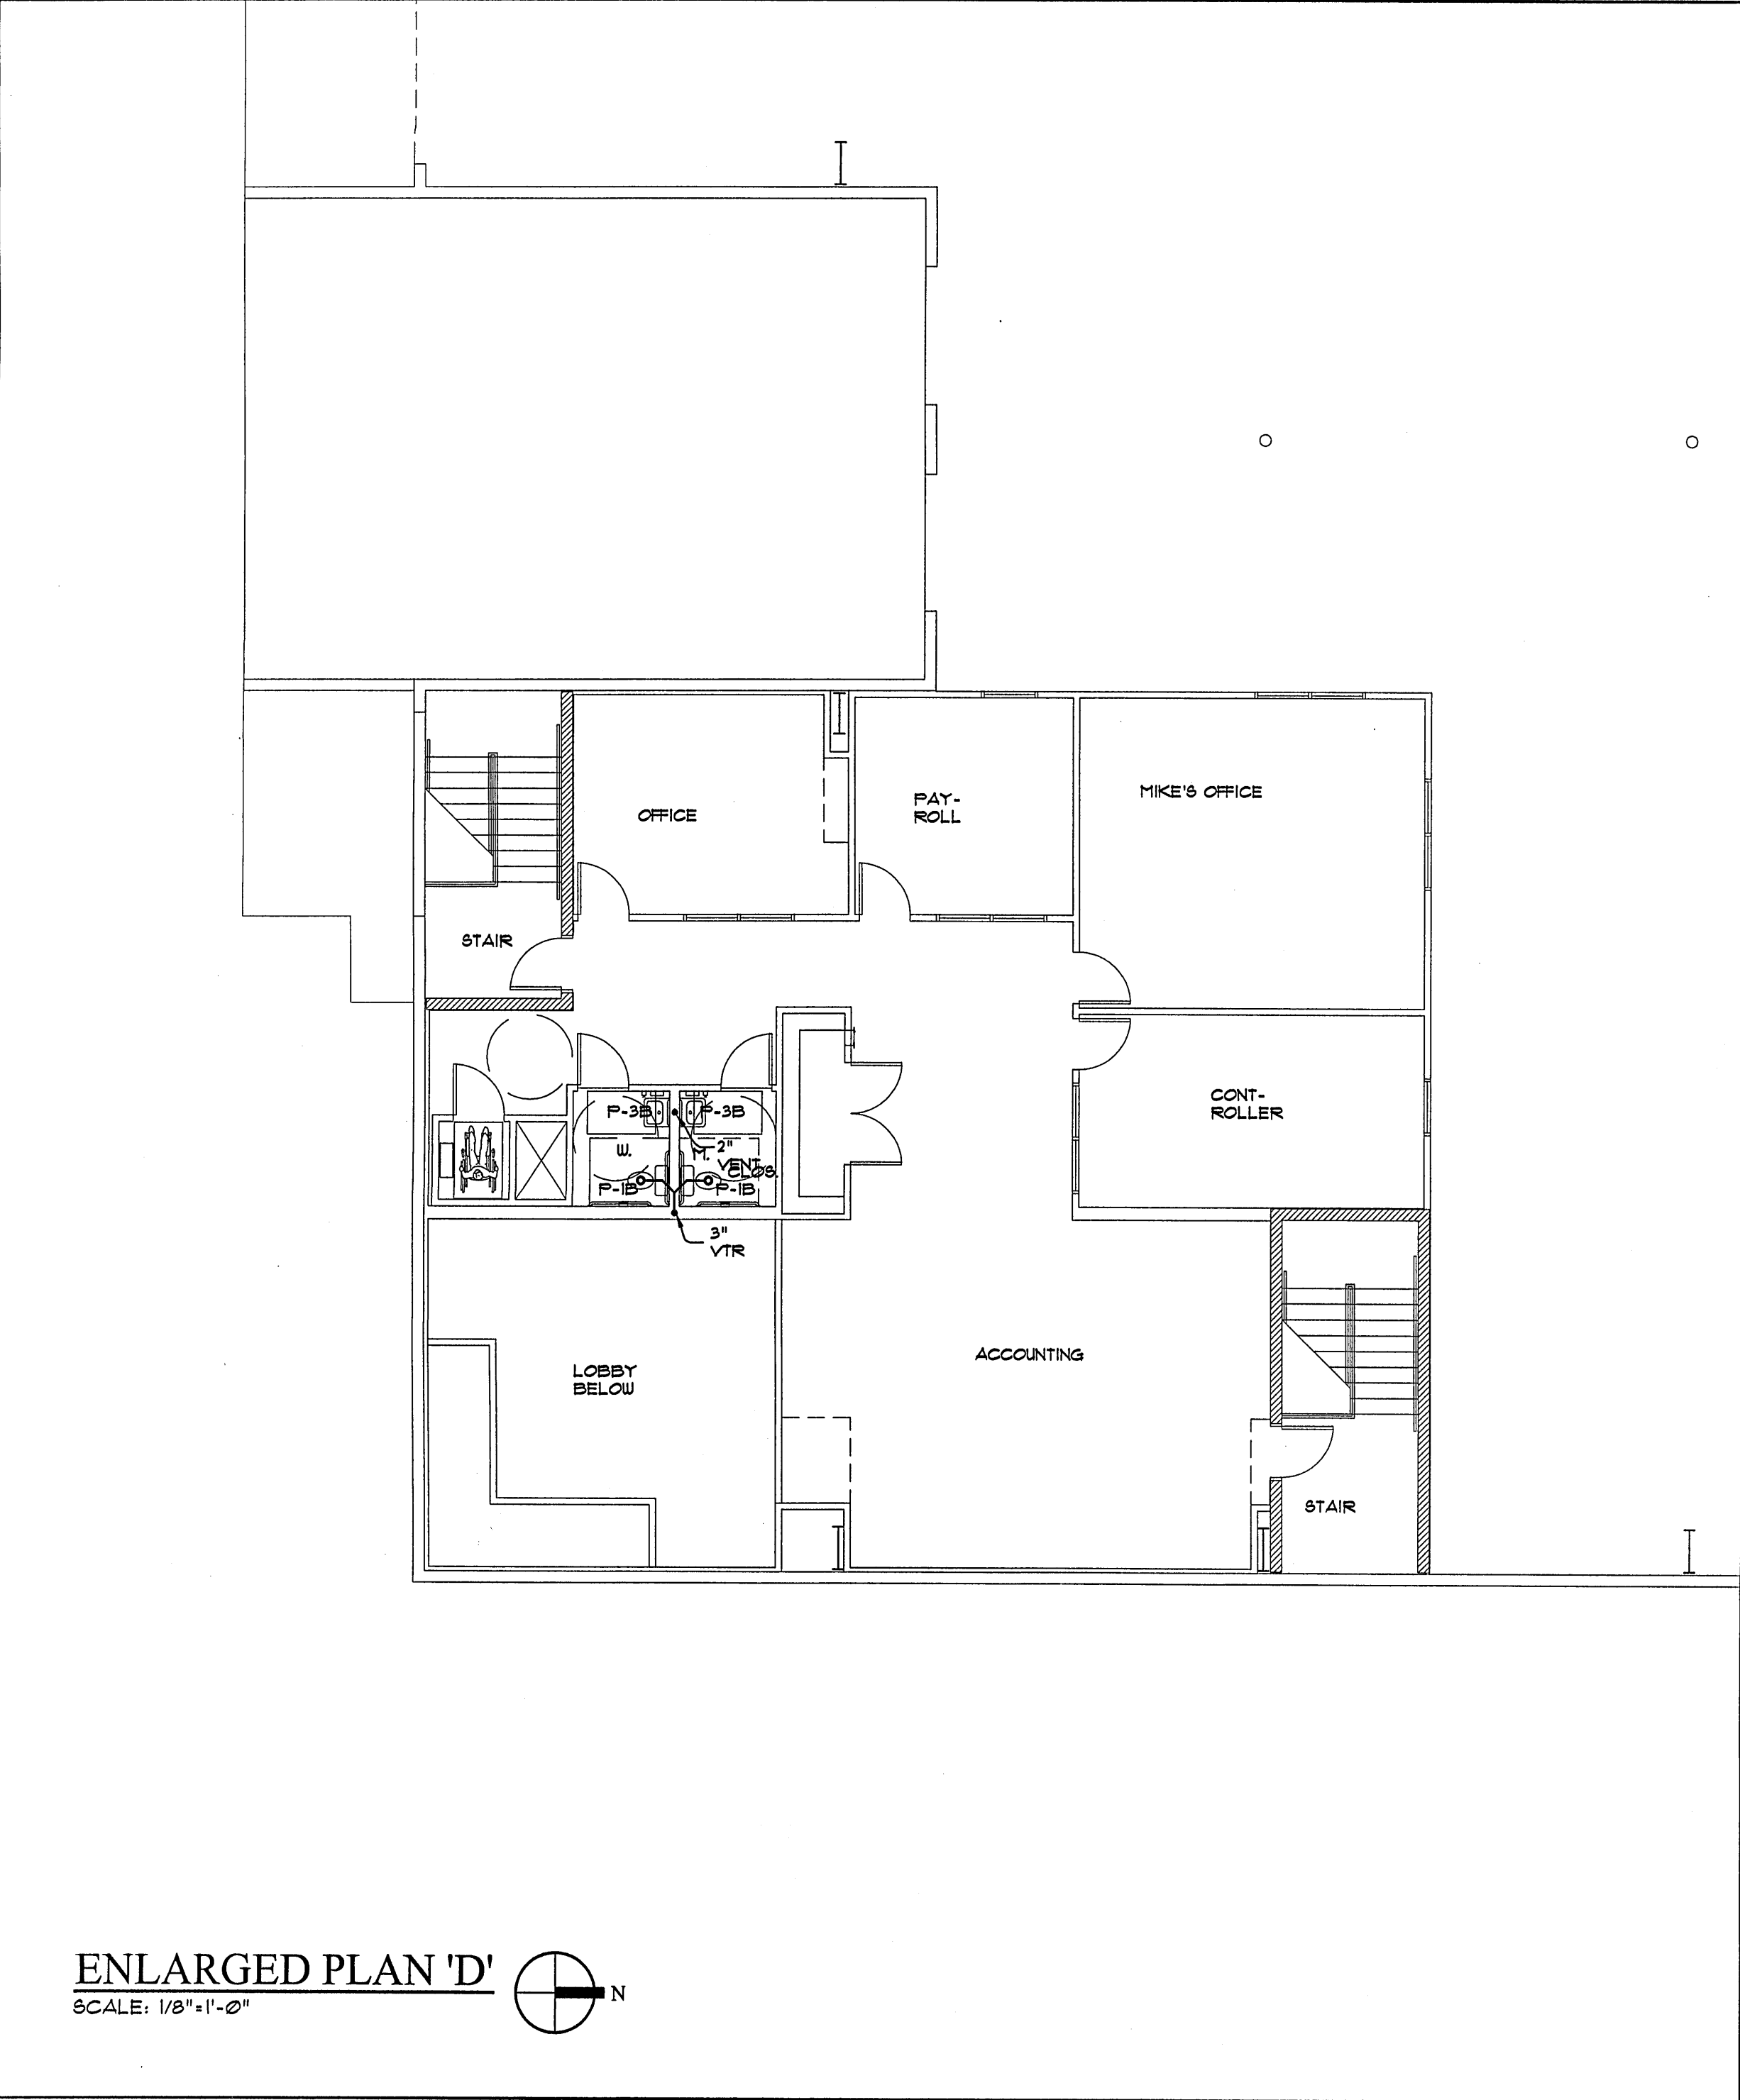


GENERAL PLUMBING NOTES

1. PLUMBING PIPING SHALL BE SCHEDULE 40 PVC EXCEPT WHERE NOTED.
2. INSTALL ALL PLUMBING AS PER APPLICABLE CODE AND LOCAL AUTHORITY HAVING JURISDICTION.
3. ALL WATER PIPING ABOVE GROUND SHALL BY TYPE L HARD DRAIN COPPER PIPE.

PLUMBING FIXTURE & CONNECTION SCHEDULE

MARK NO.	DESCRIPTION	MIN. CONNECTION			MOUNTING HEIGHT	MODEL NUMBERS (KOHLER OR ELVER EQUAL IS ACCEPTABLE)		
		W	CW	HW		MANUF.	FIXTURE NO.	TRIM NUMBERS
P-1A	WATER CLOSET FLUSH TANK	3"	1/2"		15"	AM. STD.	2838.012	NA
P-1B	WATER CLOSET FLUSH TANK HANDICAPPED	3"	1/2"		17-19"	AM. STD.	2938.012	NA
P-2	URINAL WALL HUNG	2"	3/4"		17 MAX"	AM. STD.	6501.010	SLOAN #86
P-3A	COUNTER LAVATORY	1 1/2"	1/2"	1/2"	34"	AM. STD.	0491.020	MOEN L4601
P-3B	WALL HUNG LAVATORY HANDICAPPED	1 1/2"	1/2"	1/2"	34"	AM. STD.	0355.012	MOEN L4601
P-4	KITCHEN SINK HANDICAPPED	1 1/2"	1/2"	1/2"	34"	DAYTON MOEN	33X22 S.S.	MOEN T841
P-5	ELECTRIC WATER COOLER HANDICAPPED	1 1/2"	1/2"		36"	ELKAY	HI-LO 8GFM	NA
P-6	MOP SINK	3"	1/2"	1/2"	FLOOR MOUNT	FIAT	M8B2424	T86 BRASS BSTR 665

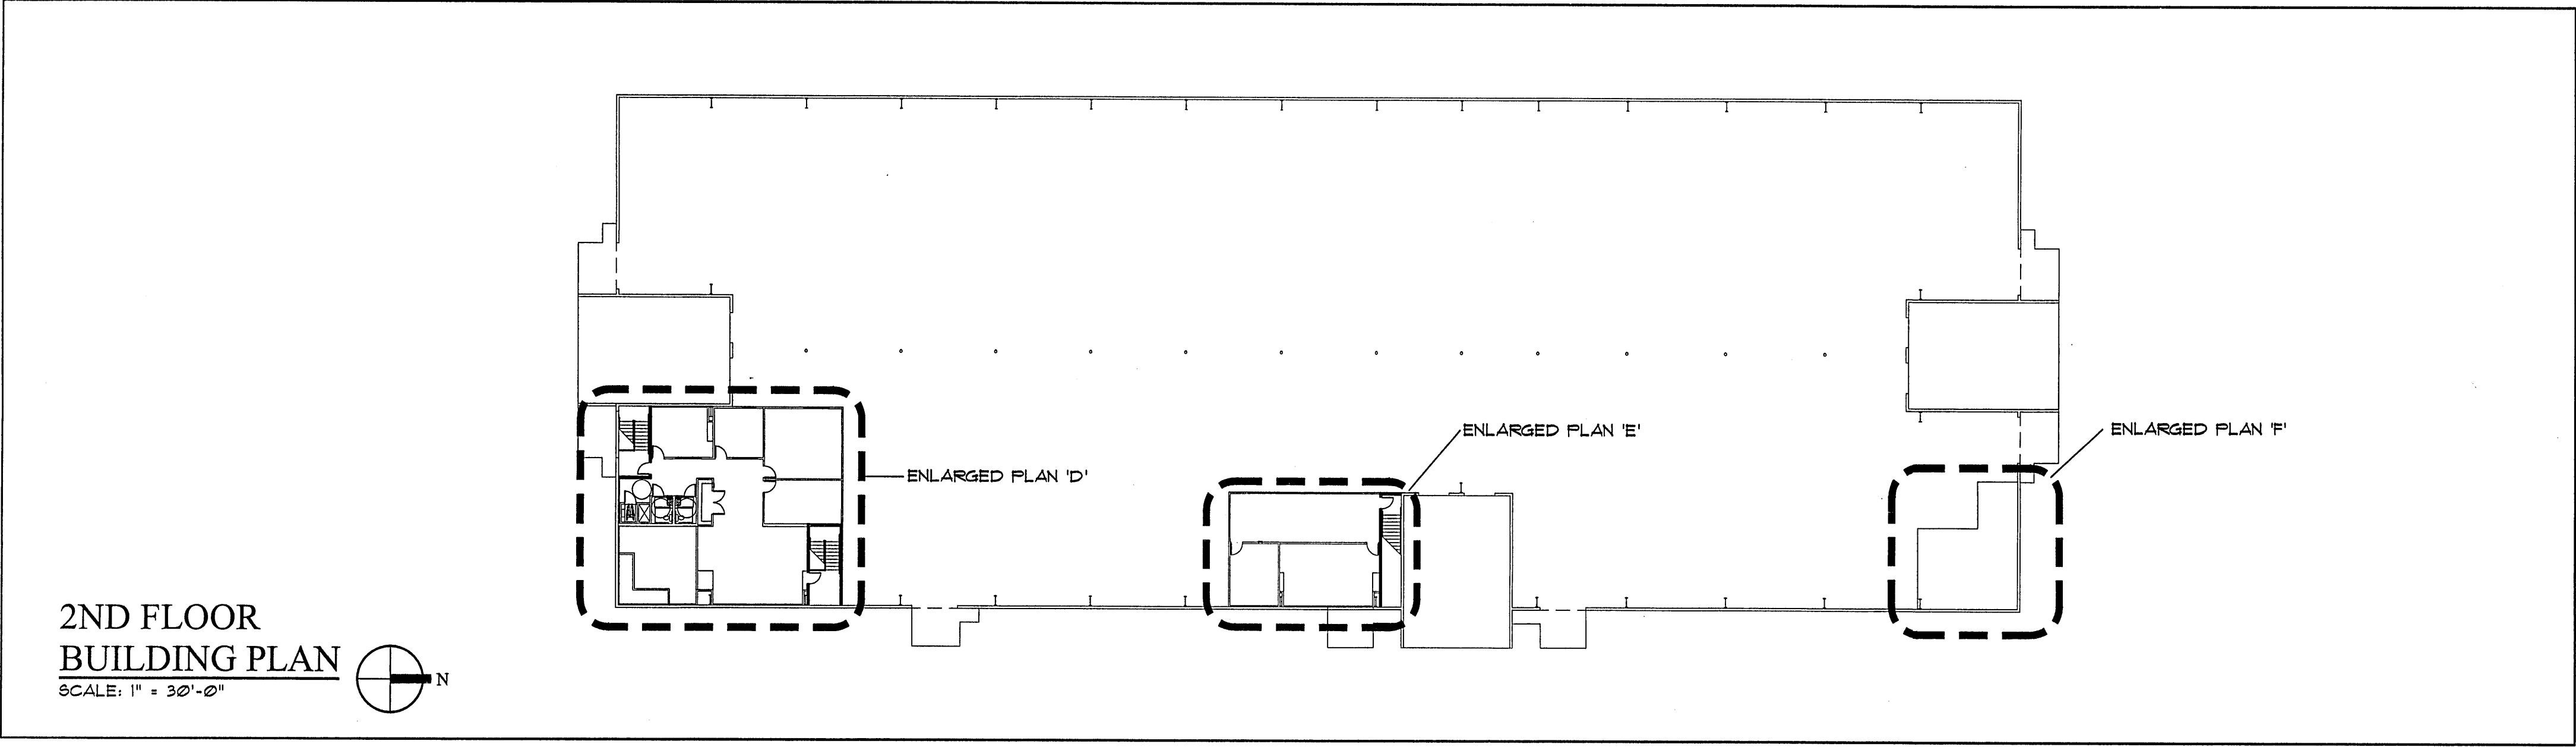

RPP
2-12-01