


**2 REFLECTED CEILING PLAN**  
 SCALE 1/8" = 1'-0"

**CEILING NOTES:**  
 1. CEILING HEIGHT NOTED ON PLAN FOR EACH ROOM.  
 2. SEE MECHANICAL PLANS FOR MECH EQUIPMENT LOCATIONS IN SHOP.


CEILING PLAN LEGEND	
[Symbol]	2X2 LAY-IN CEILING TILES
[Symbol]	LAY-IN LED LIGHT FIXTURE
[Symbol]	SUSPENDED LED LIGHT FIXTURE
[Symbol]	WALL MOUNTED LED OVER MIRROR
[Symbol]	EXTERIOR SURFACE MOUNTED FIXTURE
[Symbol]	UNDER CANOPY LIGHT (SEE ELEC. DWGS)
[Symbol]	EXIT SIGN
[Symbol]	EXHAUST FAN
[Symbol]	EMERGENCY LIGHT

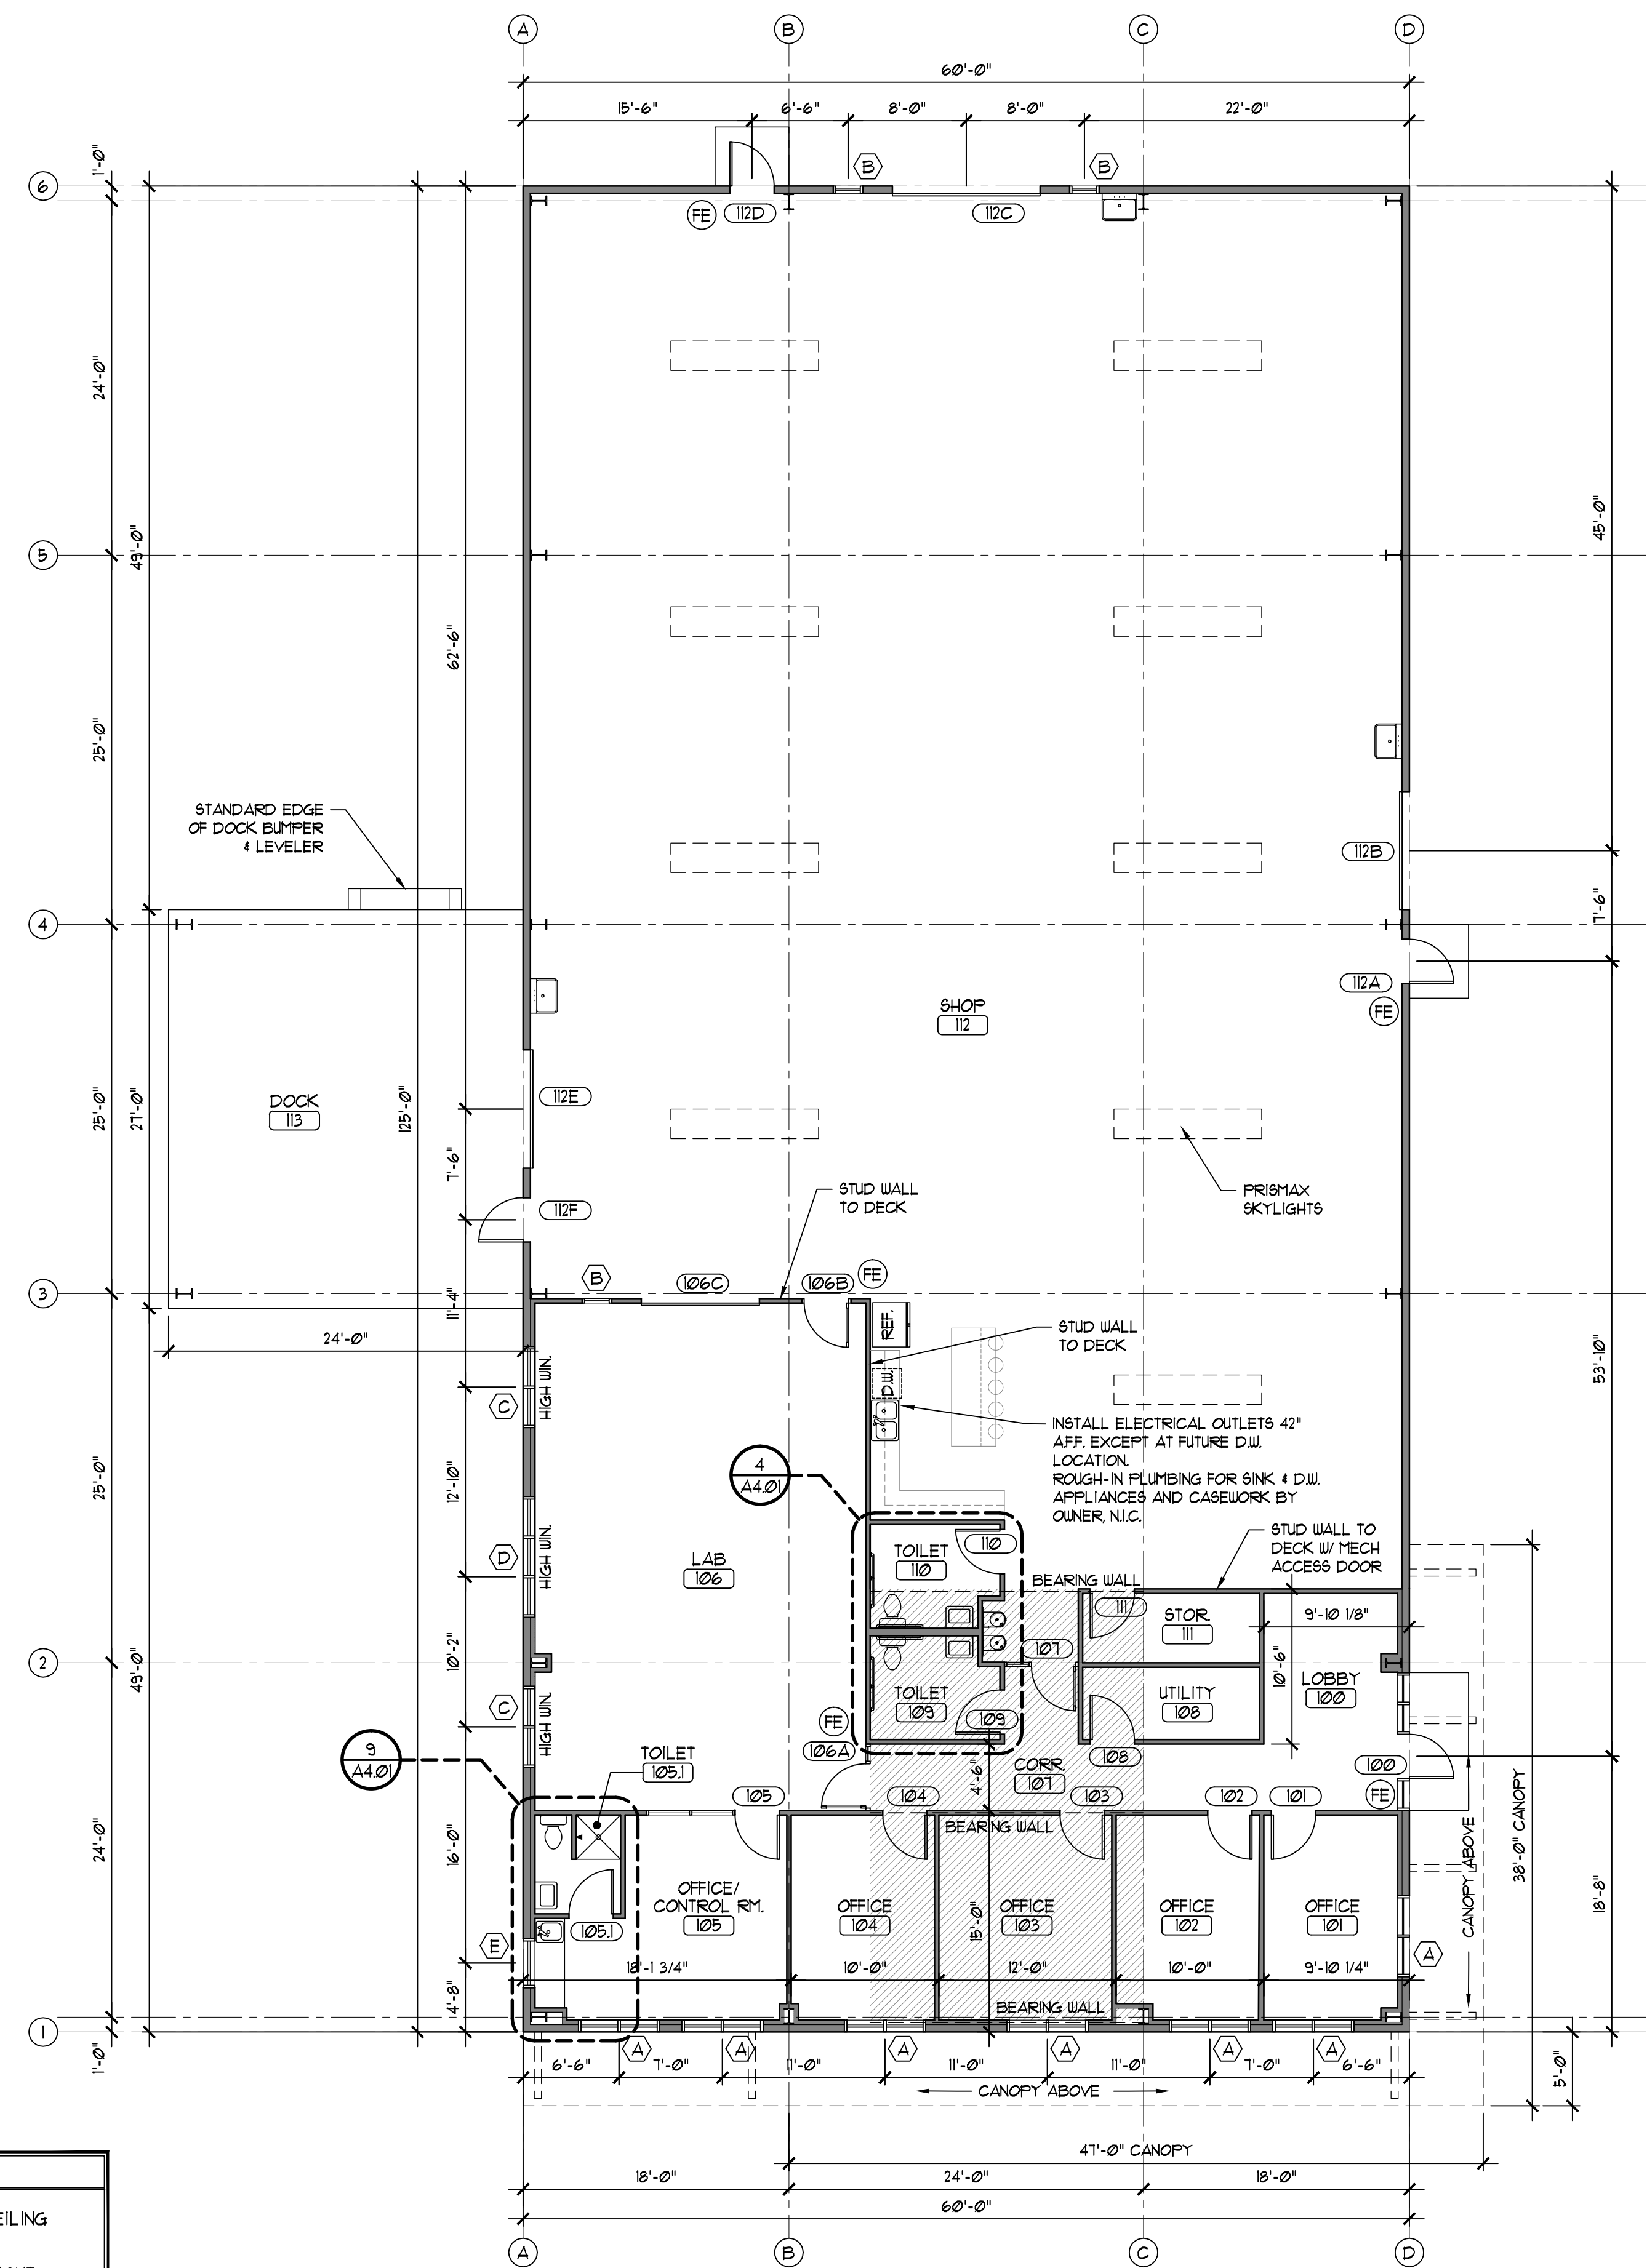

**1 FLOOR PLAN**  
 SCALE 1/8" = 1'-0"

**GENERAL NOTES:**  
 1. ALL INTERIOR PARTITION WALLS TO BE 3-5/8" MTL STUDS W/ 5/8" GYP BD EACH SIDE. SEE DETAIL 3/A3.01 FOR PLUMBING.  
 2. EXTERIOR WALLS AT LOBBY, OFFICES AND LABS TO BE 3-5/8" MTL STUDS WITH 5/8" GYP BD ONE SIDE. INTERIOR OF METAL BUILDING STRUCTURAL GIRTS. SEE DETAIL 1/A3.01.  
 3. SOUND PARTITIONS SURROUNDING TOILET ROOMS, TYP. SEE DETAIL 6/A3.01.  
 4. SEE PLANS FOR WALL HANG FIRE EXTINGUISHER (FE) LOCATIONS.  
 5. PROVIDE CODE COMPLIANT SIGNAGE WITH BRILLE IDENTIFYING TOILET ROOMS. SIGNS TO BE MOUNTED ON THE LATCH SIDE OF DOOR AT A MIN 48" AFF.  
 6. HATCHED AREA INDICATES UPPER LEVEL PLATFORM FOR FUTURE GROWTH. USE 16 GA. STUDS WITH 12" 14 GA. HEADER OVER OPENINGS ALONG BEARING WALLS AS INDICATED ON PLAN WITH 17" 14 GA. FLOOR JOISTS.  
 7. MECHANICAL PLATFORM TO BE LOCATED ABOVE STORAGE II AND UTILITY 108 FOR HVAC UNIT. PROVIDE ACCESS FROM SHOP WITH HIGH ACCESS DOOR.

PHONE 828-692-7238  
 FAX 828-696-9978

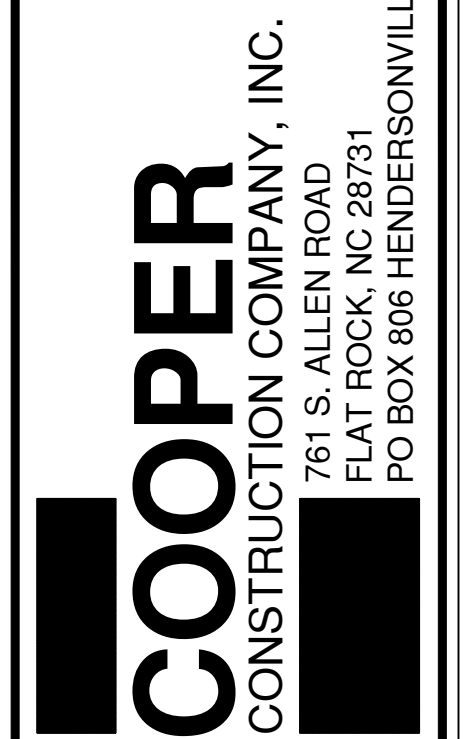

Wayland Shamburger, AIA  
 Architect  
 421 Fifth Avenue West  
 Hendersonville, NC, 28739  
 (P) 828-692-2737  
 (F) 828-694-0737  
 wayland@sdsaia.com

**Arrowood Mechanical Design**

THIS DRAWING MAY NOT BE COPIED OR REPRODUCED, IN WHOLE OR IN PART, WITHOUT PERMISSION FROM SHAMBURGER ARCHITECTURAL GROUP PLLC. COPYRIGHT © 2018

General Contractor to comply with all state and local codes. Any discrepancies in plans shall be discussed with Shamburger Architectural Group prior to assembly, ordering, and construction.

DO NOT SCALE DIMENSIONS FROM BLUEPRINT

FLOOR PLAN

Scale:  
 AS NOTED  
 Date:  
 April 20, 2018  
 Drawn By:  
 Checked By:  
 Project no.  
 Sheet no.

**A2.01**