


**ELECTRICAL  
PARTIAL ROOF PLAN**  
SCALE: 1/8" = 1'-0"

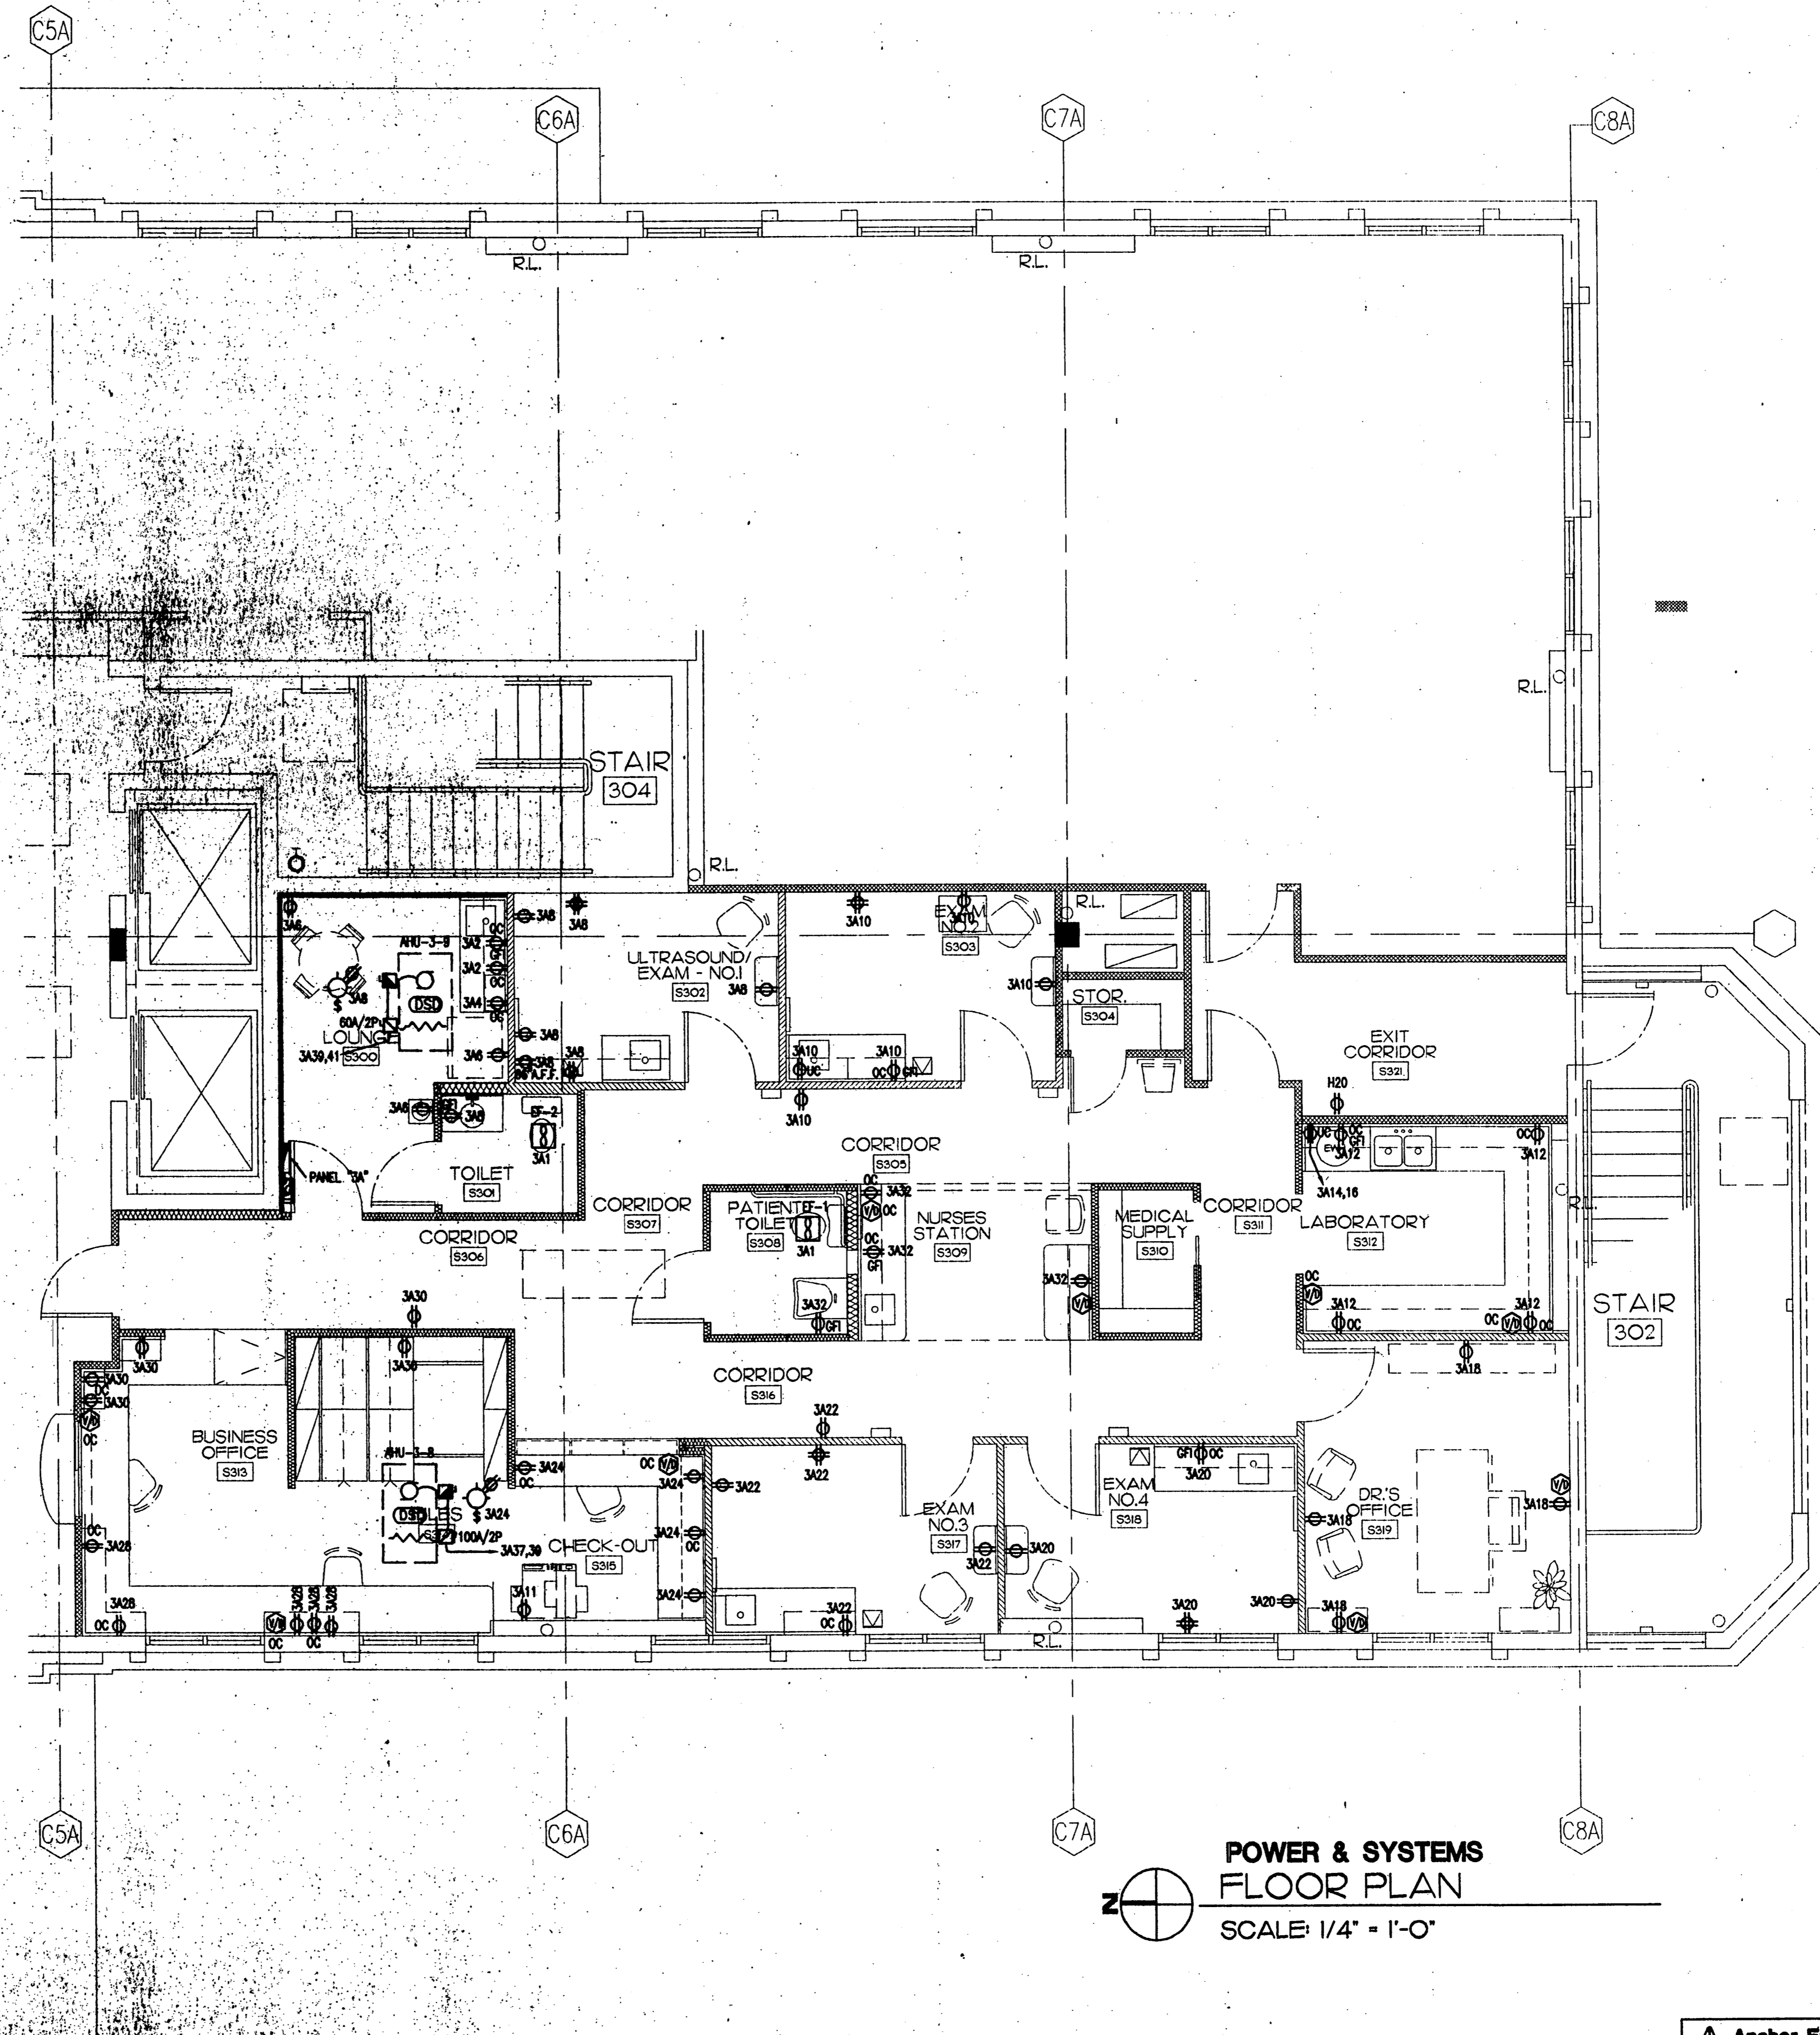

**POWER & SYSTEMS  
FLOOR PLAN**  
SCALE: 1/4" = 1'-0"

DYEHOUSE & GESHAY, INC. ARCHITECTS  
 999 Fifth Ave Pkwy  
 Naples, Fla. 34102  
 DR. FRANCISCO SMITH / NCA  
 1660 MEDICAL BLVD.  
 NAPLES, FLORIDA  
 THIRD FLOOR TENANT IMPROVEMENT FOR  
 © DYEHOUSE & GESHAY, INC.

Anchor Engineering Consultants, Inc.		
DRAWN BY: L.B.	DESIGNED BY: D.G.F.	APPROVED BY: D.G.F.
SCALE: AS NOTED	DATE: 8-9-97	JOB NO.: 4309-20-04 CNO. REF.: 0200041