

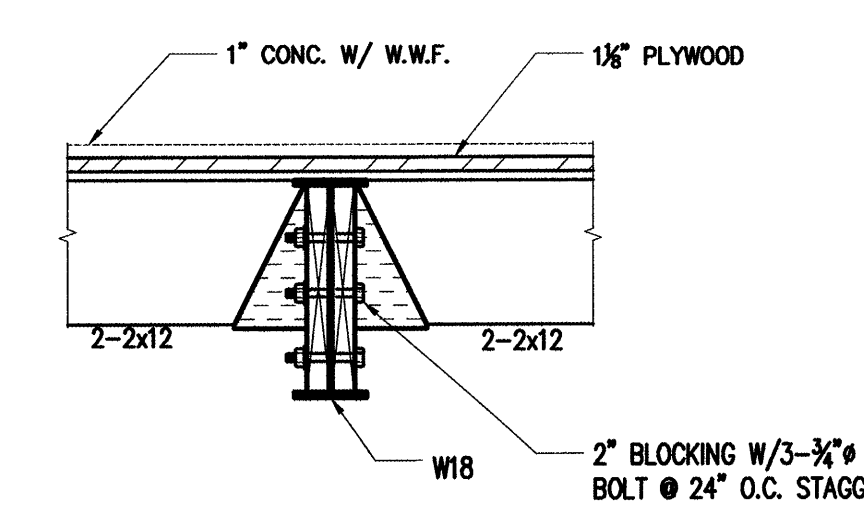
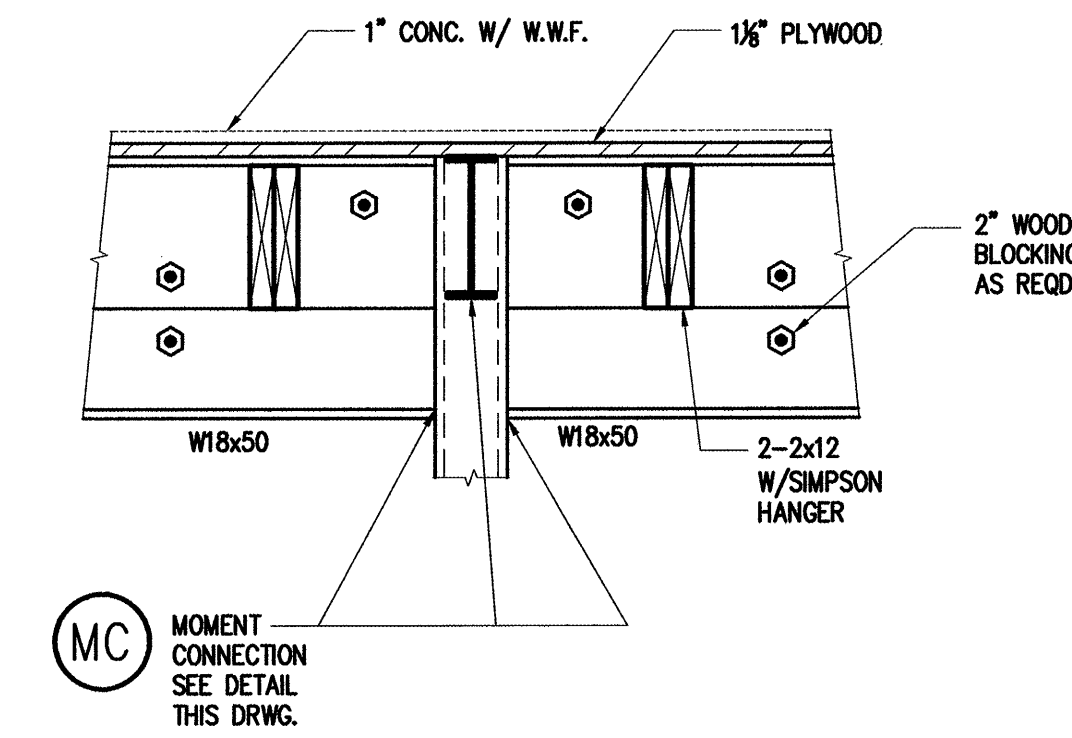
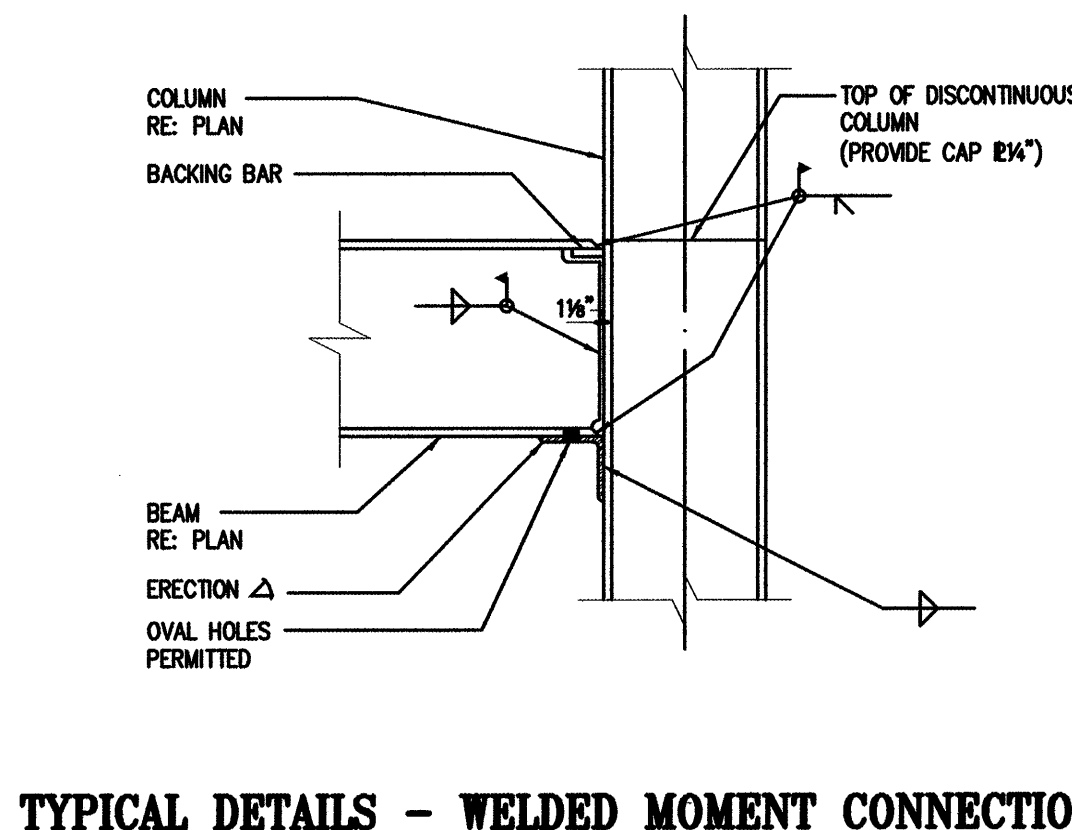
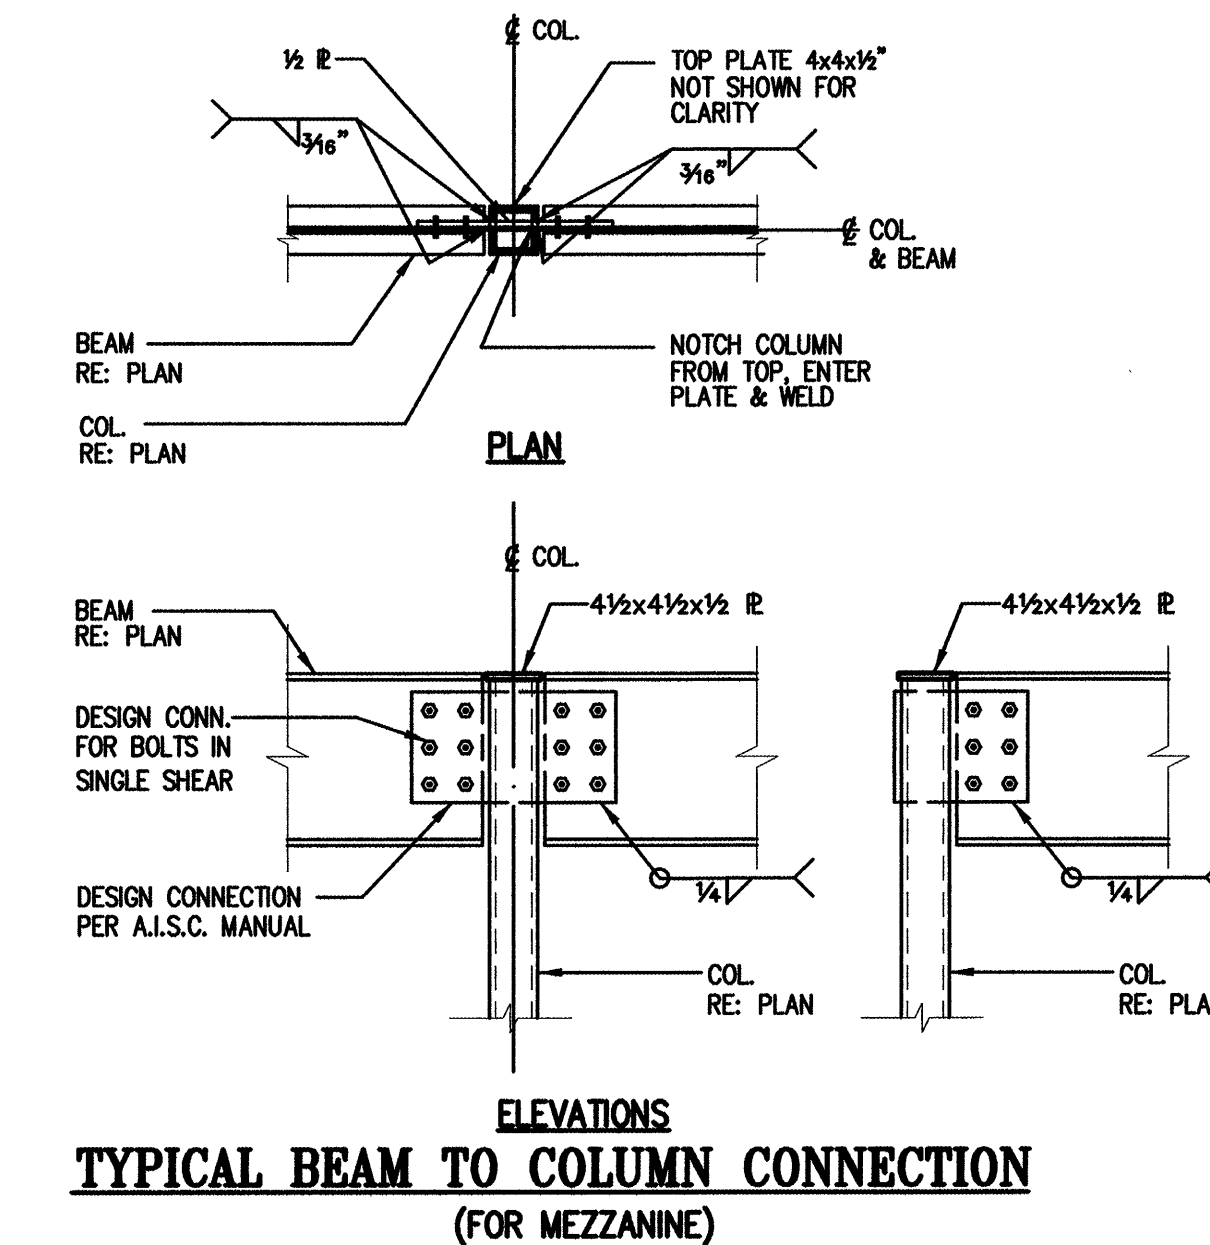


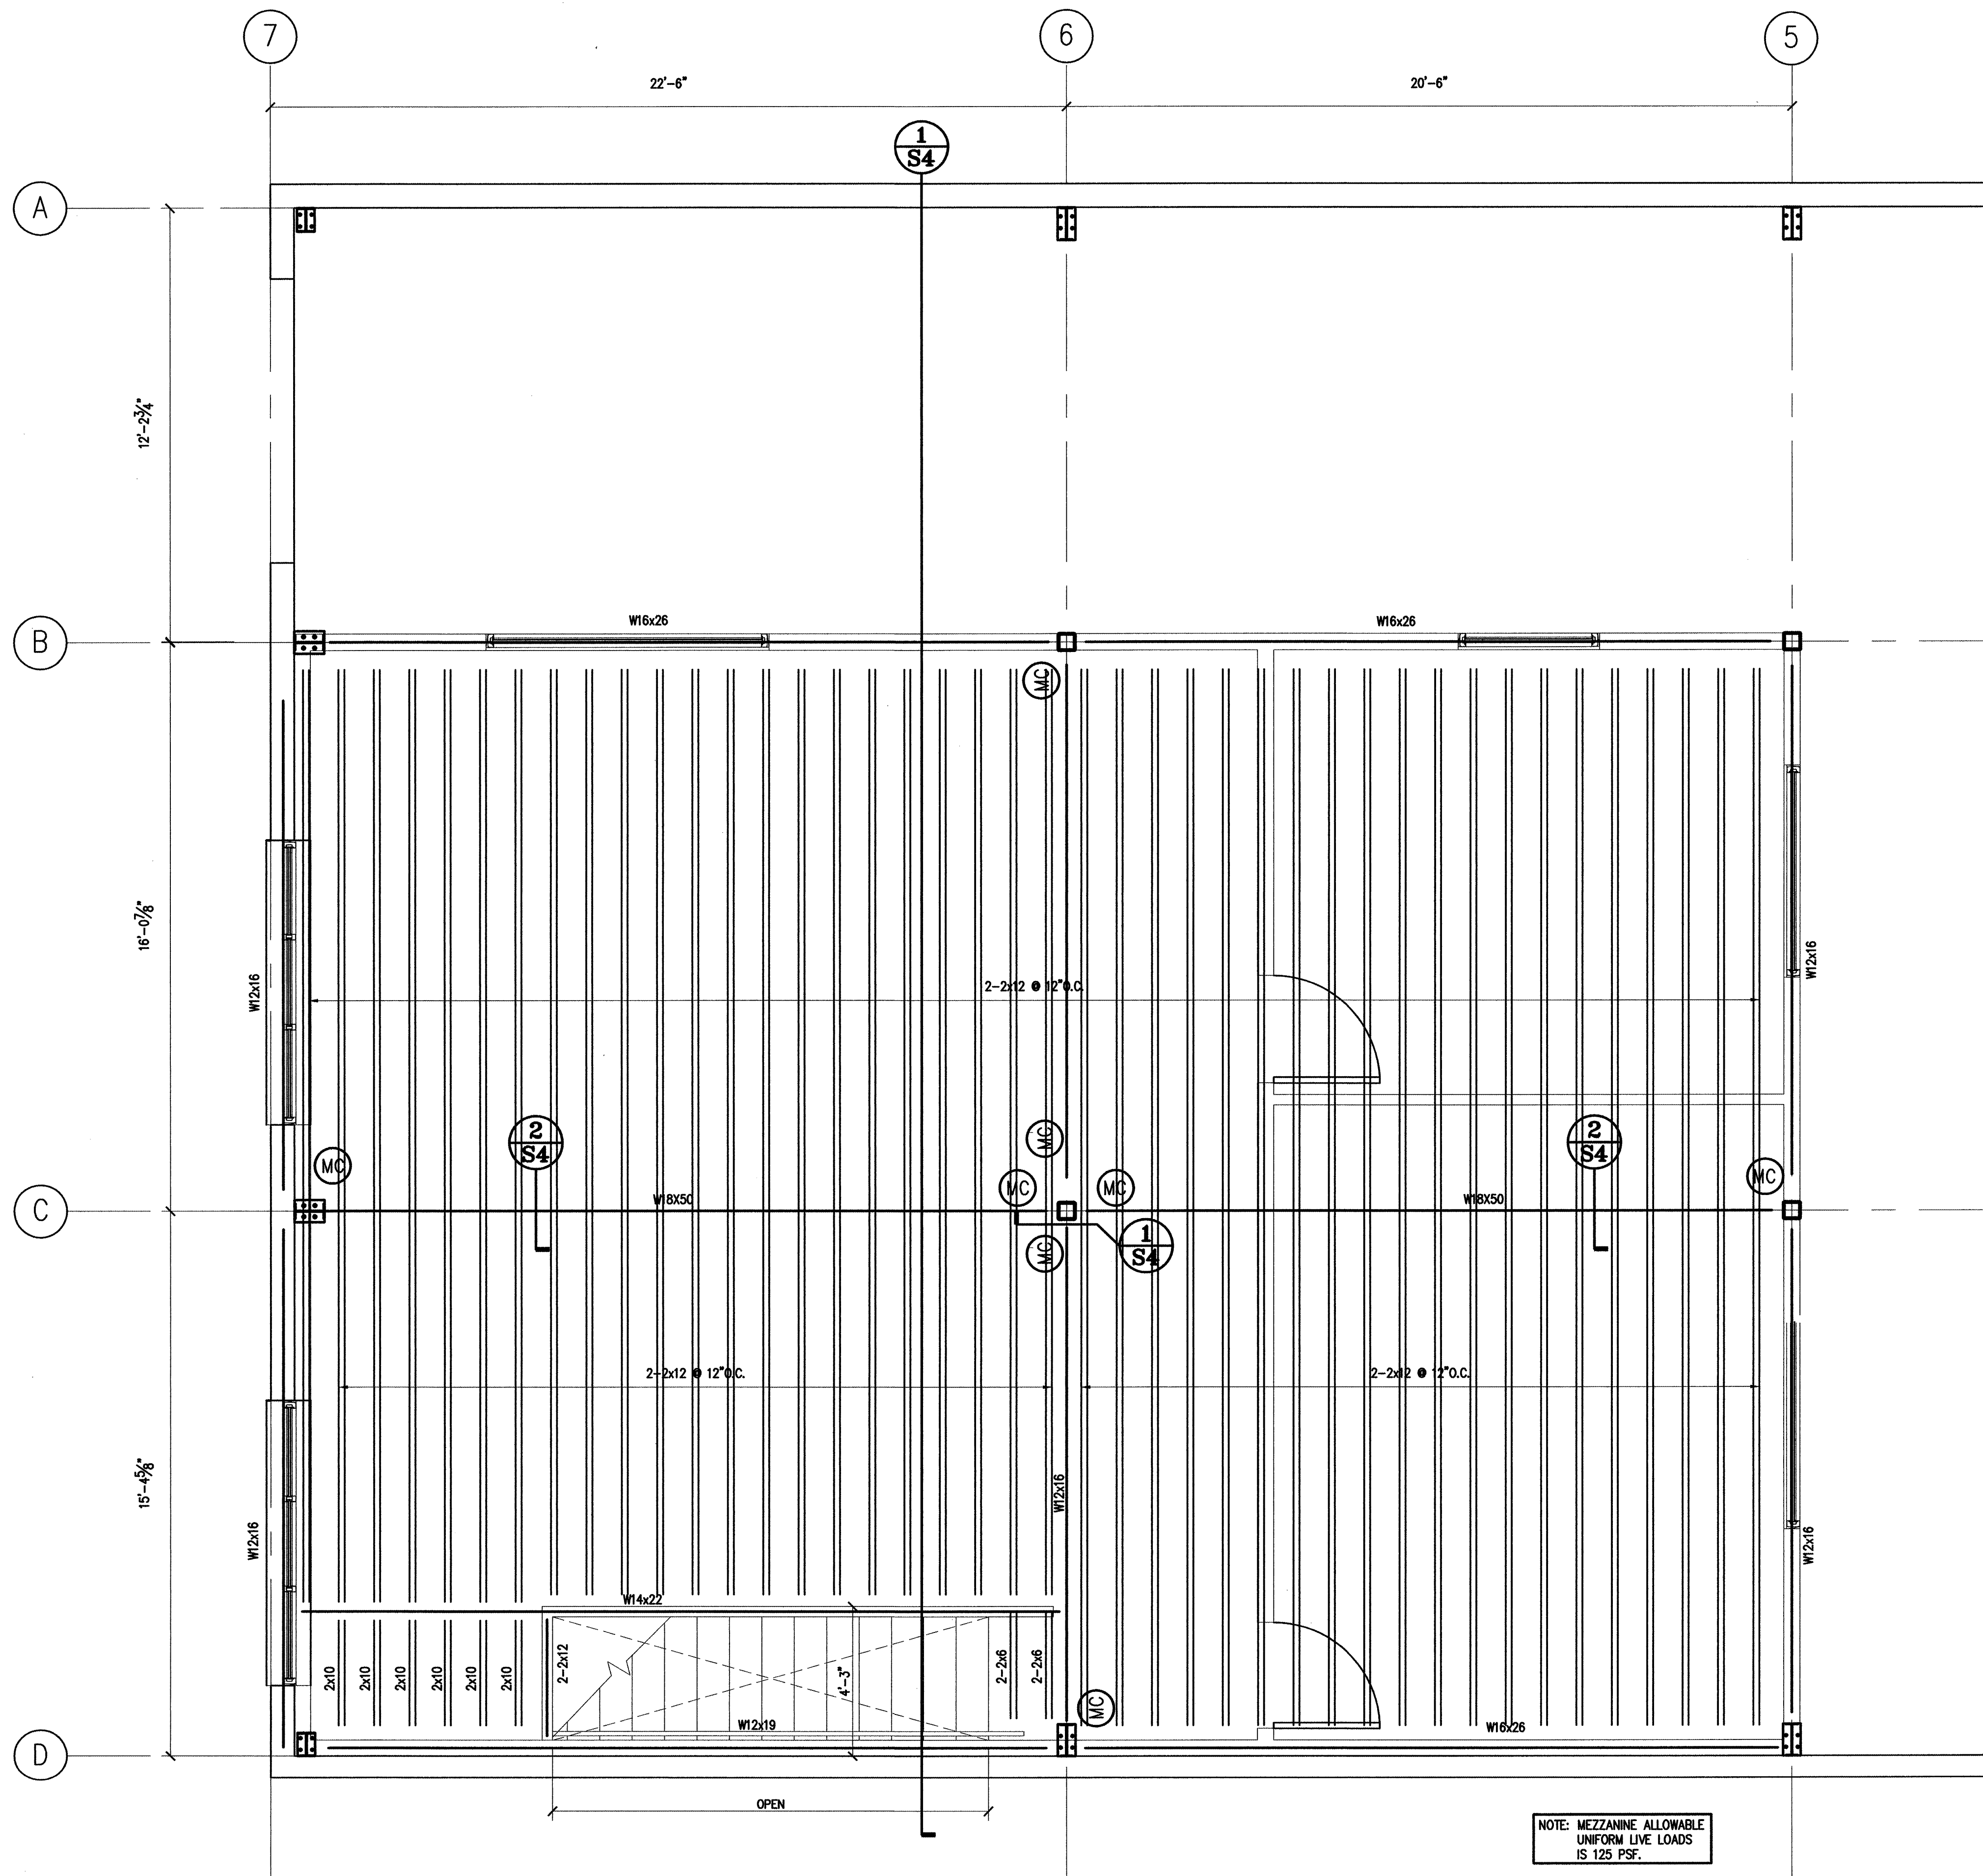

MEZZANINE FRAMING PLAN

ASTRO APPAREL OFFICE WAREHOUSE
AT 4007 OSAGE STREET
HOUSTON, TEXAS 77063

ISSUE HISTORY	
DATE	ISSUED FOR
	CLIENT REVIEW
	PERMIT
	CONSTRUCTION

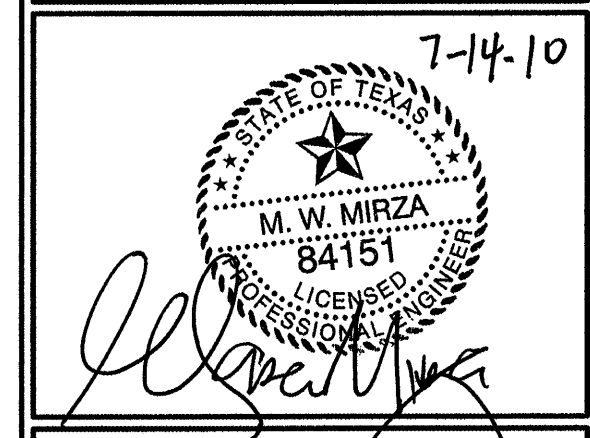

PE
BUILDINGS
BRIDGES
INSPECTIONS
MARINE STRUCTURES
CIVIL ENGINEERING & STRUCTURAL ENGINEERING

PARAMOUNT ENGINEERING LLC
7322 SOUTHWEST FREEWAY STE. 1050
HOUSTON, TX 77074
TEL : (713) 272-7184
FAX : (713) 995-4744
CEL : (713) 204-1742

TYPE REGISTRATION # F-3394
DRAWN BY: K.S. CHECKED BY: M.M.

PROJ. NO.: PE10-152

SHEET: **S4**