



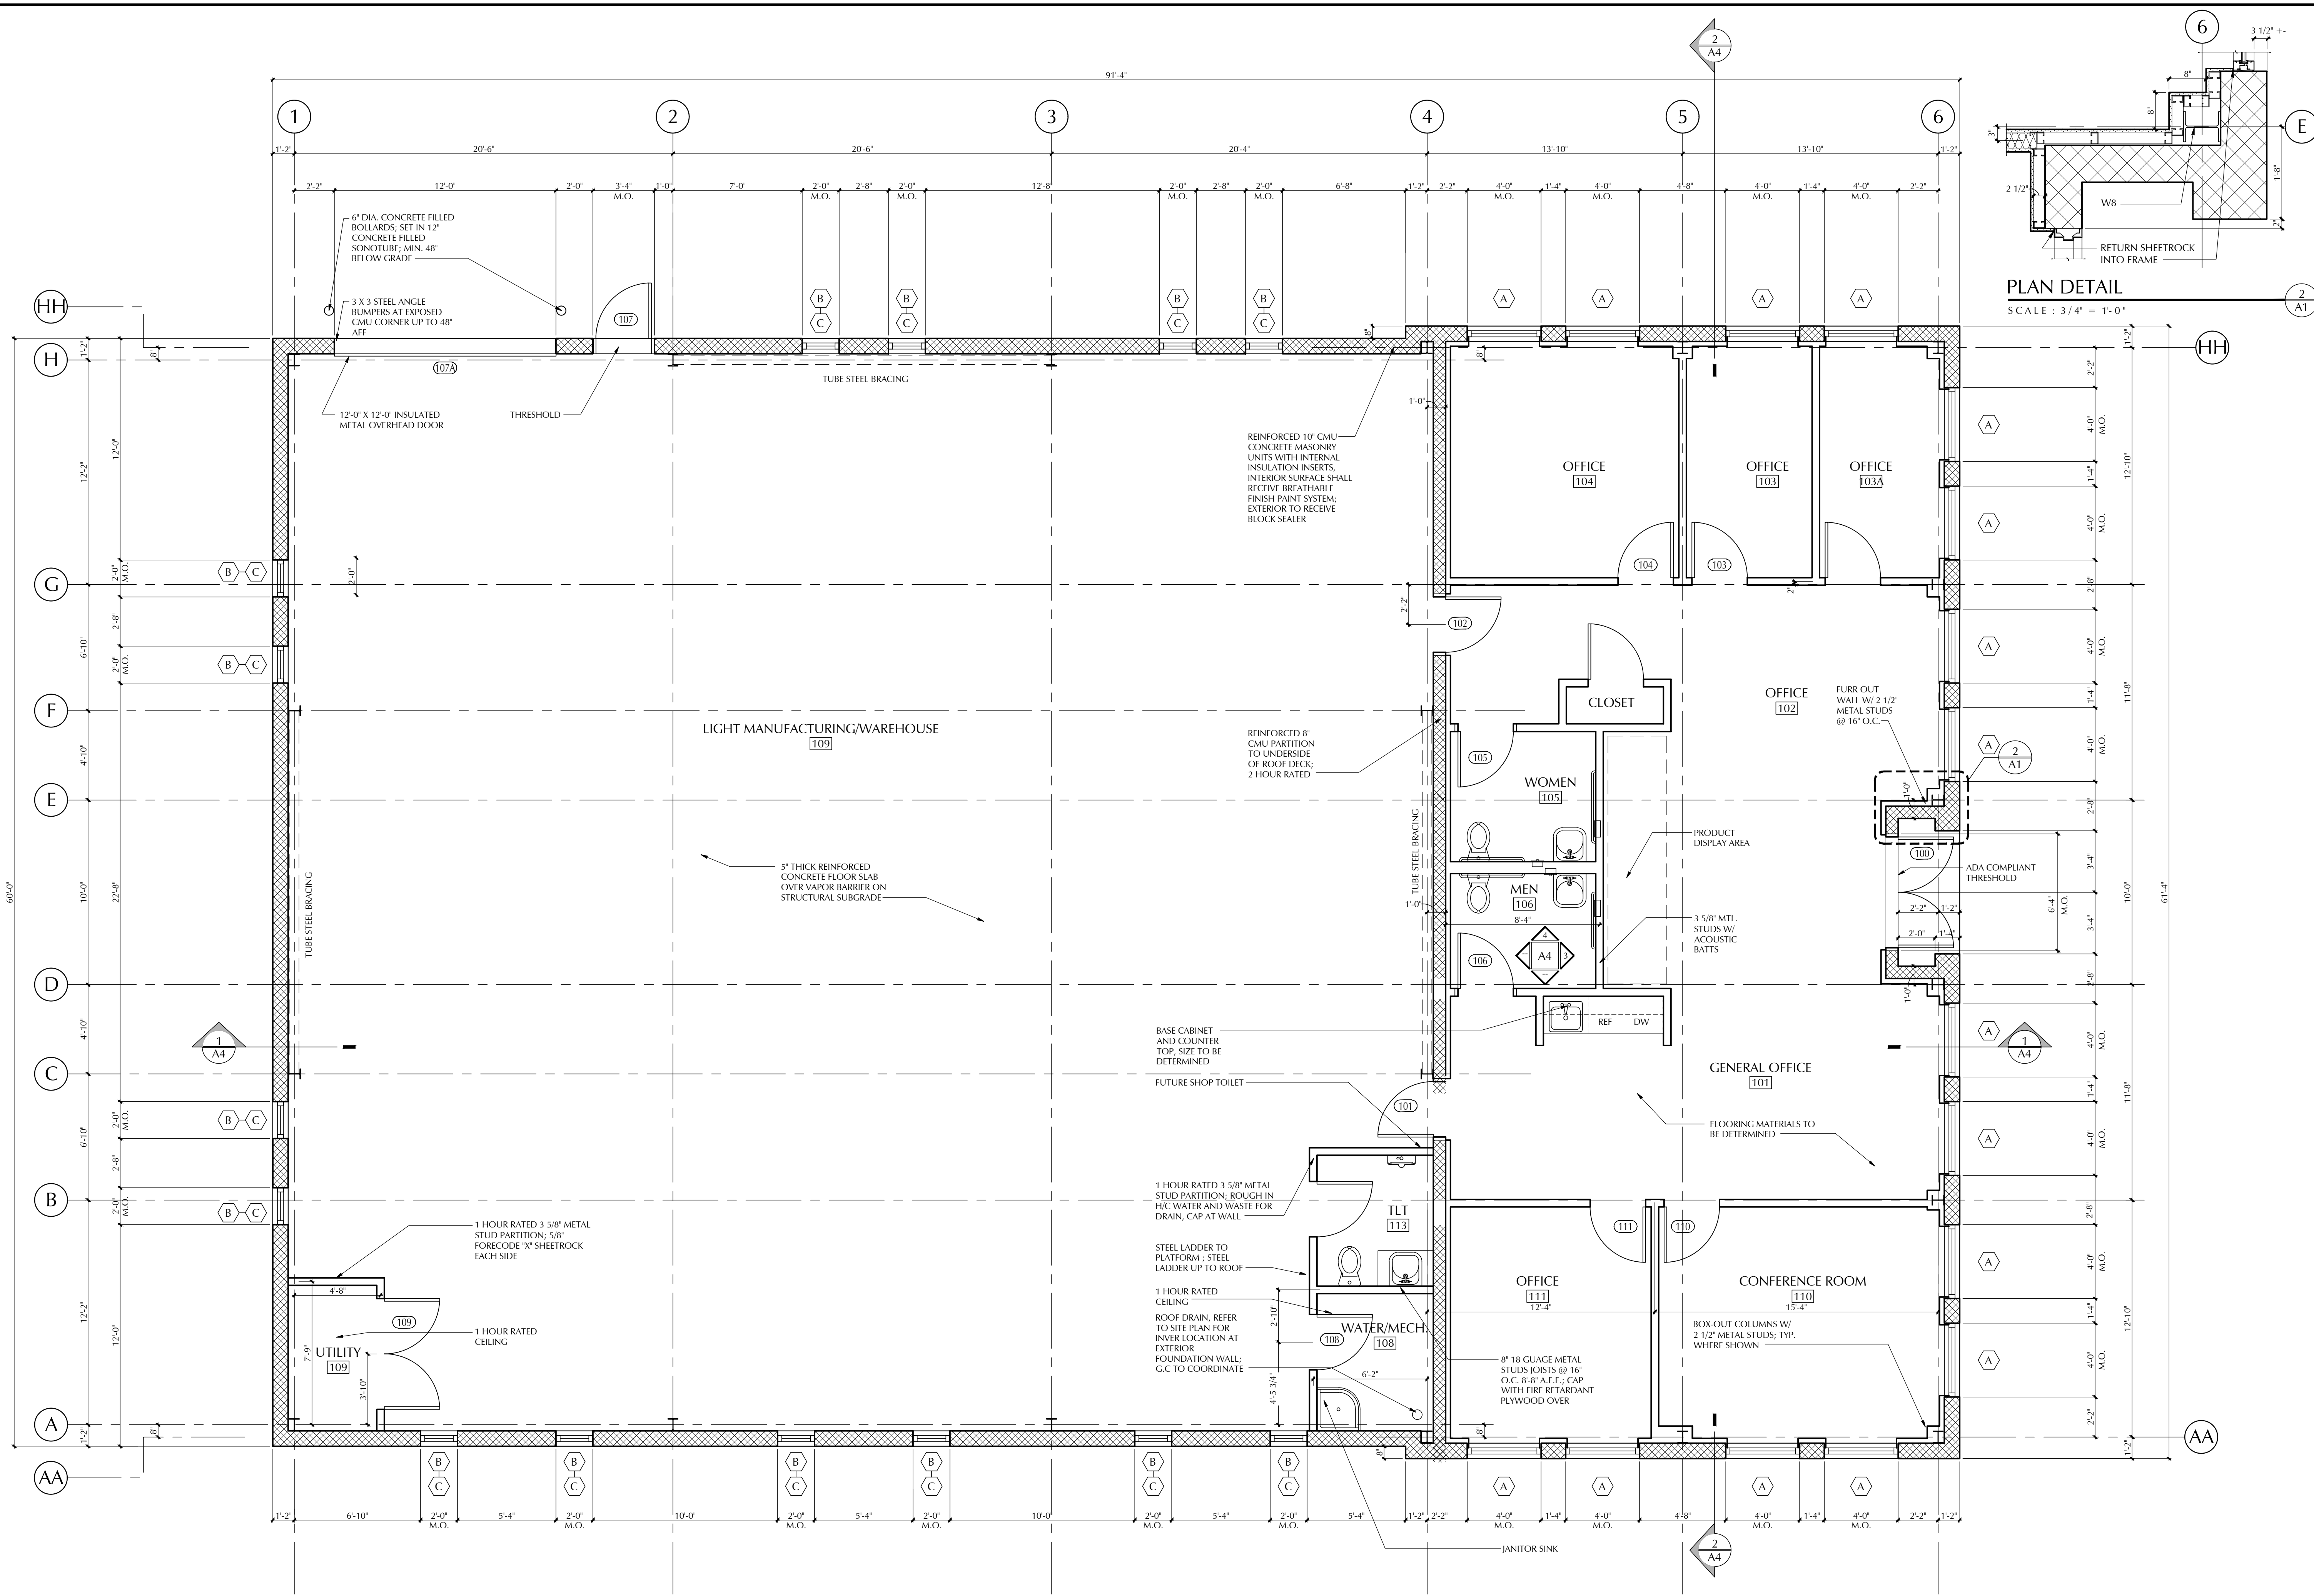

FLOOR PLAN
SCALE : 1/4" = 1'-0"

1
A1

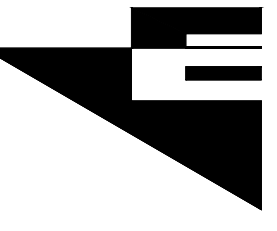

PO BOX 1137 380 Central Street
Hudson, Massachusetts 01505
telephone 508-869-0597

WILLIAM J. MASTELLO ARCHITECT, INC.

DATE: AUGUST 2, 2005
REVISION: MAY 30, 2007

PROJECT: NEW LIGHT MANUFACTURING FACILITY
KANE INDUSTRIAL DRIVE
HUDSON, MASSACHUSETTS

LOT 1 - OPTION A - PLANS AND ELEVATIONS

A
1