
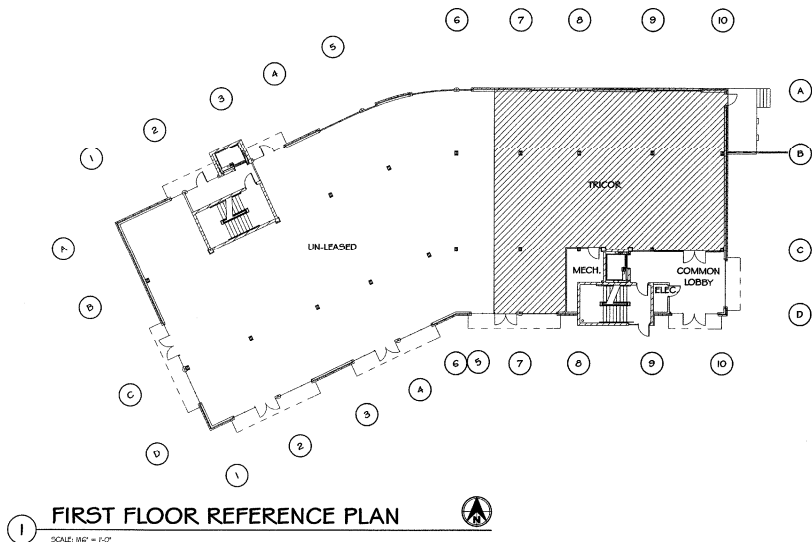


GENERAL NOTES:

1. **GENERAL:**
 - A. ALL DIMENSIONS SHOWN ARE TO THE STRUCTURAL FRAMING. FINISH COVERINGS ARE TO BE ADDED.
 - B. CONTRACTOR SHALL VERIFY ALL ROOF OPENINGS REQUIRED FOR WINDOWS, DOORS, PLUMBING FIXTURES, ETC. PRIOR TO WALL CONSTRUCTION.
2. **FIRE EXTINGUISHERS:**
 - A. FIRE EXTINGUISHERS SHALL BE PROVIDED BY OWNER AND LOCATED WHERE SHOWN ON THE PLANS OR IN ACCORDANCE WITH THE 2005 WISCONSIN ENCLOSED COMMERCIAL BUILDING CODE (WCCB), INTERNATIONAL FIRE CODE, LOCAL AFD-1000 NATIONAL FIRE PROTECTION ASSOCIATION, STANDARD INSTITUTE, AND THE AMERICAN WITH DISABILITIES ACT (ADA).
 - B. FIRE EXTINGUISHER RATING TO BE 4A-40BC.
3. **BLOCKING:**
 - A. PROVIDE BLOCK BLOCKING FOR TENANT SUPPLIED EQUIPMENT AND ACCESSORIES.
 - B. PROVIDE BLOCKING FOR DRIVING AND CHANGING PER INTERIOR DESIGNED PLANS AND SPECIFICATIONS.

06-24 Arch Notes-2

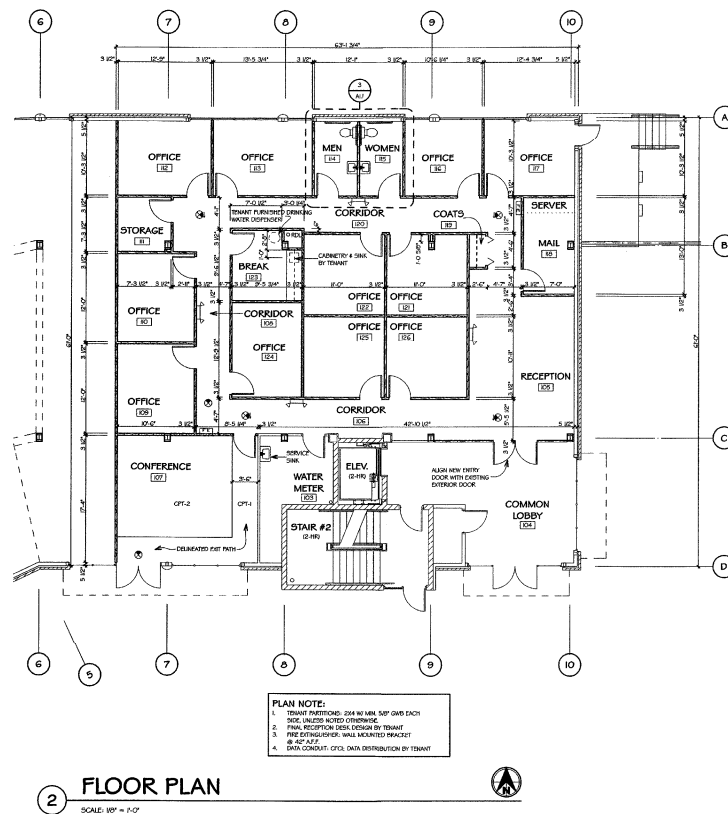

ADCI Architectural Design Consultants Inc. 161 Horizon Drive • Suite 102 Verona, WI 53593 Phone: (608) 848-2324 Fax: (608) 848-5122 These drawings are the property of ADCI. No part of these drawings may be reproduced, stored in a retrieval system, or transmitted in any form or by any means, electronic, mechanical, photocopying, recording, or by any information storage and retrieval system, without prior written permission of ADCI.	
TRICOR TENANT SPACE WISCONSIN MADISON	
FLOOR PLANS	
DRAWN BY: AGS/BWP CHECKED BY: P. SCHMIDT DATE: FEB. 1, 2007 SCALE: AS NOTED TYPED BY: AGS	SHEET NUMBER A1.1