


PLUMBING SYMBOLS AND ABBREVIATIONS			
	CONDENSATE LINE BELOW SLAB		CHECK VALVE
	CONDENSATE LINE ABOVE SLAB		ARROW INDICATES DIRECTION OF FLOW
	FIRE PROTECTION		GAS SHUTOFF VALVE
	GREASE WASTE		CW COLD WATER
	COLD WATER PIPING (CW)		FD FLOOR DRAIN
	HOT WATER PIPING (HW)		FPHB FREEZE PROOF HOSE BIBB
	HOT WATER RETURN PIPING (HWR)		G GAS
	GAS PIPING		HB HOSE BIBB
	VENT PIPING		HW HOT WATER
	SANITARY BELOW GRADE OR SLAB		HWR HOT WATER RETURN
	SANITARY ABOVE GRADE OR SLAB		HD HUB DRAIN
	HOSE BIBB OR WALL HYDRANT		LV LAVATORY
	FLOOR DRAIN OR FLOOR SINK		MS MOP SINK
	FLOOR HYDRANT		OD OVERFLOW DRAIN
	SHUTOFF VALVE IN PIPE		RD ROOF DRAIN
	BALANCING VALVE		SK SINK
	90 DEG. ELBOW DOWN (DROP IN PIPE)		S STORM
	90 DEG. ELBOW UP (RISE IN PIPE)		UR URINAL
	HORIZONTAL CLEAN OUT		V VENT
	CLEAN OUT IN FLOOR		VTR VENT THRU ROOF
	VERTICAL PIPE DROP OUT OF BOTTOM OF HORIZONTAL PIPE		WH WALL HYDRANT
	VERTICAL PIPE RISE OUT OF TOP OF HORIZONTAL PIPE		W WASTE
	WATER HAMMER ARRESTOR		WC WATER CLOSET
	PITCH PIPE DOWN IN DIRECTION OF ARROW		WH WATER HEATER
NOTE: SOME SYMBOLS MAY NOT BE USED.			CONNECTION TO EXISTING UTILITY

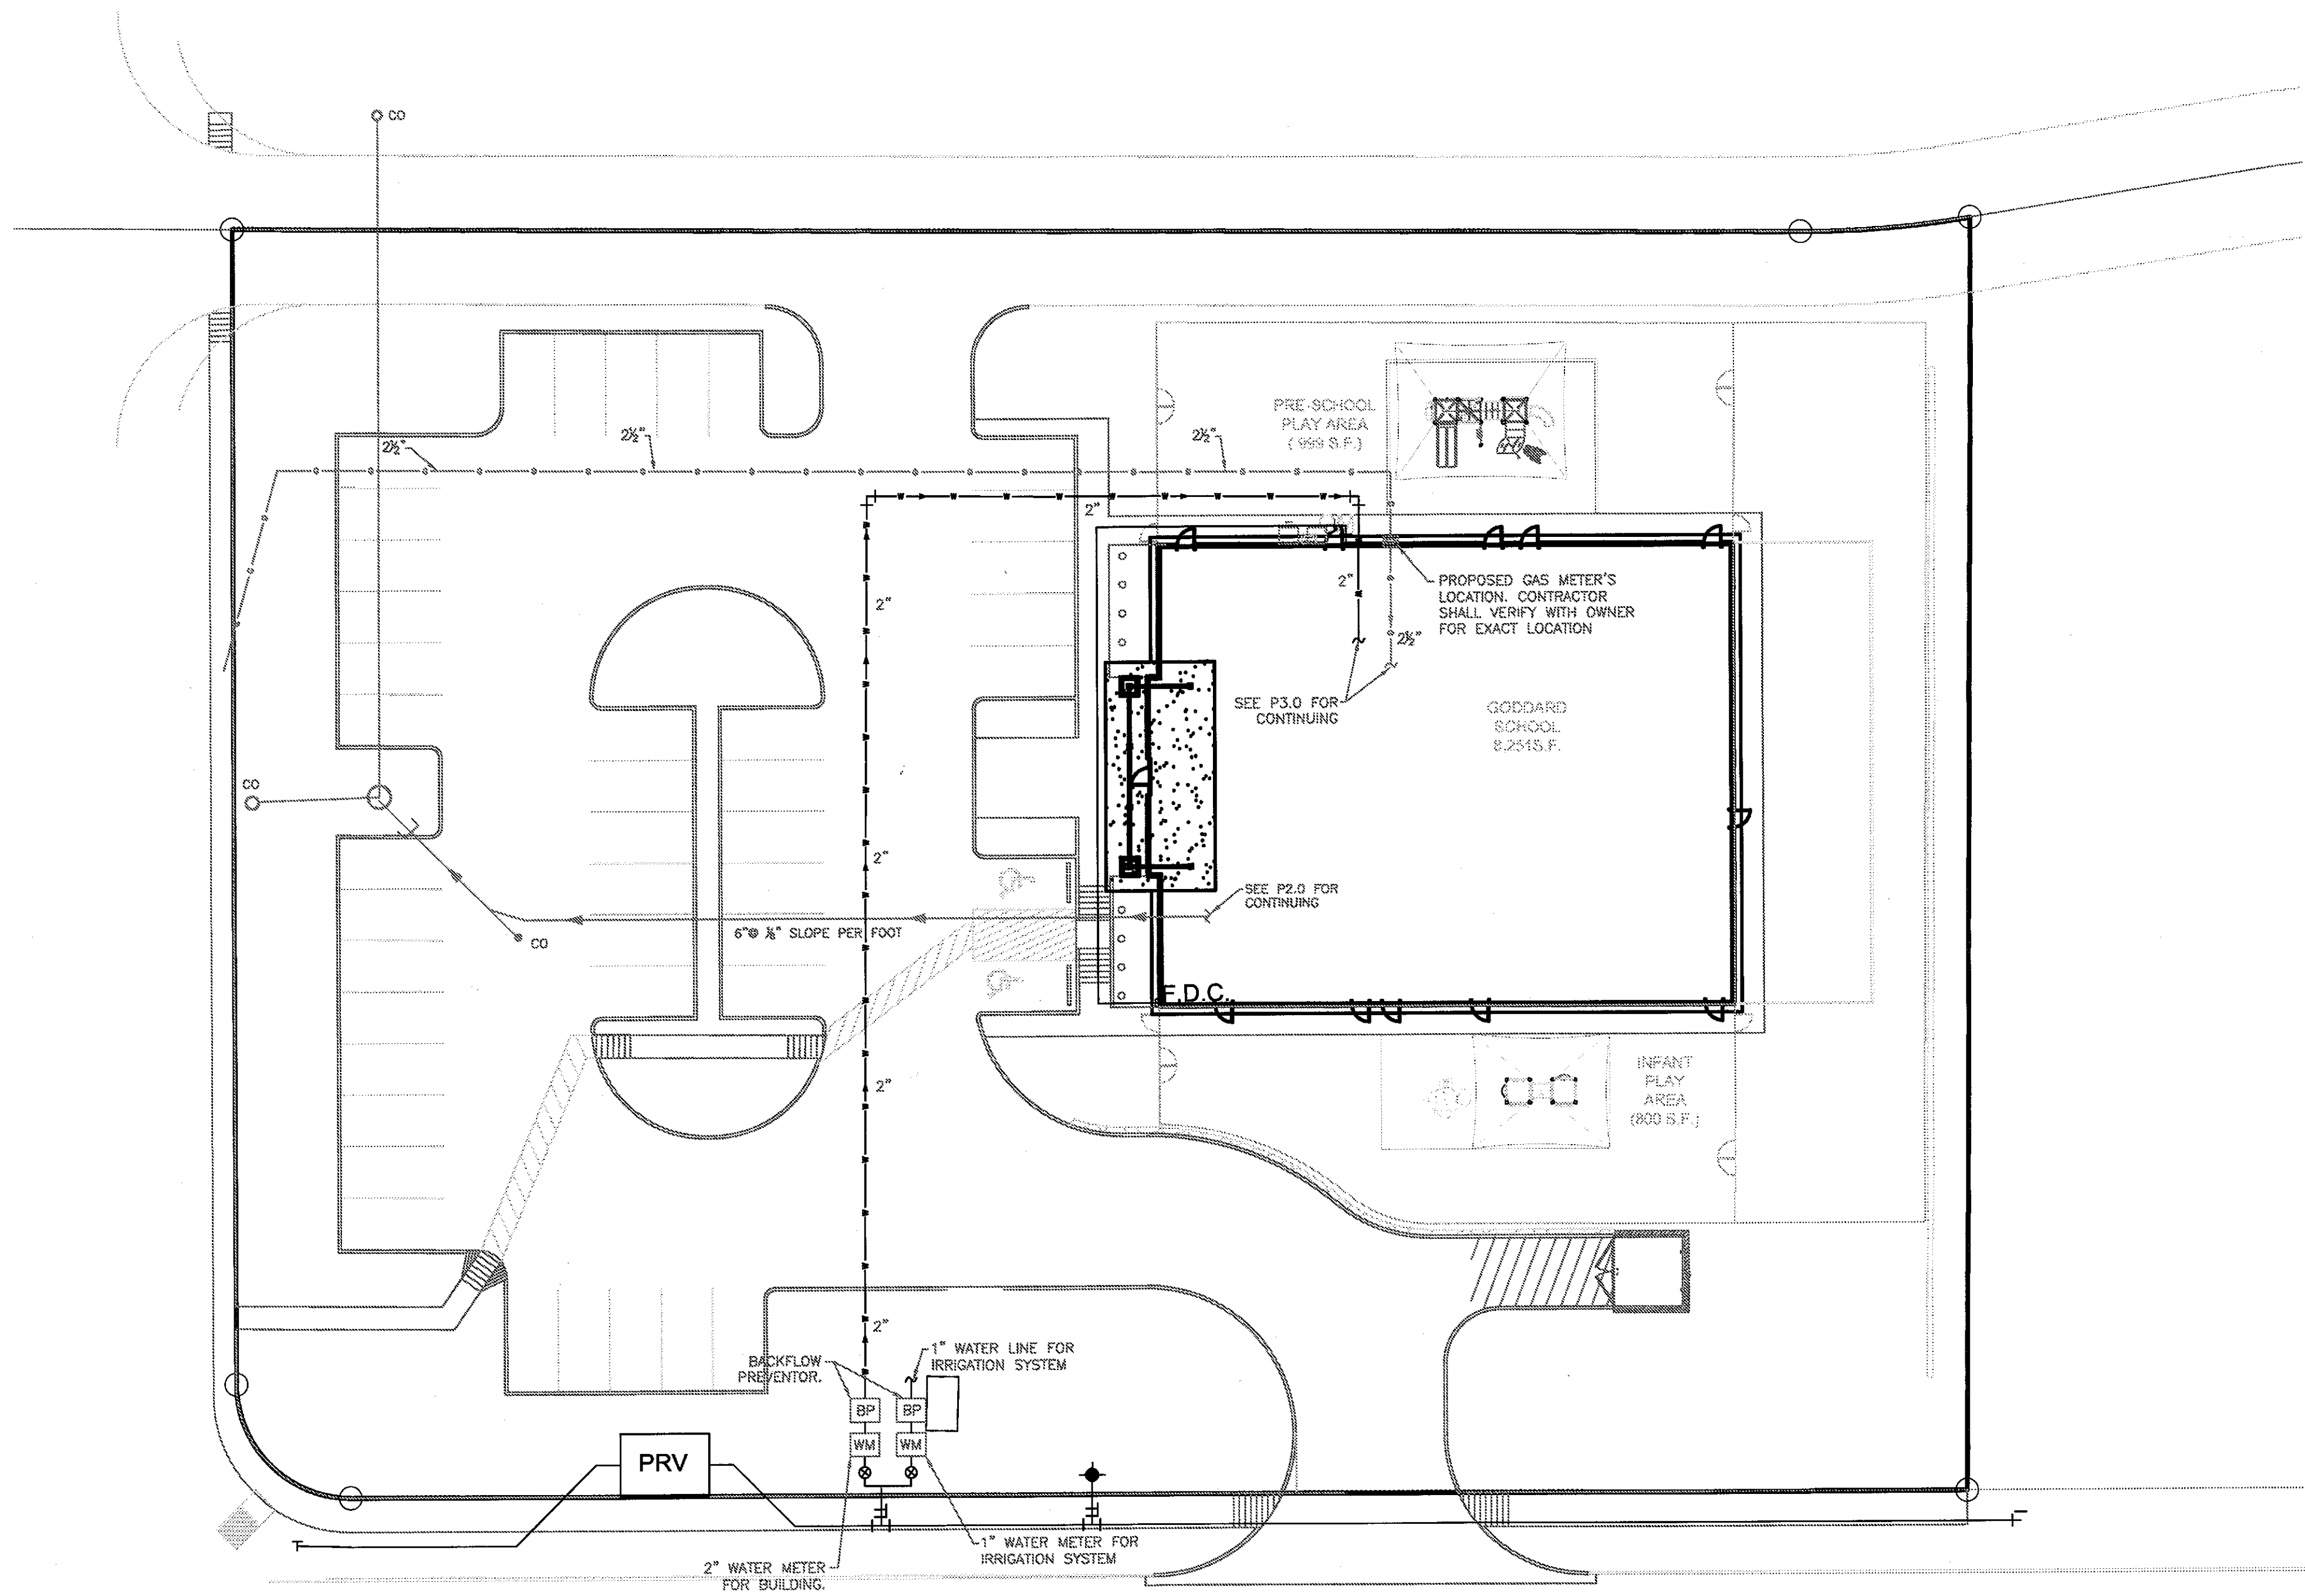


1 SITE PLAN
SCALE: 1"=20'-0"

D.R.
ASSOCIATES
ARCHITECTS

800 W. SAN ANTONIO STREET, SUITE 100
HOUSTON, TX 77042

P: (713) 865-1111 F: (713) 865-1112
WWW.DRARCHITECTS.COM

APRIL 4, 2011

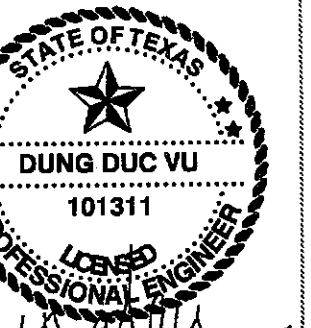

DUNG DUC VU, P.E.
REGISTRATION #: 101311
1250 Bay Area Blvd., Suite D
Houston, TX 77058
Tel: (832) 278-0752
Fax: (281) 282-9144

REVISIONS	1	2	3	4	5

The Goddard School
Sandy Brook Dr. & Satellite View
ROUND ROCK, TX

PLUMBING
SITE
PLAN

SHEET TITLE

1/8"=1'-0"

SCALE

5047

PROJECT NUMBER

Mar. 18, 2011

DATE

P6.0

SHEET NUMBER