


FLOOR PLAN
SCALE : 1/8" = 1'-0"

SANITARY RISER DIAGRAM


NOT TO SCALE

NOTE:
1. CONTRACTOR IS TO PROVIDE MAIN SANITARY, 3" VTR'S AND STUBS FOR FUTURE TOILETS. TENANT IS TO PROVIDE FINISHED TOILETS AT TIME OF INTERIOR FINISH OUT.

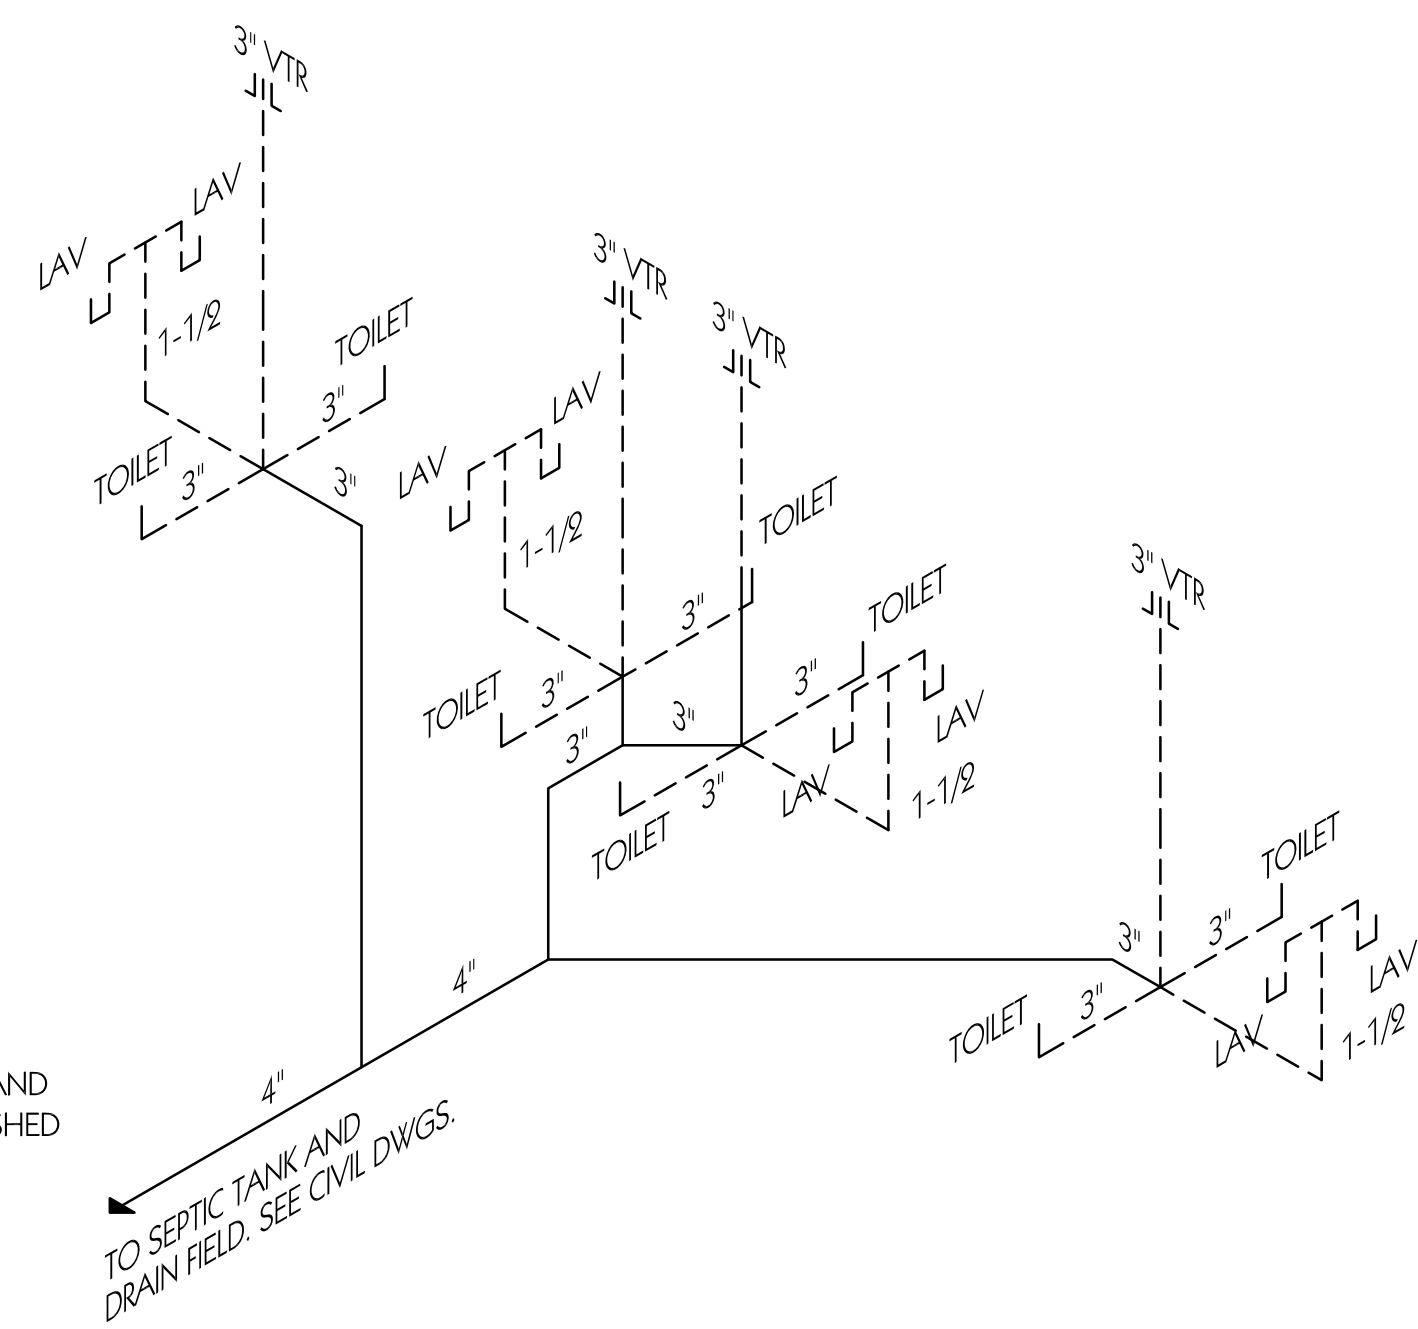

TO SEPTIC TANK AND DRAIN FIELD. SEE CIVIL DWGS.

TO SEPTIC TANK AND DRAIN FIELD. SEE CIVIL DWGS.

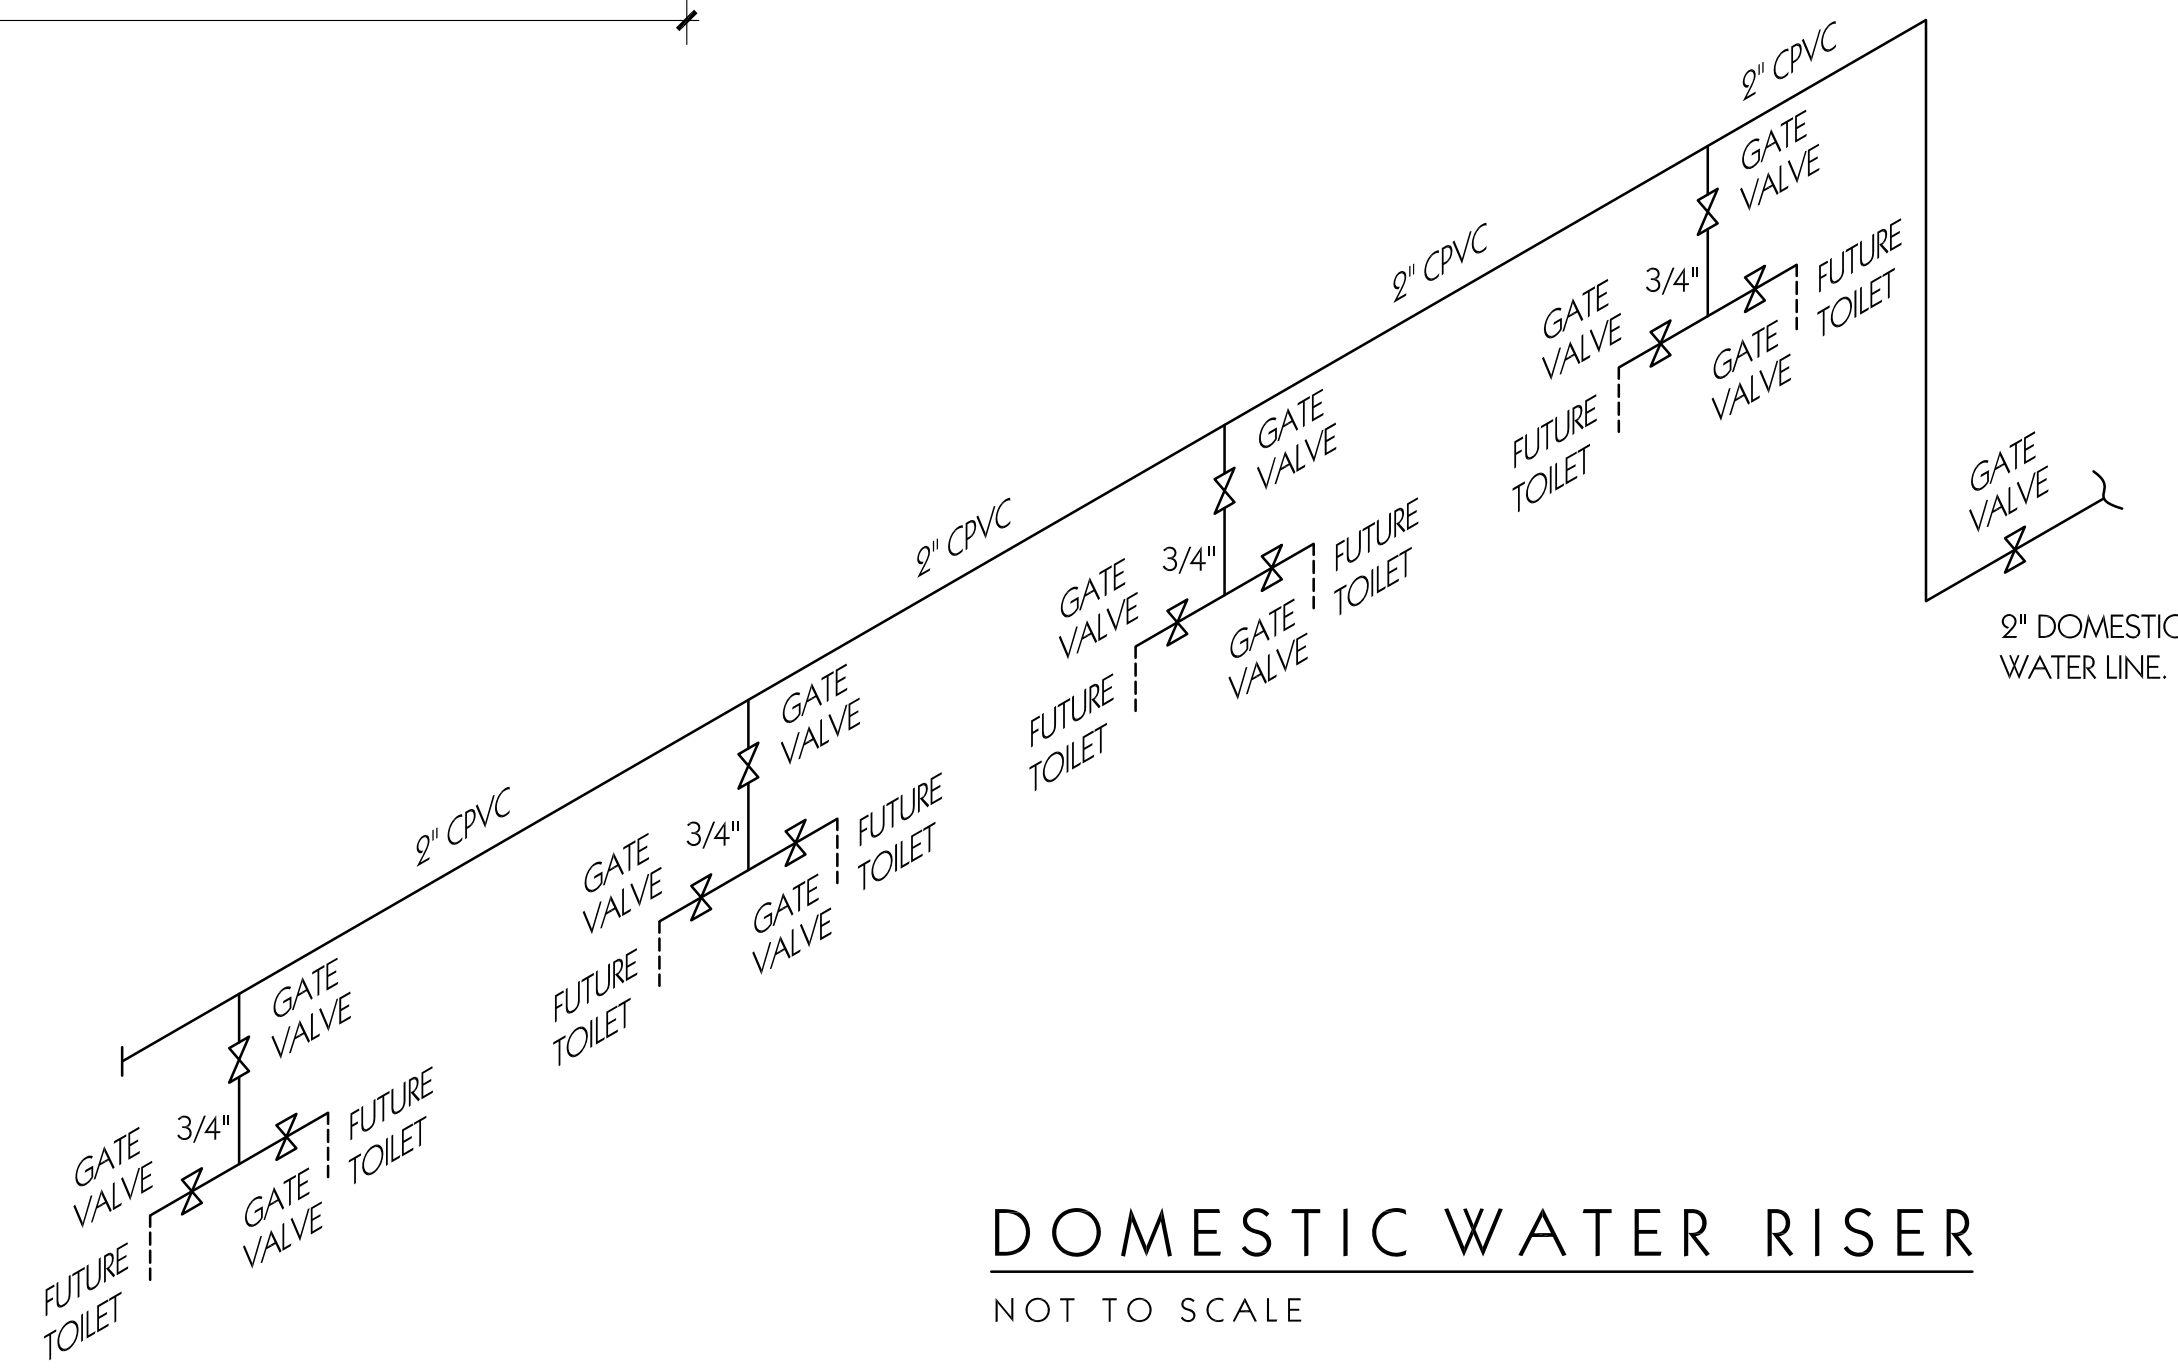


DOMESTIC WATER RISER
NOT TO SCALE

dr	JJA
pl	17-035
ch	MDJ
da	11-15-17

architect	engineer
Mark D. Johnson, AIA	

New Office Building for:
LAND O' LAKES BUSINESS CENTER
Pasco County, Florida
AA-C000164
813-685-4521

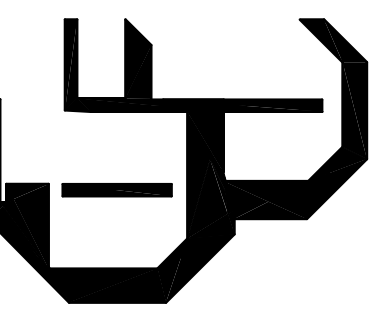

1	
2	
3	
4	
SHEET	
A-1	
OF 2	

dykes-johnson architecture, inc.
2006 west brandon blvd. brandon, florida 33511