



REVISIONS	BY

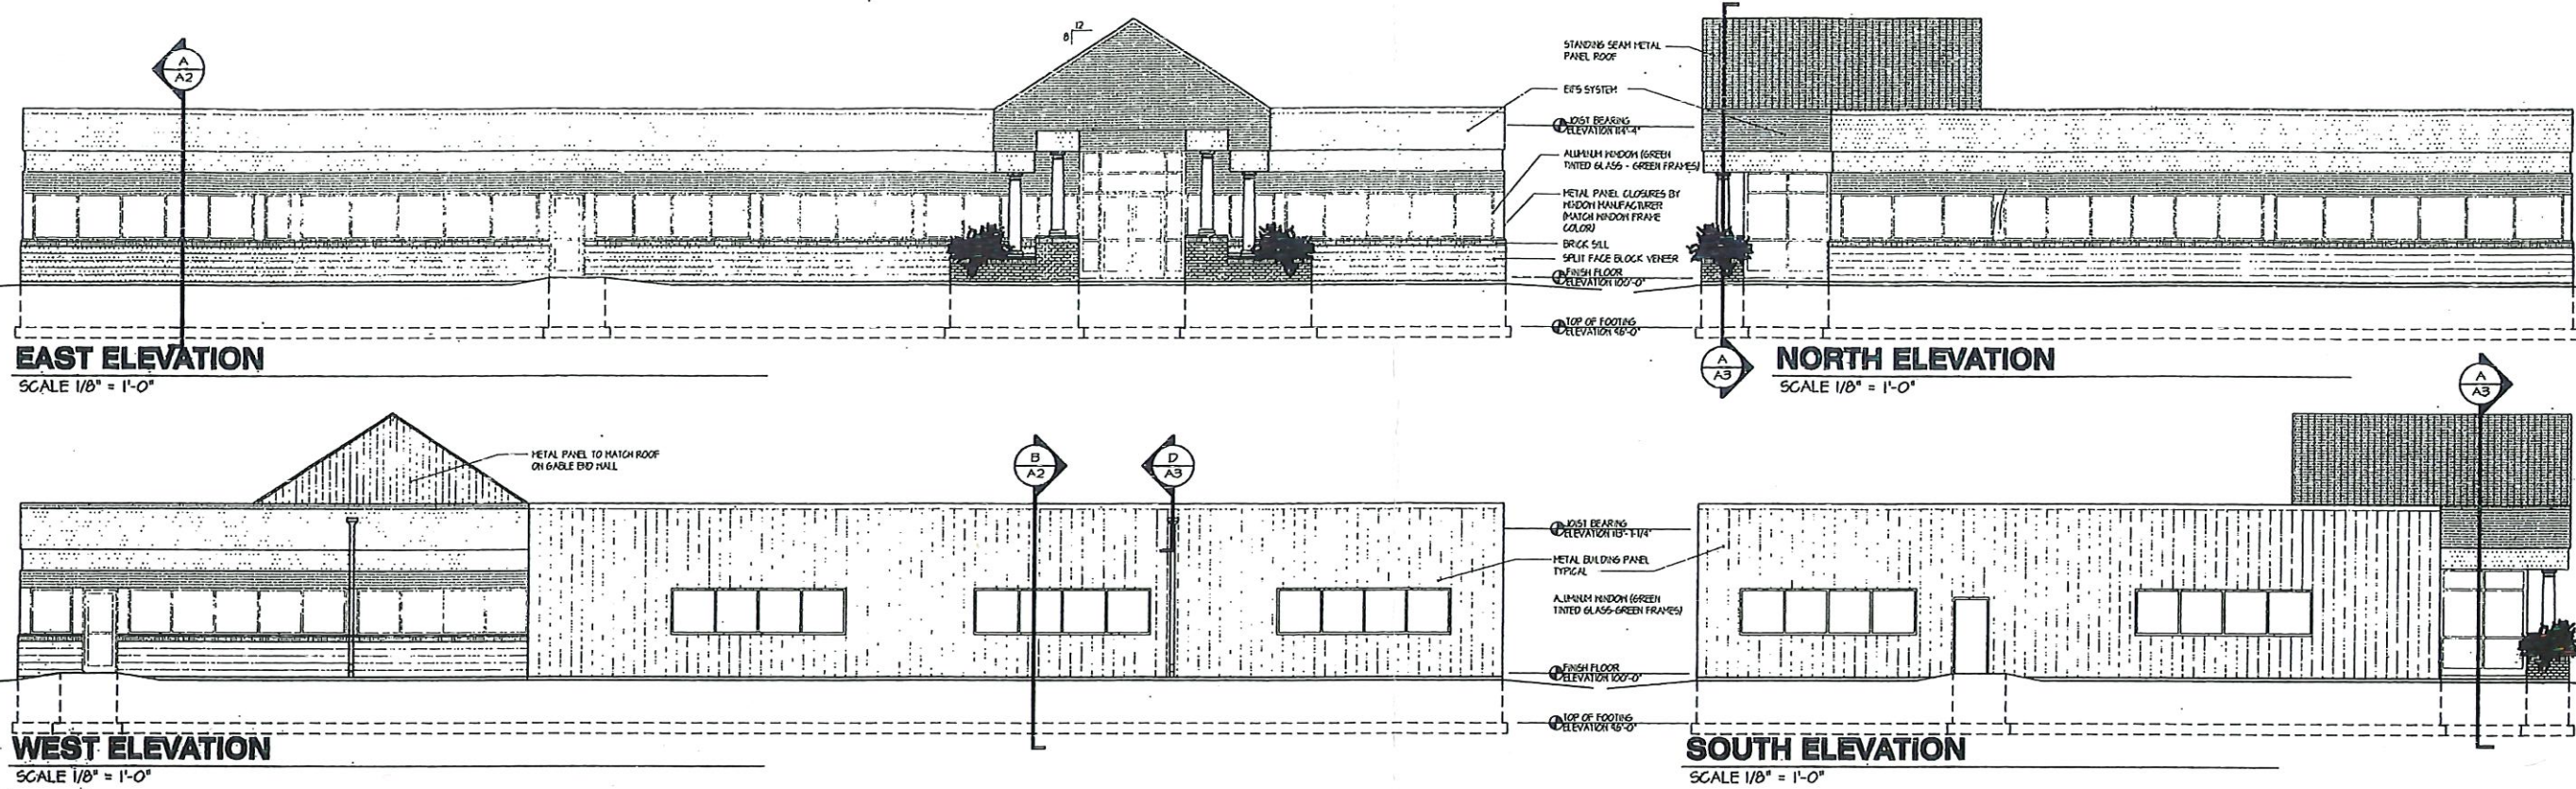

ROOM FINISH SCHEDULE							(VERIFY FINISHES NUMBER)
ROOM	FLOOR	BASE	WALLS	CEILING	HEIGHT	REMARKS	
101	VESTIBULE	CERAMIC TILE	G.T.	GYPSPM PAINTED	2'X2' A.G.T.	12'-0"	REG. FLOOR MAT
102	LOBBY	12'X12' V.G.T.	VINYL	GYPSPM PAINTED	2'X2' A.G.T.	10'-0"	
103	MECHANICAL	CONCRETE/PID.	VINYL	GYPSPM PAINTED	EXP. STRUCTURE	14'-0" H.	
104	HEATING ROOM	CARPET	VINYL	GYPSPM PAINTED	2'X2' A.G.T.	10'-0"	
105	REL. LAB	12'X12' V.G.T.	VINYL	GYPSPM PAINTED	2'X2' A.G.T.	8'-6"	
106	VESTIBULE	12'X12' V.G.T.	VINYL	GYPSPM PAINTED	2'X2' A.G.T.	8'-6"	
107	CORRIDOR	12'X12' V.G.T.	VINYL	GYPSPM PAINTED	2'X2' A.G.T.	10'-0"	
108	CLOSING	CARPET	VINYL	GYPSPM PAINTED	2'X2' A.G.T.	8'-6"	
109	NOVEN	CERAMIC TILE	C.T.	HP. GYP. PAINTED	2'X2' V.G.B.	8'-6"	
110	MEN	CERAMIC TILE	C.T.	HP. GYP. PAINTED	2'X2' V.G.B.	8'-6"	
111	CONF. BREAK ROOM	12'X12' V.G.T.	VINYL	GYPSPM PAINTED	2'X2' A.G.T.	8'-6"	
112	SERVICE	CARPET	VINYL	GYPSPM PAINTED	2'X2' A.G.T.	8'-6"	
113	BOOKKEEPING	CARPET	VINYL	GYPSPM PAINTED	2'X2' A.G.T.	8'-6"	
114	CORRIDOR	CARPET	VINYL	GYPSPM PAINTED	2'X2' A.G.T.	8'-6"	
115	STORAGE	12'X12' V.G.T.	VINYL	GYPSPM PAINTED	2'X2' A.G.T.	8'-6"	
116	HALL/COFF	CARPET	VINYL	GYPSPM PAINTED	2'X2' A.G.T.	8'-6"	
117	NOVEN'S SHOWER	CERAMIC TILE	C.T.	HP. GYP. PAINTED	2'X2' V.G.B.	8'-6"	
118	MEN'S SHOWER	CERAMIC TILE	C.T.	HP. GYP. PAINTED	2'X2' V.G.B.	8'-6"	
119	SAMPLE PREP	12'X12' V.G.T.	VINYL	GYPSPM PAINTED	2'X2' A.G.T.	8'-6"	
120	CORRIDOR	CARPET	VINYL	GYPSPM PAINTED	2'X2' A.G.T.	8'-6"	
121	OFFICE	CARPET	VINYL	GYPSPM PAINTED	2'X2' A.G.T.	8'-6"	
122	STORAGE	12'X12' V.G.T.	VINYL	GYPSPM PAINTED	2'X2' A.G.T.	8'-6"	
123	FILE ROOM	CARPET	VINYL	GYPSPM PAINTED	2'X2' A.G.T.	8'-6"	
124	STORAGE	12'X12' V.G.T.	VINYL	GYPSPM PAINTED	2'X2' A.G.T.	8'-6"	
125	STORAGE	12'X12' V.G.T.	VINYL	GYPSPM PAINTED	2'X2' A.G.T.	8'-6"	
126	OFFICE	CARPET	VINYL	GYPSPM PAINTED	2'X2' A.G.T.	8'-6"	
127	OFFICE	CARPET	VINYL	GYPSPM PAINTED	2'X2' A.G.T.	8'-6"	
128	OPEN OFFICE	CARPET	VINYL	GYPSPM PAINTED	2'X2' A.G.T.	8'-6"	
129	OPEN OFFICE	CARPET	VINYL	GYPSPM PAINTED	2'X2' A.G.T.	8'-6"	
130	OFFICE	CARPET	VINYL	GYPSPM PAINTED	2'X2' A.G.T.	8'-6"	
131	HALLWAY	CARPET	VINYL	GYPSPM PAINTED	2'X2' A.G.T.	8'-6"	

DOOR SCHEDULE							(VERIFY ALL HARDWARE FRUNCTIONS NUMBER)
NO.	SIZE	DOOR TYPE	ELEV.	FRAME TYPE	ELEV.	HARDWARE	REMARKS
1	(2) 3'-0"X7'-0"	ALUMINUM	L.I.K.	ALUMINUM	H	PANIC HARDWARE	
2	(2) 3'-0"X7'-0"	ALUMINUM	H	ALUMINUM	H	PUSH/PULL	
3	3'-0"X7'-0"X3/4"	SC. WOOD	A	HOLLOW METAL	F	LOCKSET	
4	3'-0"X7'-0"X3/4"	SC. WOOD	B	HOLLOW METAL	F	PANIC HARDWARE	
5	(2) 2'-6"X7'-0"X3/4"	SC. WOOD	C	HOLLOW METAL	F	STORAGE LOCK	
6	3'-0"X7'-0"X3/4"	SC. WOOD	B	HOLLOW METAL	F	PANIC HARDWARE	
7	3'-0"X7'-0"	ALUMINUM	G	ALUMINUM	S	LOCKSET	
8	3'-0"X7'-0"X3/4"	SC. WOOD	B	HOLLOW METAL	F	LOCKSET	
9	3'-0"X7'-0"X3/4"	SC. WOOD	B	HOLLOW METAL	F	LATCHSET	
10	(2) 3'-0"X7'-0"X3/4"	SC. WOOD	D	HOLLOW METAL	F	PANIC HARDWARE	
11	3'-0"X7'-0"X3/4"	SC. WOOD	B	HOLLOW METAL	F	LATCHSET	
12	3'-0"X7'-0"X3/4"	SC. WOOD	A	HOLLOW METAL	F	PUSH/PULL	
13	3'-0"X7'-0"X3/4"	SC. WOOD	A	HOLLOW METAL	F	PUSH/PULL	
14	3'-0"X7'-0"X3/4"	SC. WOOD	B	HOLLOW METAL	F	LOCKSET	
15	3'-0"X7'-0"X3/4"	SC. WOOD	A	HOLLOW METAL	F	LOCKSET	
16	3'-0"X7'-0"X3/4"	SC. WOOD	D	HOLLOW METAL	F	LOCKSET	
17	3'-0"X7'-0"X3/4"	SC. WOOD	A	HOLLOW METAL	F	STORAGE LOCK	
18	(2) 1						
19	3'-0"X7'-0"X3/4"	SC. WOOD	A	HOLLOW METAL	F	PRIVATEY LOCK	
20	3'-0"X7'-0"X3/4"	SC. WOOD	A	HOLLOW METAL	F	PRIVATEY LOCK	
21	3'-0"X7'-0"X3/4"	SC. WOOD	B	HOLLOW METAL	F	LOCKSET	
22	3'-0"X7'-0"	ALUMINUM	G	ALUMINUM	G	LOCKSET	
23	3'-0"X7'-0"X3/4"	SC. WOOD	B	HOLLOW METAL	F	LOCKSET	
24	3'-0"X7'-0"X3/4"	SC. WOOD	A	HOLLOW METAL	F	STORAGE LOCK	
25	3'-0"X7'-0"X3/4"	SC. WOOD	A	HOLLOW METAL	F	STORAGE LOCK	
26	3'-0"X7'-0"X3/4"	SC. WOOD	B	HOLLOW METAL	F	LOCKSET	
27	3'-0"X7'-0"X3/4"	SC. WOOD	A	HOLLOW METAL	F	STORAGE LOCK	
28	3'-0"X7'-0"X3/4"	SC. WOOD	B	HOLLOW METAL	F	LOCKSET	
29	3'-0"X7'-0"X3/4"	SC. WOOD	B	HOLLOW METAL	F	LOCKSET	
30	3'-0"X7'-0"X3/4"	SC. WOOD	B	HOLLOW METAL	F	LOCKSET	
31	3'-0"X7'-0"	HULL REG.	E	HULL REG.	F	PANIC HARDWARE	

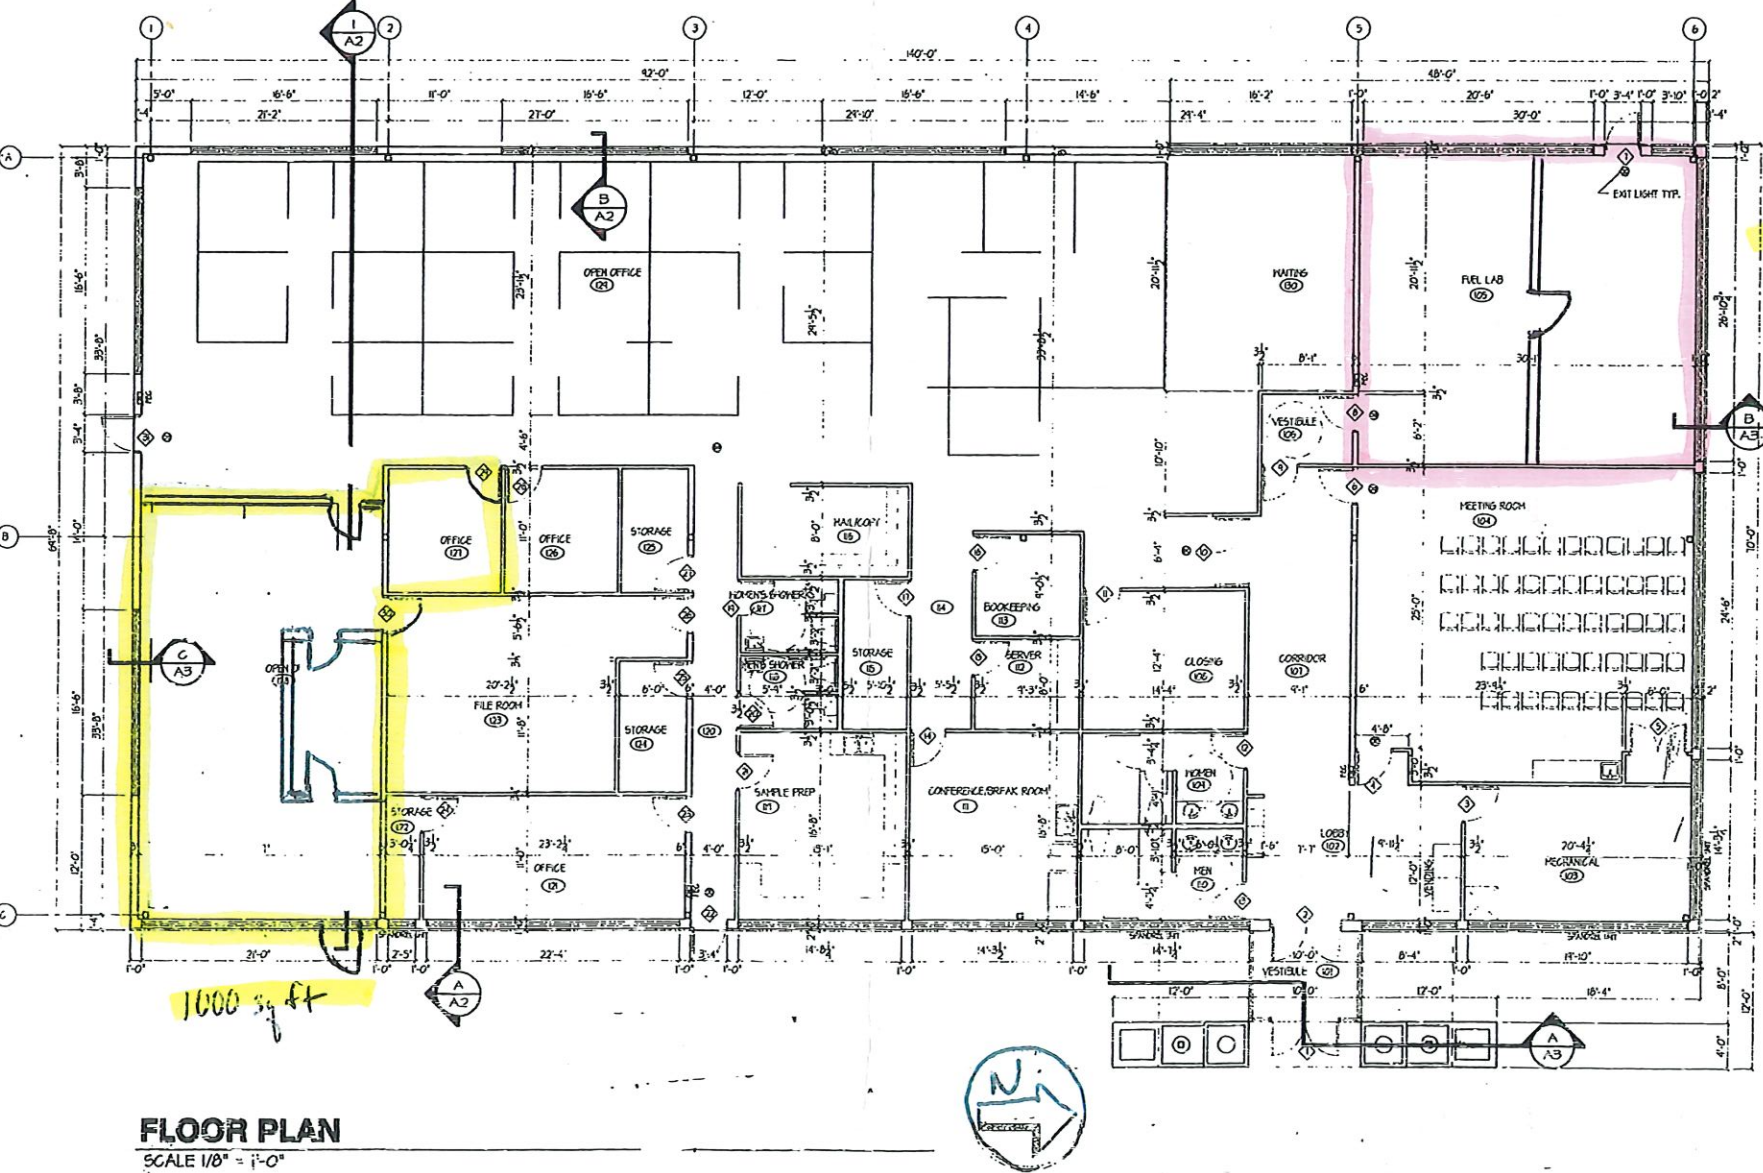

950 sq ft

1000 sq ft

FINAL PLAN VIEW 1008-3-3-2715
 BY DANIEL J. HELMIG ARCHITECTURALLY APPROVED
Daniel J. Helmig



SHEET INDEX	
NO.	ROOM NAME
A-1	FLOOR PLAN, ELEVATIONS, ROOM FINISH & DOOR SCHEDULE
A-2	SECTIONS, SITE PLAN, INTERIOR ELEVATIONS, DOOR ELEVATIONS
A-3	SECTIONS, GENERAL NOTES
S-1	FOUNDATION PLAN, SCHEDULES, DETAILS
S-2	ROOF FRAMING PLAN, DETAILS & ROOF PLAN
P-1	PLUMBING PLAN, ISOMETRICS

JANESVILLE DNR
DESIGN UNLIMITED
 DAN HELMIG, ARCHITECT A.I.A. 303 WEST VERMILION STREET, JACO, MASSHURLEIGH, WI (715) 364-3207 (FAX) 364-4923



DRAWN BY
 DLH5
 CHECKED BY
 D.J.H.
 DATE
 1/24/49
 SCALE
 AS NOTED
 JOB NO.
 SHEET

A-1