


PROPOSED PLUMBING

NOTES:

- ① BAR SINK ELKAY # BLR-15, WITH CHICAGO FAUCET # 895 317
- ② NEW MOD SINK & FAUCET - MUSTEE 24x14 W/FAUCET & HOSE ASSEMBLY
- ③ NEW TOILET HANDICAP ACCESSIBLE - AMERICAN STANDARD # 2812-053 ELONGATED V/BENESE SENT ELEVATOR
- ④ NEW LAV: AMERICAN STANDARD # 0 355 1012 WALL HUNG V/NOEN 4" CTR FAUCET
- ⑤ PROVIDE DRAIN FOR CONDENSATE FROM RT. UNIT COORDINATE LOCATION W/ H.V.A.C. CONTR.
- ⑥ NEW HW. HEATER 40 GAL GAS (AD. SMITH'S EQUAL)
- ⑦ GAS WATER COOLER INVEL # 0065414
- ⑧ FUTURE BAR SINK
- ⑨ AMERICAN STANDARD TOILET #
- ⑩ FIBERGLASS SHOWER UNIVERSAL - RUNDLE # 6030-U-01 OR APPROVED EQUAL
- ⑪ ONE PIECE COUNTER & LAV COMBINATION (COORDINATE V/USER)
- ⑫ FUTURE SINK FOR PROFESSIONAL BACK CLEANING
- ⑬ NEW 5 PAN GAS FIRED RECEPTOR UNIT
- ⑭ FUTURE RECEPTOR UNIT

PLUMBING NOTES:

- 1. ALL WORK MUST MEET PLUMBING CODE
- 2. PLUMBING CONTR. TO RUN NEW 4" SAN. 2. 2" SAN. 2. HOT & COLD WATER.
- 3. PLUMBING CONTRACTOR TO PROVIDE NEW HOT WATER TANK W/CIRCULATING PUMP & LOOP
- 4. PLUMBING CONTRACTOR TO PROVIDE PERMITS FOR SANITARY & WATER ISOMETRIC DRAWING FOR PERMIT AS REQ'D.
- 5. PLUMBING CONTRACTOR TO PROVIDE ALL SHEETS OF EQUIPMENT TO OWNER FOR APPROVAL

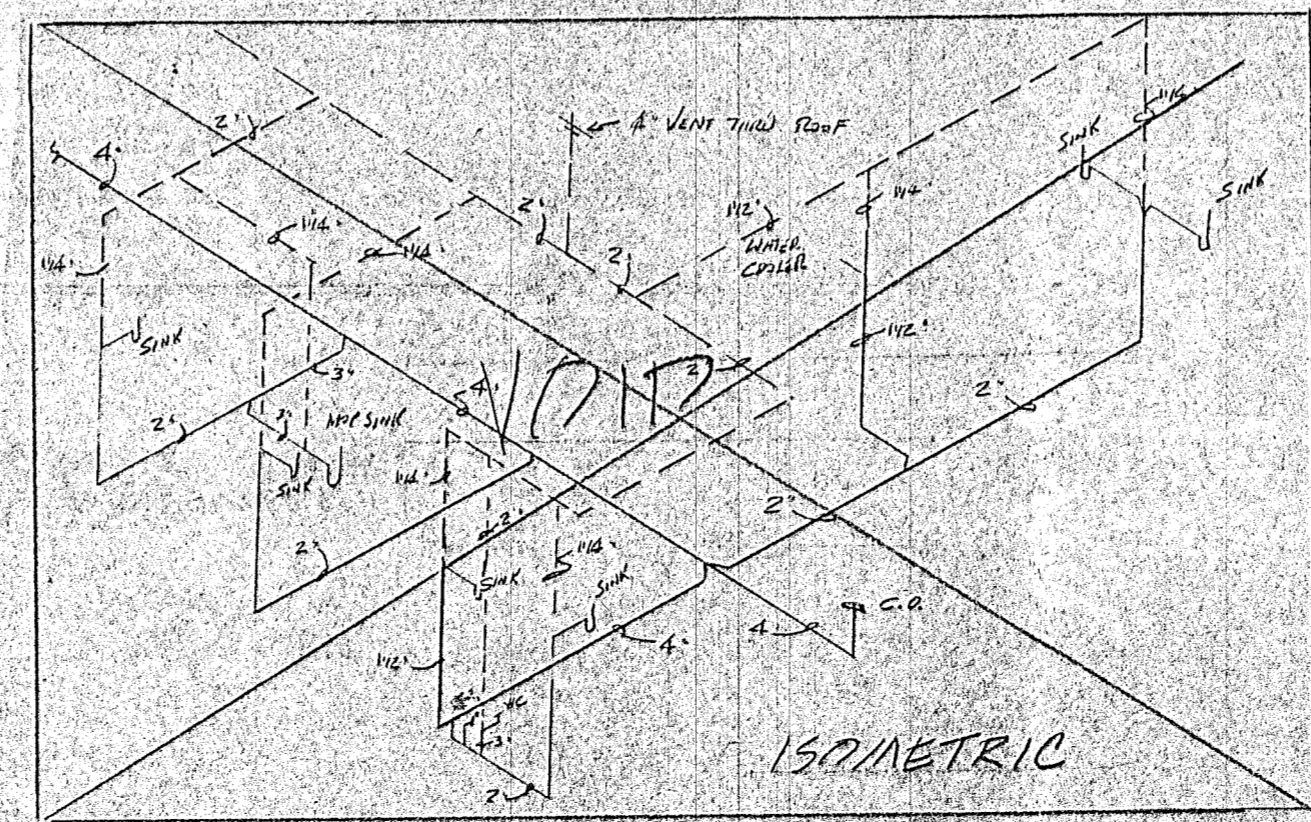

REVISION	NO.	DATE	BY
DATE ISSUED FOR CONSTRUCTION			
TITLE PROPOSED PLUMBING PLAN			WORK ORDER NO.
PROJECT FARMERSVILLE DOCTORS OFFICE			PROJECT NO. 0326
			DATE NOV. 21, 1993
			DRAWN BY R. PAPP
Kettering Medical Center ARCHITECTURE & DESIGN 3535 SOUTHERN BLVD. KETTERING, OHIO 45429			SCALE 1/8" = 1'-0"
			DRAWING NO. 12-1