


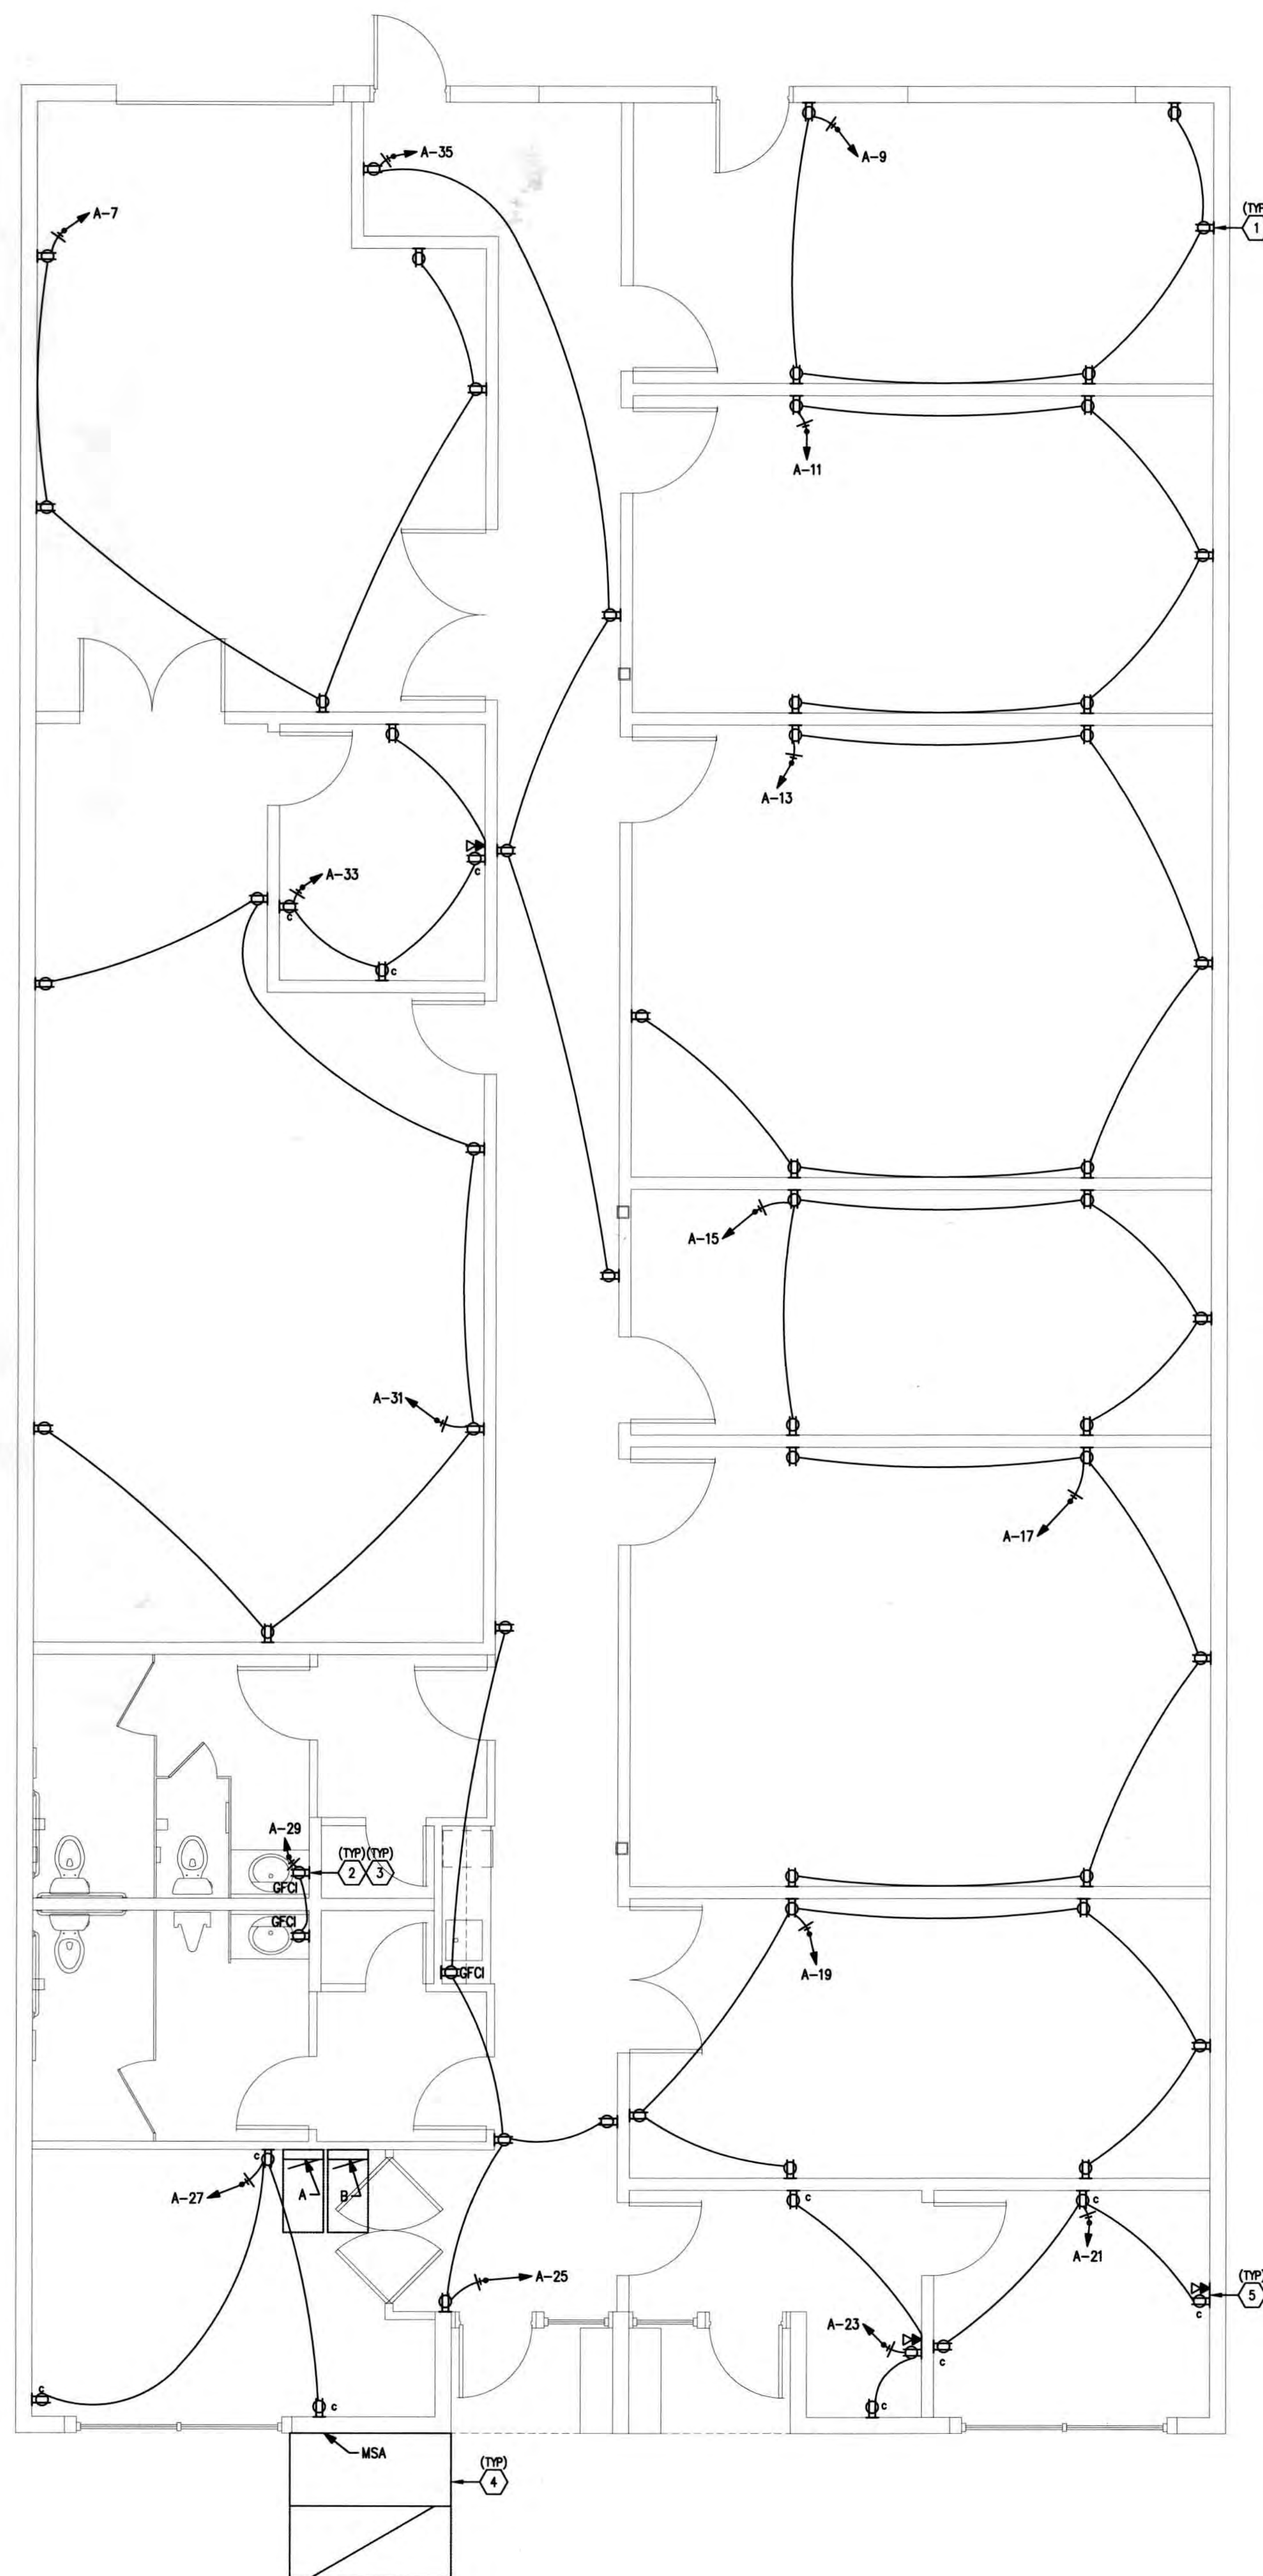

CALL-OUT NOTES


1. VERIFY POWER AND DATA RECEPTACLE MOUNTING HEIGHTS AND REQUIREMENTS WITH OWNER/ARCHITECT (TYP).
2. CONTRACTOR MUST INSTALL GFCI PROTECTION FOR ALL 15A AND 20A, 120V RECEPTACLES IN DAMP AND WET LOCATIONS PER NEC 210.8. (TYP)
3. RUN 1/2" C FROM DATA/PHONE RECEPTACLE UP TO CEILING SPACE, STUB WITH LABELED PULL STRING FOR FUTURE WIRING BY OTHERS. VERIFY ROUTING REQUIREMENTS PRIOR TO COMMENCEMENT OF WORK. (TYP)
4. CONTRACTOR TO VERIFY ALL NEW SERVICE EQUIPMENT INSTALLED MEETS ALL WORKSPACE REQUIREMENTS PER NEC SECTION 110.26. (TYP)
5. IN ALL BUILDINGS, BOTH CONTROLLED AND UNCONTROLLED 120 VOLT RECEPTACLES SHALL BE PROVIDED, WITHIN 6' OF ANY UNCONTROLLED RECEPTACLE, CONTRACTOR MUST INSTALL A CONTROLLED RECEPTACLE TO MEET THE CALIFORNIA ENERGY CODE REQUIREMENTS IN LOBBIES, OFFICE AREAS, OFFICE SPACES. CONNECT VIA LOW VOLTAGE LIGHTING CONTROL SYSTEM. CONTROLLED RECEPTACLE AREAS ARE NOTATED WITH THE LETTER "C".

POWER PLAN

SCALE: 1/4"=1'-0"

1/4"=1'-0"
Sheet Number
E1.2
Of Sheets

Project and Location
AMERICAN FLOWER LLC, T.I.
1667 COTA AVE
LONG BEACH, CA 90813

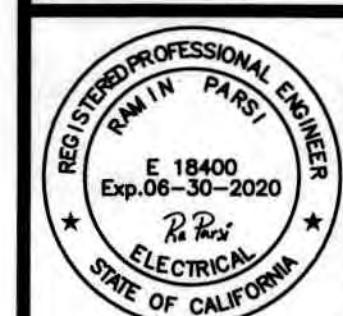

Drawn by: RP
Checked by:
Date: 06/18/20
Job No. 18-140

Title:
POWER PLAN

DMA
DAVE MADDEN ARCHITECT
Phone 951-684-2712 • E-Mail: dave@dmacollective.net
41197 Golden Gate Circle, Suite 109, Murrieta, Ca 92562

PROENGINEERING