


11	XXXX SCALE: XXXX	12	XXXX SCALE: XXXX	13	XXXX SCALE: XXXX	14	XXXX SCALE: XXXX	15	XXXX SCALE: XXXX
----	---------------------	----	---------------------	----	---------------------	----	---------------------	----	---------------------

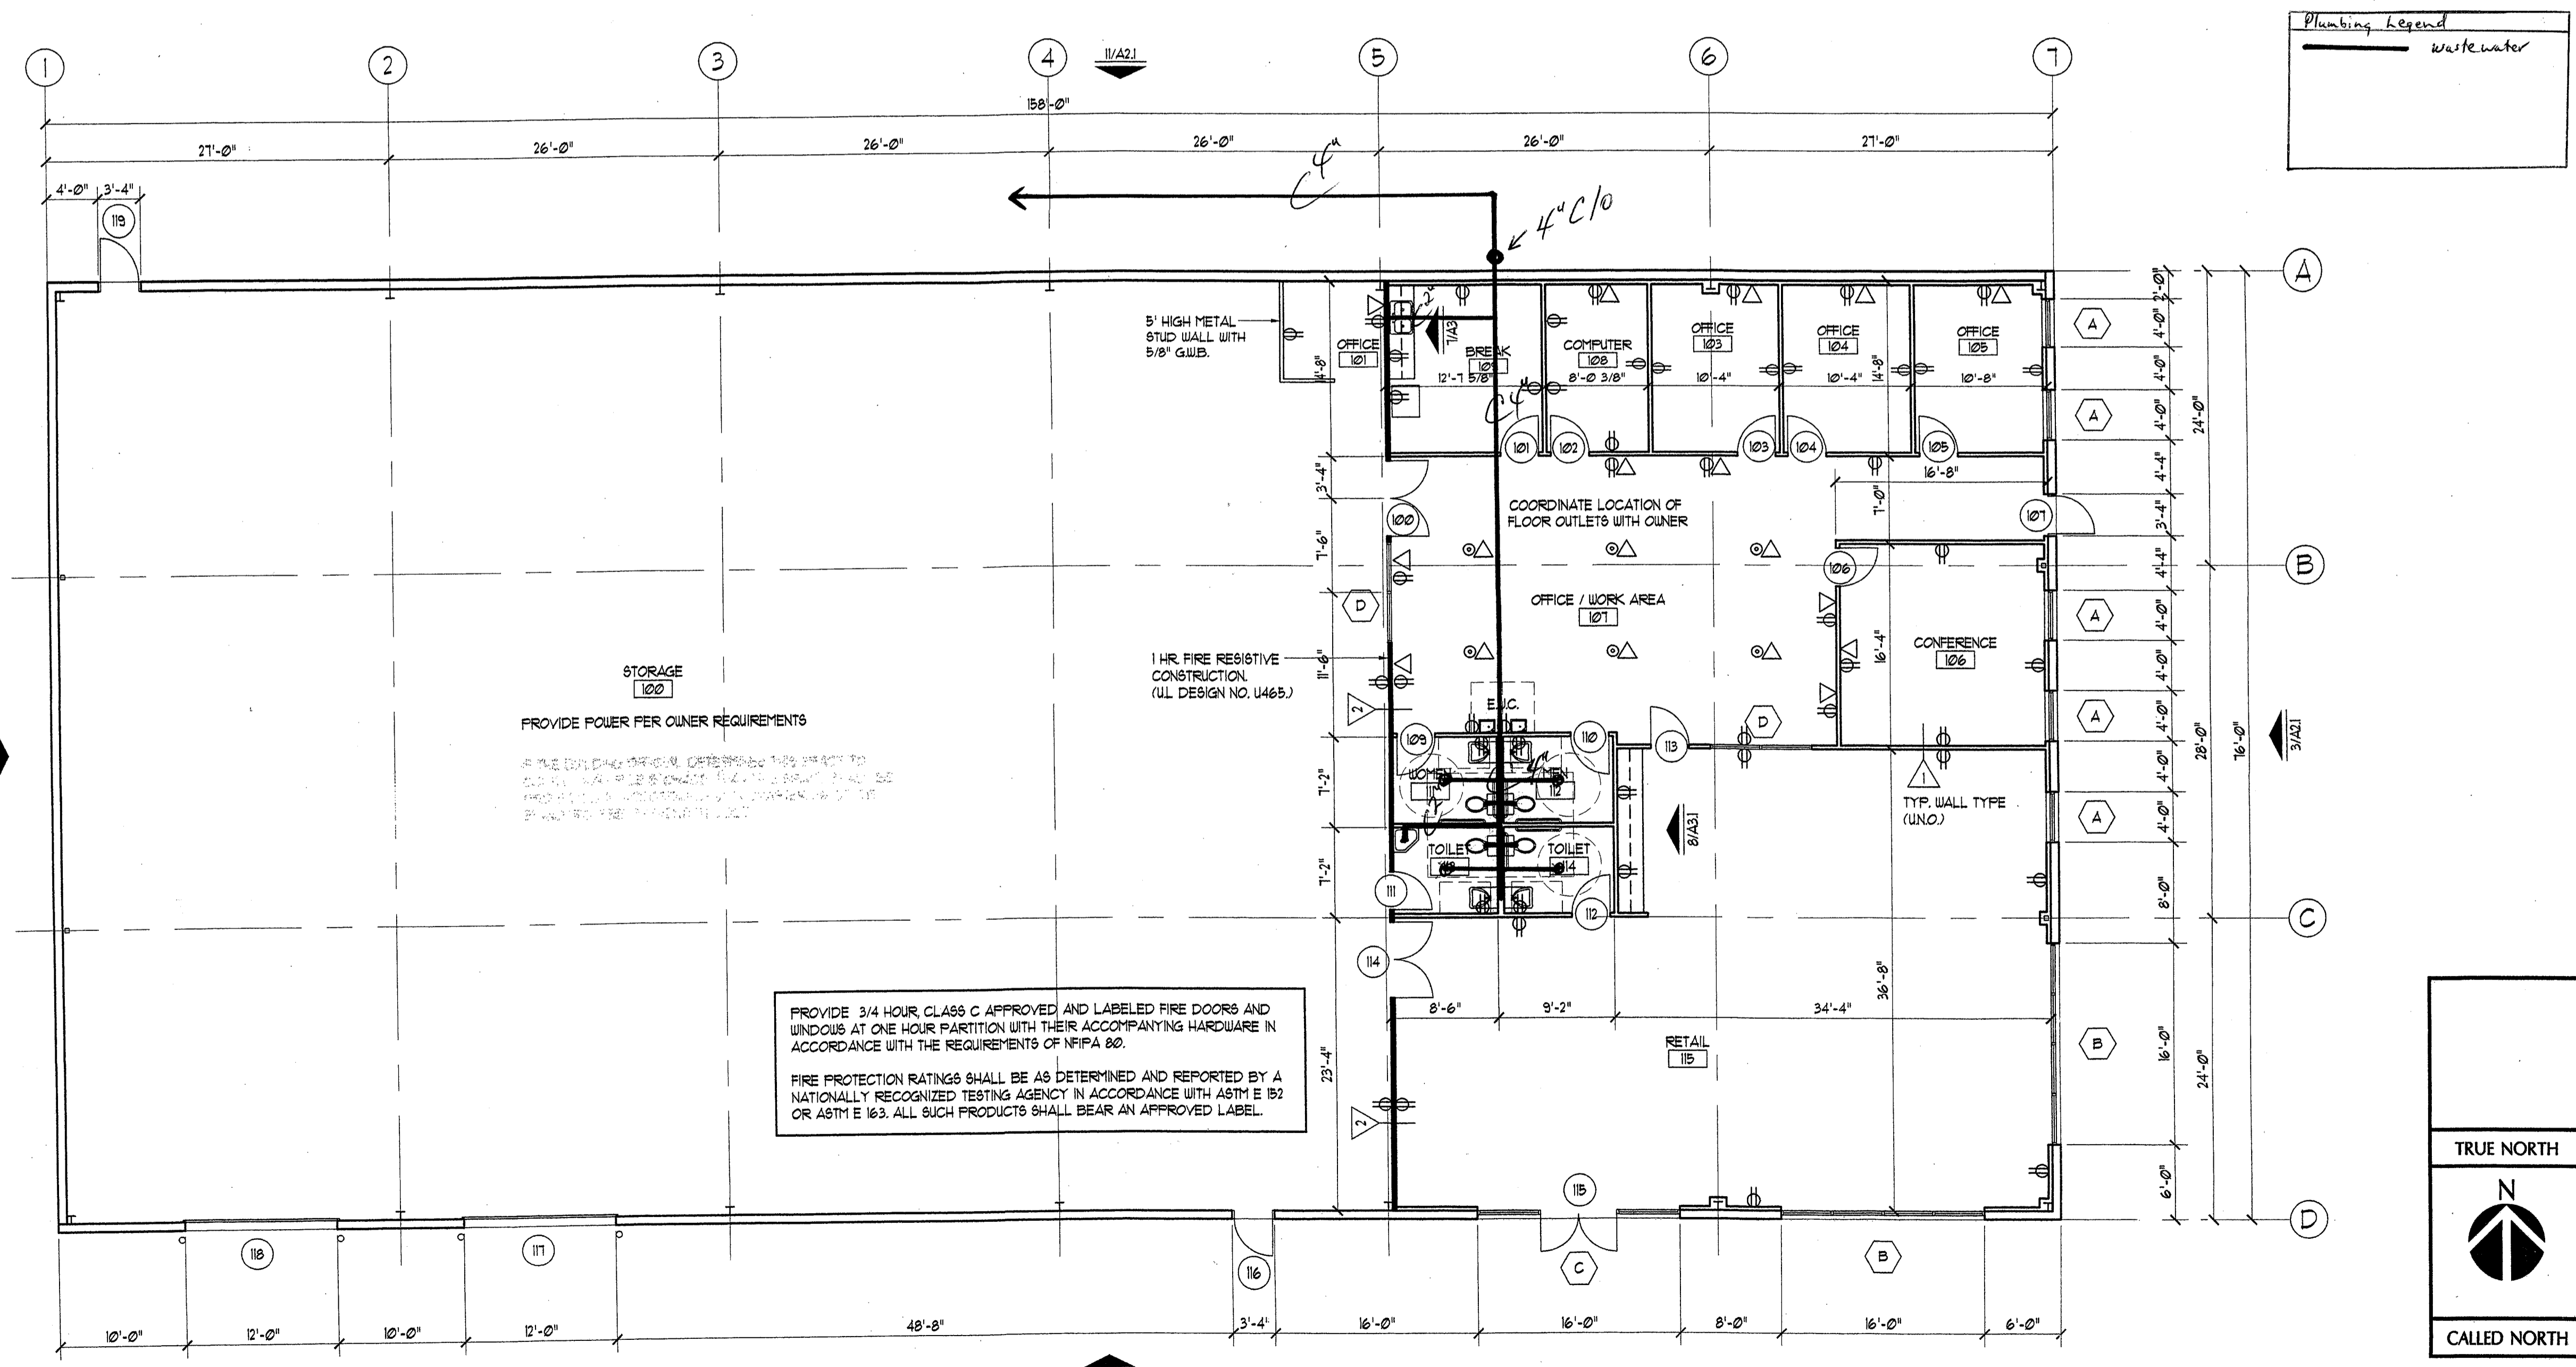


Plumbing Legend

	wastewater
--	------------

PROVIDE 3/4 HOUR, CLASS C APPROVED AND LABELED FIRE DOORS AND WINDOWS AT ONE HOUR PARTITION WITH THEIR ACCOMPANYING HARDWARE IN ACCORDANCE WITH THE REQUIREMENTS OF NFPA 80.
 FIRE PROTECTION RATINGS SHALL BE AS DETERMINED AND REPORTED BY A NATIONALLY RECOGNIZED TESTING AGENCY IN ACCORDANCE WITH ASTM E 162 OR ASTM E 163. ALL SUCH PRODUCTS SHALL BEAR AN APPROVED LABEL.

STORAGE 102
 PROVIDE POWER PER OWNER REQUIREMENTS

5' HIGH METAL STUD WALL WITH 5/8\" G.W.B.
 1 HR FIRE RESISTIVE CONSTRUCTION (UL DESIGN NO. U465)

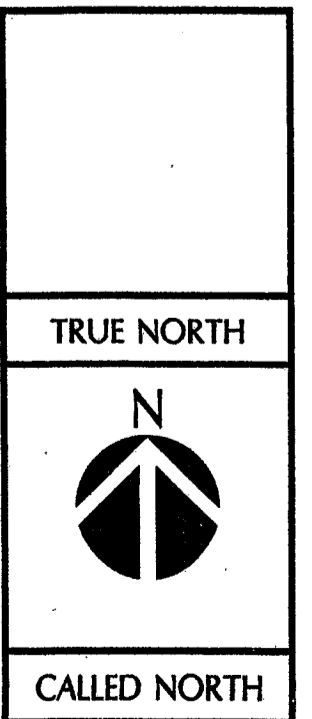

1 FLOOR PLAN
 SCALE 1/8" = 1'-0"


MAYATEX
 LOT 2, GEORGETOWN TECHNOLOGY PARK
 GEORGETOWN, TEXAS 78626



Date 03/05/99
 Revisions

FLOOR PLAN
 Plumbing
 Sheet No.

A1.1

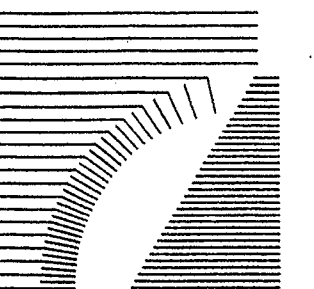


11 XXXX
SCALE XXXX

12 XXXX
SCALE XXXX

13 XXXX
SCALE XXXX

14 XXXX
SCALE XXXX


15 XXXX
SCALE XXXX

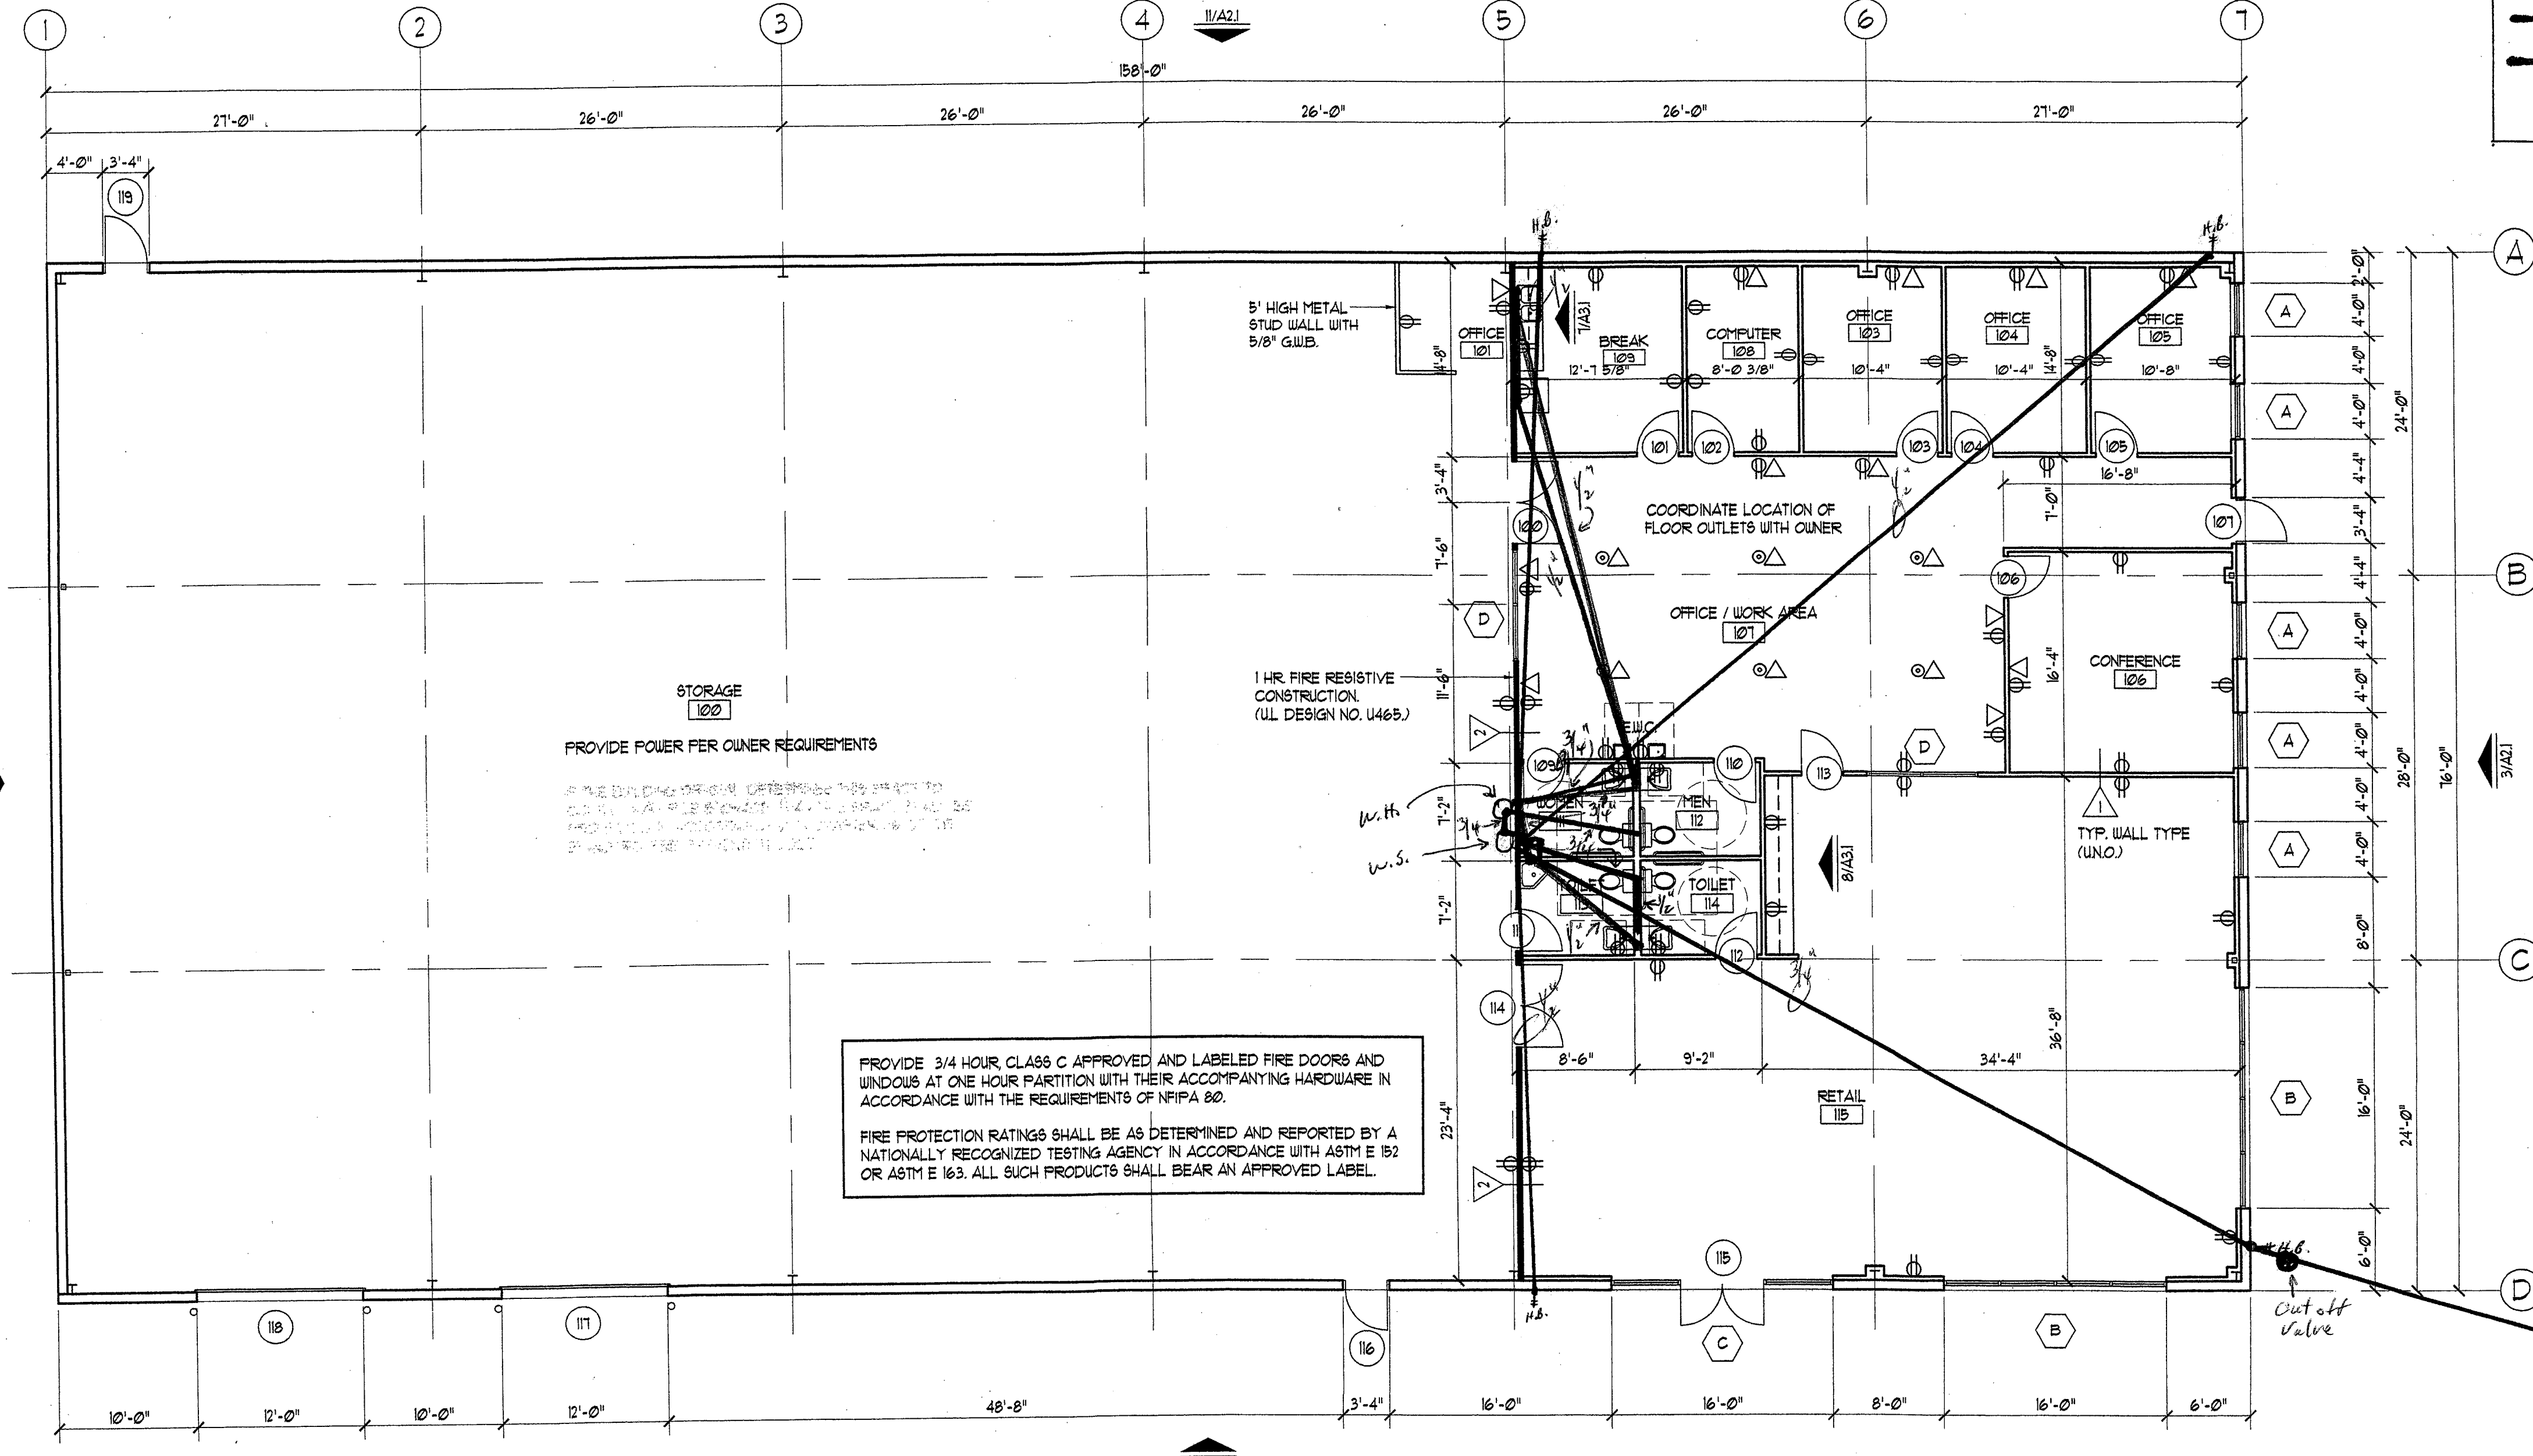

Plumbing Legend

— cold water

— hot water

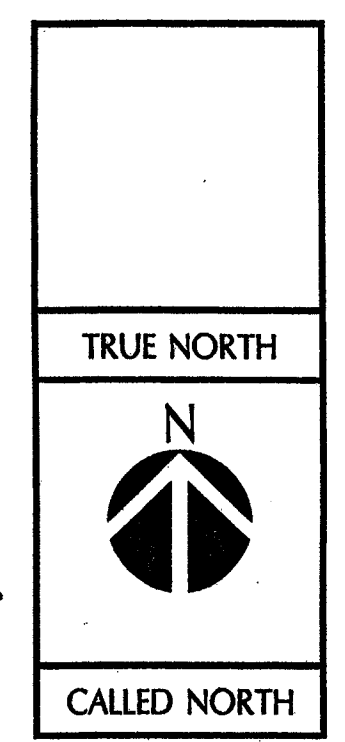

PROVIDE 3/4 HOUR CLASS C APPROVED AND LABELED FIRE DOORS AND WINDOWS AT ONE HOUR PARTITION WITH THEIR ACCOMPANYING HARDWARE IN ACCORDANCE WITH THE REQUIREMENTS OF NFPA 80.

FIRE PROTECTION RATINGS SHALL BE AS DETERMINED AND REPORTED BY A NATIONALLY RECOGNIZED TESTING AGENCY IN ACCORDANCE WITH ASTM E 152 OR ASTM E 163. ALL SUCH PRODUCTS SHALL BEAR AN APPROVED LABEL.

STORAGE 100

PROVIDE POWER PER OWNER REQUIREMENTS

5' HIGH METAL STUD WALL WITH 5/8" G.W.B.

1 HR FIRE RESISTIVE CONSTRUCTION (UL DESIGN NO. U465)

RETAIL 107

TYP. WALL TYPE (U.N.O.)

Out off Valve

1 FLOOR PLAN
SCALE 1/8" = 1' - 0"

MAYATEX
LOT 2, GEORGETOWN TECHNOLOGY PARK
GEORGETOWN, TEXAS 78626




Date 03/05/99
Revisions

FLOOR PLAN
Plumbing
water
Sheet No.


A1.1

11	XXXX SCALE XXXX	12	XXXX SCALE XXXX	13	XXXX SCALE XXXX	14	XXXX SCALE XXXX	15	XXXX SCALE XXXX
----	--------------------	----	--------------------	----	--------------------	----	--------------------	----	--------------------

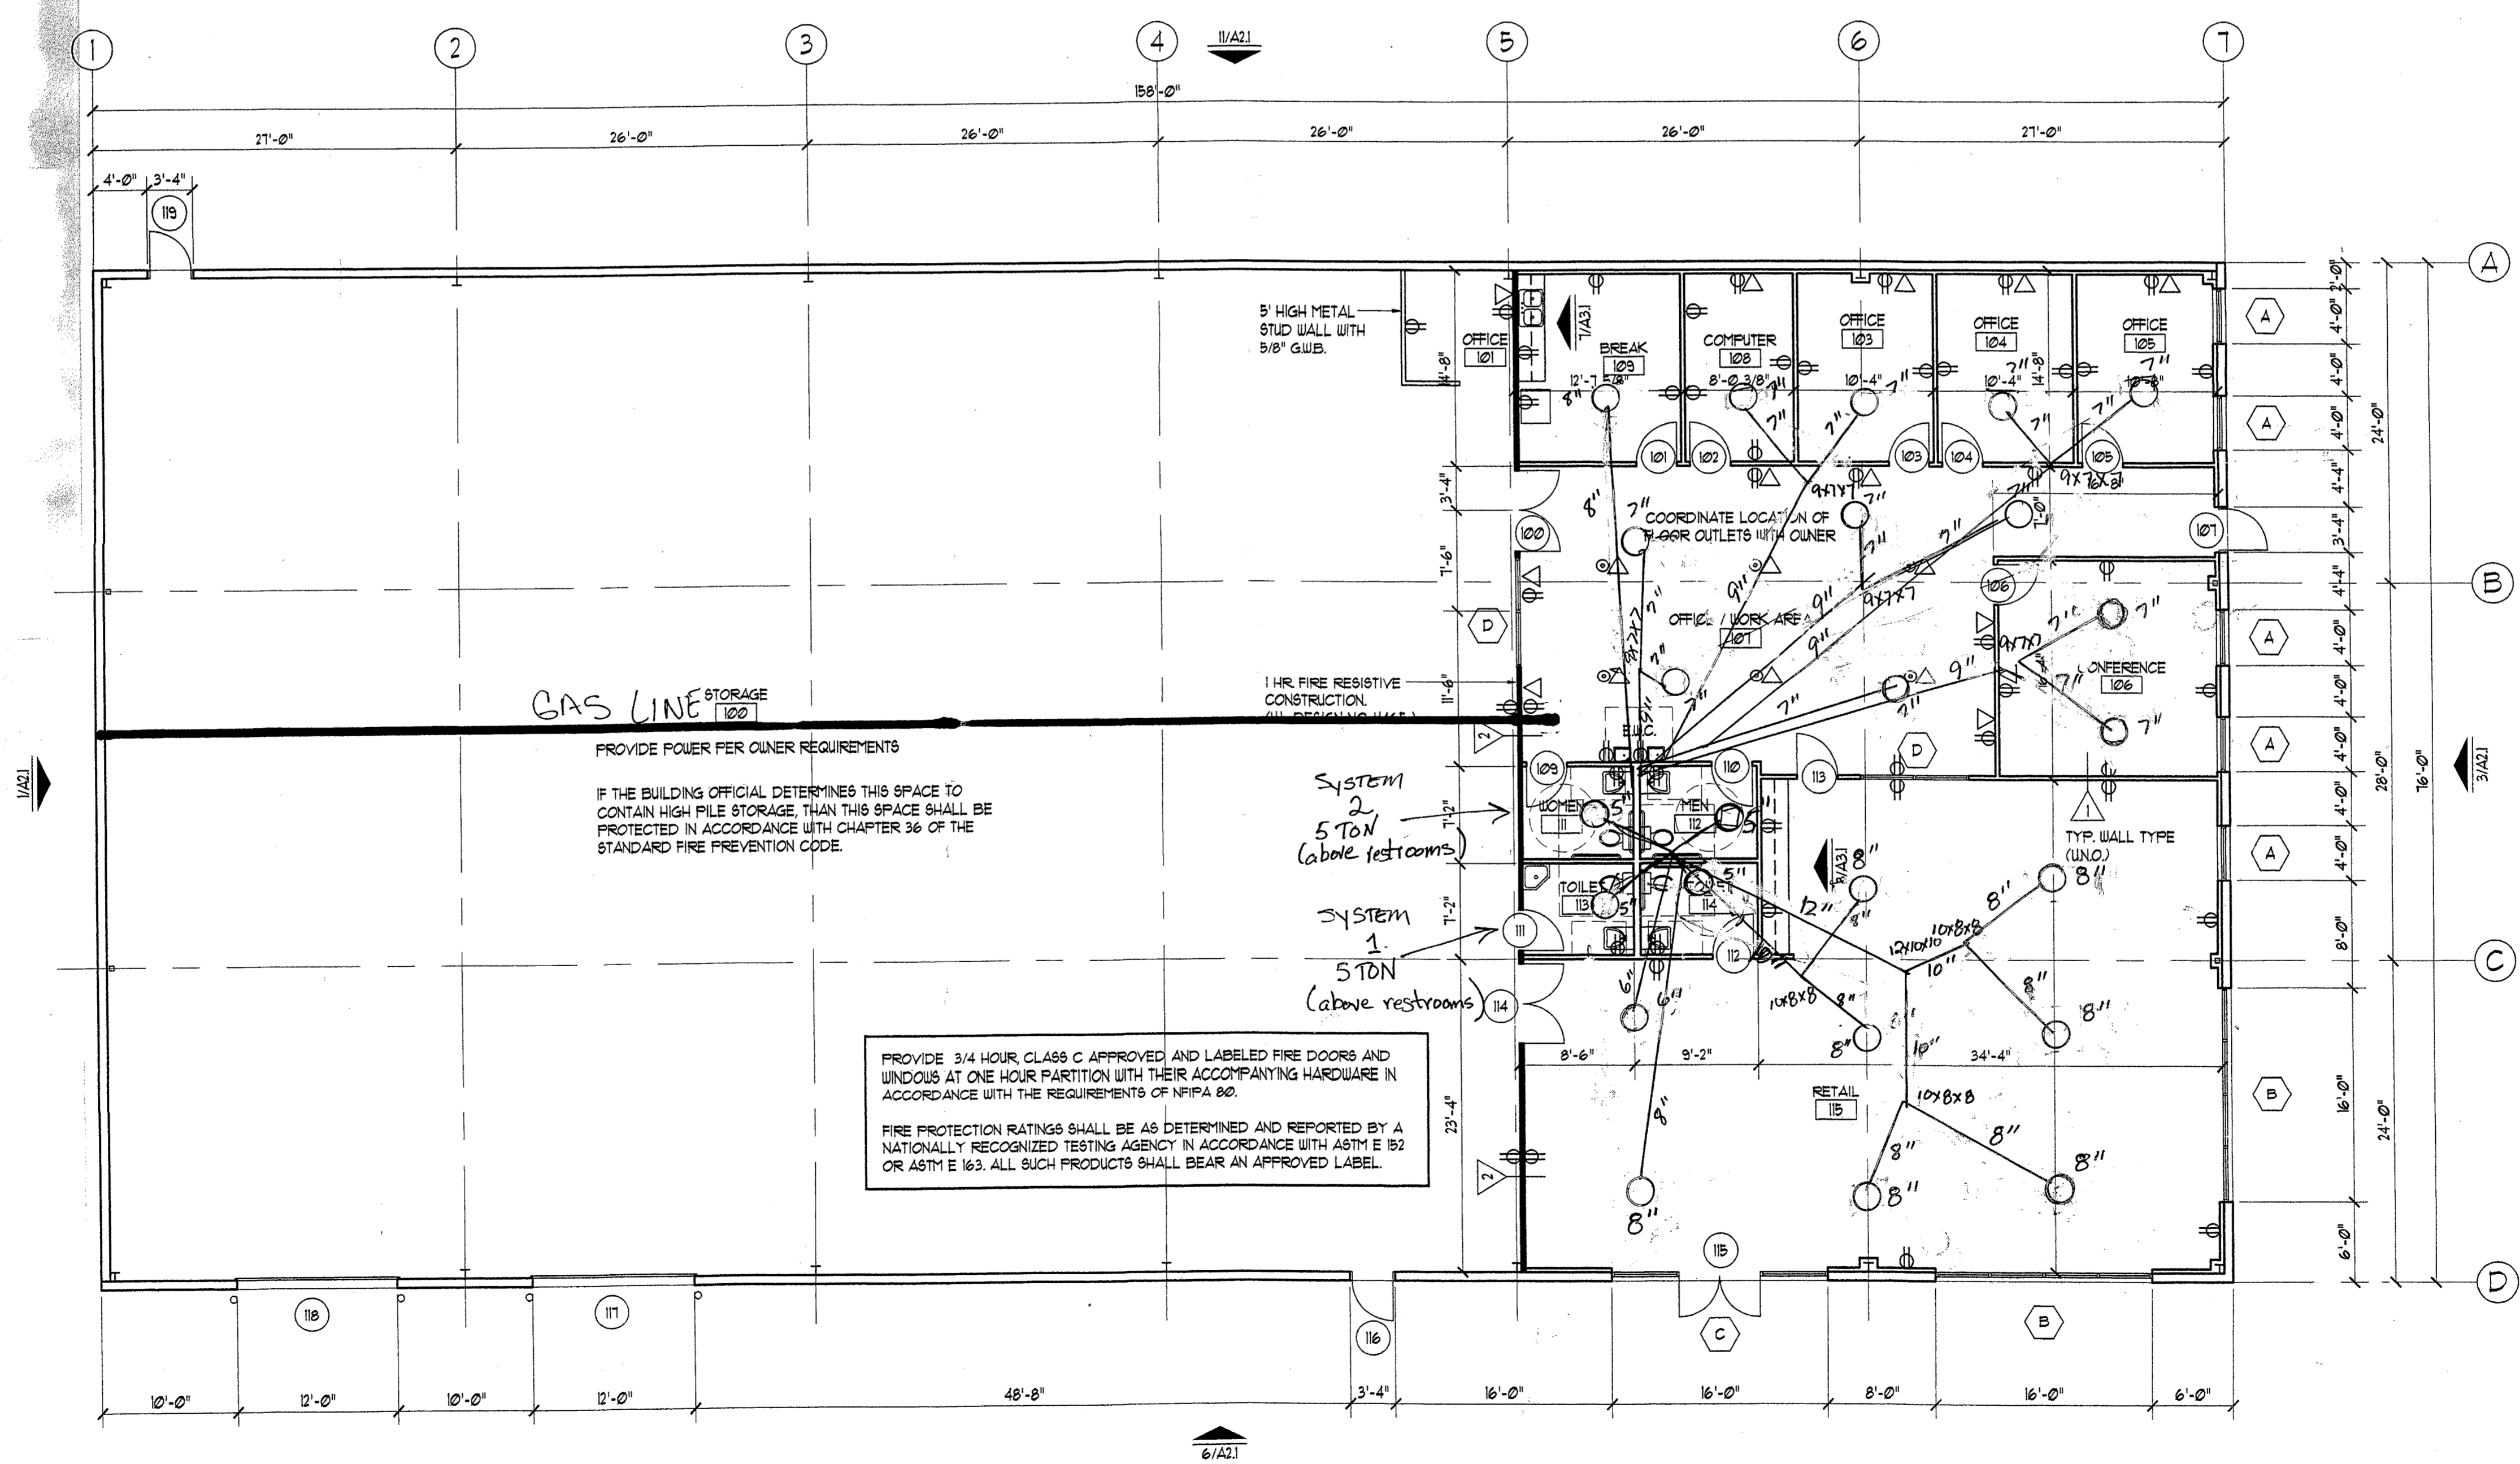


GAS LINE STORAGE
 PROVIDE POWER PER OWNER REQUIREMENTS
 IF THE BUILDING OFFICIAL DETERMINES THIS SPACE TO CONTAIN HIGH PILE STORAGE, THAN THIS SPACE SHALL BE PROTECTED IN ACCORDANCE WITH CHAPTER 36 OF THE STANDARD FIRE PREVENTION CODE.

PROVIDE 3/4 HOUR CLASS C APPROVED AND LABELED FIRE DOORS AND WINDOWS AT ONE HOUR PARTITION WITH THEIR ACCOMPANYING HARDWARE IN ACCORDANCE WITH THE REQUIREMENTS OF NFPA 80.
 FIRE PROTECTION RATINGS SHALL BE AS DETERMINED AND REPORTED BY A NATIONALLY RECOGNIZED TESTING AGENCY IN ACCORDANCE WITH ASTM E 82 OR ASTM E 163. ALL SUCH PRODUCTS SHALL BEAR AN APPROVED LABEL.

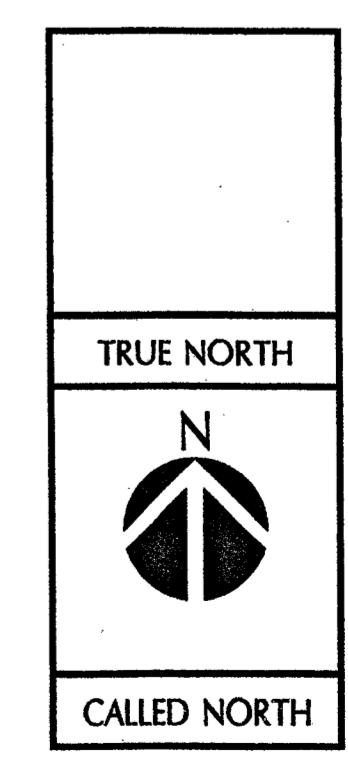

MAYATEX
 LOT 2, GEORGETOWN TECHNOLOGY PARK
 GEORGETOWN, TEXAS 78626

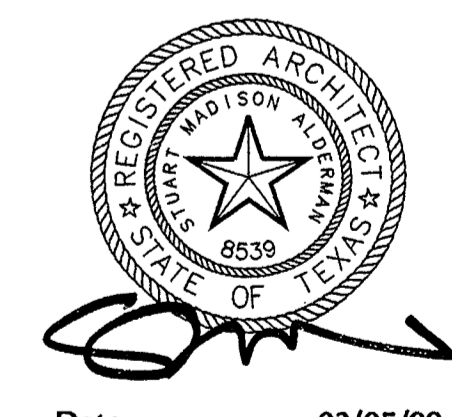

Date 03/05/99
 Revisions

FLOOR PLAN
 HVAC
 Sheet No. **A1.1**