





SITE EVALUATORS LLC
6136 FRISCO SQUARE BLVD.
SUITE 400
FRISCO, TX 75034
214-705-8555

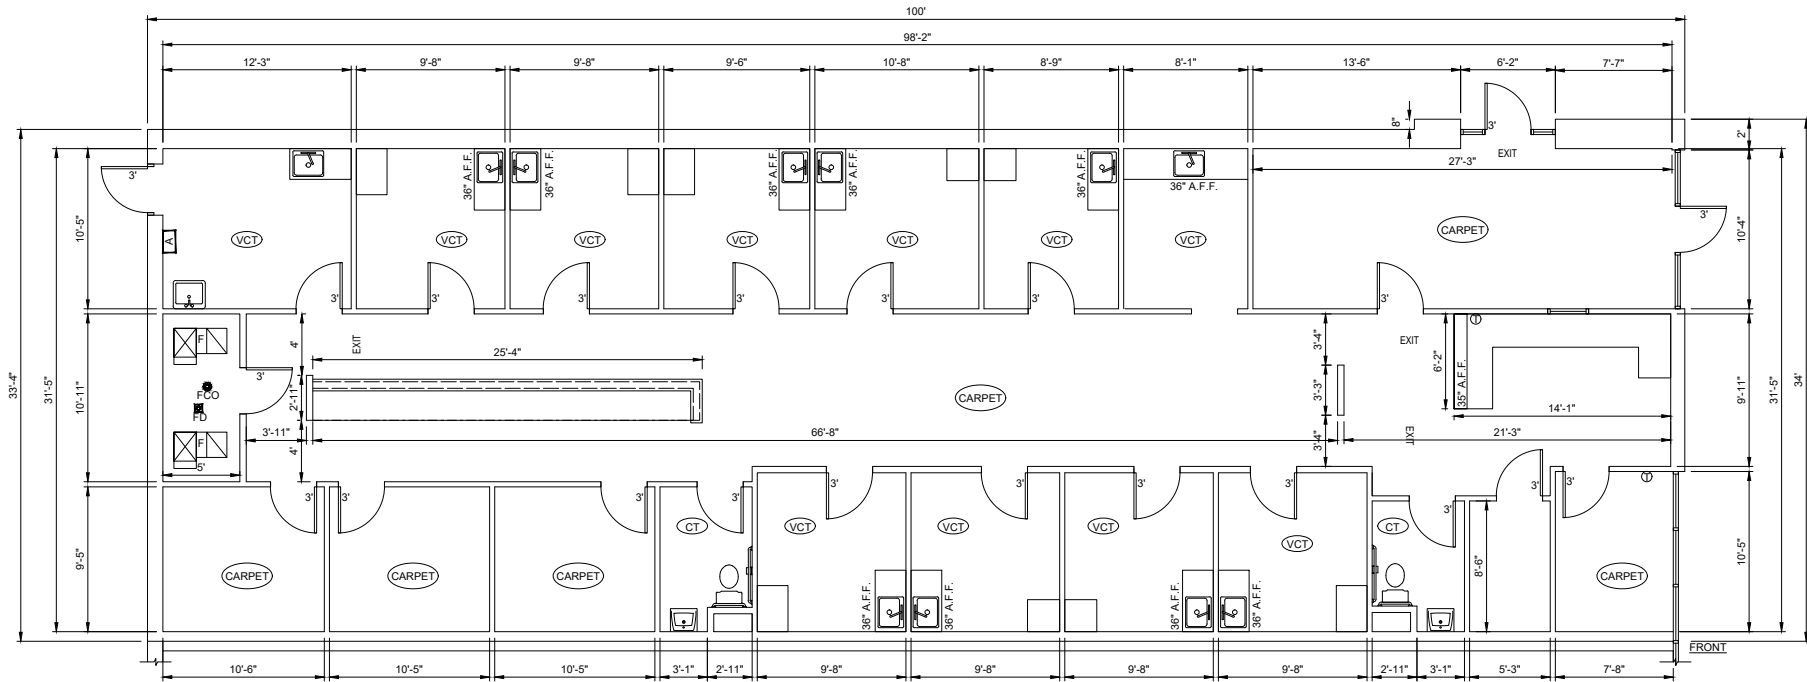

FLOOR PLAN
N.T.S.

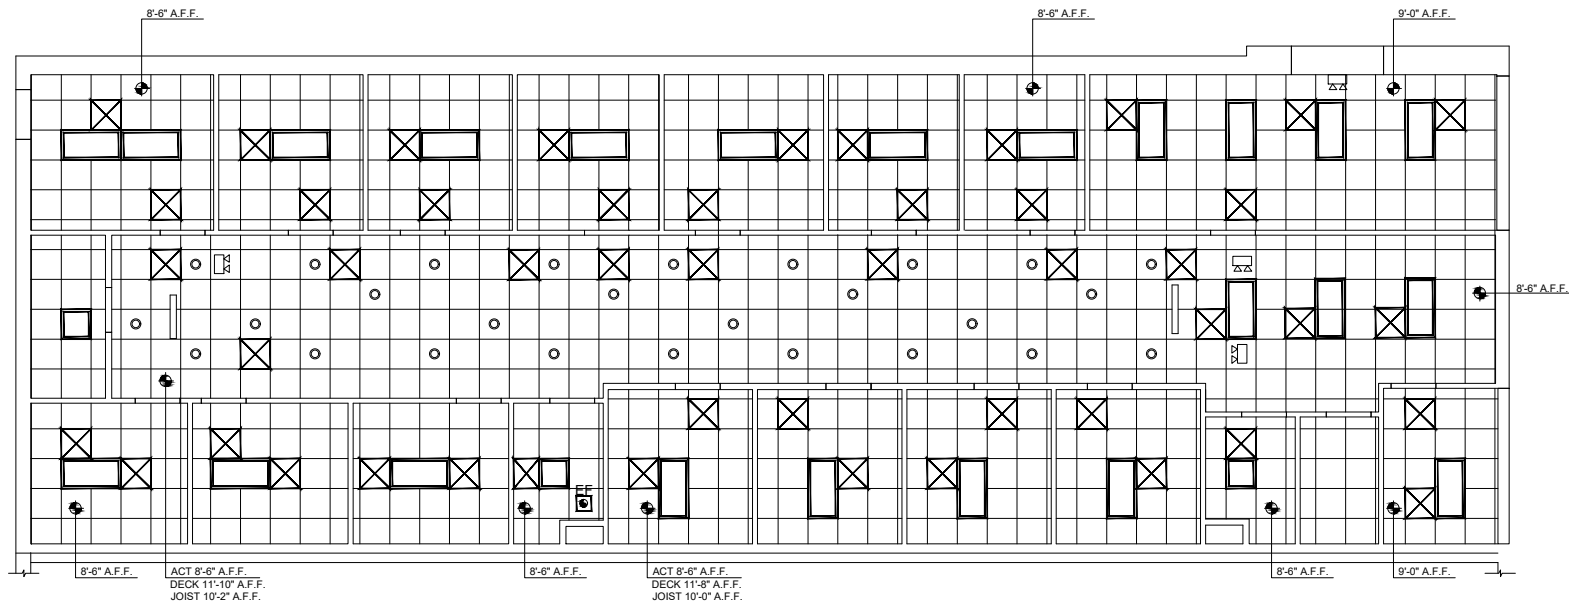

REFLECTED CEILING PLAN
N.T.S.

LEGEND

- A = 400 AMP, 208Y/120V
- ⊕ THERMOSTAT
- ⊗ AIR SUPPLY DIFFUSOR
- ⊘ AIR RETURN DIFFUSOR
- 2x2 LAY-IN LIGHT FIXTURE
- ▭ 2x4 LAY-IN LIGHT FIXTURE
- EF EXHAUST FAN
- RECESSED CAN LIGHT FIXTURE

LEASEABLE S.F. = 3,400 SF

LEVCOR

230 W 19TH STREET,
HOUSTON, TX 77008

THIS IS NOT A WORKING
DRAWING.
DO NOT USE FOR
CONSTRUCTION.
ALL DIMENSIONS ARE
SUGGESTED AND ARE TO BE
VERIFIED BY THE
CONTRACTOR.

DRAWN BY: I.S.
NOT TO SCALE
DATE: 09-22-24