
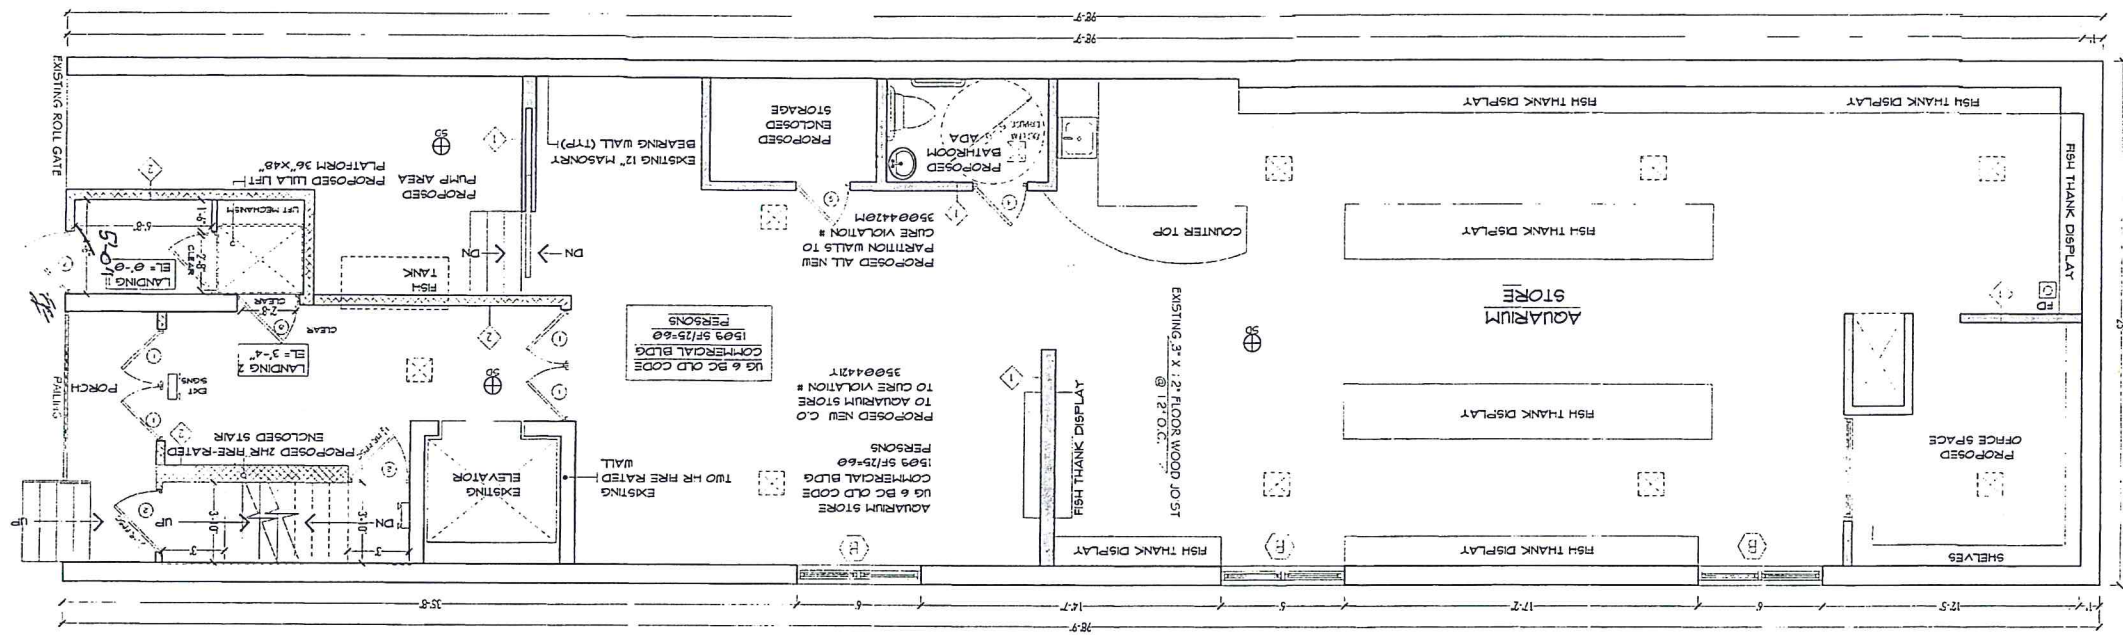


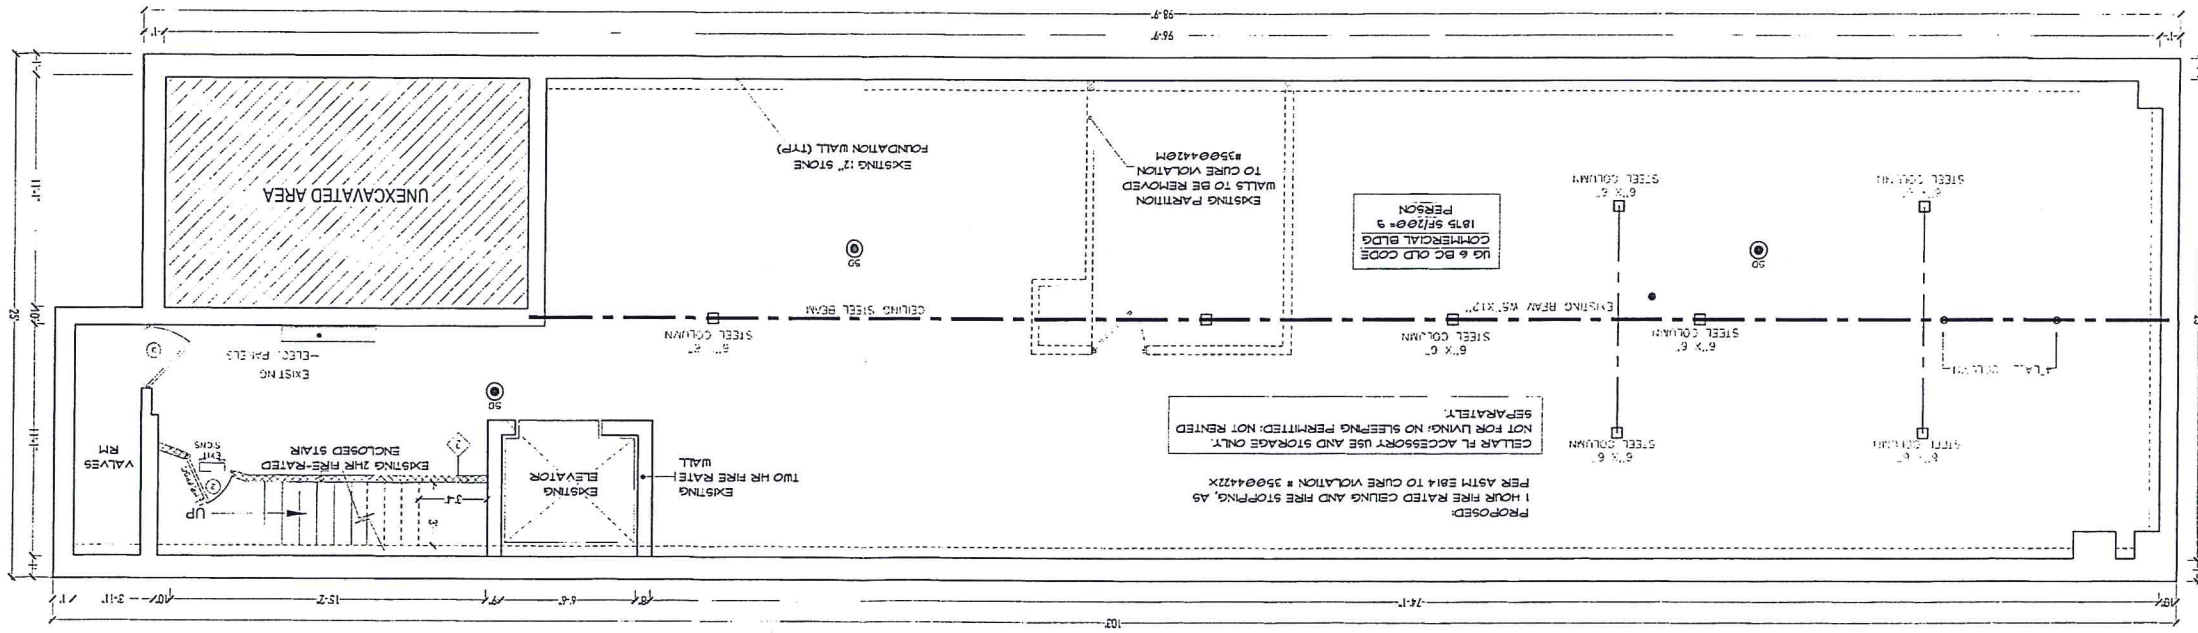

DOOR SCHEDULE						
LOCATION	DIMENSIONS	MATERIAL	TYPE	QTY	U FACTOR	REMARK
ENTRANCE	2'-8" x 6'-0"	GLASS	SWING	4	0.50	
STAIR/ HALL WAY	2'-8" x 6'-0"	H.MTL.	SWING	6		1 1/2 HR RATED FPSC
H.C.BATHROOM	2'-8" x 6'-0"	WOOD	SWING	14		
HALL WAY	3'-0" x 6'-0"	WOOD	SWING	4		
CLOSET	2'-8" x 6'-0"	WOOD	SWING	2		
BATHROOM	2'-6" x 6'-0"	WOOD	SWING	6		
UFT LANDING 1	3'-0" x 6'-0"	GLASS	SWING	1	0.50	
UFT LANDING 2	3'-0" x 6'-0"	GLASS	SWING	1	0.50	

WINDOW SCHEDULE						
FIRE RATED	DIMENSIONS	MATERIAL	TYPE	QTY	U FACTOR	SHGC
7. PROPOSED	(3'x6') MATCH EX. OPNG		DOUBLE HUNG	16	0.35	0.7
8. PROPOSED	(7'2'x6') MATCH EX. OPNG		FIXED	4	0.35	0.7
9. PROPOSED	(3'x6') MATCH EX. OPNG		FIXED	2	0.35	0.7

ENGINEER FRANCISCO D. PEREZ	1503 91ST STREET NORTH BEGON, NJ 07047 Telephone: 201-758-2882 EMail: fperezq1@optonline.net	OWNER: RUDOLF SAMANDAROV
SCOPE OF WORK: FILED TO LEGALIZE BUILDINGS CONDITIONS CHANGE USE AND OBTAIN A NEW CERTIFICATE OF OCCUPANCY TO RESOLVE ECB VIOLATIONS 35004420M, 35004421Y, 35004422X & 35004423H. REVIEW UNDER PRIOR. TO: 1966 CODE IN REQUESTED. REVIEW UNDER 2008 CODE WAS REQUESTED IN ERROR.	Address: 522 WEST 37TH STREET NEW YORK NY, DRAWING TITLE: CELLAR CONDITIONS AND 1ST FL	

61-21-1

SEAL & SIGNATURE:

A circular professional engineer seal for the State of New York. The outer ring contains the text "STATE OF NEW YORK" at the top and "PROFESSIONAL ENGINEER" at the bottom. The inner circle features a central emblem of a figure holding a torch and a scroll, with the number "083397" above it. A signature, "Robert J. Berman", is written across the seal.

DATE:	01/19/14
PROJECT NO:	
DRAWING NO:	EB
CHK BY:	FP
DRAWN NO:	A-101.00
CADD FILE NO:	2 OF 4

[illegible]


11.11

102

29

11.11

[illegible]

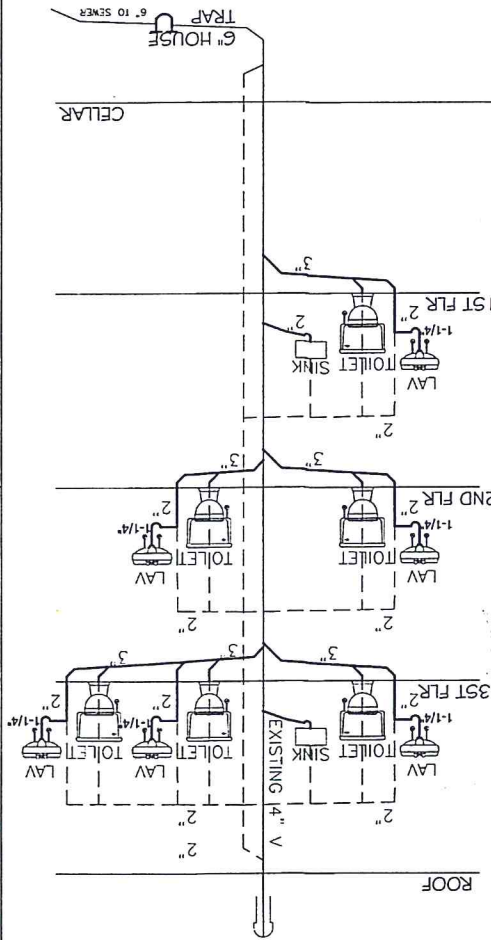


PROPOSED PLUMBING RISER

NTS


SECOND FLOOR PLAN

1/8"=1'-0"

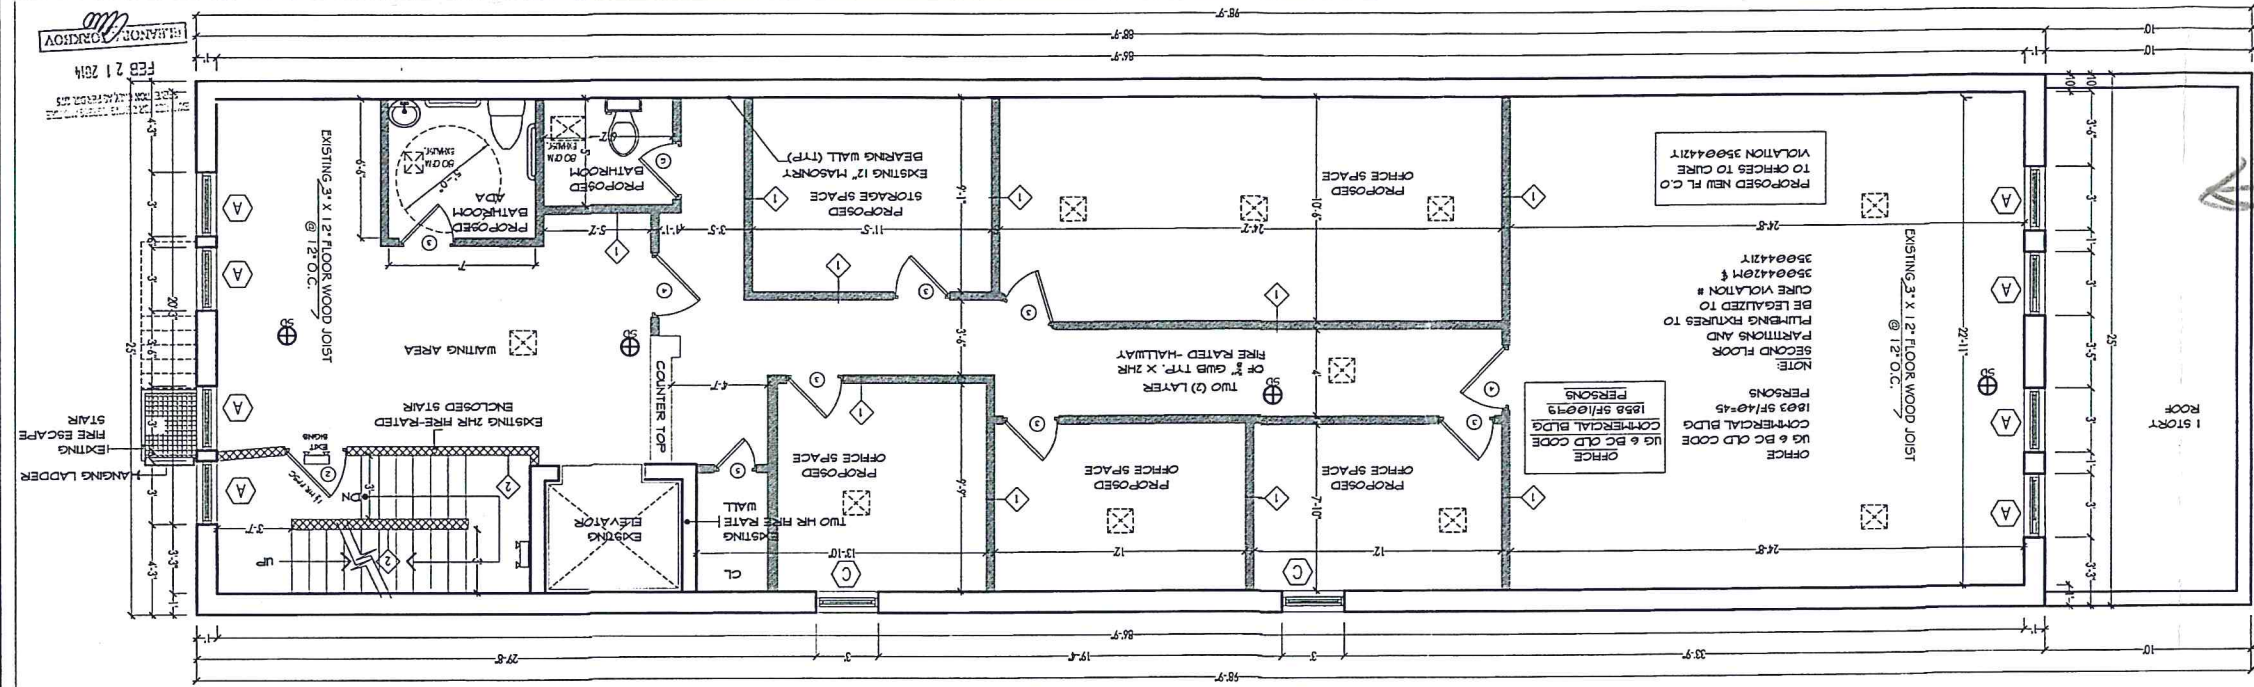

THIRD FLOOR PLAN

1/8"=1'-0"

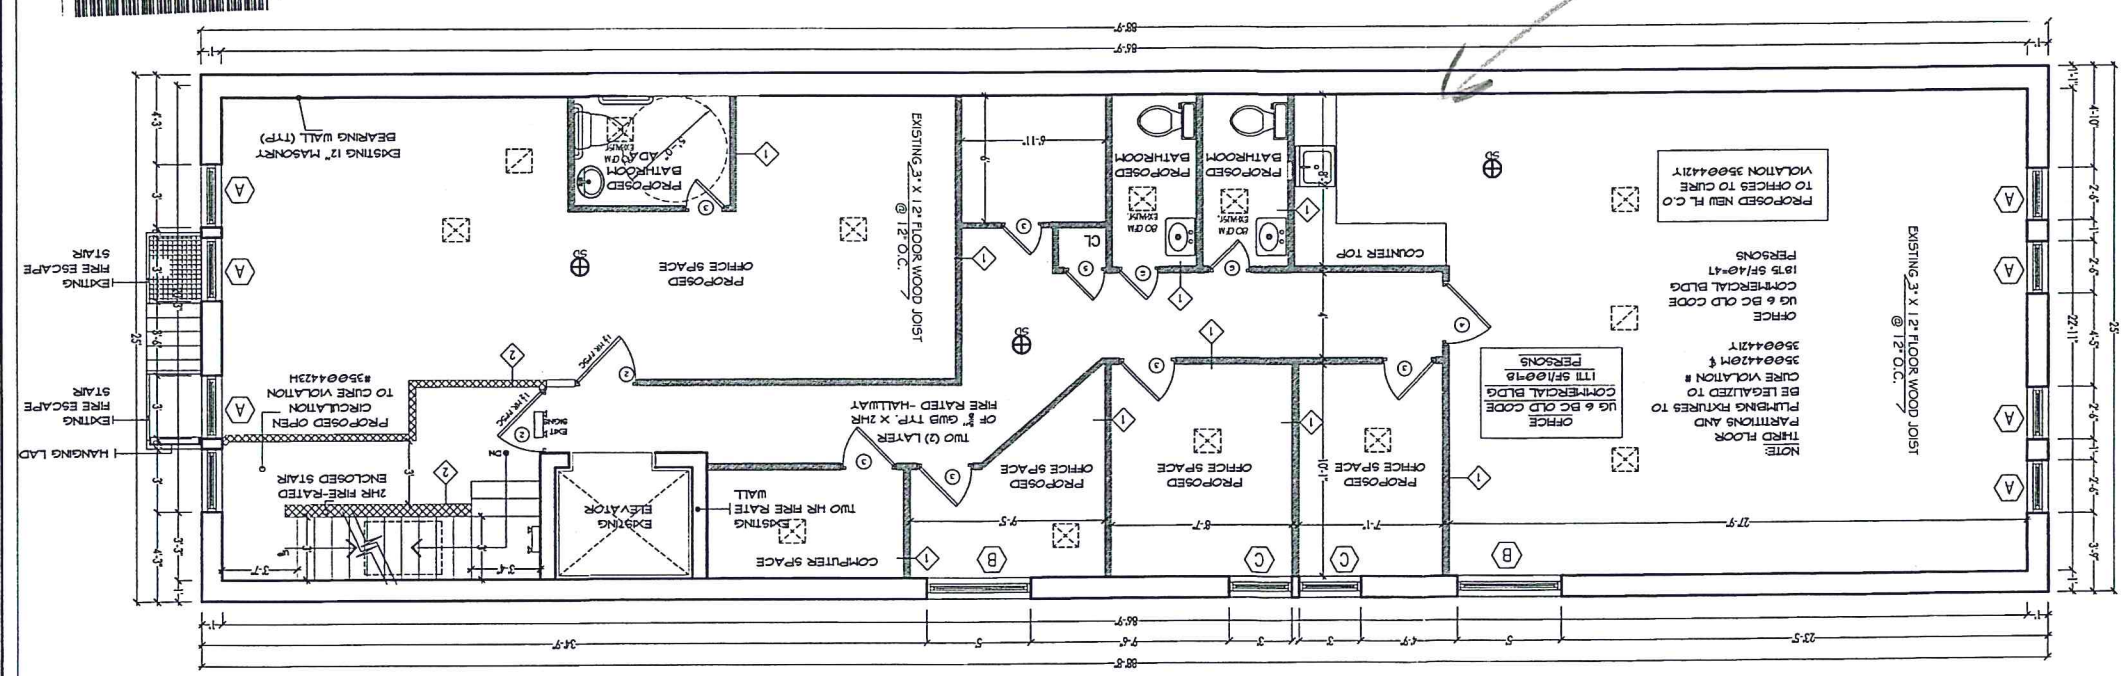

ENGINEER: FRANCISCO D. PEREZ 1503 91ST STREET NORTH BEGEN, NJ 07047 Telephone: 201-758-2882 E-MAIL: fperezq1@optonline.net		OWNER: RUDOLF SAMANDAROV Address: 522 WEST 37TH STREET NEW YORK, NY. Drawing Title: PROPOSED 3rd FL, 2ND FL PLAN AND PLUMBING RISER	
SCOPE OF WORK: A NEW CERTIFICATE OF OCCUPANCY TO RESOLVE ECB VIOLATIONS UNDER PRIOR TO 1968 CODE IS REQUESTED. REVIEW UNDER 2008 CODE WAS REQUESTED IN ERROR.		DATE: 01/19/14	
PROJECT NO: A-102.00		DRAWING NO: EB	
CHK BY: FP		CADD FILE NO: 3 OF 4	

DATE OF NEW YORK CITY OF NEW YORK
Pursuant to PL 84-186, this certification will serve to authenticate this document as a true and correct copy of a record of the Department of Buildings. This record was made in the regular course of business of the Department of Buildings. It is the regular practice of the Department to make records of this type, and the record was made on the same date and at the same time of occurrence of the events recorded.

Designated Certifying Officer

