



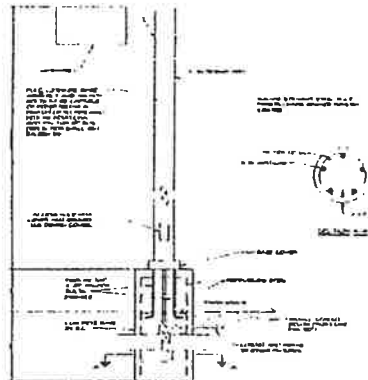

① Light Standard Detail
Not To Scale

SITE DATA	
TOTAL BLDG AREA	
TOTAL BLDG AREA	15,000 S.F.
PARKING SPACES	
TOTAL PARKING REQ'D	50 SPACES
TOTAL PARKING PROVIDED	54 SPACES

LIGHTING SCHEDULE			
LEVEL	LIGHT	MOUNTING	NOTES
A	60W METAL HALIDE	PRE-MOUNTED	w/ SHIELDS CO REQ'D TO REDUCE FC TO 2 FPM
B	175W METAL HALIDE	POLL	w/ SHIELDS (HOUSE SIDE) TO REDUCE BLARE & FC TO 1 FPM @ PROPERTY LINES

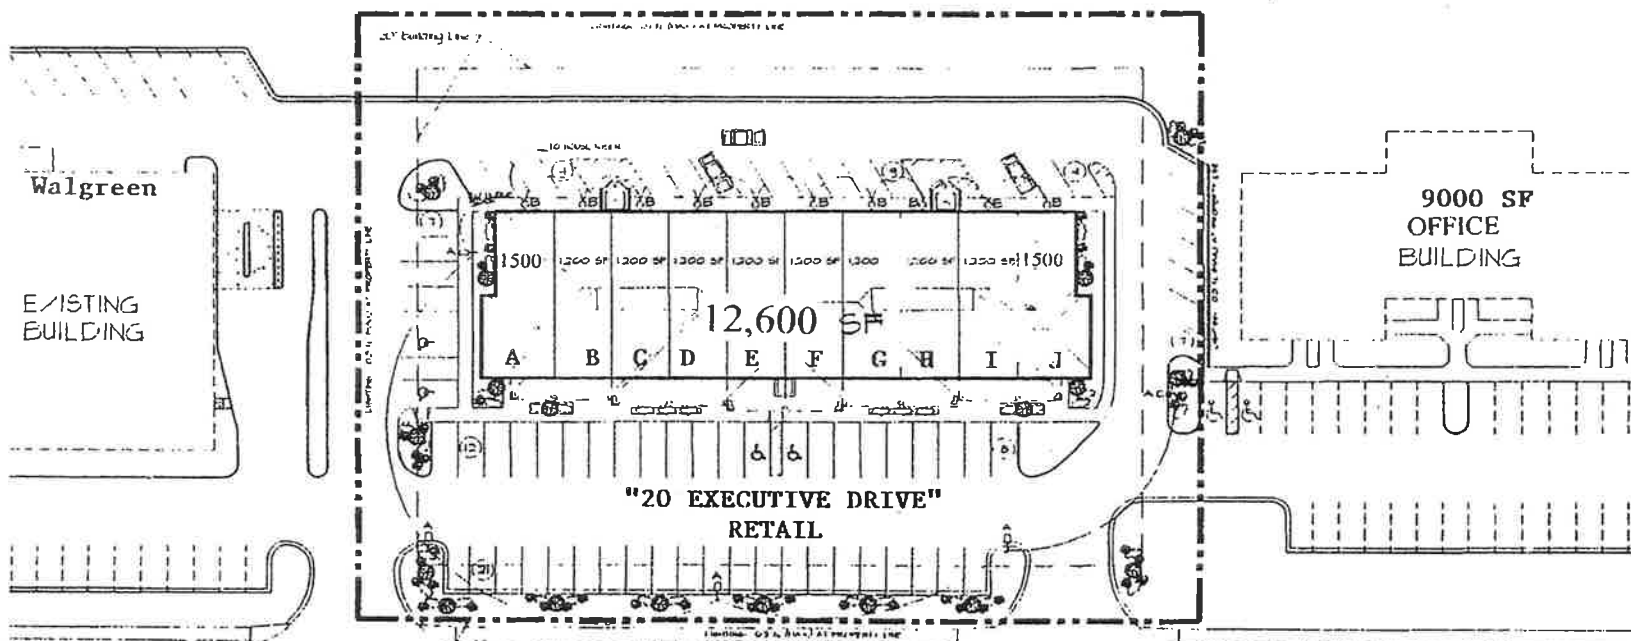

 SITE LIGHTING PLAN
SCALE: 1" = 20'-0"



DATE	REVISION	BY	CHKD
02/14/07	1	DAVID GREEN	DAVID GREEN
02/14/07	2	DAVID GREEN	DAVID GREEN
02/14/07	3	DAVID GREEN	DAVID GREEN
02/14/07	4	DAVID GREEN	DAVID GREEN
02/14/07	5	DAVID GREEN	DAVID GREEN
02/14/07	6	DAVID GREEN	DAVID GREEN
02/14/07	7	DAVID GREEN	DAVID GREEN
02/14/07	8	DAVID GREEN	DAVID GREEN
02/14/07	9	DAVID GREEN	DAVID GREEN
02/14/07	10	DAVID GREEN	DAVID GREEN

Carmel Centerpointe Suites
Building #3
CARMEL, INDIANA
developed by
Executive Concepts, Inc.

