



PLUMBING FIXTURE SCHEDULE			SPECIFICATIONS	
NO.	FIXTURE	SOIL OR WASTE	VENT	REMARKS
P-1	WATER CLOSET	4"	2"	1 1/2" KOHLER "DOWNING" K-4262-ETA WITH A WHITE SEAT
P-2	WATER CLOSET	4"	2"	1 1/2" KOHLER "HIGHCLIFF" K-4268-ETA WITH A WHITE SEAT
P-3	URINAL	2"	1 1/2"	3/4" KOHLER "BARDON" K-4980-TA & J.R. SMITH # 637 CARRIER
P-3A	LAVATORY	1 1/4"	1 1/4"	1/2" KOHLER "GREENWICH" K-2022 - SIZE 20"X18" - SUPP. & DRAIN K-7401-T-2GM - SUPP. PIPES K-7607-3/8" - TRAP K-9000-1/2" - CARRIER-SMITH # 700
P-3B	LAVATORY	1 1/4"	1 1/4"	1/2" KOHLER "SELF-RIMMING PENNINGTON" K-2195 - TRIM SAME AS P-3 ABOVE
P-4	SERVICE SINK	1 1/4"	1 1/4"	1/2" KOHLER "ROCKPORT" K-1680-B - SUPP. & DRAIN K-8040-T-2GM - SUPP. PIPES K-7607-3/8" - TRAP K-9000-1/2" - CARRIER-SMITH # 814
P-4A	SERVICE SINK	3"	2"	3/4" KOHLER "WHITBY" K-6710-A
P-5	WATER COOLER	3"	3"	3/4" KOHLER "SUBBURY" K-6650 - SUPP. K-8906 - TRAP K-6673 - RIM GUARD K-8934 - 12" LONG
P-6	SHOWER	2"	2"	1/2" OASIS #ODP7M - P.C. SHALL PROVIDE STOP VALVE ON C.W. - TRAP K-9000-1/2" - 8 MAKE ALL FINAL CONN.
P-6A	SHOWER EMERG.	1 1/2"	1 1/2"	1/2" POWERS-FIAT "COMMANDER" #5-101 - HEAD & SUPP. POWERS SERIES 411-10-66
P-11	FLOOR DRAIN	3"	3"	1/2" SPEAKMAN SE-614 P.C. SHALL PROVIDE STOP VALVE ON C.W.
P-11A	FLOOR DRAIN	3"	3"	3/4" GSR FUSEAL # 7750
P-11B	FLOOR DRAIN	3"	3"	3/4" J.R. SMITH 2010A WITH A 7" STRAINER
P-13	WALL HYDRANT	3"	3"	3/4" J.R. SMITH FIG. 3750
P-14	CLEANOUT	FULL SIZE	-	3/4" J.R. SMITH FIG. 5609
P-15	SHOCK ABSORBER	-	-	3/4" J.R. SMITH - WALL FIG. 4472 - FLOOR FIG. 4023 - OUTSIDE 4243
P-16	OVERFLOW DRAIN	4"	-	3/4" J.R. SMITH SERIES 5000 SIZE AS RECOMMENDED BY MFG.
G-7	SINK-COUNTER	1 1/2"	1 1/2"	1/2" FIXTURE BY OTHERS - P.C. SHALL PROVIDE STOP VALVES ON H&C.W. - TRAP K-9000-1/2" - 8 MAKE ALL FINAL CONN.
G-7A	SINK-LAB	1 1/2" ACID W.	1 1/2"	1/2" FIXTURE BY OTHERS - P.C. SHALL PROVIDE STOP VALVES ON H&C.W. - 8 MAKE ALL FINAL CONN.
G-12	ROOF DRAIN	5"	-	- FIXTURE BY OTHERS - P.C. SHALL CONN. RWC PIPE TO ROOF DRAIN

INDICATES HANDICAP FIXTURE

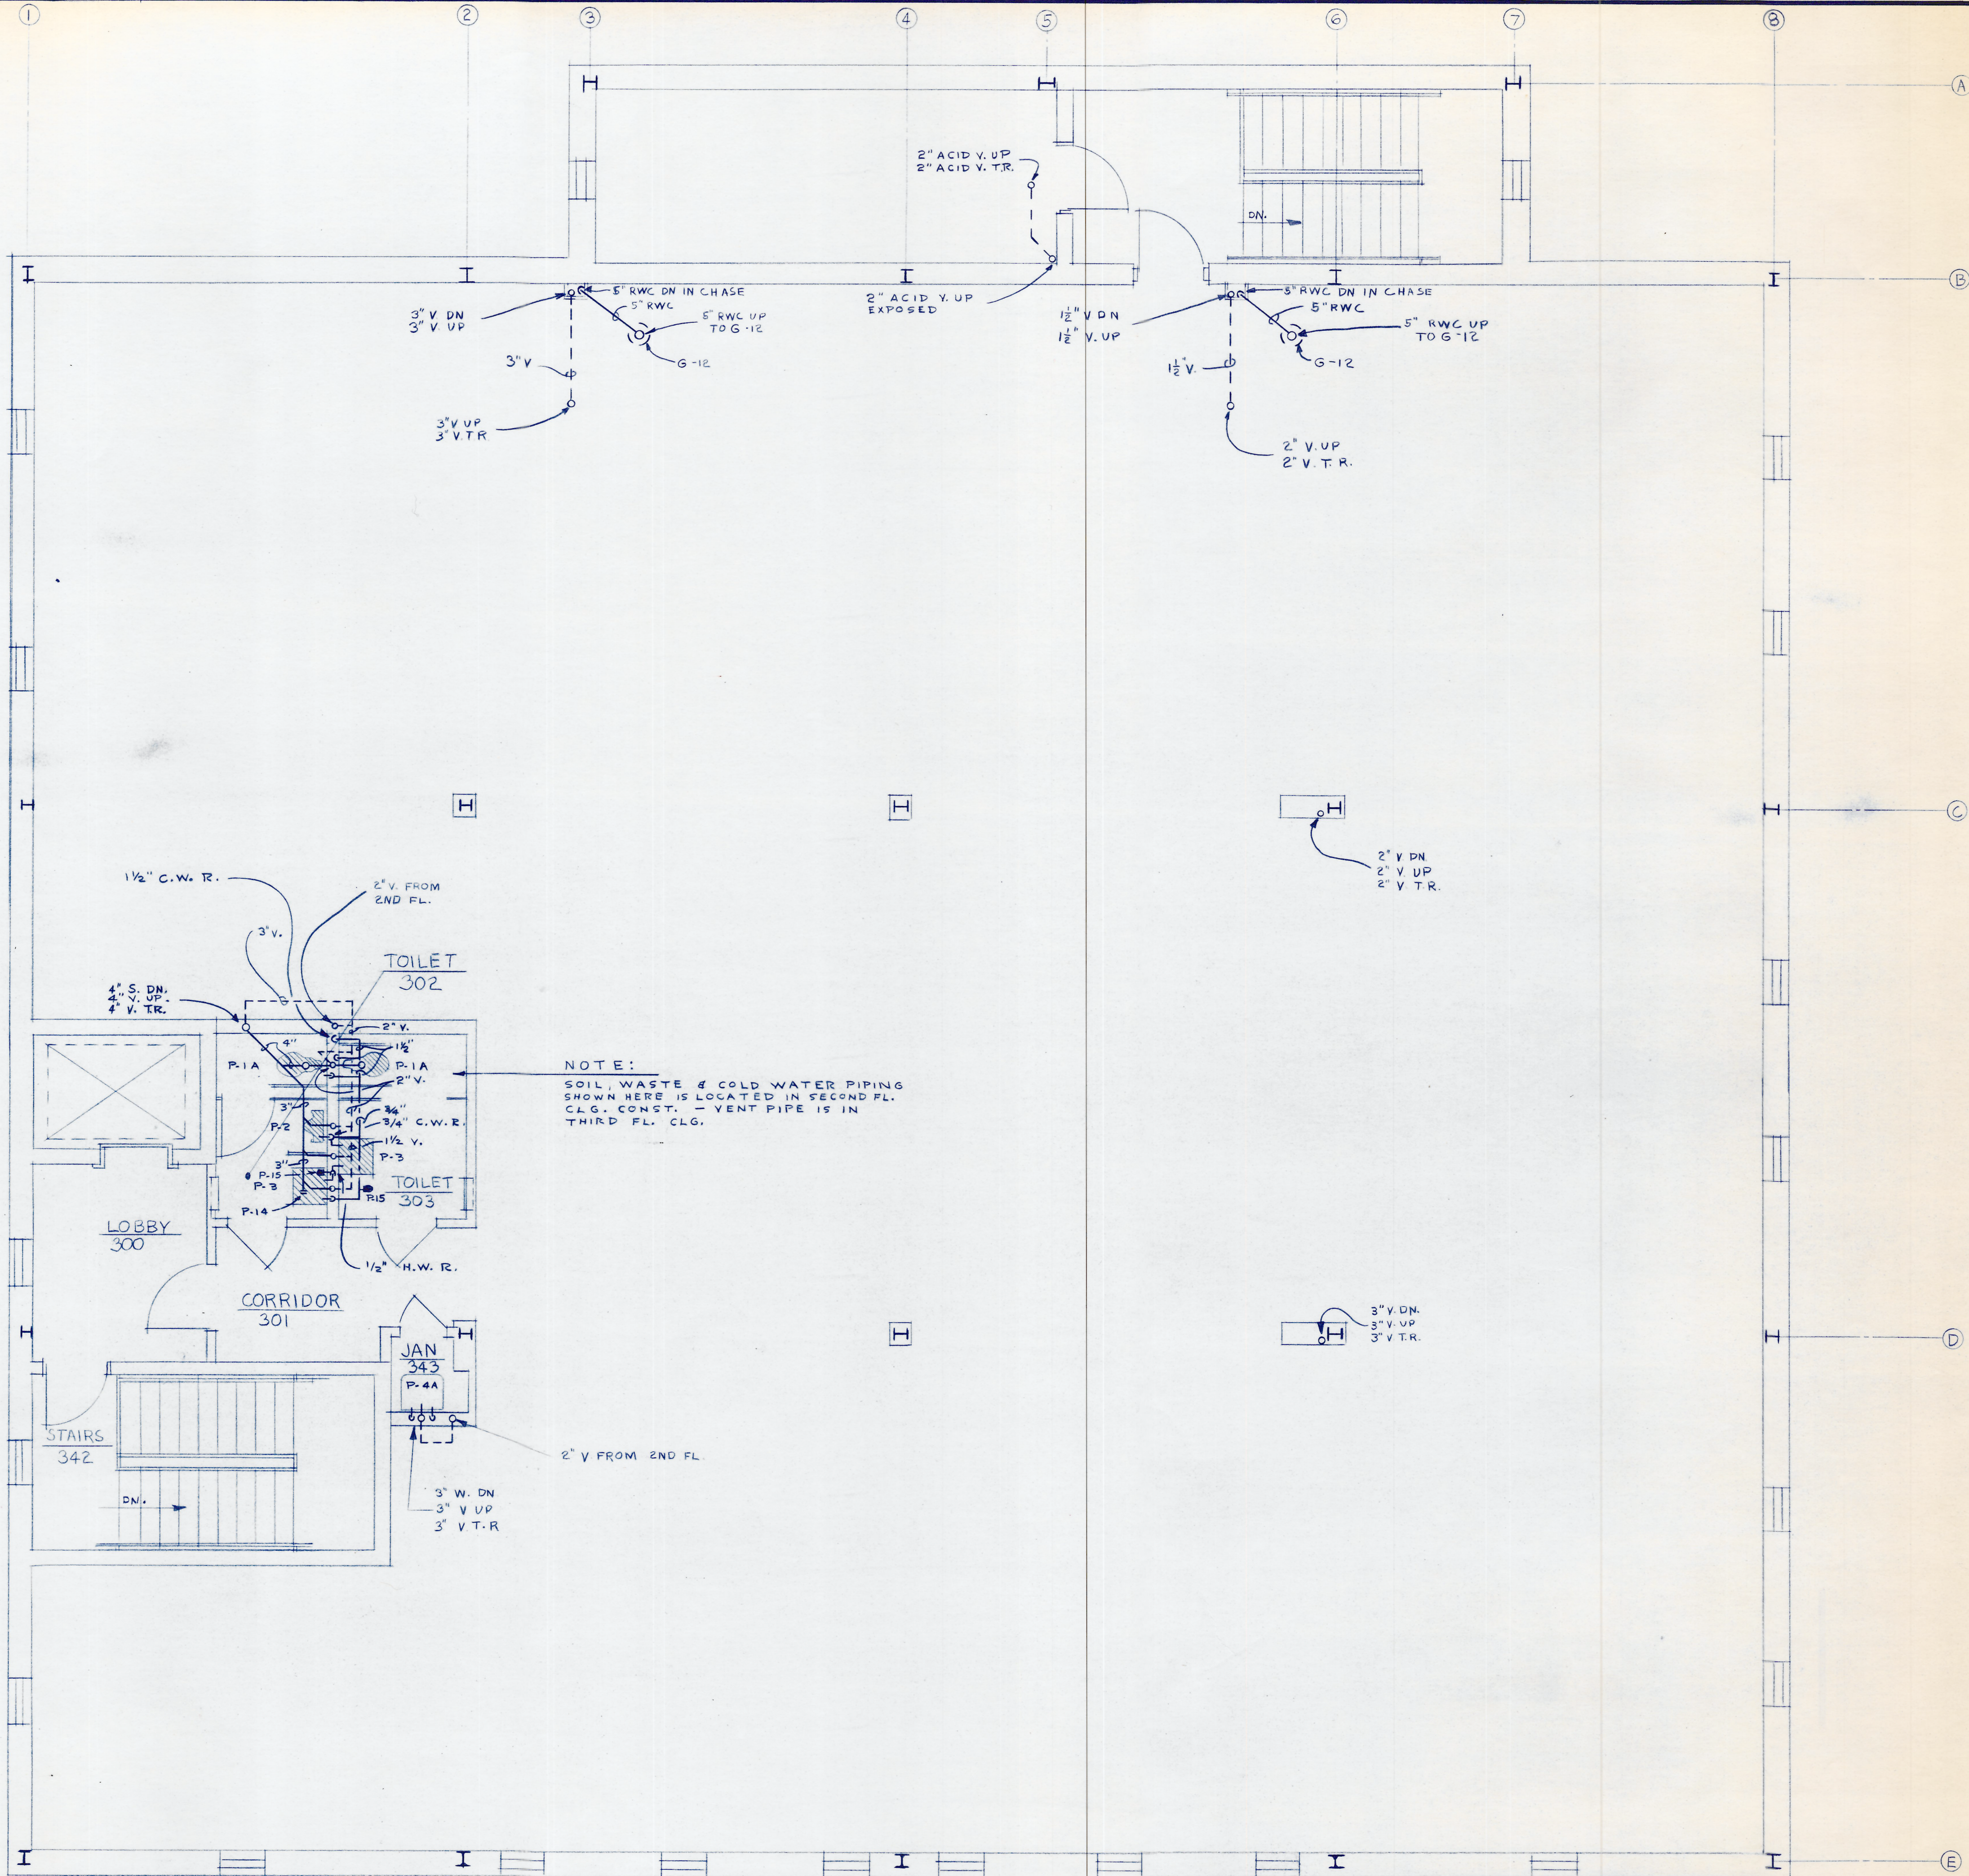

"ALL DIMENSIONS AND EXISTING CONDITIONS SHALL BE CHECKED AND VERIFIED BY CONTRACTOR AT THE SITE."

FILSON - MINNICH & ASSOCIATES, INC.
CONSULTING ENGINEERS
2426 NORTH SECOND STREET
HARRISBURG, PA. 17110

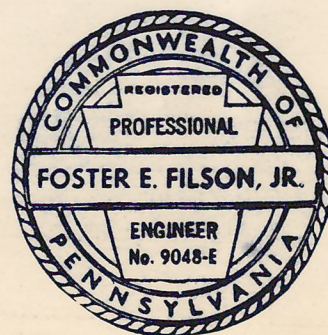

MONROEL MEDICAL BLDG.
1400 MONROE AVE.
DUNMORE, PENNA.

DATE
SCALE
1/8" = 1'-0"

DONALDSON BERGHAUSER AIA
AND JOSEPH H. YOUNG AIA
ASSOCIATED ARCHITECTS
345 JEFFERSON AVENUE, SCRANTON, PA.
THIRD FLOOR PLAN

P-5