

LIGHTING FIXTURE SCHEDULE			
TYPE	DESCRIPTION	MANUFACTURER	
1	SCONCE WITH 13W FLUORESCENT	ATLANIS	
2	TRACK LIGHTING 13W FLUORESCENT LAMPS		
3	SURFACE MOUNTED FIXTURE WITH 2,13W FLOUR. LAMPS		
4	48" 78 TWO LAMP FLUORESCENT		
5	48" x 24" LIGHT SCOTT WITH TWO 24" FLUORESCENT BULBS AND 2 - 48" 78 FLUORESCENT BULBS		
6	LED/EXIT EMERGENCY SIGN WITH INTEGRAL EMERGENCY BATTERY PACK		
7	WALL MOUNTED FIXTURE		
8	CEILING FAN		


ELECTRICAL NOTES

- ALL PURCHASED MATERIALS SHALL BE NEW AND FREE FROM DEFECTS.
- ALL EQUIPMENT AND MATERIALS SHALL BE LISTED BY UNDERWRITERS' LABORATORIES.
- ALL CONDUCTORS SHALL BE STRANDED COPPER WIRE.
- INSULATION SHALL BE THHN & THWN.
- WIRE SIZE, INSULATION TYPE, AND THE MANUFACTURERS NAME SHALL BE PERMANENTLY MARKED ON THE CONDUCTORS JACKET AT REGULAR INTERVALS.

PANEL SCHEDULE				
125 AMPS MAX. 120/240 V.A.C. SINGLE PHASE - 3 WIRE				
CIRCUIT NUMBER	DESCRIPTION	LOAD V-A	BREAKER SIZE	WIRE
1	4 OUTLETS, WEST LIGHTING, 7 SCONCES	838	20 A	NO. 12 AWG
2	LIGHTING, TRACK AND EXIT, CEILING FANS	408	20 A	NO. 12 AWG
3	3 OUTLETS, SOUTH	540	20 A	NO. 12 AWG
4	LIGHTING SOUTH	420	20 A	NO. 12 AWG
5	TANKLESS WATER HEATER	12000	60A, 2P	NO. 6 AWG
6	5 OUTLETS, MEZZANINE	900	20 A	NO. 12 AWG
7	6 OUTLETS, MEZZANINE	1080	20 A	NO. 12 AWG
8	6 SCONCES, MEZZANINE	101	20 A	NO. 12 AWG


ELECTRICAL AND MECHANICAL SYMBOLS

	DUPLEX RECEPTACLE 100V MIN. 15' ABOVE FLOOR		EXISTING LIGHT FIXTURE, UNO
	GROUND FAULT INTERRUPT MIN. 15' ABOVE FLOOR		EXISTING LIGHT FIXTURE, UNO
	SWITCH, MAX. 48' ABOVE FLOOR		EXISTING SUPPLY, UNO
	THERMOSTAT		EXISTING RETURN AIR, UNO
	EXISTING FIRE SPRINKLER		

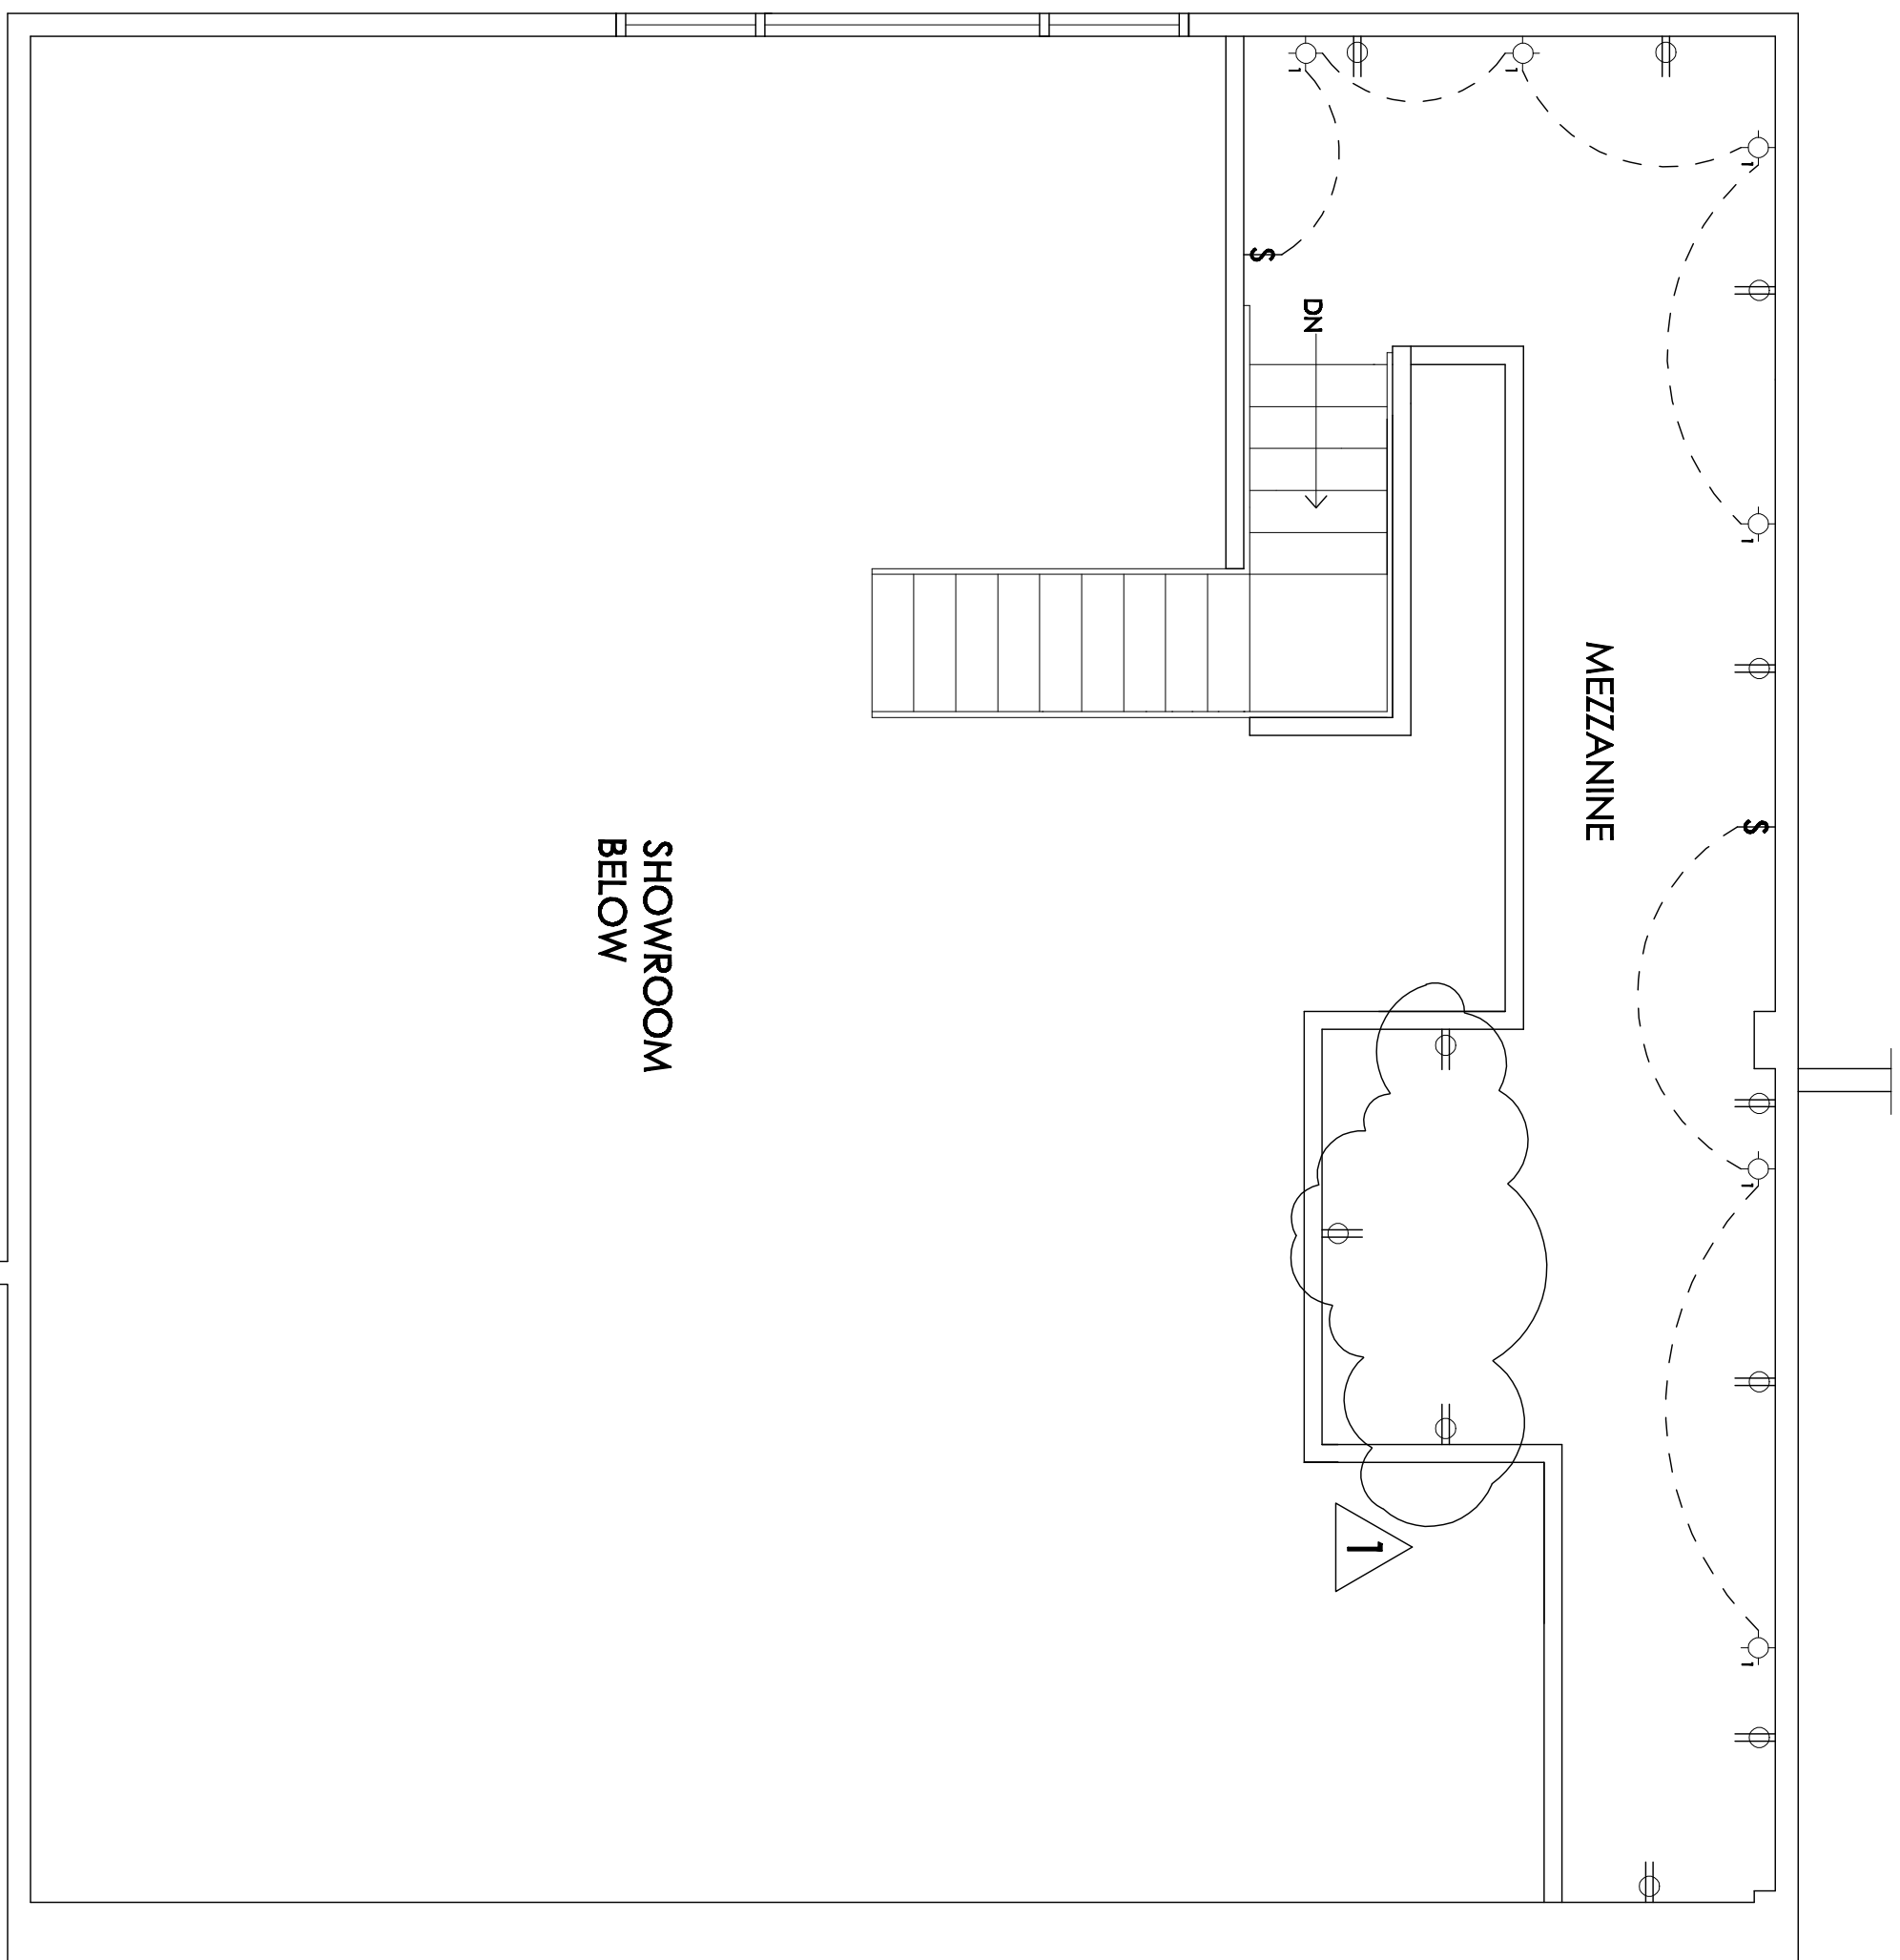

MEZZANINE ELECTRICAL/
MECHANICAL PLAN

1/4" = 1'-0"

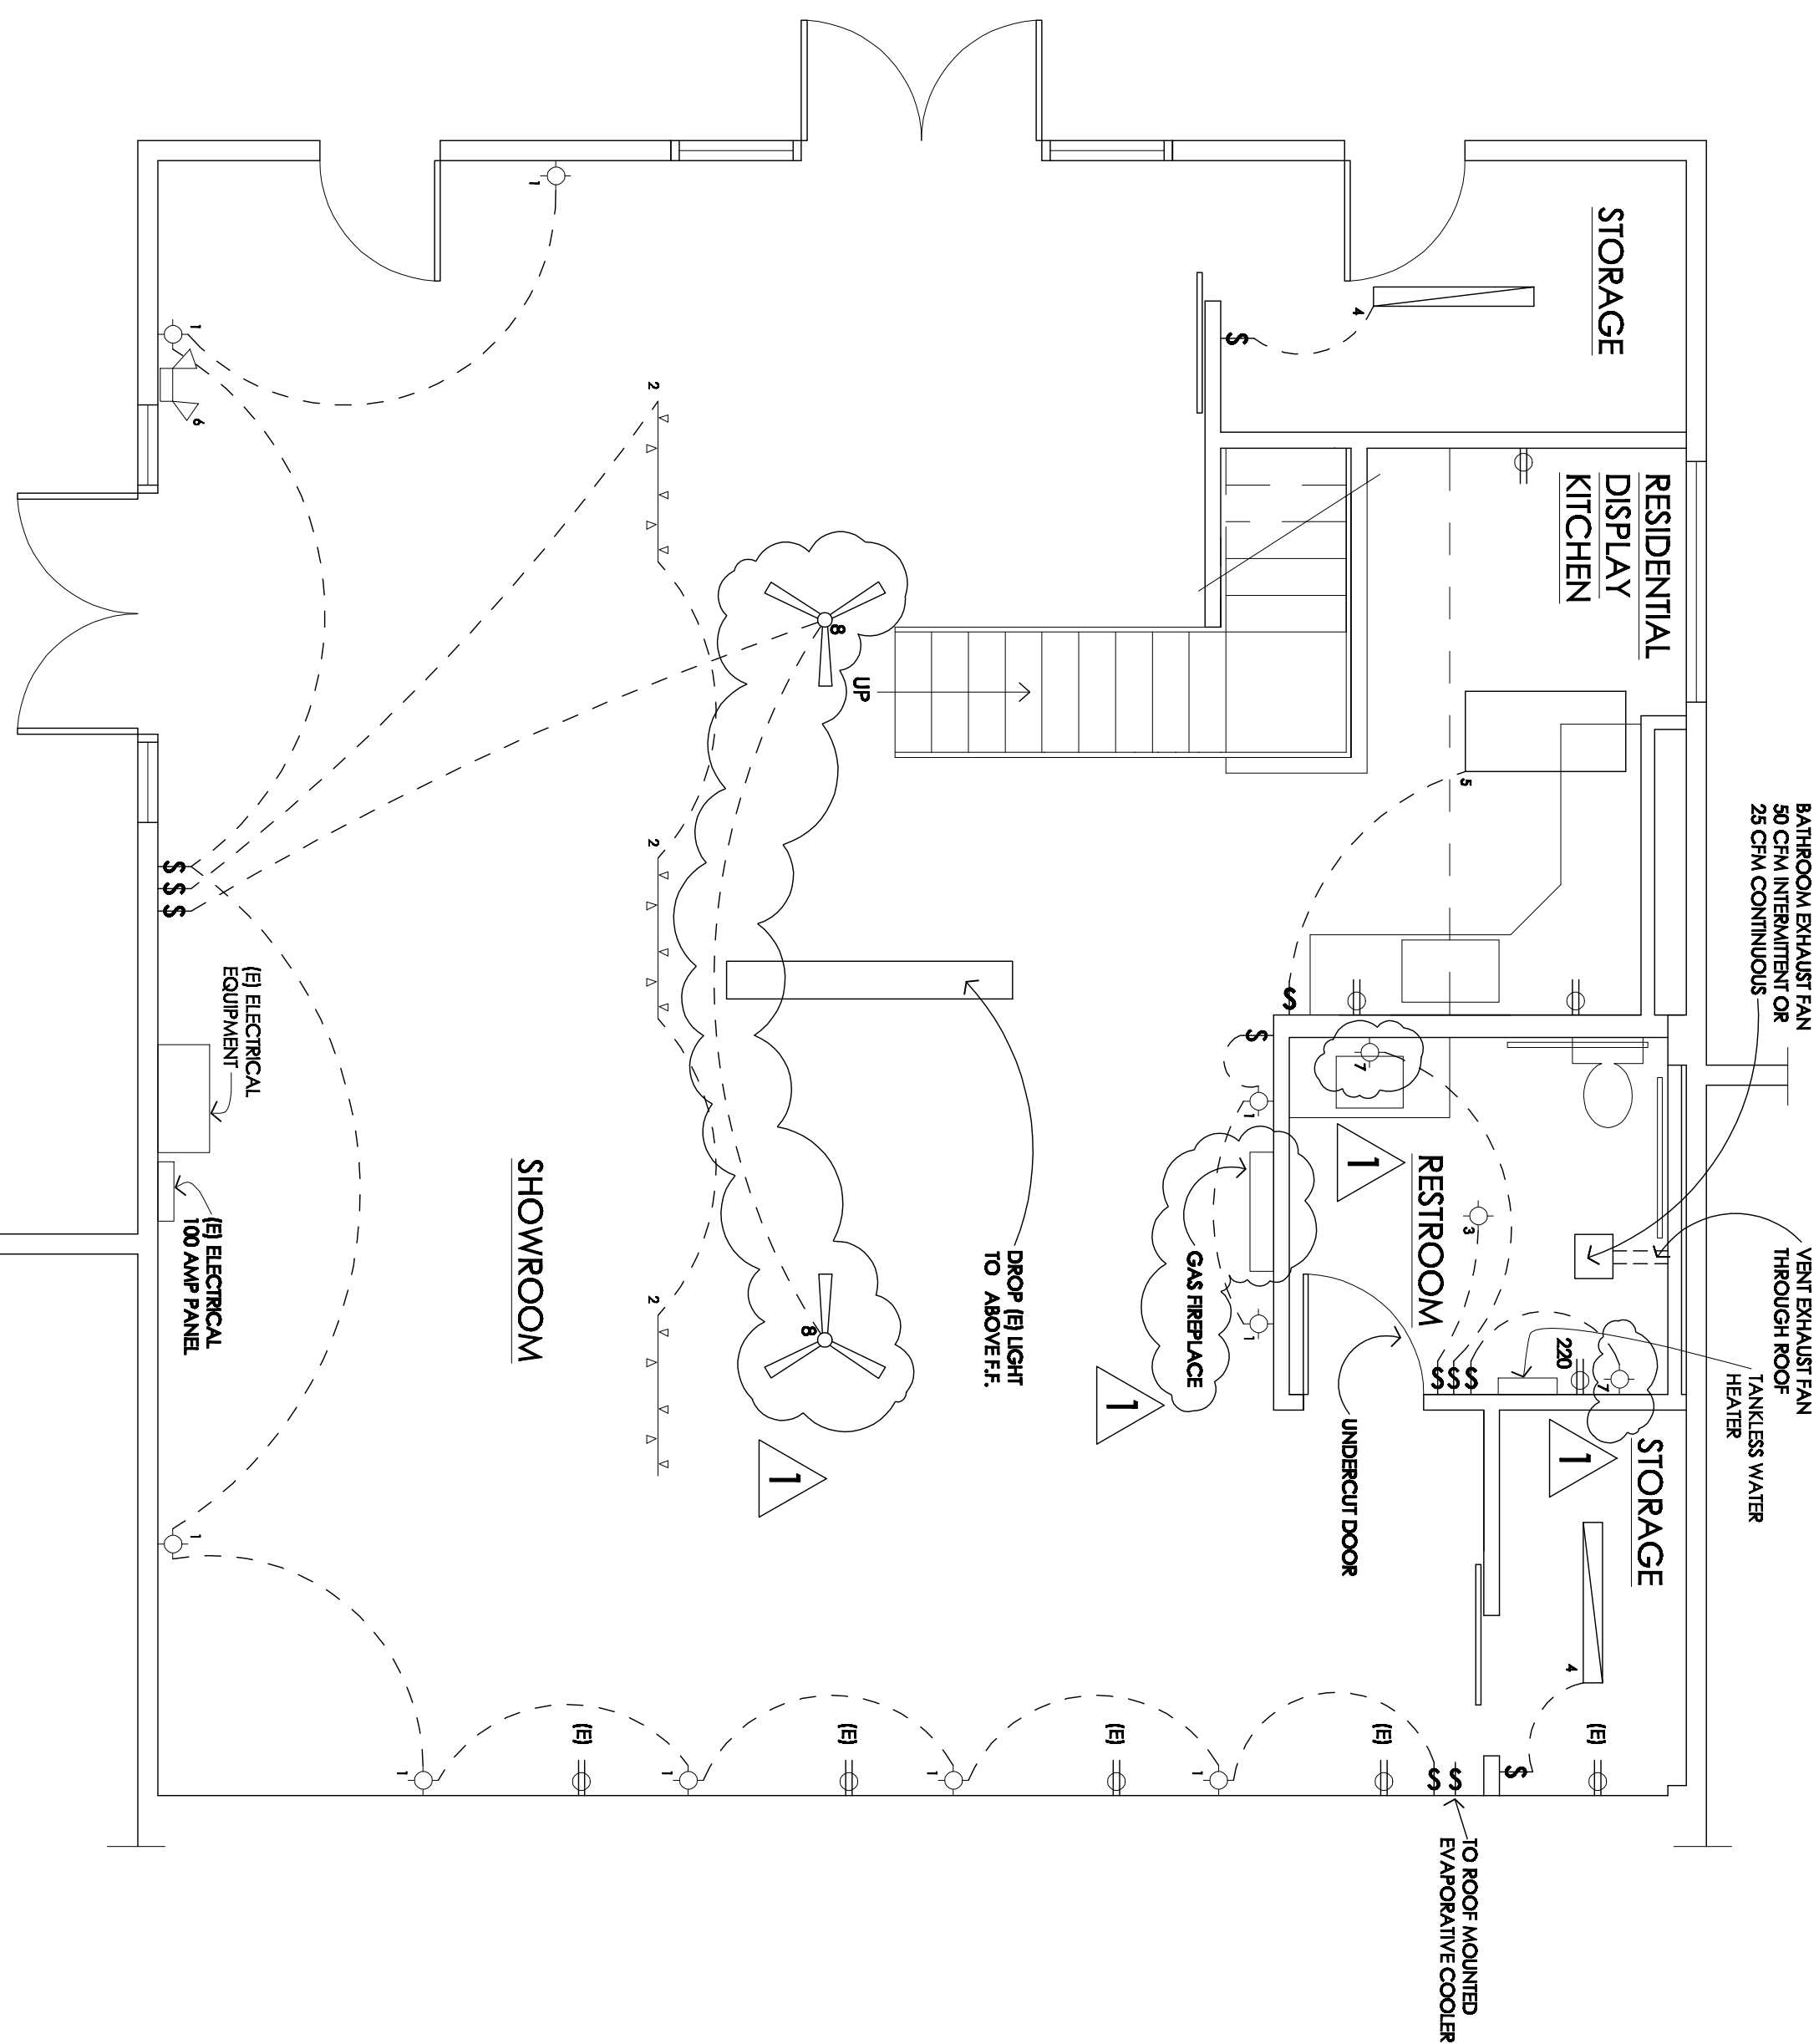

FIRST FLOOR ELECTRICAL/
MECHANICAL PLAN

1/4" = 1'-0"

CASA VERDE
DESIGNS
SHOWROOM

NANCY MORROW

5th STREET
CROSSING CENTER
912 5th STREET
DAVIS, CA 95616

PREPARED BY:
STACEY EITL
C-31704

DRAWING:

ELECTRICAL AND
MECHANICAL SYMBOLS
FIRST FLOOR ELECTRICAL/
MECHANICAL PLAN
PANEL SCHEDULE
LIGHTING FIXTURE
SCHEDULE
MEZZANINE ELECTRICAL/
MECHANICAL PLAN

PAGE: **A3**
4 OF 5

DATE:
MAY 16, 2011

1 JULY 26, 2011

SCALE:
1/4" = 1'-0"
0' 1' 2' 4' 8' 12'