


KITCHEN EQUIPMENT SCHEDULE

NO.	SUPPL'D	INS'D	DESCRIPTION	QTY.	MANUFACTURER	MODEL	NOTES	NO.	SUPPL'D	INS'D	DESCRIPTION	QTY.	MANUFACTURER	MODEL	NOTES	NO.	SUPPL'D	INS'D	DESCRIPTION	QTY.	MANUFACTURER	MODEL	NOTES
1.1	G.C.	G.C.	MIRROR	2			24" horiz. x 42" vert.	63.1	T.D.	G.C.	OVERHEAD ISLAND SHELVE	---	ISS	VARIES		114.5R	T.D.	T.D.	32" SOUP STAGING COUNTER	1			
2	T.D.	G.C.	TOILET PAPER HOLDER	2			Surface Mounted (Consult with Tim Hortons field engineer)	64.1	T.D.	G.C.	DRY STORAGE SHELVE (METAL)	---	ISS	VARIES	See plan	114.6	T.D.	T.D.	BAGEL TOASTER COUNTER	1			
3.2	G.C.	G.C.	ELECTRIC HAND DRYER	2	WORLD	NOVA 1 #2830	Surface mounted ADA/ANSI compliant Color White	64.1	T.D.	G.C.	DRY STORAGE SHELVE -- LOCKING	---	ISS	VARIES		114.7L	T.D.	T.D.	BACK COUNTER -- LEFT	1			
4A	G.C.	G.C.	42" GRAB BAR	-	BOBRICK	B-6806x42	Supplied by finished carpentry section	64.1	T.D.	G.C.	SINGLE VOLUME CREAMER -- STD	2	---	---		114.10R	T.D.	T.D.	BACK COUNTER -- RIGHT	1			
4B	G.C.	G.C.	36" GRAB BAR	-	BOBRICK	B-6806x36	Supplied by finished carpentry section	64.3	T.D.	G.C.	ICER CREAMER-DUAL VOLUME (STANDARD)	1	SURE SHOT	AC10		116.1	T.D.	T.D.	EDGE LIGHT MENUBOARD	5			
4C	G.C.	G.C.	24" GRAB BAR	-	BOBRICK	B-6806x24	Supplied by finished carpentry section	67.4	T.D.	G.C.	HOT POWERED DRINK MACHINE (STANDARD)	2	BUNN	PHD DBC-3		118	T.D.	T.D.	PORTAL COMPUTER	1			
4D	G.C.	G.C.	SHING UP GRAB BAR	-	BOBRICK	B-4998	Supplied by finished carpentry section	68.1	T.D.	G.C.	COFFEE BREWER	6	BUNN-O-MATIC	STS 35		118.1	T.D.	T.D.	PRINTER	1			
5	T.D.	G.C.	SOAP DISPENSER -- HAND SINK AREA	4				70	T.D.	G.C.	SUGAR DISPENSER -- ELECTRIC	3	SURE SHOT	AC4E	GC to provide water shut-off at backbar for each	121	T.D.	T.D.	MPO PLATFORM WITH COVER	---			
5.1	T.D.	G.C.	SOAP DISPENSER -- WALL MOUNTED	3	BOBRICK	B-2111	Liquid Soap Surface mounted	71.4	T.D.	G.C.	WALK-IN FREEZER	1	ICS	PDT 819		122	T.D.	G.C.	WIRE SHELF -- WALL BRACKET	4			
6	T.D.	T.D.	RECEIVER (MUSAK)	1	PANASONIC	SA160K	On shelf -- electrician to supply & connect speakers	71.5	T.D.	G.C.	WORK TABLE S/S	1	WASSERSTROM		(36' Long)	123	T.D.	G.C.	MEDIA STORAGE CABINET	1F			
8.2	T.D.	T.D.	BAG-N-BOY W/ CARBONATOR	-	COKE	-	43"	72.2	T.D.	G.C.	EXHAUST HOOD (OVEN #55.4)	1			(48' Long)	124	T.D.	T.D.	LCD MONITOR	1F			G.C. to pre-wire between menu boards
16.3	T.D.	T.D.	IN-STORE CAMERA	9	PANASONIC	WV-BP140	Location to suit Tim Hortons field engineer	72.3	T.D.	G.C.	EXHAUST HOOD (BAGEL TOASTER)	1			See Mechanical & Electrical drawings	128	T.D.	G.C.	FLAVOR DISPENSER FOR COFFEE	3	SURE SHOT		
20.12	T.D.	G.C.	3 COMPARTMENT SINK	1	S4G		(72" Long)	72.4	T.D.	G.C.	EXHAUST HOOD (SOUP WARMERS)	1			See Mechanical & Electrical drawings	130.1	T.D.	G.C.	ICED COFFEE DISPENSER	3			
22.1	T.D.	G.C.	FIRE EXTINGUISHER WITH RECESSED CABINET	1				73.1	T.D.	G.C.	EXHAUST HOOD (DISHWASHER)	1			See Mechanical & Electrical drawings	133	T.D.	G.C.	DONUT SHOWCASE 4-WIDE LOWBOY	1	QBD		
22.2	T.D.	G.C.	FIRE EXTINGUISHER WALL SURFACE MTD.	1				73.2	T.D.	G.C.	HAND SINKS -- COUNTER MOUNTED	4	POLAR	1734		134	T.D.	T.D.	HIGH CHAIR AND TRAY	2	RUBBERMAID	7805/7815	
24.2	T.D.	T.D.	POWER WHISK MIXER	1				74	T.D.	G.C.	HAND SINKS -- WALL MOUNTED	1	AMTEKO	D41T		135	T.D.	G.C.	HOT HOLDING UNIT	1/1F	MERCO SAVORY		
25	T.D.	T.D.	REGULAR KEEPER	1				75	T.D.	G.C.	WALK-IN COOLER	1	ICS	PDT 819		136	T.D.	G.C.	FUTURE BEVERAGE UNIT	1/1F	TBD		
26.5	S.F.C.	G.C.	ALWAYS FRESH FINISHING TABLE (4'-0")	1	WASSERSTROM			77.5	T.D.	G.C.	SOUP WARMERS (TRIPLE BUILT-IN) STND.	1	WELLS / WYOTT	TD1900	Plumbing contractor to provide separate ball valve drain for each soup well.	137	T.D.	G.C.	PAPER TOWEL DISP. & WASTE RECEPTACLE	2	BOBRICK	B-3649	Recessed into wall.
27.1	T.D.	T.D.	DRIVE-THRU MONITOR (WALL MOUNTED)	1	PANASONIC		C/W Monitor Bracket #VMB-9 by CBM Metal	81.4	T.D.	G.C.	UNDERCOUNTER BEVERAGE REFRIGERATOR	2F			Future	STORE FIXTURE SCHEDULE S.F.C. STORE FIXTURE COMPANY T.D. TIM DONUT LIMITED G.C. GENERAL CONTRACTOR							
27.2	T.D.	T.D.	SANDWICH MONITOR (WALL MOUNTED)	4	PANASONIC			82	T.D.	G.C.	UNDERCOUNTER REFRIGERATOR	2	BEVERAGE AIR	UCR27									
28	T.D.	G.C.	HOT WATER MACHINE	1F	BUNN	442					DEPOSIT BOX SAFE	3	PERMAVAULT	PRO-500	One at P.U.W. one at front register.	D1	S.F.C.	S.F.C.	MAIN COFFEE STATION	1	S4G		
28.1	T.D.	G.C.	PAPER TOWEL DISPENSER ROLL	4	FROST	126										D2	S.F.C.	S.F.C.	SECOND COFFEE STATION	1	S4G		
29.2	T.D.	G.C.	PAPER TOWEL DISPENSER	1	FROST	101										D4	S.F.C.	S.F.C.	GLASS GUARD	---	S4G		
31	T.D.	T.D.	WIRELESS BASE STATION	1	HME/3M/PANASONIC											D8	S.F.C.	S.F.C.	DRIVE-THRU DONUT WALLCASE	1	S4G		
32	T.D.	T.D.	BATTERY CHARGER	1	HME/3M/PANASONIC											D9	S.F.C.	S.F.C.	DRIVE-THRU CASH COUNTER	1	S4G		
33	T.D.	T.D.	HARDWARE RECEIVER	1	HME/3M/PANASONIC											D10	S.F.C.	S.F.C.	DRIVE-THRU BACK BAR	1	S4G		
34.7	T.D.	G.C.	DISHABLING W/ SINK FOR TEMPSTAR	1	S & G											D11	S.F.C.	S.F.C.	BACK BAR	1	S4G		
34.8	T.D.	G.C.	DRAWER PANS FOR TEMP STAR	1	S & G											D12	S.F.C.	S.F.C.	DRINK BAR	1	S4G		
35.3	T.D.	G.C.	DISHWASHER	1	TEMPSTAR	208/230/3 PHASE										D14	S.F.C.	S.F.C.	CAFE DOOR AND FRAME	1	S4G		
37.10	T.D.	T.D.	CASH REGISTERS	4	PANASONIC	7500	Insulated, isolation outlet									D17	S.F.C.	S.F.C.	MICROWAVE SHELF	1	S4G		
40.1	S.F.C.	S.F.C.	LID DISPENSER -- HOT	3												D17.1	S.F.C.	S.F.C.	MICROWAVE SHELF -- WHITE MELAMINE	1	S4G		
40.3	S.F.C.	S.F.C.	ICED CAPPUCCINO LID DISPENSER	1F												D21	S.F.C.	S.F.C.	3' DISPLAY MERCHANDISER	1	S4G		
42.4	T.D.	T.D.	MICROWAVE OVEN (STANDARD)	2	PANASONIC	NE 1054	On shelf (D17)									D22	S.F.C.	S.F.C.	LOW PARTITION	1	S4G		
43	T.D.	G.C.	WALL SHELVE 12" DEEP	---	ISS		Consult Tim Hortons field engineer -- See plan									D23	S.F.C.	S.F.C.	WAINSCOTING	---	S4G		
44.1	T.D.	T.D.	BEVERAGE FOUNTAIN W/ ICE BIN	---	WILSHIRE	DRINKMASTER II	15" X 22"									D23.1	S.F.C.	S.F.C.	WINDOW SILL	5	S4G		
46.3	T.D.	T.D.	BAGEL TOASTER -- TURBO	1/1F	STAR MFG.	QC53-1602B										D24	S.F.C.	S.F.C.	TRAINING CABINET	1	S4G		
47.7	S.F.C.	G.C.	SEATING PACKAGE WATERFALL (FREE)	---	PETER ANTHONY		Waterfall Free-standing									D34a	S.F.C.	S.F.C.	GARBAGE UNIT W/ TRAY STORAGE	1	S4G		
49	T.D.	G.C.	WALK-IN SHELVE	---	ISS		See plan									D42	S.F.C.	S.F.C.	CONVECTION OVEN S/S SILL	1	S4G		
50.2	T.D.	T.D.	FAX MACHINE -- STANDARD	1	PANASONIC		Connect to incoming line before any phone									D46	S.F.C.	S.F.C.	OFFICE COUNTERTOP	1	S4G		
51	T.D.	G.C.	PRECAST STONE GARBAGE UNIT	1	WASSAU	TF1025										D46.1	S.F.C.	S.F.C.	FILE DRAWER	1	S4G		
51.1	T.D.	G.C.	PRECAST STONE ASHTRAY UNIT	1	WASSAU	TF2045										D46.2	S.F.C.	S.F.C.	PENCIL DRAWER	1	S4G		
52.6	T.D.	T.D.	FASCIA SIGN -- 42"	3			Verify w/ Tim Hortons field engineer									D46.3	S.F.C.	S.F.C.	SINGLE OVERHEAD CABINET	1	S4G		
53.1	G.C.	G.C.	VANITY SINGLE BOWL	2	KARADON/SINGLE											D46.4	S.F.C.	S.F.C.	DOUBLE OVERHEAD CABINET	1	S4G		
55.4	T.D.	G.C.	MOISTURE PLUS -- 1/2 SIZE ELECT. OVEN	1/1F	GARLAND	MP065L	Oven with drain and vent kit																
57.2	T.D.	T.D.	FONDANT CONDITIONER	1	GARLAND	ED-154P	In Finishing table (#26)																
58.9	S.F.C.	S.F.C.	30" CAKE DISPLAY	1																			
60.1	T.D.	G.C.	HOT PLATE -- ELECTRIC	2	GARLAND	E24-12H(Elec)																	
62.4	T.D.	G.C.	ICE MACHINE	1	HOSHIZAKI	F-4501AH																	
63	T.D.	G.C.	SUSPENDED STORAGE SHELVE (METAL)	---	ISS	VARIES	Height above floor varies -- See I.S.S. drawings																

EQUIPMENT PLAN SCALE: 1/4" = 1'-0"

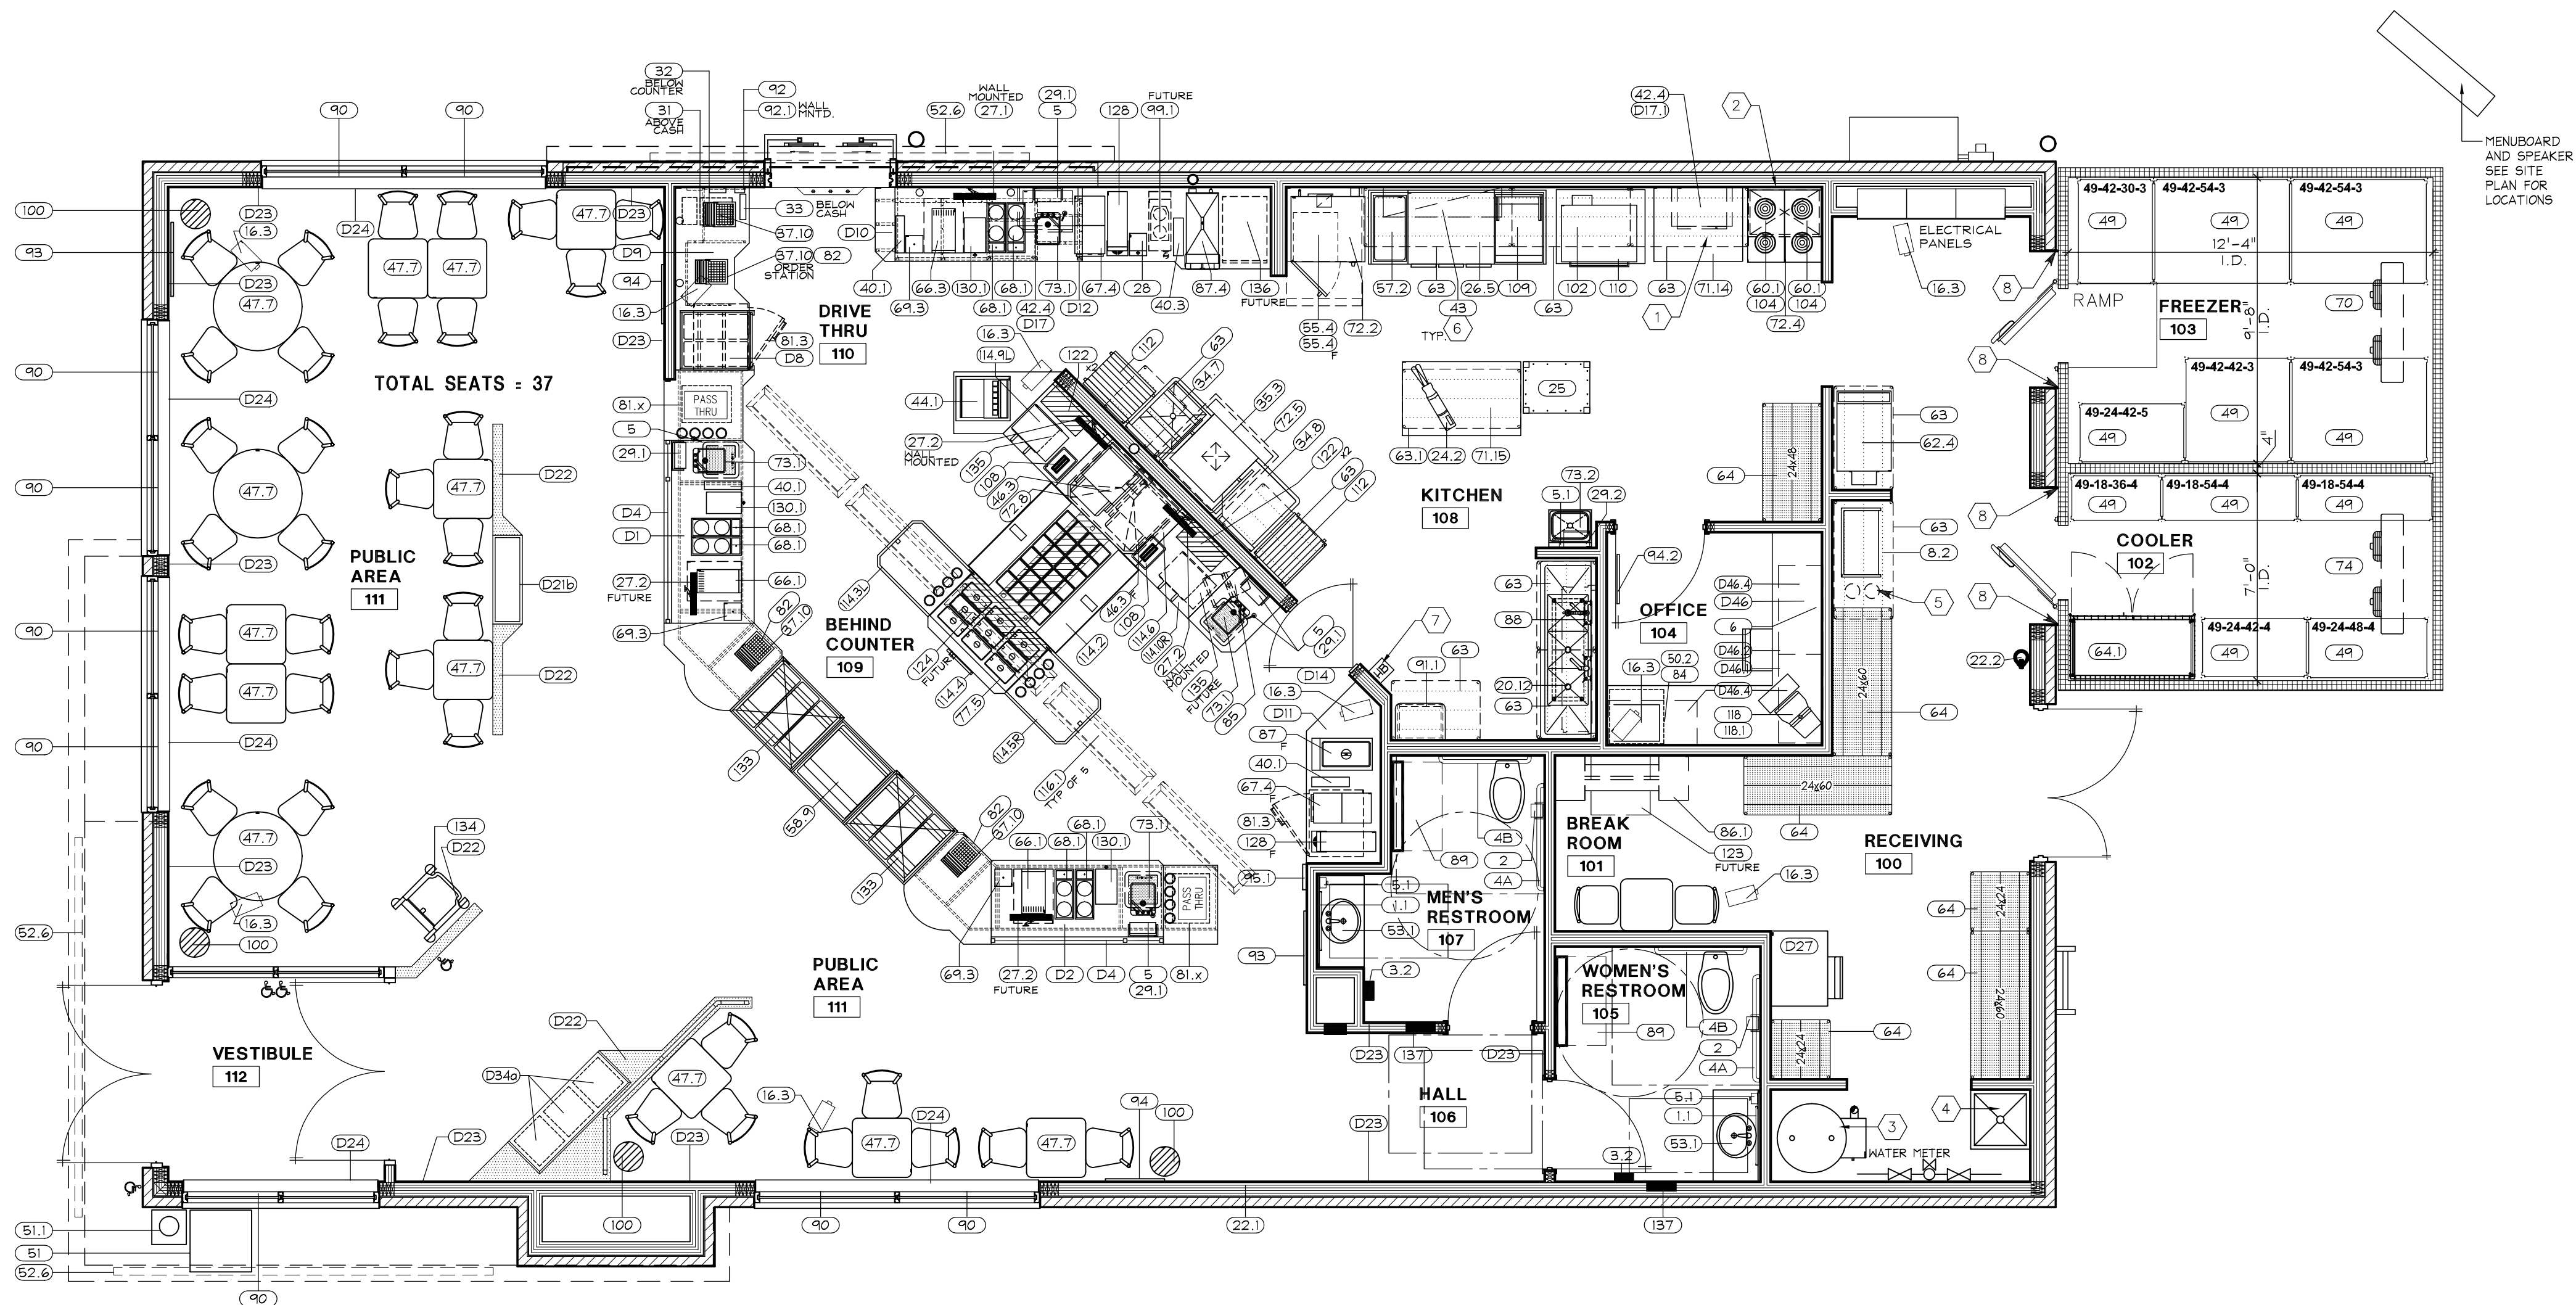

GENERAL NOTES

- GENERAL CONTRACTOR RESPONSIBLE FOR UNLOADING EQUIPMENT TRUCK AND PLACEMENT OF EQUIPMENT IN STORE.
- GENERAL CONTRACTOR SHALL BE RESPONSIBLE FOR VERIFYING AND COORDINATING ROUGH-IN LOCATIONS FOR ALL UTILITIES W/ EQUIPMENT DRAWINGS AND TIM HORTONS REPRESENTATIVE PRIOR TO INSTALLATION.
- FINAL CONNECTIONS TO EQUIPMENT TO BE MADE BY THE GENERAL CONTRACTOR AND HIS SUBCONTRACTOR.

FLOOR PLAN NOTE LEGEND

- 16" WIDE STAINLESS STEEL PANEL. ATTACH TO TABLE ON END NEAREST TO HOT PLATES.
- 4'-0" HIGH STAINLESS STEEL PANEL ON WALL. ATTACH TO WALL BEHIND HOT PLATES. SEE SHEET A-9 ELEV. 19.
- WATER HEATER, SUPPLIED BY T.D. AND INSTALLED BY G.C. SEE PLUMBING PLAN FOR MANUFACTURER AND MODEL NUMBER.
- RECESSED STAINLESS STEEL MOP SINK. PROVIDED AND INSTALLED BY CONTRACTOR. SEE PLUMBING SHEETS.
- CO2 TANK. PROVIDE SAFETY CHAIN. ATTACHED TO WALL.
- WALL TRACKING
- ROUGH-IN FOR FUTURE HOT BUTTON. SEE ELECTRICAL SHEETS FOR ADDITIONAL INFORMATION.
- FREEZER / COOLER MFG. TO PROVIDE STAINLESS STEEL CLOSURE ANGLE.

STORAGE SHELVE LEGEND

SHELVE TYPE	ITEM-DEPTH-LENGTH-TIERS	QUANTITY
OVERHEAD SHELVE #43	43-12-48	1
OVERHEAD SHELVE #88	88-12-36	1
OVERHEAD SHELVE #63	63-24-24 63-24-36 63-24-42 63-24-48 63-24-60	1 4 1 4 1
FLOOR SHELVE #64	64-24-24-4 64-24-30-4 64-24-48-4 64-24-60-4 64-24-72-4	2 0 1 3 0
WALK-IN SHELVE #49	49-18-36-4 49-18-54-4 49-24-42-4 49-24-48-4 49-24-42-5 49-42-30-3 49-42-42-3 49-42-54-3	1 2 1 1 1 1 1 3

NOTES:

- PROVIDE METAL SHELVE AS INDICATED ON DRAWINGS.
- REFER TO INTERIOR ELEV. SHEET A9 FOR SHELVE HEIGHTS.
- PROVIDE BLOCK/BACKING IN WALLS & CEILING AS REQUIRED FOR SHELVE SUPPORT.

Tim Hortons
MODEL 2400-07 (U.S.)
5625 S. CEDAR ST.
LANSING, MI

EQUIPMENT PLAN

SHREMSHOCK ARCHITECTS, INC.
6130 S. Sunbury Rd. WESTERVILLE, OH 43081
Phone: (614) 546-4650 Fax: (614) 546-4655
email: info@shremshock.com

REVISIONS:

* REVISIONS TO BE SHOWN ON THIS SHEET
DATE ISSUED:
06/14/2007

THE ARCHITECT ASSUMES NO RESPONSIBILITY OR LIABILITY FOR THE USE OF THESE PLANS OR ANY PROJECT OTHER THAN SPECIFICALLY AUTHORIZED BY THEM AND SIGNED AND SEALED FOR SUCH SPECIFIC LOCATION IN THE STATE SHOWN ON THE SEAL. THIS BUILDING USE IS ONLY APPLICABLE IN AREAS MEETING THE STATED DESIGN CRITERIA.

SAI # 06464
DRAWING NUMBER:

A2

DRAWN BY: PJS CHECKED BY: MLL