
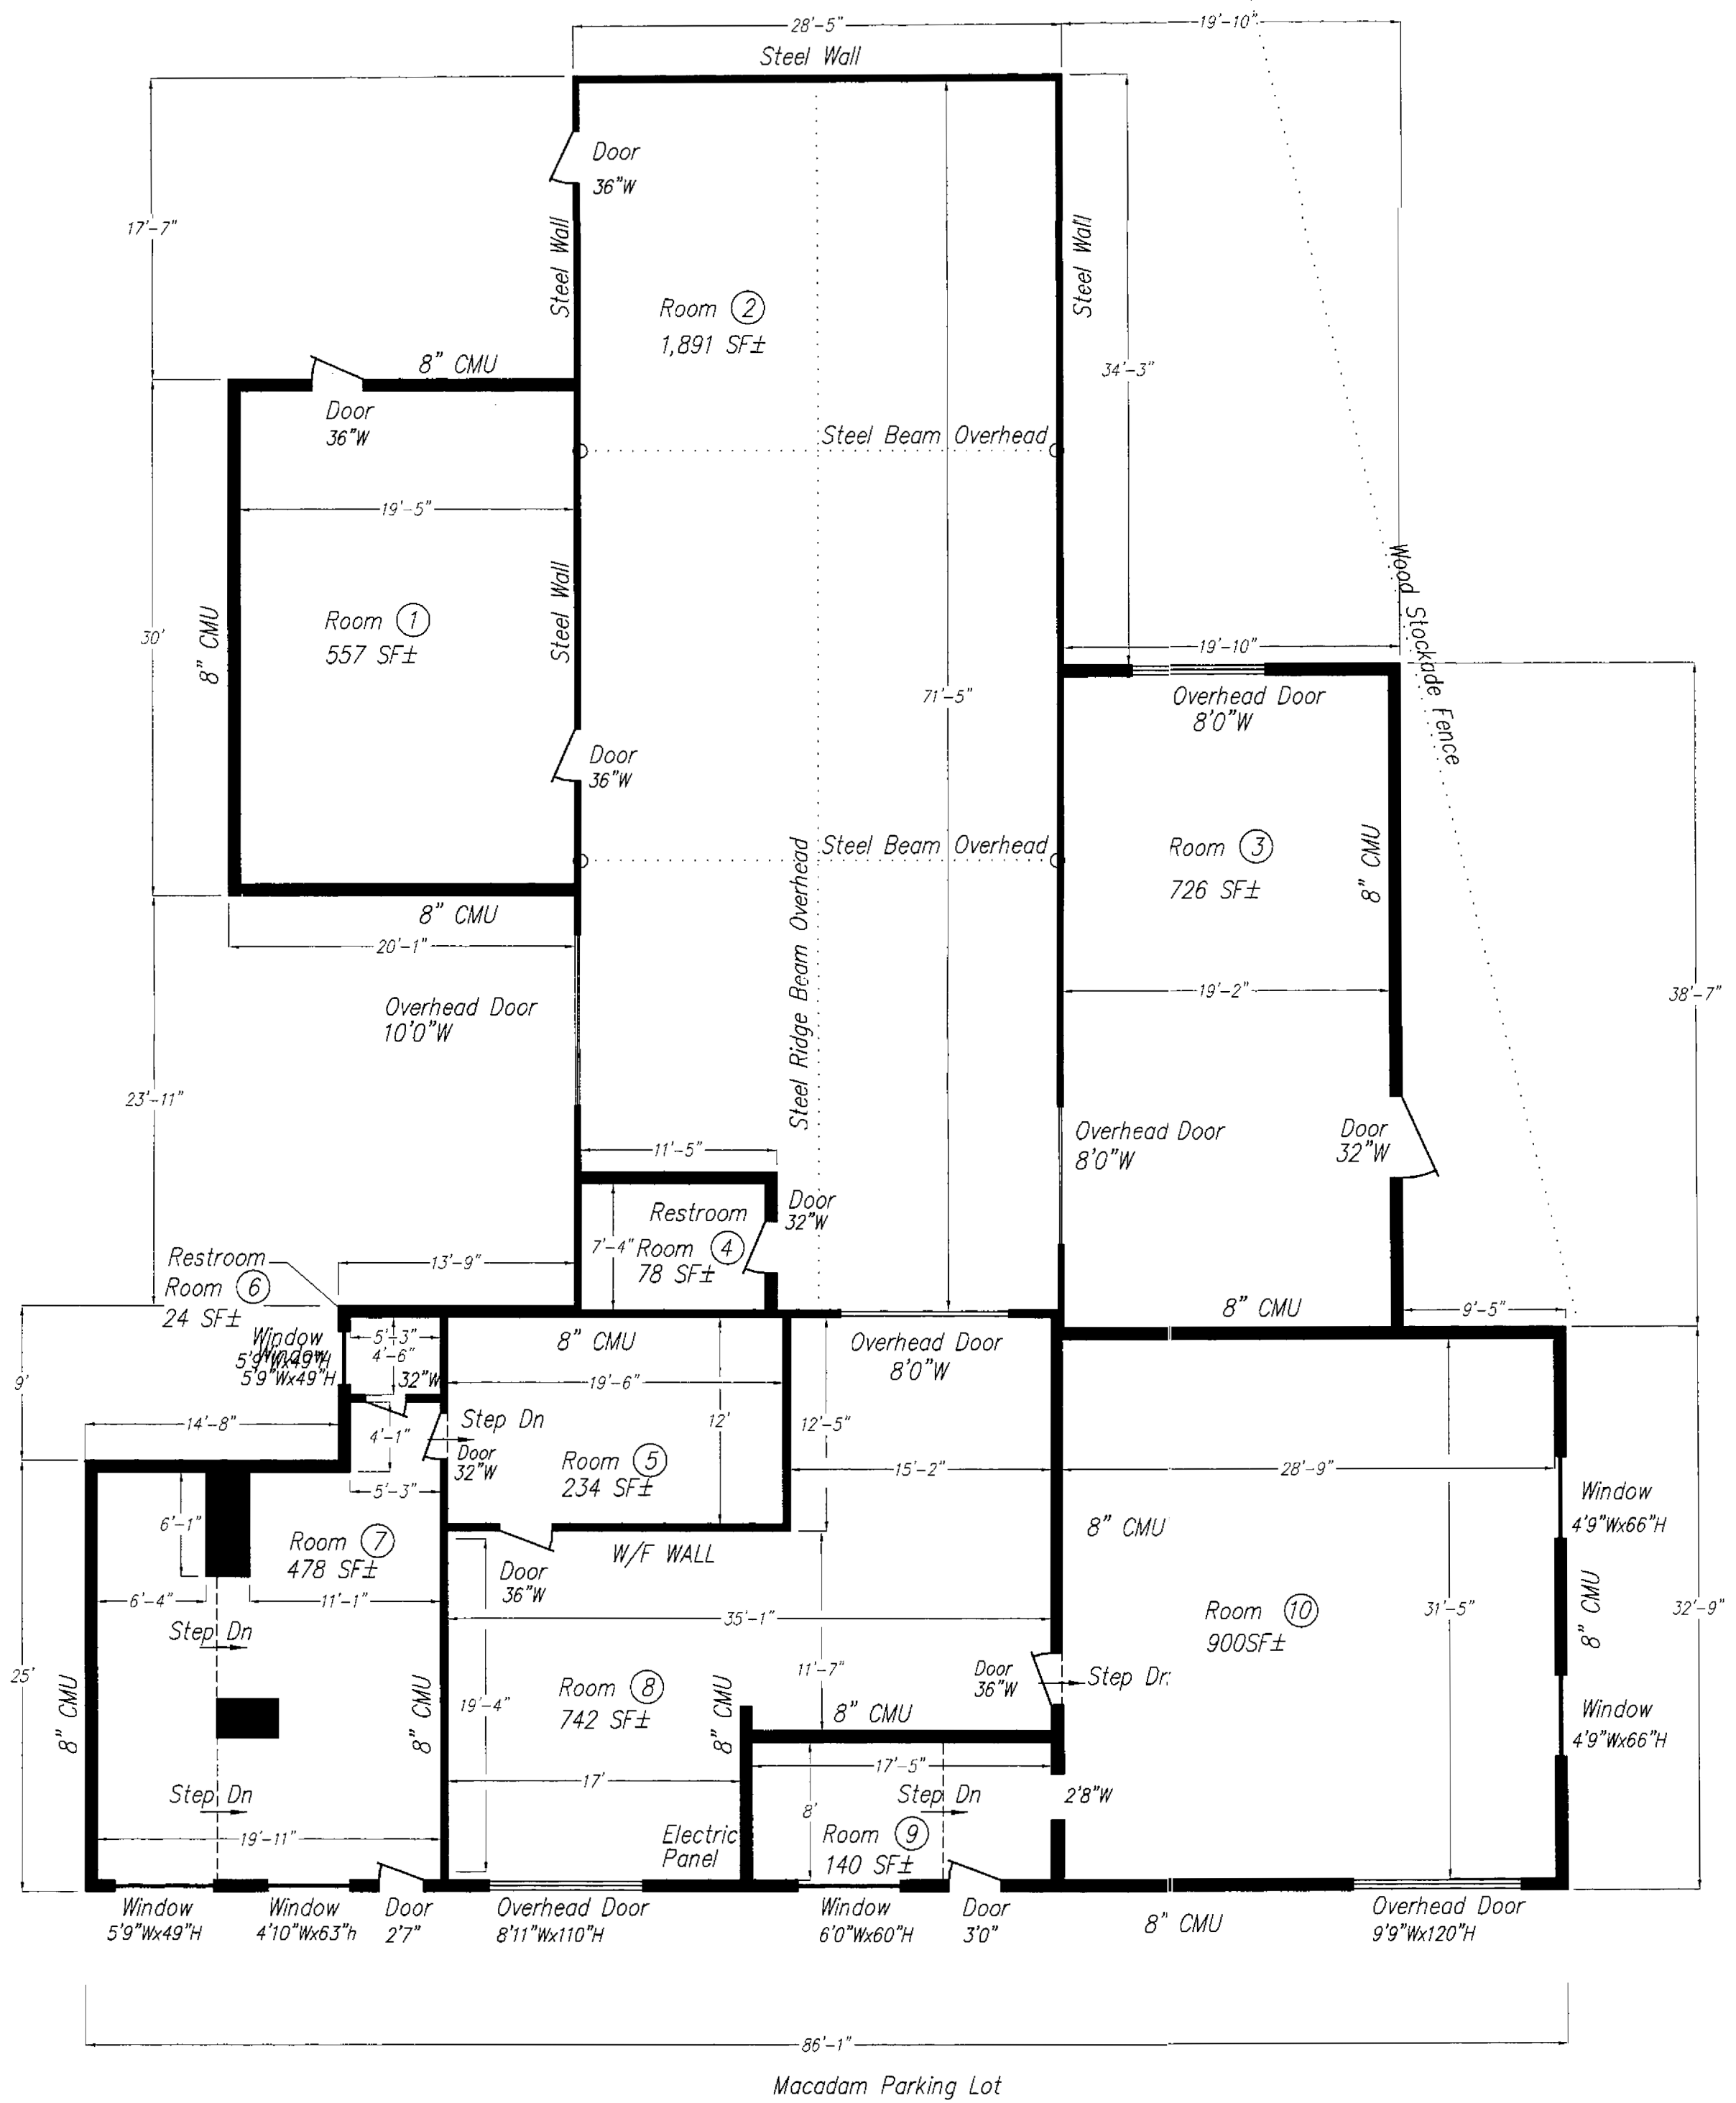


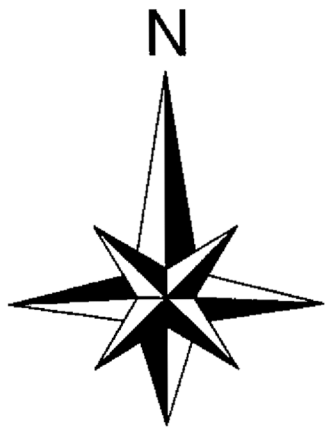

CONTRACTOR TO VERIFY ALL DIMENSIONS IN THE FIELD. DIMENSIONS INDICATED FOR DOORS ARE FOR ROUGH OPENINGS

FLOOR PLAN

SCALE: 1/8" = 1'-0"

1	12/18/2009	FPV
2		
3		
4		
5		
6		
7		
8		
9		
10		

FPV FRANK P. VILLANO, P.E.
CONSULTING ENGINEER, L.L.C.
116 WEST MEADOW WIND LANE
NEWBURGH, NEW YORK 12550
PHONE: (845) 564-0461
FAX: (845) 913-9010

PROFESSIONAL ENGINEER'S
CERTIFICATION
[Signature]
FRANK P. VILLANO, P.E.
NEW YORK, L.C. NO. 07604

PROJECT: COMMERCIAL BUILDING
LOCATED AT
976 LITTLE BRITAIN ROAD
N.Y.S. ROUTE 207
NEW WINDSOR, NEW YORK

SHEET TITLE:
EXISTING FLOOR PLAN

SK-1

1 OF 1 SHEETS