

- KOH
ARCHITECTURE PLLC

87-10 NORTHERN BLVD, SUITE 204
JACKSON HEIGHTS, NY 11372
phone : (718) 225-6400

CONTACT INFO

CLIENT:
179 UNION CENTER,
LLC

ATTN: MEIR BABAEV
87-10 NORTHERN BLVD, SUITE 203
JACKSON HEIGHTS, NY 11372
TEL: 718-631-9000

ARCHITECT:
KOH
ARCHITECTURE, PLLC

ATTN: DINAH KLAMERT, R.A.
87-10 NORTHERN BLVD SUITE 204
JACKSON HEIGHTS, NY 11372
TEL: 718-225-6400
E-MAIL: DINAHK@KOHARCH.COM

KOH ARCHITECTURE PLLC EXPRESSLY RESERVES ITS COMMON LAW COPYRIGHT AND OTHER PROPERTY RIGHTS TO THESE PLANS. ALL DESIGNS, SPECIFICATIONS AND DRAWINGS ARE THE PROPERTY OF KOH ARCHITECTURE PLLC WHICH ARE TO BE USED ONLY AS ISSUED FOR THIS PROJECT. THEY SHALL NOT BE USED ON ANY OTHER PROJECT IN FULL OR IN PART, WITHOUT FIRST OBTAINING THE EXPRESSED WRITTEN APPROVAL AND CONSENT OF KOH ARCHITECTURE PLLC. THESE DOCUMENTS SHALL NOT BE TRANSFERRED TO ANY UNAUTHORIZED THIRD PARTY WITHOUT THE SAME CONSENT.

BUILDING TO BE FULLY SPRINKLERED

NOTE:
ALL WORK SHALL COMPLY WITH LOCAL, MUNICIPAL, AND STATE CODES, ORDINANCES, ETC.
THE ARCHITECT IS NOT RESPONSIBLE FOR SITE SUPERVISION, SAFETY, OR CONSTRUCTION MEANS AND METHODS.

NO. SUBMISSIONS/ REV. DATE

NYC DOB NUMBER

Q005560771

PROJECT NAME:
179-24 UNION TURNPIKE
FRESH MEADOWS, NY 11366

BLOCK: 7229 LOT: 20


DRAWING TITLE
FIRST FLOOR PLAN

DRAWING NO.
A-101.00

SEAL AND SIGNATURE START DATE:


DRAWN BY: YS
CHK BY: DK

SHEET OF

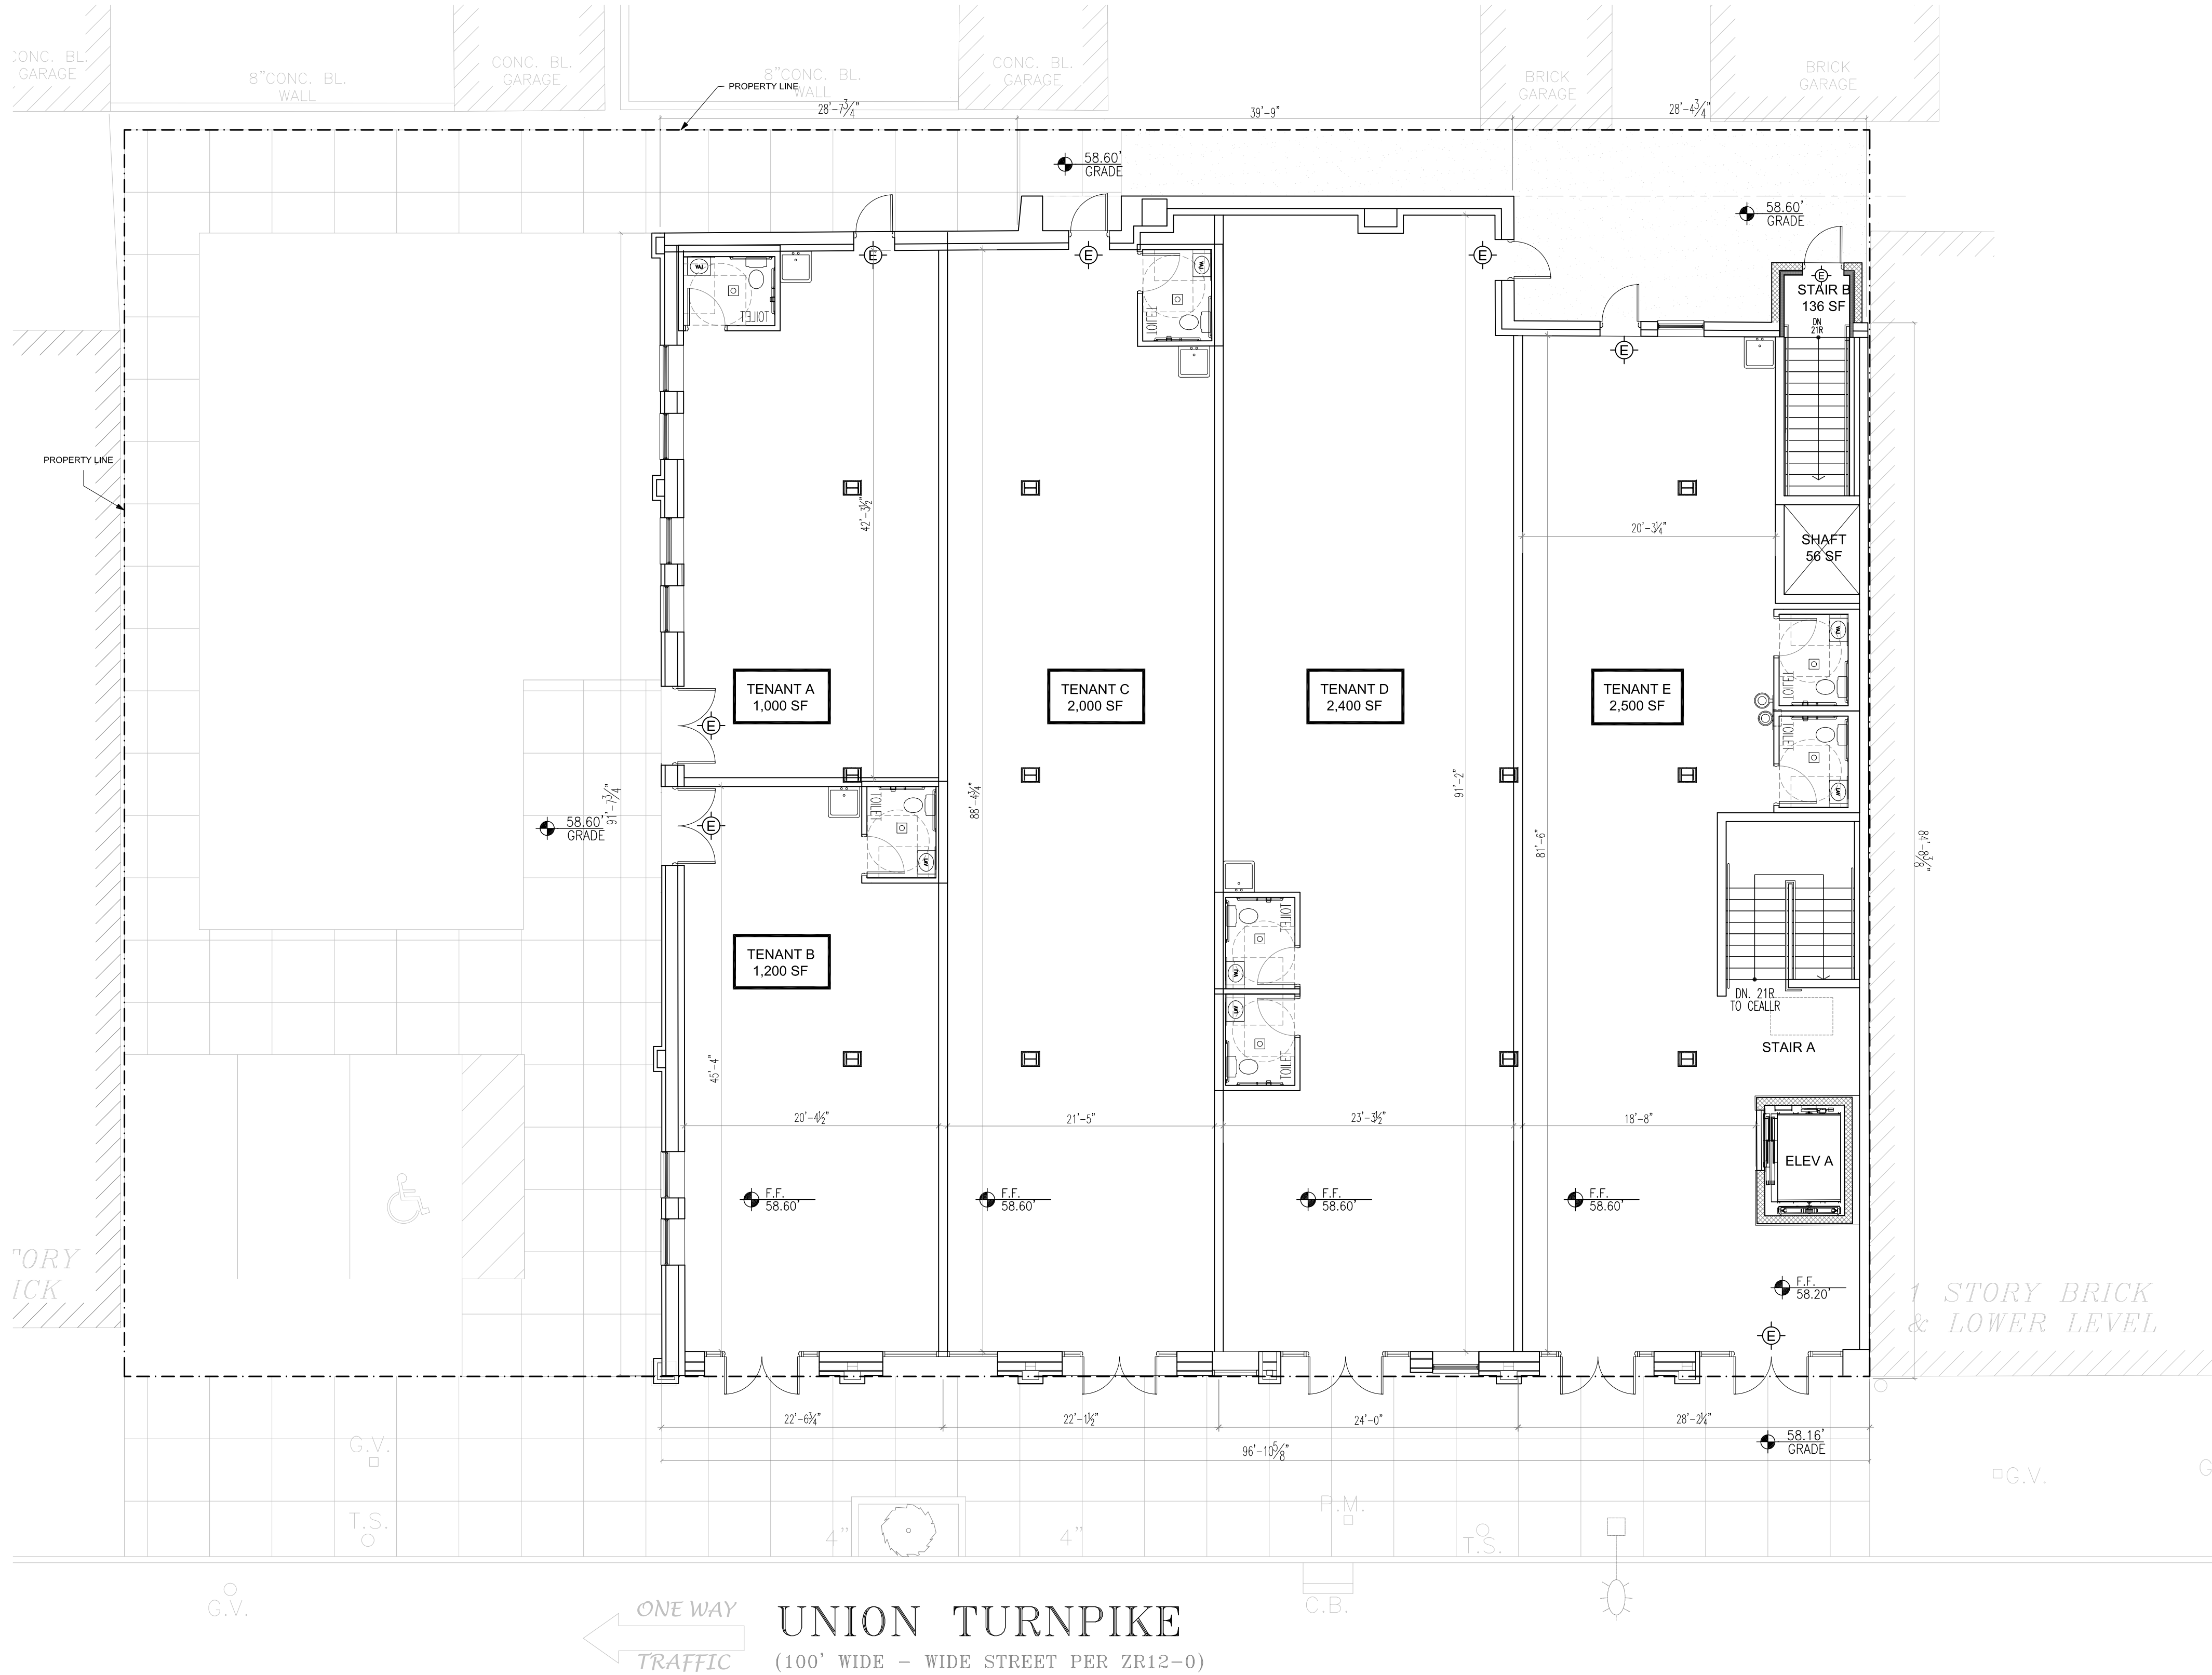


NOTE: ENTIRE BUILDING TO BE FULLY SPRINKLERED. TO BE FILED UNDER SEPARATE APPLICATION

NOTE: ENTIRE BUILDING SHALL HAVE FIRE ALARM SYSTEM

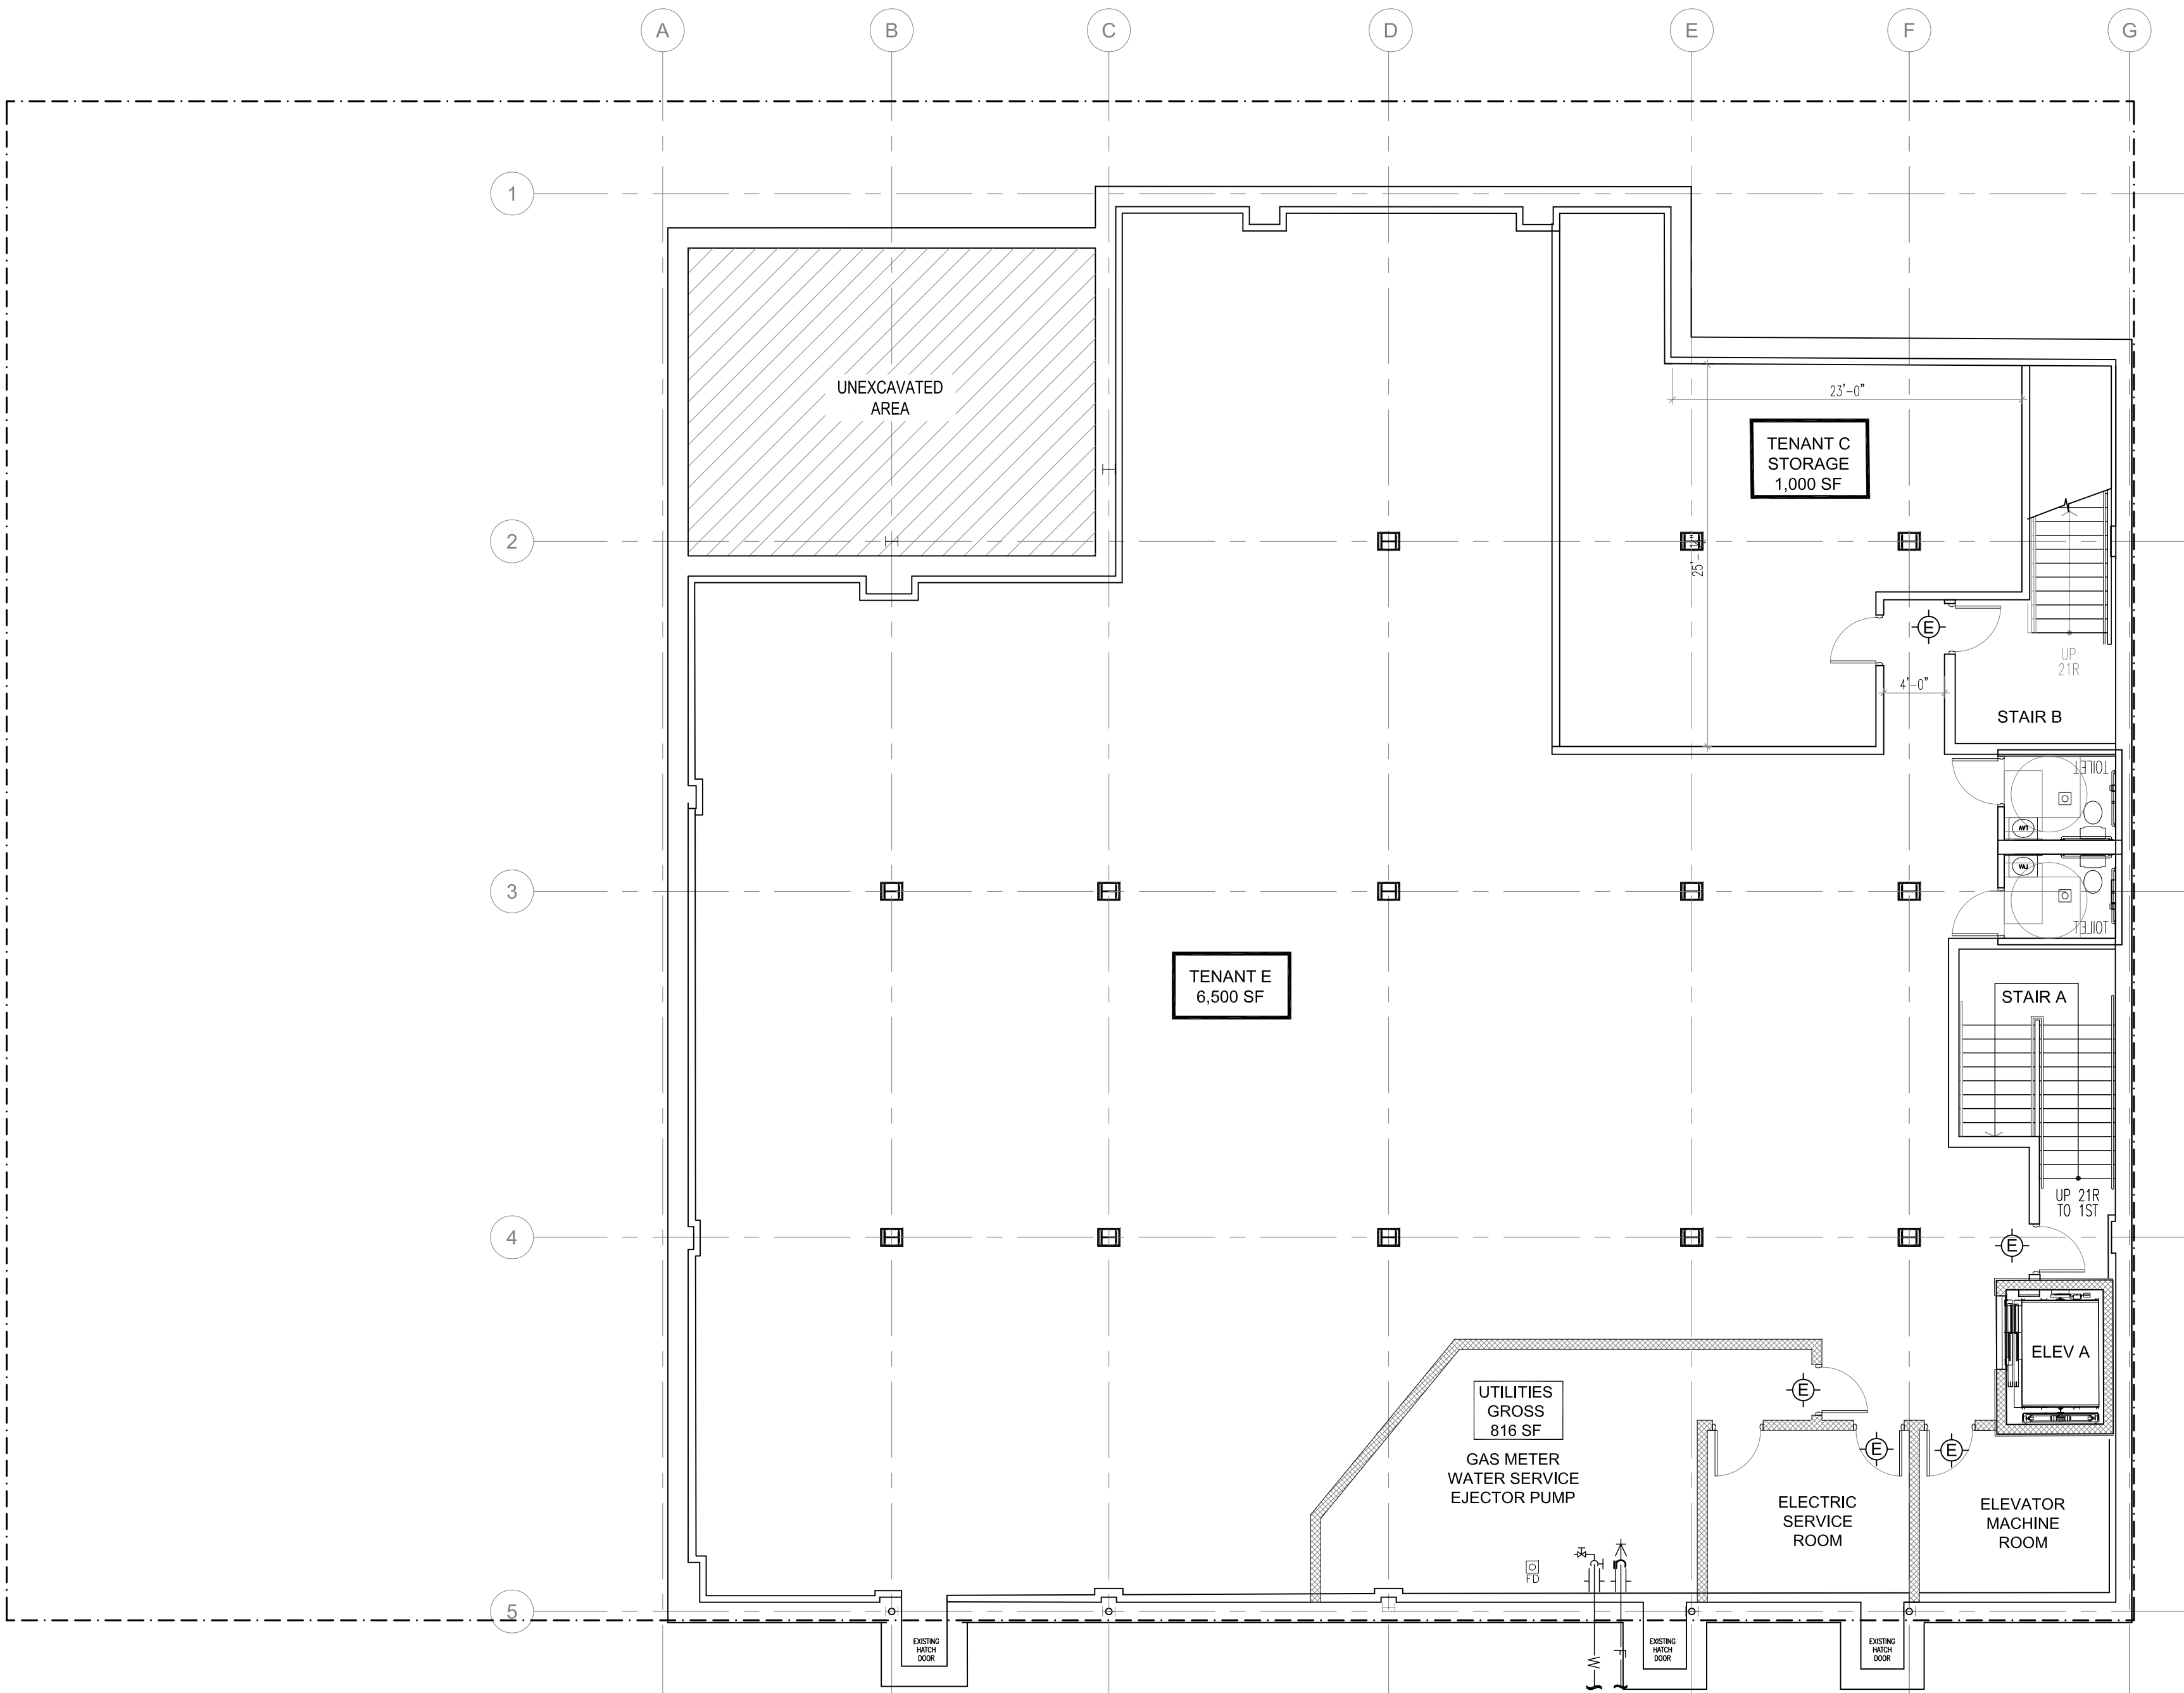

UNION TURNPIKE

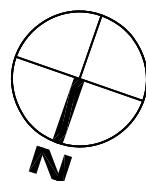

1 **CELLAR FLOOR PLAN**
SCALE: 1/8"=1'-0"

- KOH
ARCHITECTURE PLLC

87-10 NORTHERN BLVD, SUITE 204
JACKSON HEIGHTS, NY 11372
phone : (718) 225-6400

CONTACT INFO

CLIENT:
179 UNION CENTER,
LLC

ATTN: MEIR BABAEV
87-10 NORTHERN BLVD, SUITE 203
JACKSON HEIGHTS, NY 11372
TEL: 718-631-9000

ARCHITECT:
KOH
ARCHITECTURE, PLLC

ATTN: DINAH KLAMERT, R.A.
87-10 NORTHERN BLVD SUITE 204
JACKSON HEIGHTS, NY 11372
TEL: 718-225-6400
E-MAIL: DINAHK@KOHARCH.COM

KOH ARCHITECTURE PLLC EXPRESSLY RESERVES ITS COMMON LAW COPYRIGHT AND OTHER PROPERTY RIGHTS TO THESE PLANS. ALL DESIGNS, SPECIFICATIONS AND DRAWINGS ARE THE PROPERTY OF KOH ARCHITECTURE PLLC WHICH ARE TO BE USED ONLY AS ISSUED FOR THIS PROJECT. THEY SHALL NOT BE USED ON ANY OTHER PROJECT IN FULL OR IN PART, WITHOUT FIRST OBTAINING THE EXPRESSED WRITTEN APPROVAL AND CONSENT OF KOH ARCHITECTURE PLLC. THESE DOCUMENTS SHALL NOT BE TRANSFERRED TO ANY UNAUTHORIZED THIRD PARTY WITHOUT THE SAME CONSENT.

BUILDING TO BE FULLY SPRINKLERED

NOTE:
ALL WORK SHALL COMPLY WITH LOCAL, MUNICIPAL, AND STATE CODES, ORDINANCES, ETC.
THE ARCHITECT IS NOT RESPONSIBLE FOR SITE SUPERVISION, SAFETY, OR CONSTRUCTION MEANS AND METHODS.

NO. SUBMISSIONS/ REV. DATE

NYC DOB NUMBER

Q005560771

PROJECT NAME:
179-24 UNION TURNPIKE
FRESH MEADOWS, NY 11366

BLOCK: 7229 LOT: 20

DRAWING TITLE
CELLAR FLOOR PLAN

DRAWING NO.
A-100.00

SEAL AND SIGNATURE

START DATE:

DRAWN BY: YS
CHK BY: DK

SHEET OF

NOTE: ENTIRE BUILDING TO BE FULLY SPRINKLERED. TO BE FILED UNDER SEPARATE APPLICATION

NOTE: ENTIRE BUILDING SHALL HAVE FIRE ALARM SYSTEM