

SQUARE FOOTAGE	
AREA	SQ FT
TOTAL AREA	6400

DOOR & WINDOW SCHEDULE		
MARK	SIZE	DESCRIPTION
①	36" X 80"	METAL FLUSH
②	36" X 80"	6 PANEL MASONITE INT GD
③	20' X 40'	TEMPERED GLASS SHOWER DOOR
④	12' X 16'	OVERHEAD METAL GARAGE DOOR
⑤		
⑥		
⑦	40' X 40'	SINGLE HUNG INSUL VINYL
⑧		


NOTE - GLAZING REQUIRED ON ALL WINDOW PANS WITHIN 18" OF FINISHED FLOOR, DOOR, TUB OR SHOWER AND ANY SOLID PANE OVER 9.60 FT. ALL GLASS SHALL BE LOW E.

ALL BEAMS TO COMPLY WITH:
2009 IRC TABLE R502.5 (1) & (2) HEADER & GIRDER SPANS


BUILDING NOTES:

WALLS WITHIN 2 FEET OF URINALS AND WATER CLOSETS SHALL HAVE A SMOOTH, HARD, NONABSORBENT SURFACE TO A HEIGHT OF 4 FEET ABOVE THE FLOOR AND EXCEPT FOR STRUCTURAL ELEMENTS, THE MATERIALS USED IN SUCH WALLS SHALL BE OF A TYPE THAT IS NOT ADVERSELY AFFECTED BY MOISTURE.

BO (CONSTRUCT ON TYPE) PREPARED BUILDING EXISTING METAL

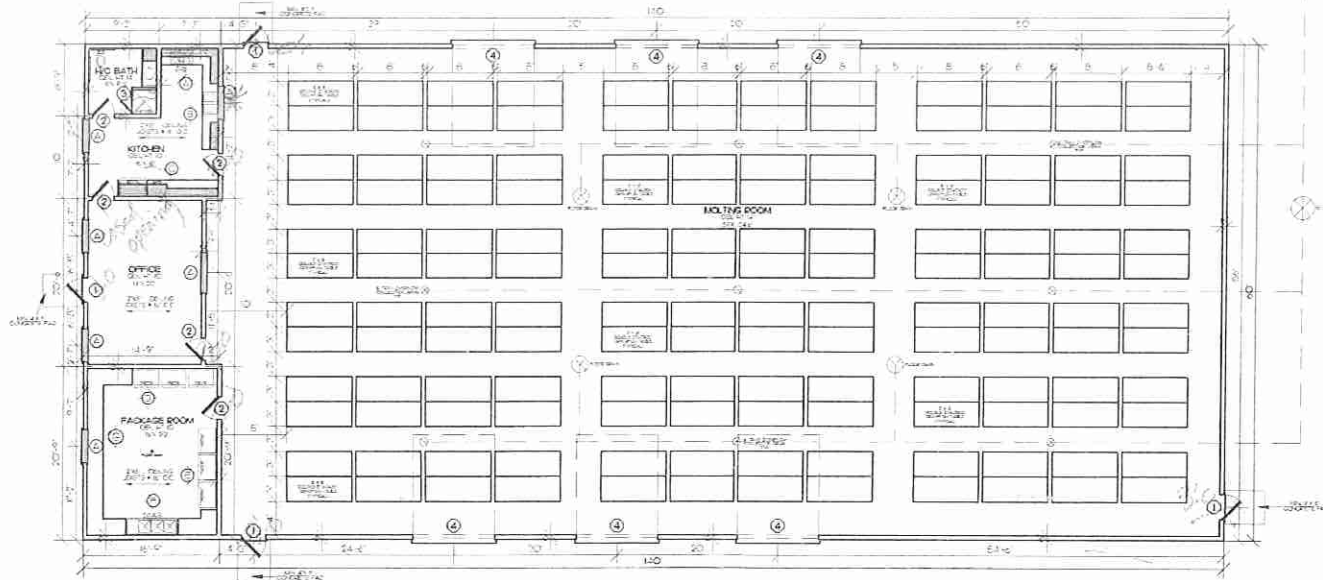

FLOOR PLAN
SCALE: 1/8" = 1'-0"
ALL ROOM DIMENSIONS ARE INSIDE TO INSIDE

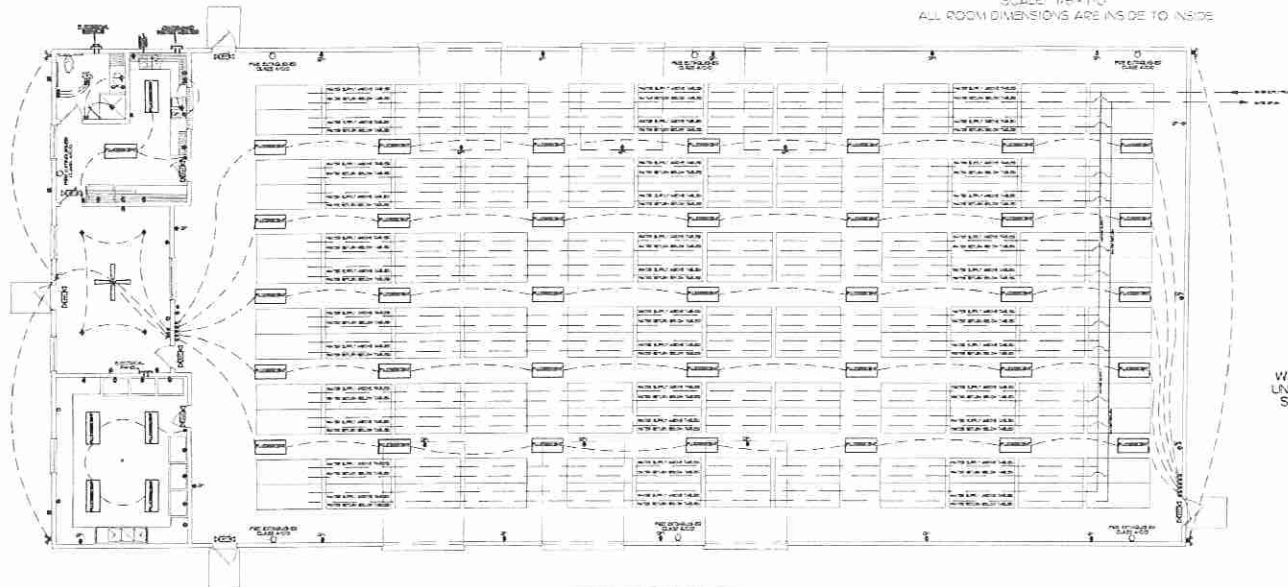

MECHANICAL PLAN
SCALE: 1/8" = 1'-0"

ELECTRICAL SCHEDULE	
MARK	DESCRIPTION
⊕	DUPLEX RECEPTACLE OUTLET
⊕	220 VOLT DUPLEX RECEPTACLE OUTLET
⊕	WATERPROOF RECEPTACLE OUTLET
⊕	WATERPROOF 220 VOLT OUTLET
⊕	EMERG LIGHT W/EXIT SIGN (BATT BACK)
⊕	SINGLE POLE SWITCH
⊕	DOUBLE POLE SWITCH
⊕	LIGHT OUTLET
⊕	FLOOD LIGHT
⊕	TELEPHONE
⊕	RECESSED SPOT
⊕	DOOR CHIME
⊕	TELEVISION
⊕	SMOKE ALARM
⊕	HEAT/VENT LIGHT
⊕	4" 2 BULB T8 FLUORESCENT LIGHT

ELECTRICAL NOTES

ELECTRICAL SERVICE TO BE 60 CIRCUIT 200 AMPERE
NON-LOCATED IN UTILITY

SERVICE TO BE 1/2" COPPER CONDUCTORS FROM METER TO PANEL
PANELS GROUNDED BY 2 #6 GROUNDING RODS OR REBAR
IN ACCORDANCE WITH SECT. 250 OF THE NATIONAL
ELECTRIC CODE

ALL EXTERIOR, GARAGE, KITCHEN, AND BATH CIRCUITS TO BE
GROUND FAULT CIRCUIT INTERRUPTER EQUIPPED.



SMOKE DETECTORS SHALL DETECT FOR SMOKE AND CARBON MONOXIDE
AND BE WIRED TOGETHER AND CONNECTED TO THE A.C. POWER SYSTEM

PLUMBING NOTES

CLEARANCE OF ALL HEAT PRODUCING APPLIANCES
TO BE GREATER THAN 18" ABOVE OR 6" TO THE SIDE

HEATING / AC NOTES

NO AIR CONDITIONING

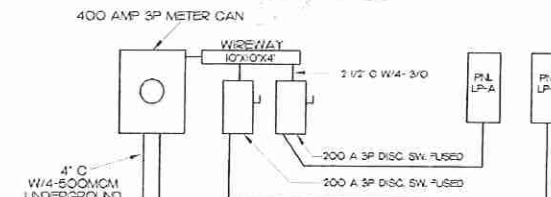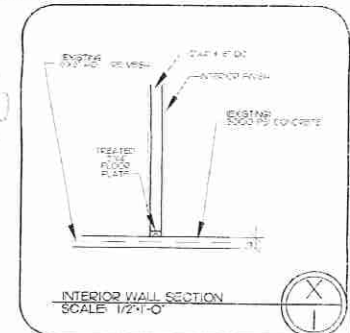

6400 SF.	
KVA	AMPS
GENERAL LIGHTING	4000
RECEPTACLES	1450
REFrigeration	1500
A/C & TDS	1000
HEAT PUMP	500
TOTAL KVA	8450

PANEL A				PANEL B			
200 AMP				200 AMP			
1	HEAT PUMP	A/C	2	HEAT PUMP	A/C	2	
3	REF	REF	4	REF	REF	4	
5	REF	REF	6	REF	REF	6	
7	REF	REF	8	REF	REF	8	
9	REF	REF	10	REF	REF	10	
11	REF	REF	12	REF	REF	12	
13	REF	REF	14	REF	REF	14	
15	REF	REF	16	REF	REF	16	
17	REF	REF	18	REF	REF	18	
19	REF	REF	20	REF	REF	20	
21	REF	REF	22	REF	REF	22	
23	REF	REF	24	REF	REF	24	



ACADIANA HOME
DESIGN LLC.
DESIGNER
3500 PINEAPPLE AVENUE
BAYTOWN, LOUISIANA 70511
ACADIANA DESIGN
OFFICE: 225-333-7777
FAX: 225-333-7777
TOLL FREE: 1-888-155-1001



ACADIANA HOME
DESIGN LLC.
DESIGNER
3500 PINEAPPLE AVENUE
BAYTOWN, LOUISIANA 70511
ACADIANA DESIGN
OFFICE: 225-333-7777
FAX: 225-333-7777
TOLL FREE: 1-888-155-1001

IMPORTANT NOTE

THIS SET OF PLANS AND SPECIFICATIONS IS THE PROPERTY OF ACADIANA DESIGN. IT IS TO BE USED ONLY FOR THE PROJECT AND SITE SPECIFICALLY IDENTIFIED HEREON. IT IS NOT TO BE REPRODUCED, COPIED, OR TRANSMITTED IN ANY FORM OR BY ANY MEANS, ELECTRONIC OR MECHANICAL, INCLUDING PHOTOCOPYING, RECORDING, OR BY ANY INFORMATION STORAGE AND RETRIEVAL SYSTEM, WITHOUT THE WRITTEN PERMISSION OF ACADIANA DESIGN.

PROJECT NAME
HUE PHAM Crawfish Facility
LOT 16, CO-MAR COMMERCE CENTER
WALKER, LA



DRAWN BY
AHD
DATE
2/13

SHEET NO
1
PROJECT NO
213024