



FLOOR PLAN

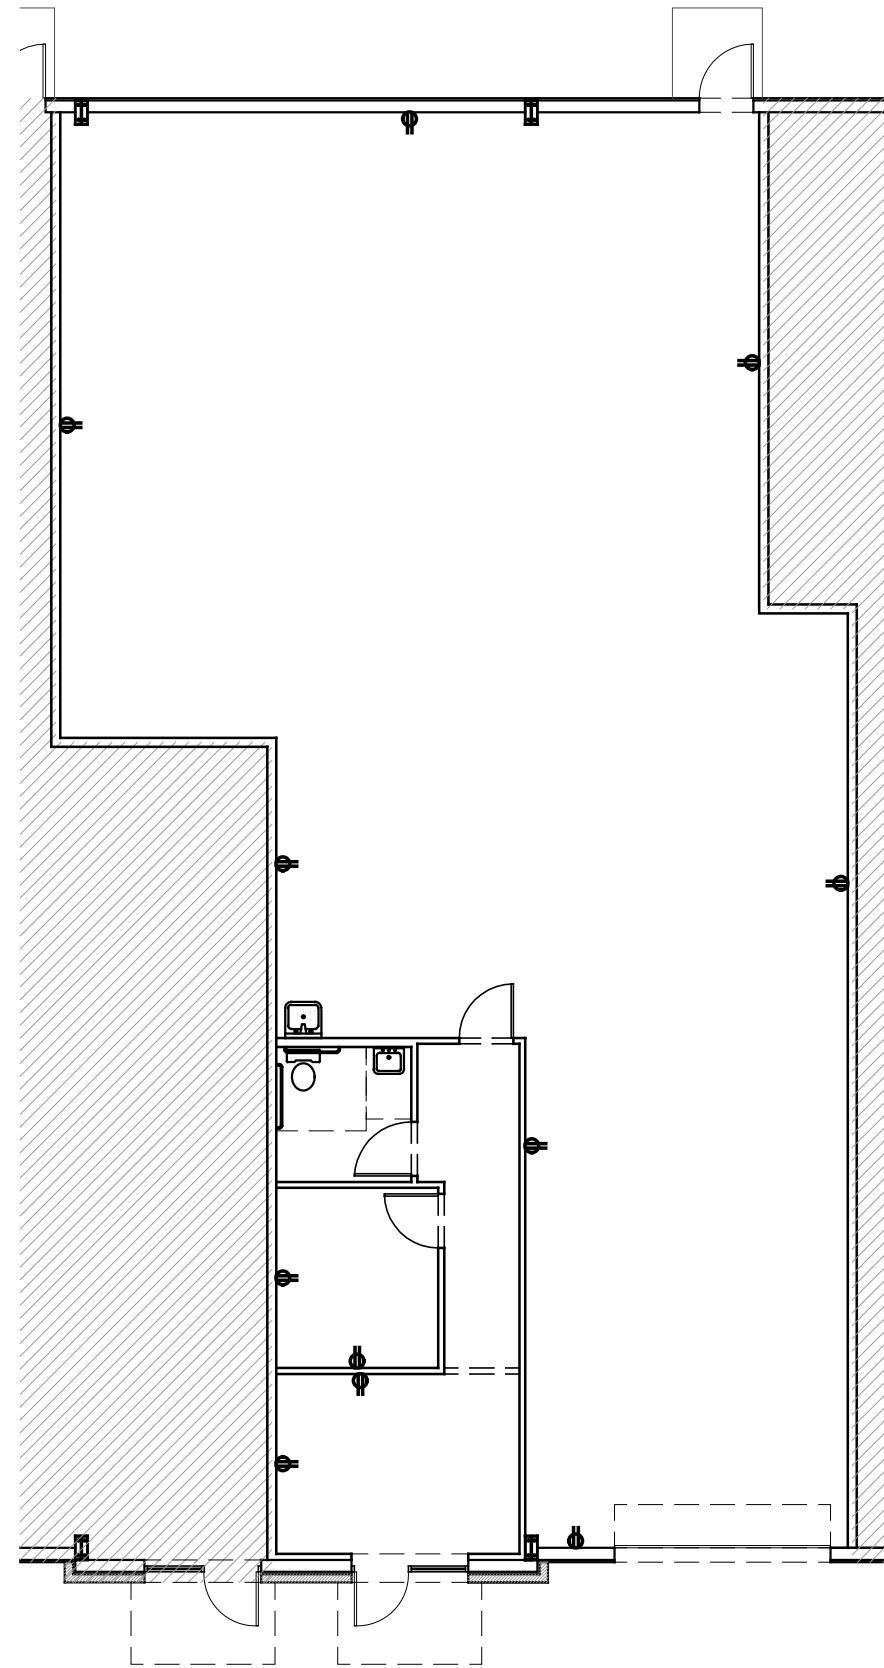

ELECTRICAL PLAN

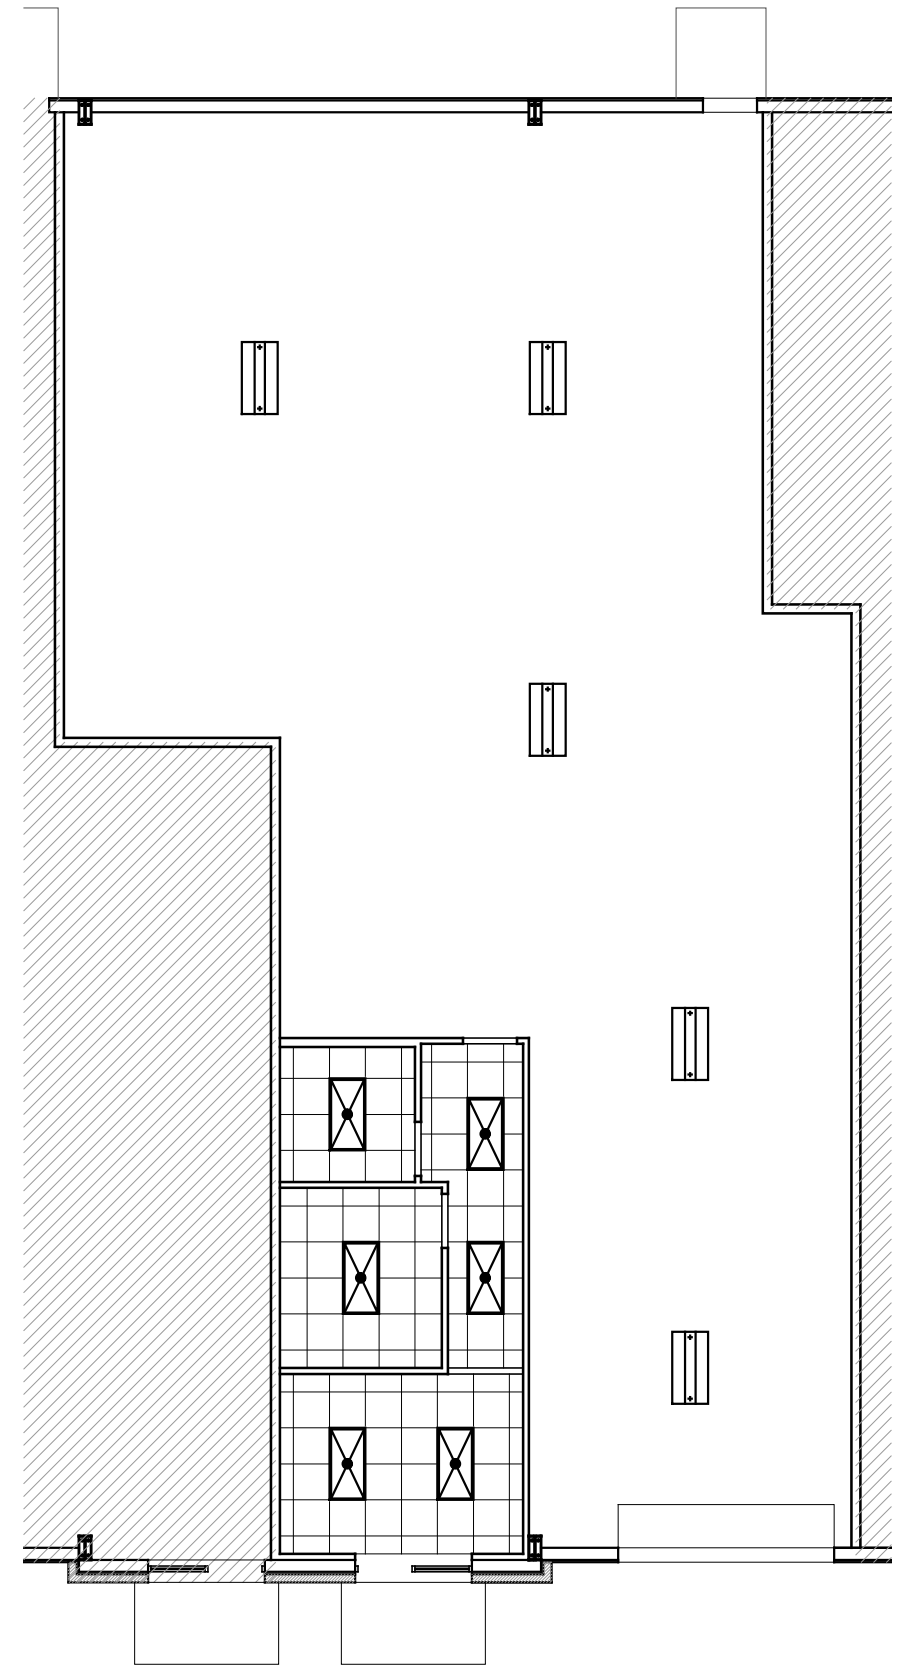

REFLECTED CEILING PLAN

**315 ODYSSEY SUITE C**  
 PROPOSED STANDARD LAYOUT  
 2930 S.F. GROSS LEASABLE AREA  
 SCALE: 3/32" = 1'-0"