


JOB NO. 16-114  
**RPJ, Inc.**  
 Mechanical/Electrical Consulting Engineers  
 STATE OF FL. LICENSE NO. (00000013) P.E. NO. (61930)  
 4977 S.W. 74th COURT  
 MIAMI, FL 33155  
 PHONE: (305) 666-2131 FAX: (305) 666-0131  
 E-MAIL: rj@rpj.com

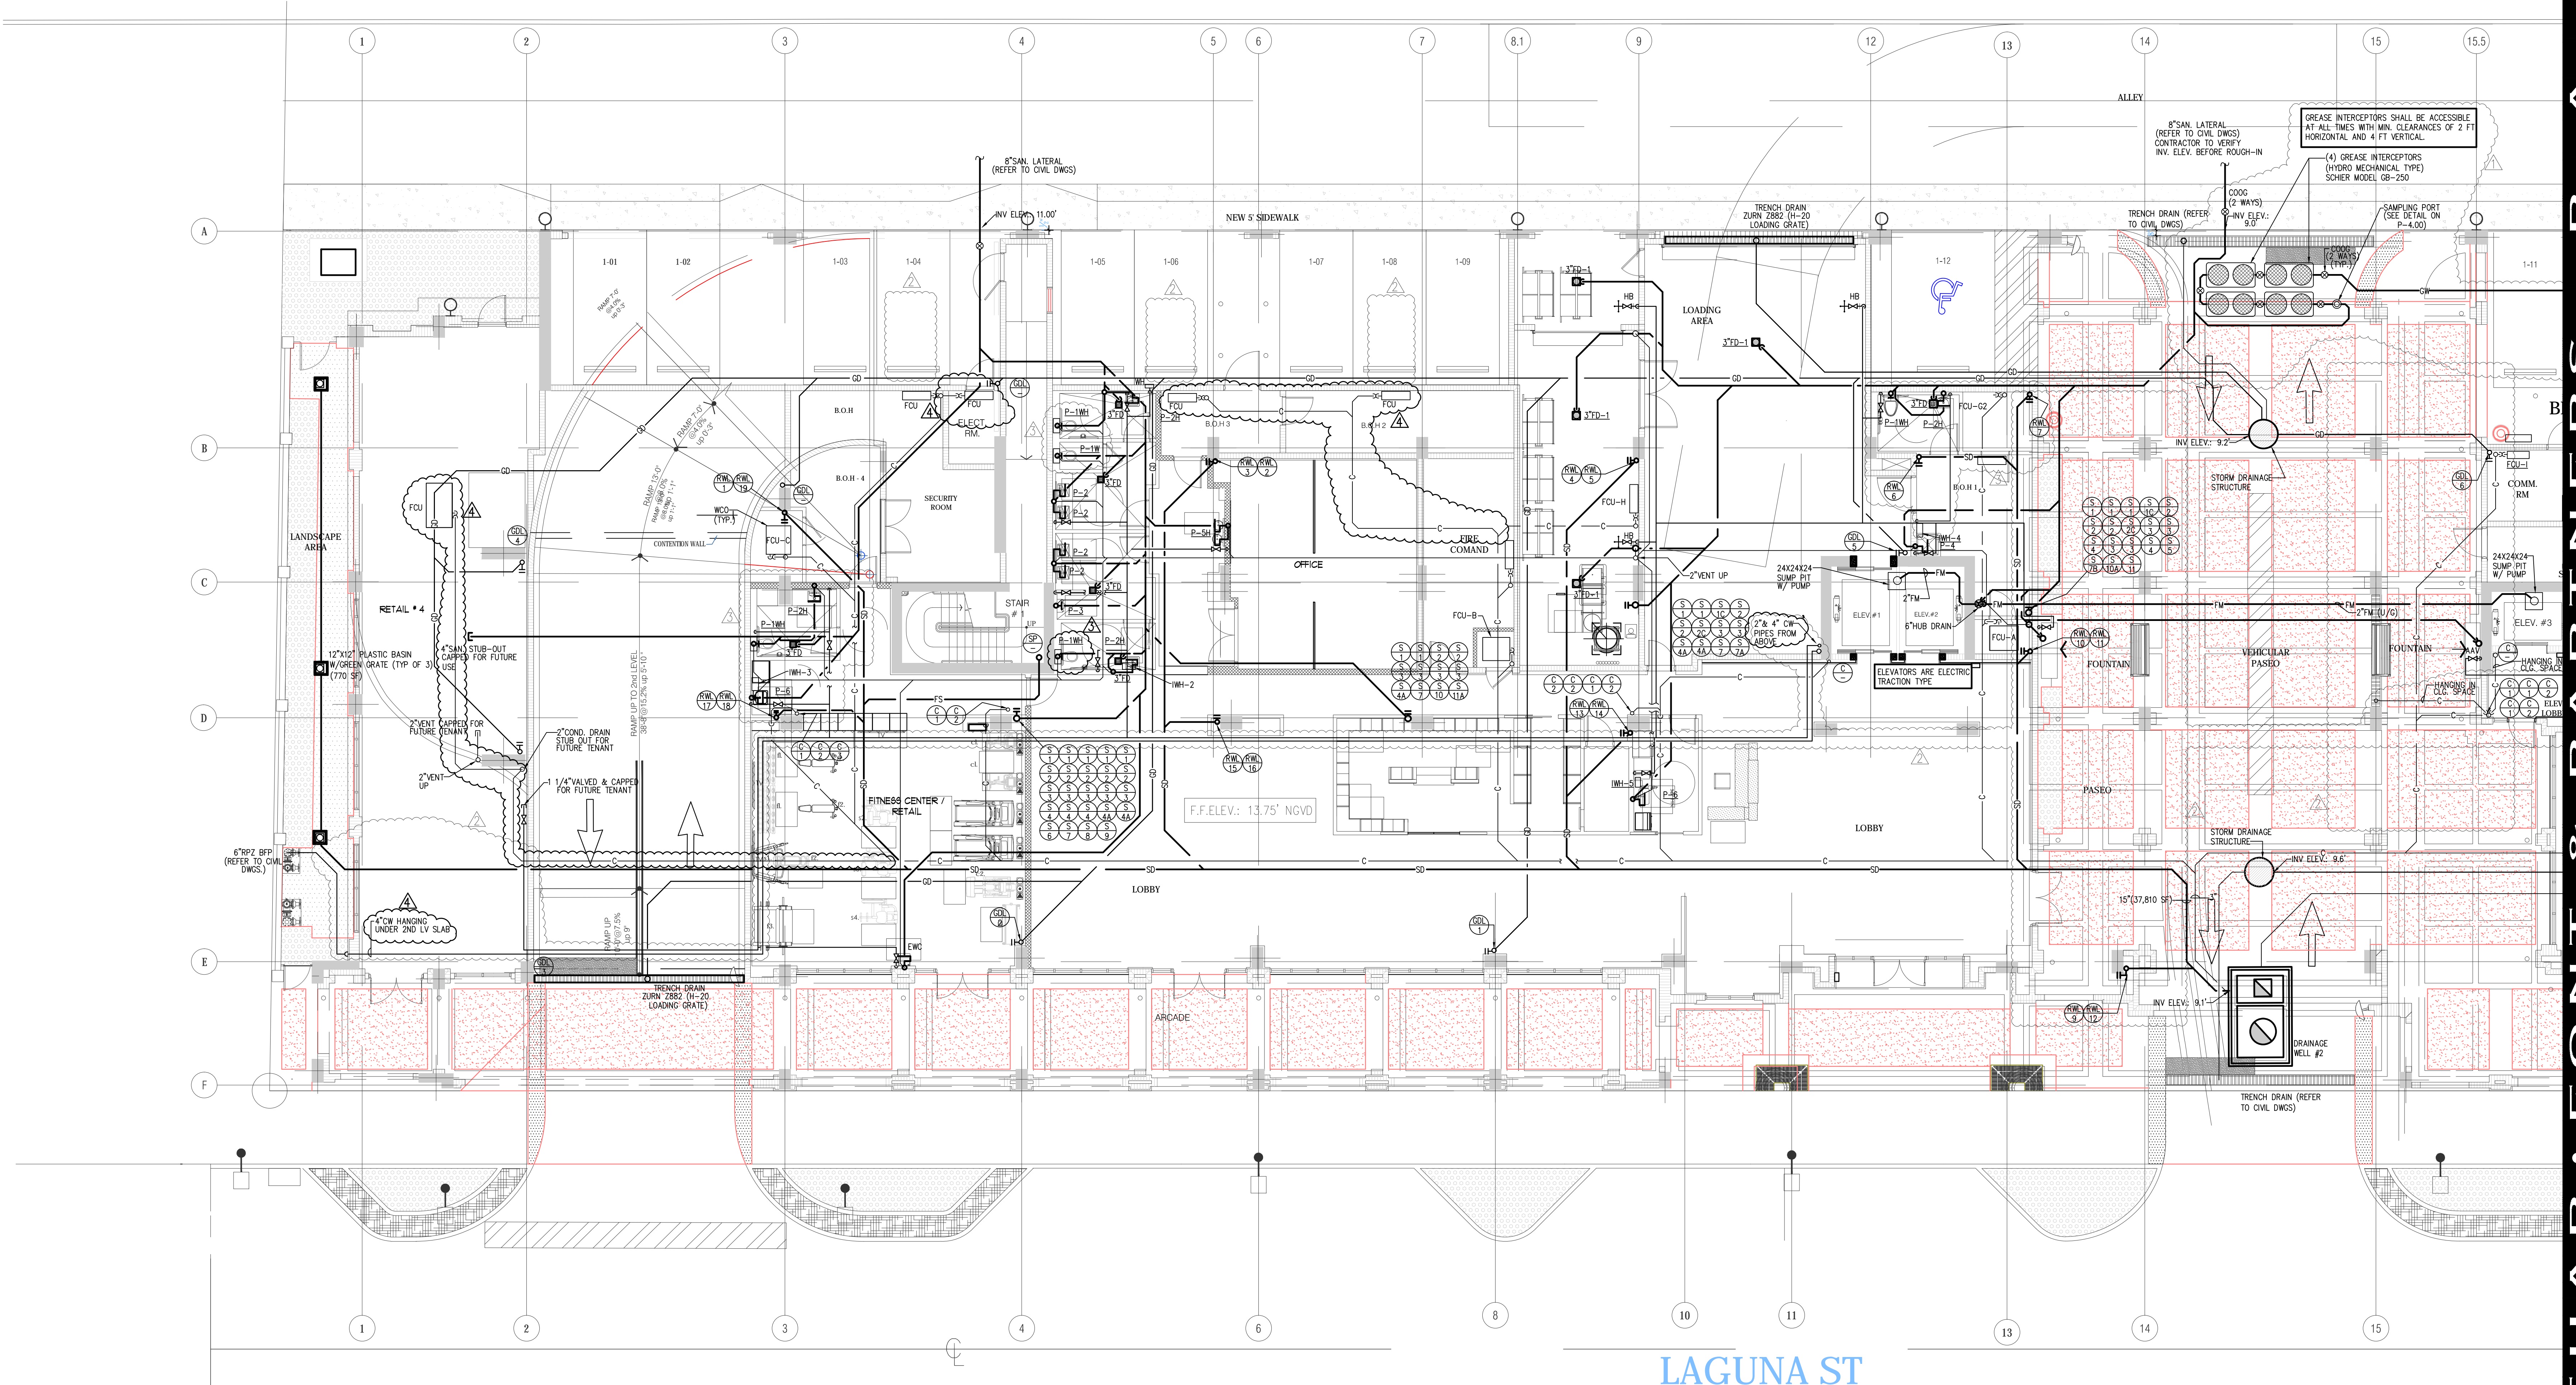

PARTIAL GROUND FLOOR PLAN-PLUMBING  
 SCALE: 1/8" = 1'-0"

LAGUNA ST

THESE PLANS ARE FOR BUILDING DEPARTMENT REVIEW ONLY. THEY ARE NOT TO BE CONSIDERED AS CONSTRUCTION DOCUMENTS UNTIL ALL BUILDING DEPARTMENT APPROVALS ARE OBTAINED.  
 NO COPIES, REPRODUCTIONS, TRANSMISSIONS OR ELECTRONIC TRANSMISSIONS OF ANY PORTION OF THESE DRAWINGS IN WHOLE OR IN PART ARE TO BE MADE WITHOUT THE EXPRESS WRITTEN PERMISSION OF BEHAR FONT & PARTNERS P.L.L.C. ALL RIGHTS RESERVED. © 2018.

BEHAR • FONT & PARTNERS • P . A .