

LAMP NEW OFFICE
RENOVATION
207 W. PINE ST.
PONCHATOULA, LA 70454

LAMP
DESIGN+BUILD

475 SW RAILROAD
AVE.
PONCHATOULA, LA.
70454
(985) 386-9212

NOT
FOR
CONSTRUCTION

REVISIONS:


DATE: 07/15/20

SHEET NO

A101

SUITE 1
2,200 sf

SUITE 2
2,150 sf

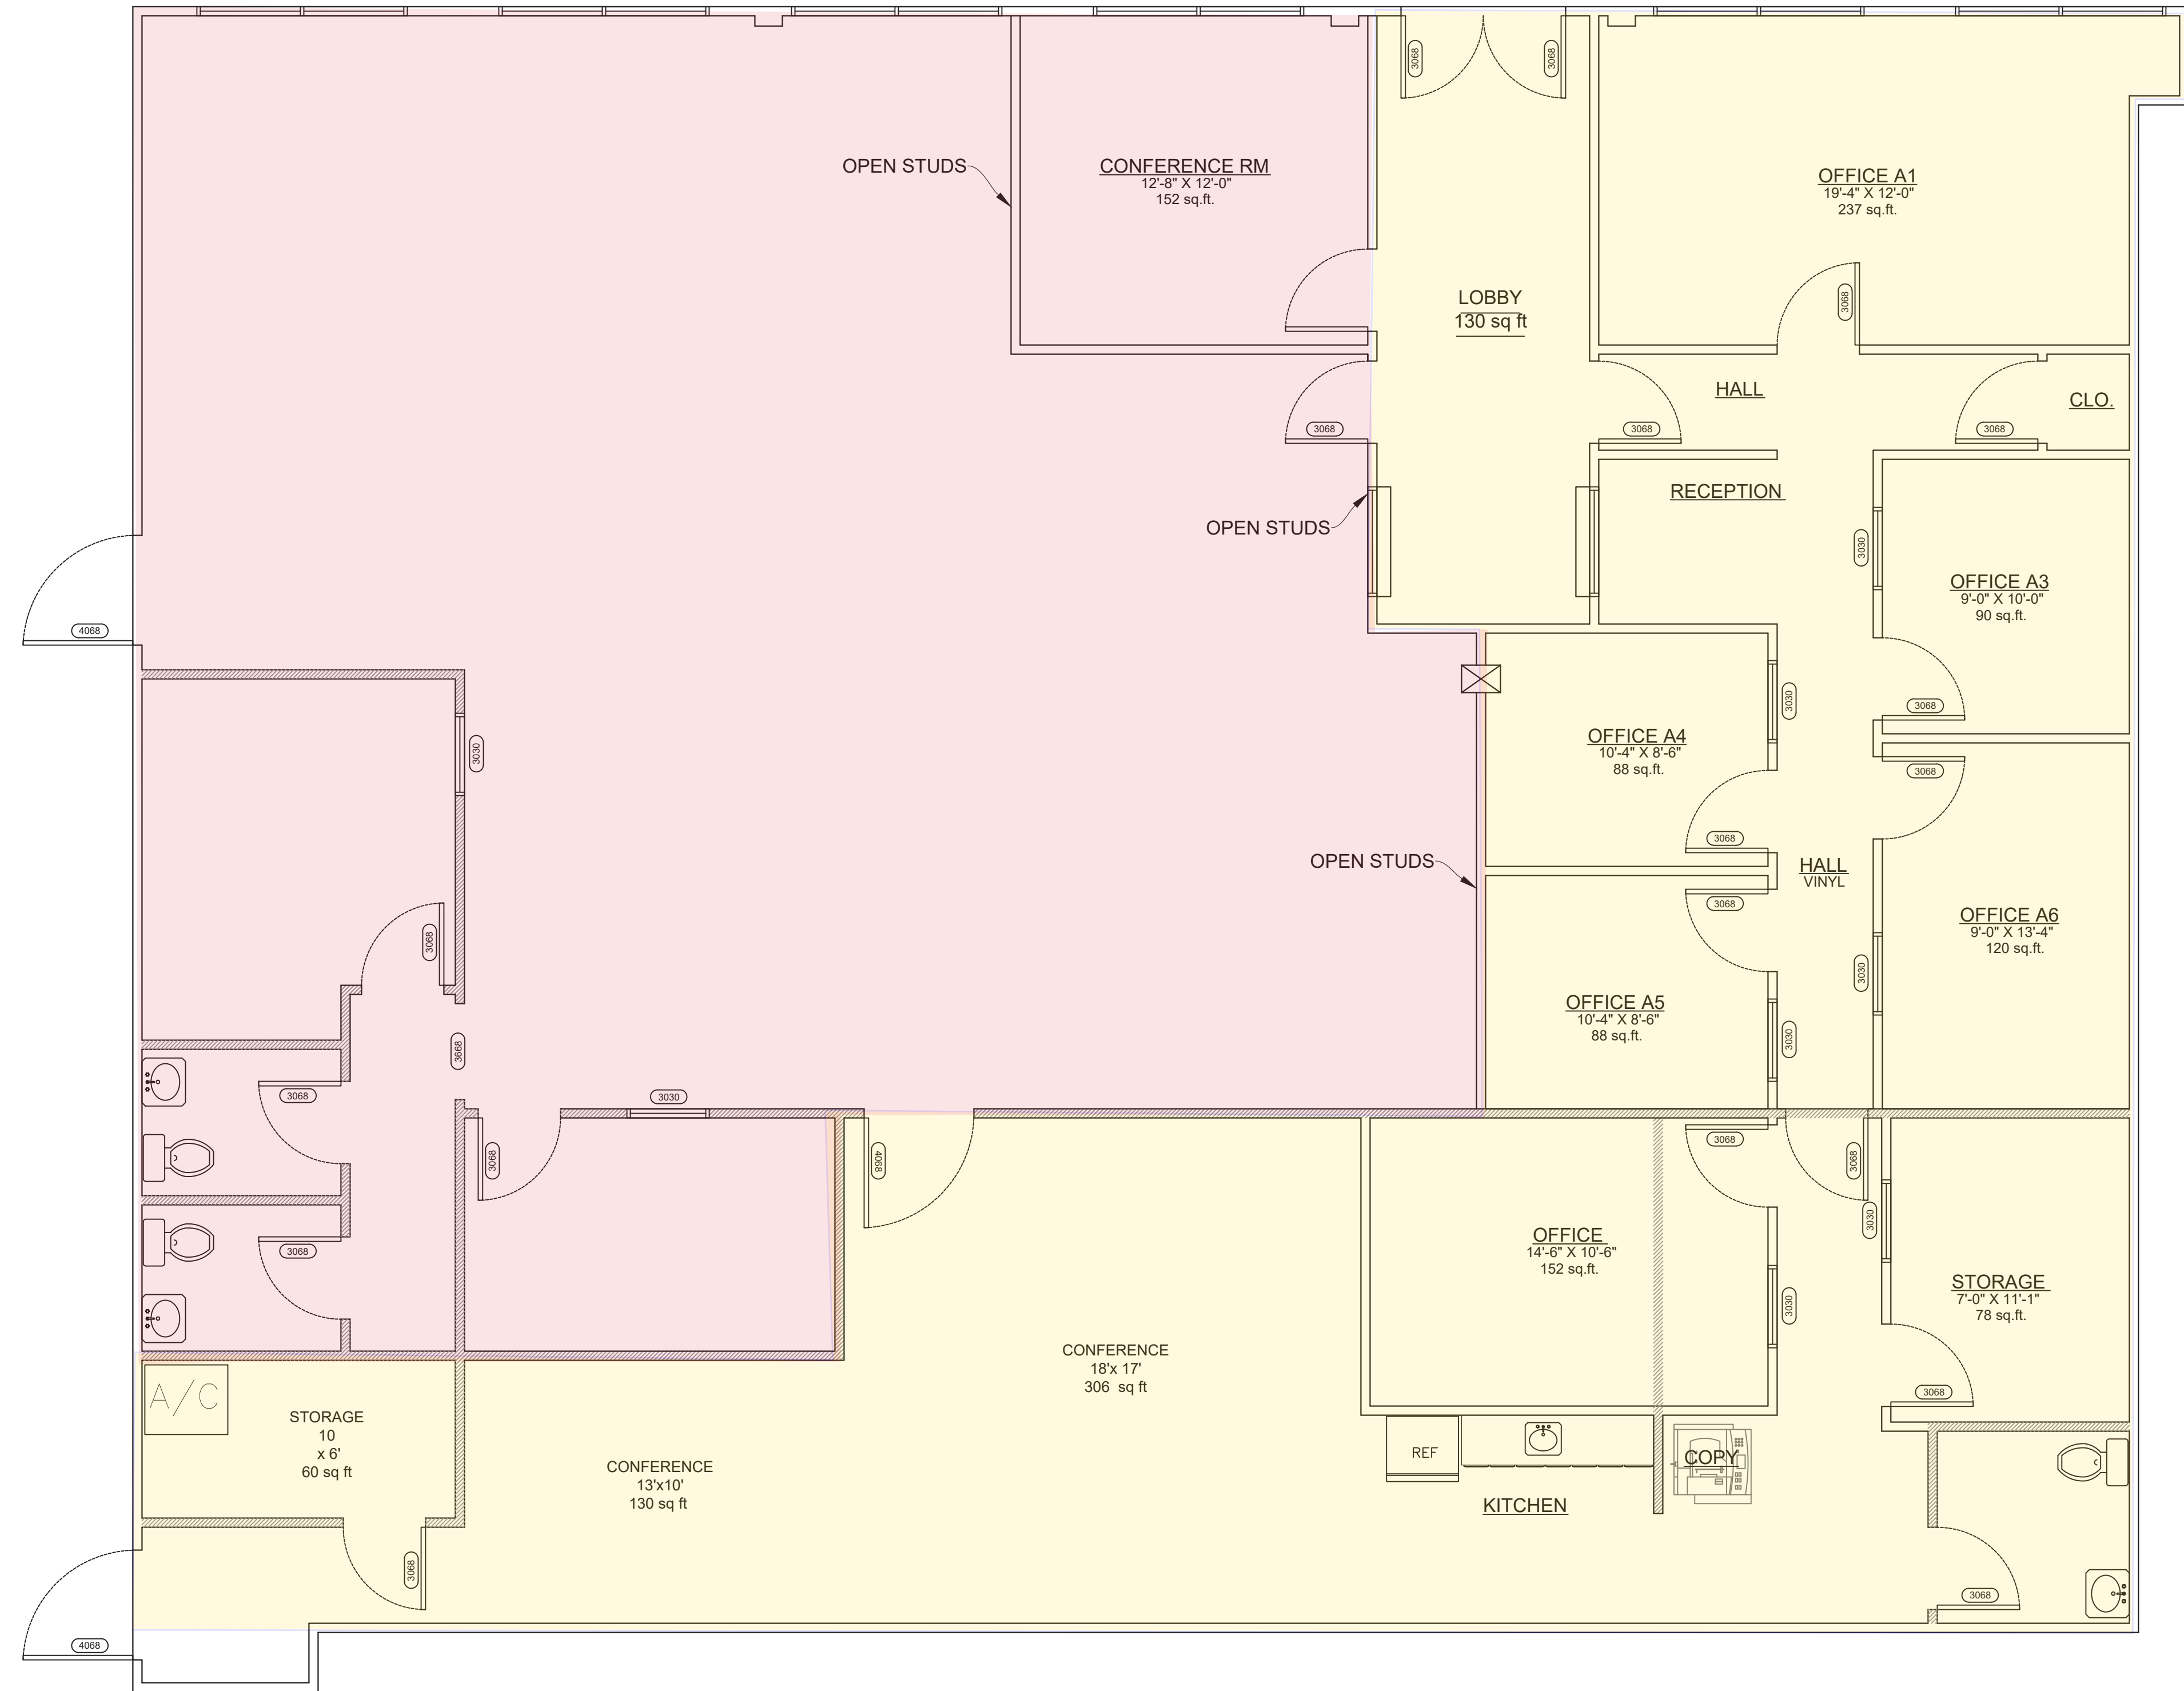

**NEW
FLOOR PLAN**

0' 2' 4' 6' 8' FULL SIZE: 1/4" = 1'-0"
1/2" SIZE: 1/8" = 1'-0"