

BOCK & PARTNERS
ARCHITECTURE


998 Lake Destiny Road, Altamonte Springs, FL 32714
Tel: 407.838.0500 Fax: 407.838.0600 AA-0003301

REVISIONS

- | | |
|----------|-----------------------|
| 09310.A1 | WINDOW WALL SYSTEM |
| 09310.A1 | WINDOW WALL |
| 09335.A1 | DIMENSION STONE TILE |
| 09335.A1 | granite tile polished |
| 09335 | SHEET CARPET |
| 09335.A1 | carpet |
| 09310 | PAINTING |
| 09310.A1 | Paint |
| 09341 | TEXTURED COATINGS |
| 09341.A1 | textured wall coating |

GENERAL NOTES

- | | |
|-------|------------------------------|
| 3.000 | STRUCTURAL |
| 3.003 | concrete floor slab on metal |
| 3.351 | deck up concrete wall panel |
| 4.000 | PLUMBING |
| 4.003 | plumbing riser |
| 4.055 | second story riser |

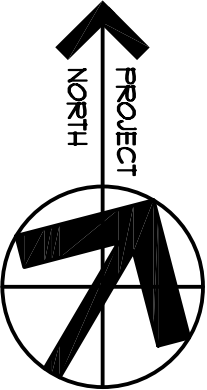

Key Plan / North Arrow



Project Name
Drawing Name
Drawing Number
A13

09310.A1	WINDOW WALL SYSTEM
09310.A1	WINDOW WALL
09335.A1	DIMENSION STONE TILE
09335.A1	granite tile polished
09335	SHEET CARPET
09335.A1	carpet
09310	PAINTING
09310.A1	Paint
09341	TEXTURED COATINGS
09341.A1	textured wall coating

09310.A1	WINDOW WALL SYSTEM
09310.A1	WINDOW WALL
09335.A1	DIMENSION STONE TILE
09335.A1	granite tile polished
09335	SHEET CARPET
09335.A1	carpet
09310	PAINTING
09310.A1	Paint
09341	TEXTURED COATINGS
09341.A1	textured wall coating

Project Name
Drawing Name
Drawing Number
A13

THIRD FLOOR
PLAN

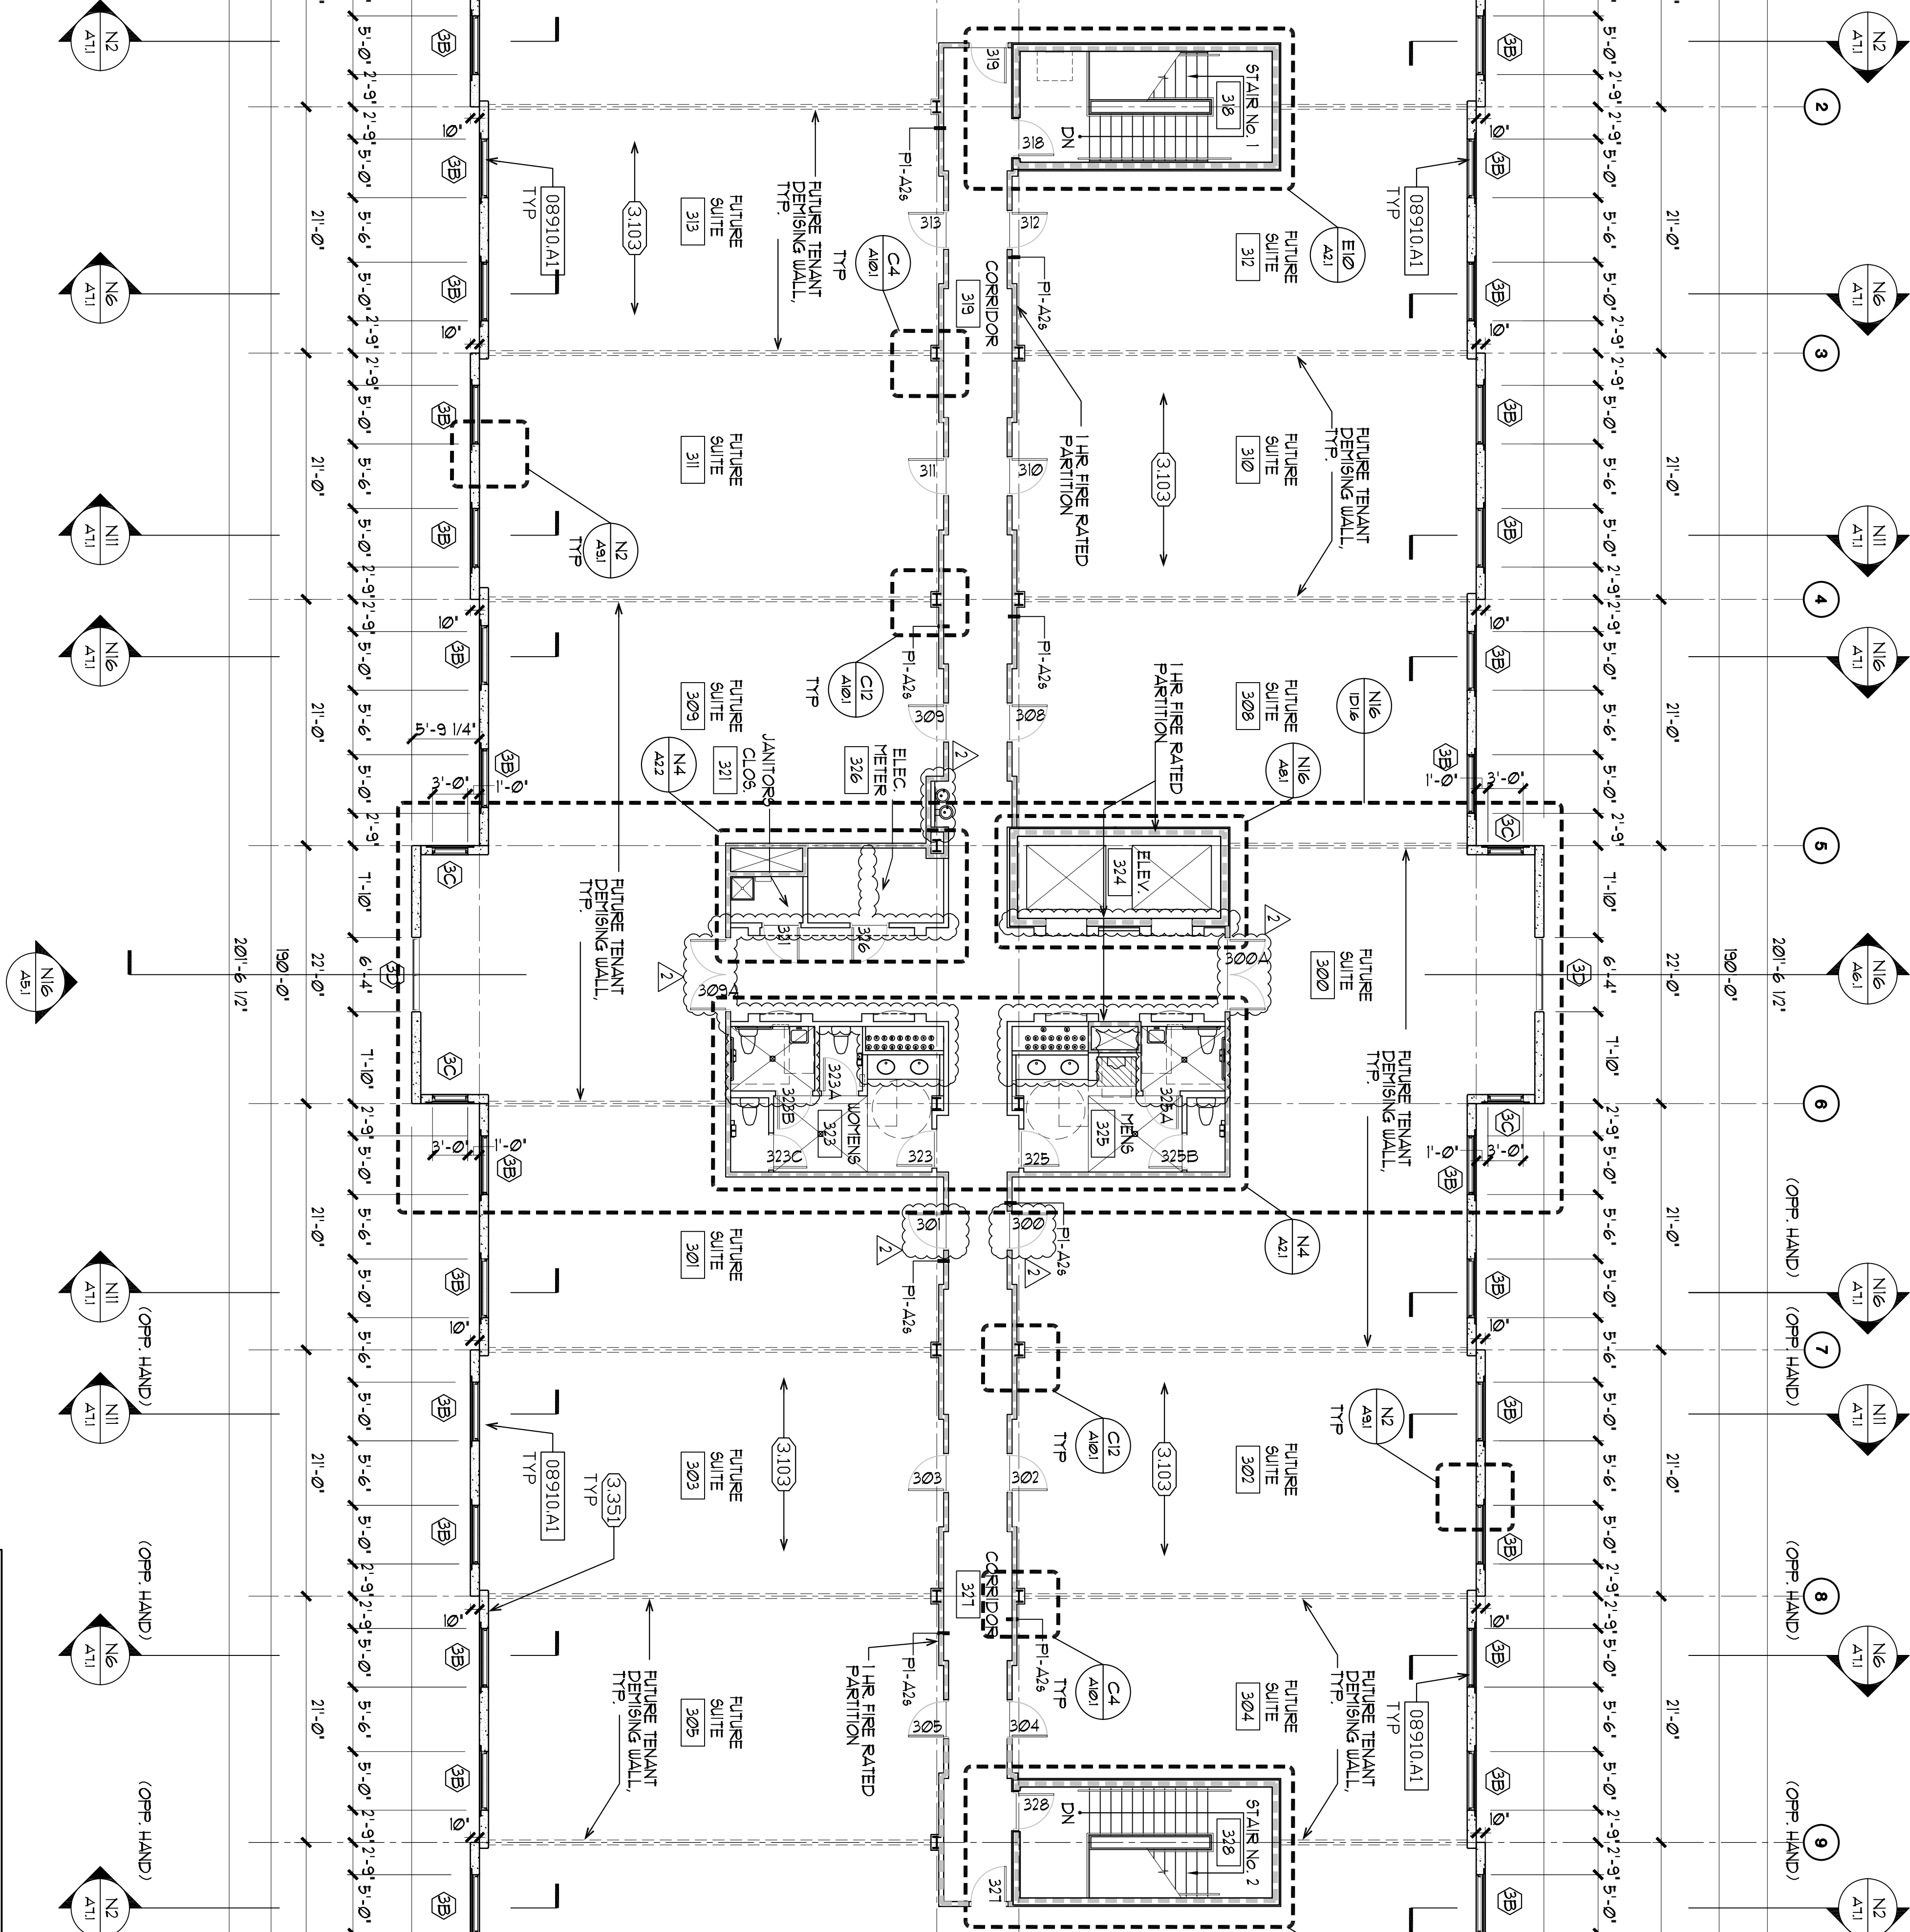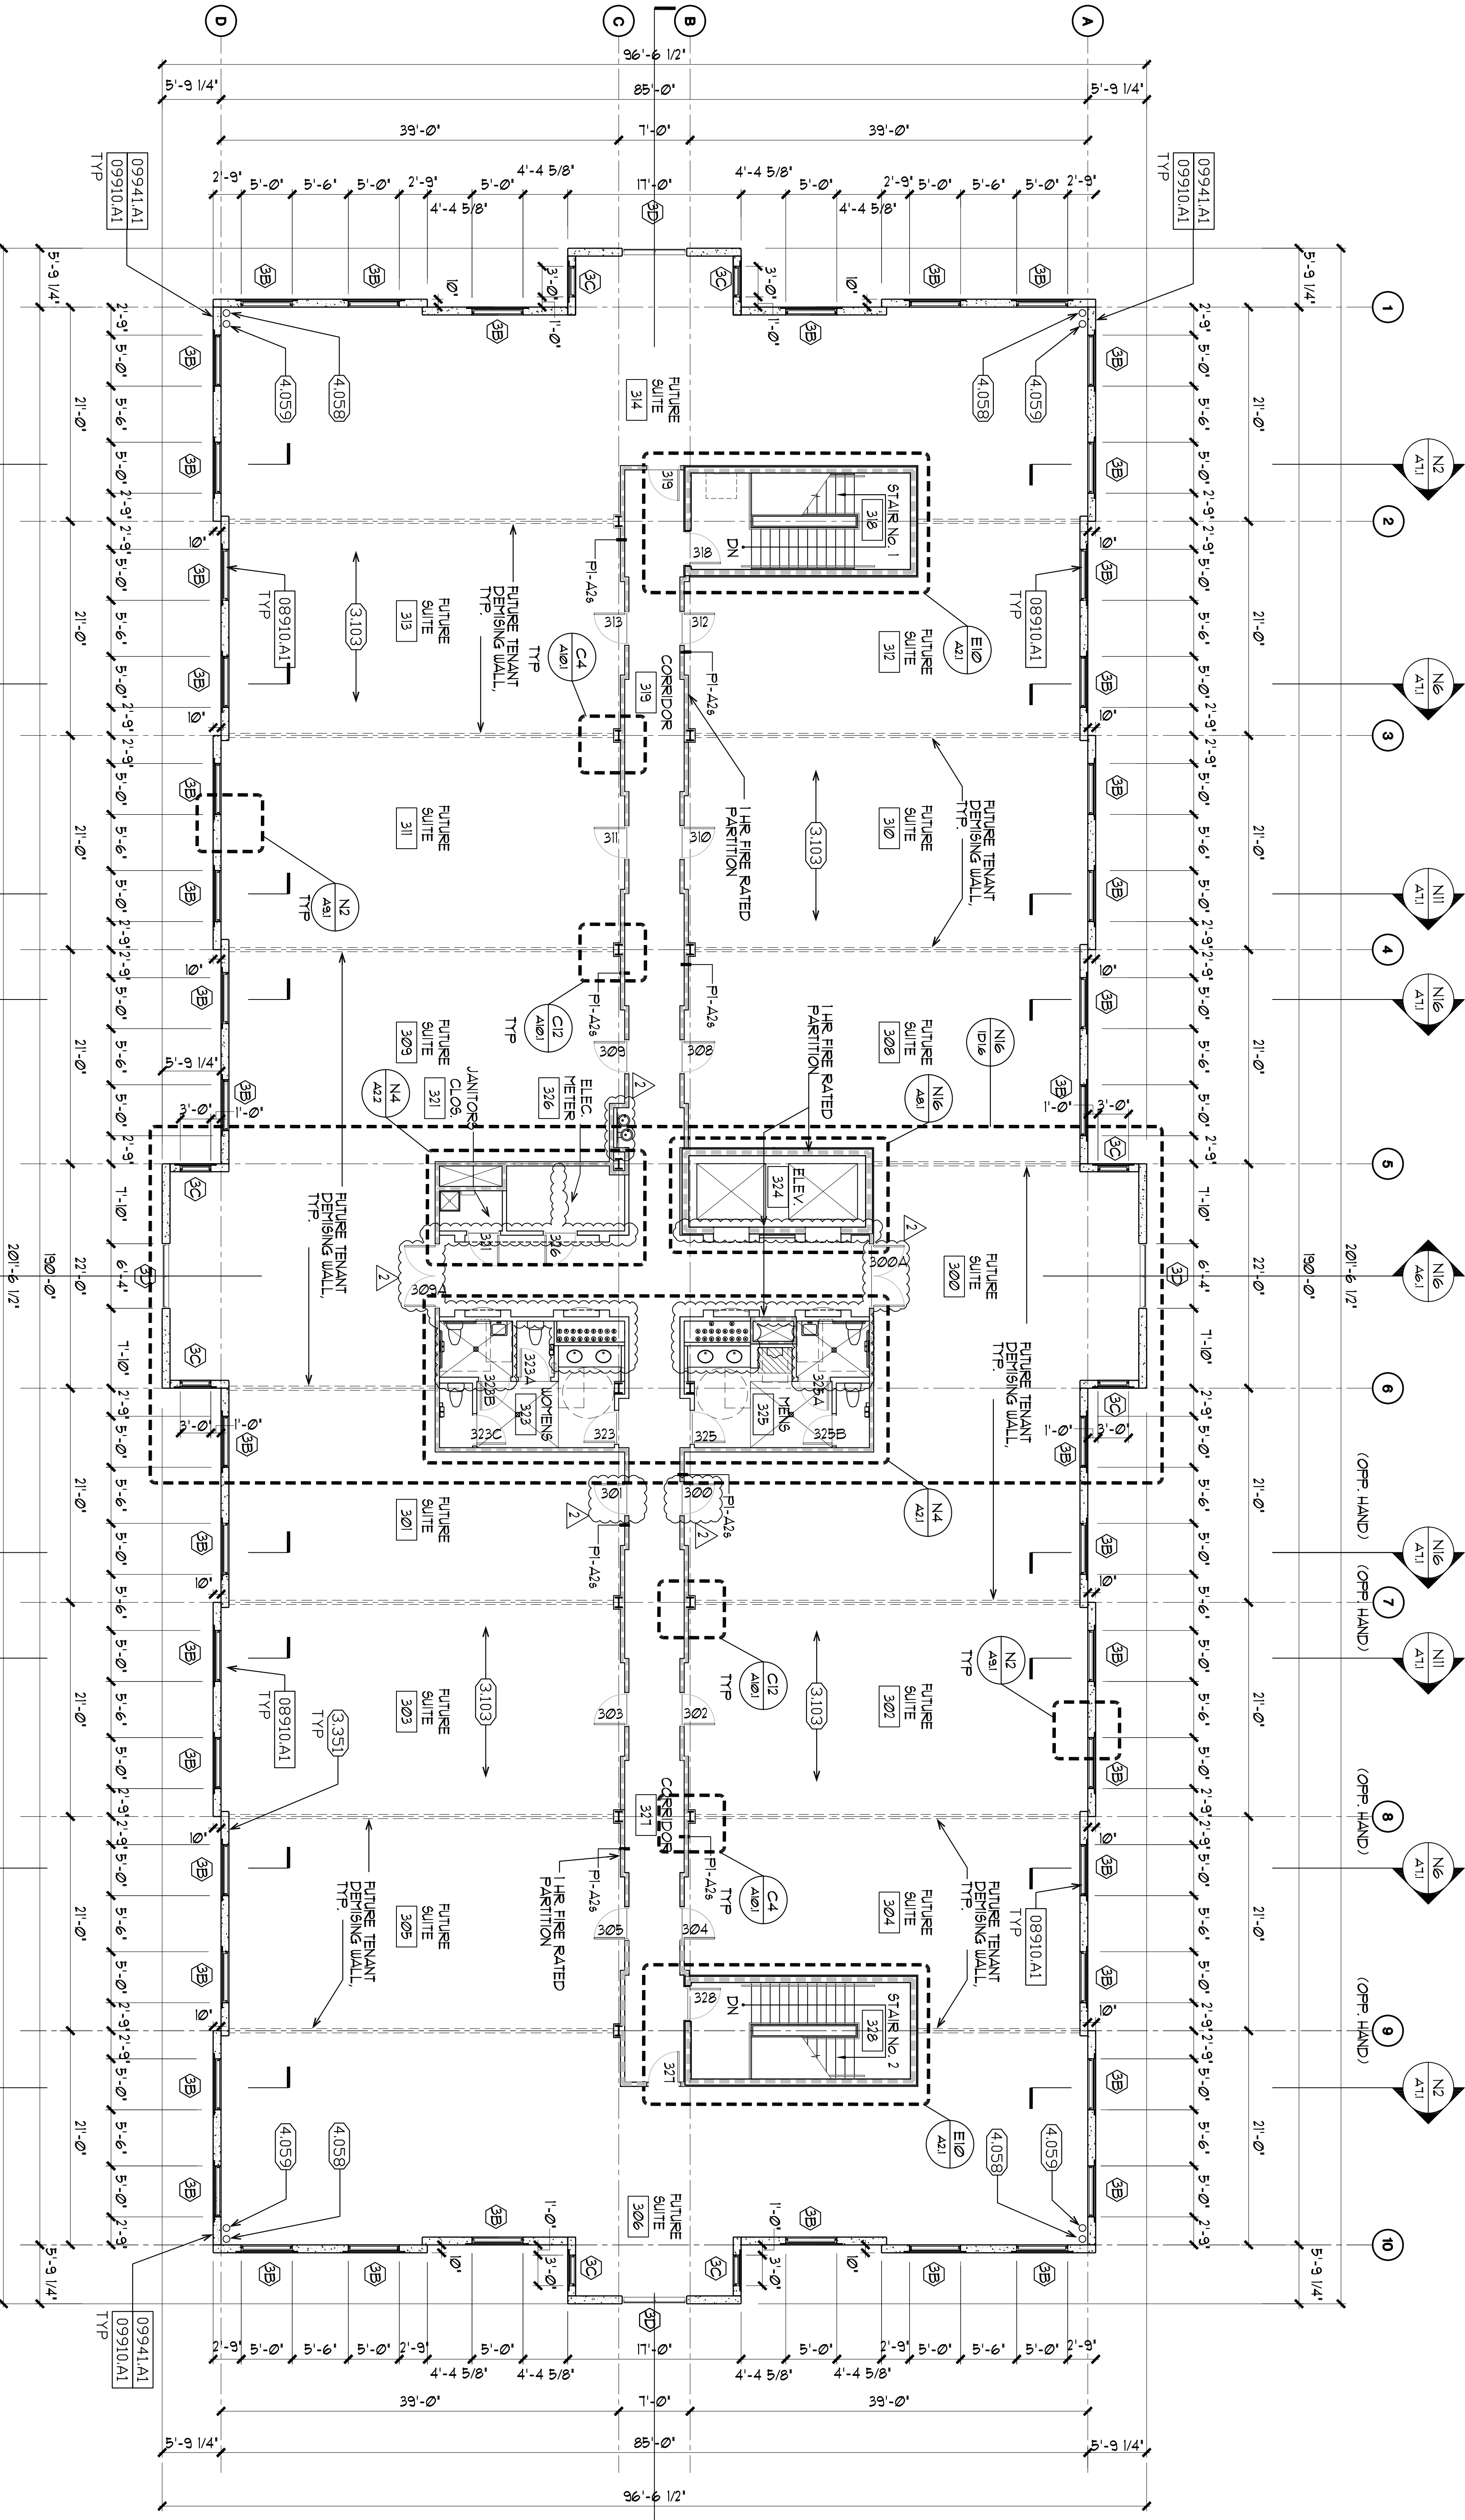

THIRD FLOOR PLAN

THIRD FLOOR
PLAN