


GENERAL NOTES:

- 1 - PROVIDE A 20A-3P-4W-GROUNDING-250V-3Ø RECEPTACLE, CORD, AND PLUG FOR CONNECTION OF THIS UNIT. RECEPTACLE SHALL BE SIMILAR TO ARROW-HART, HART-LOCK CAT. N° 6420. PLUG SHALL BE HART-LOCK CAT. N° 6421. PROVIDE REQUIRED LENGTH OF 4 CONDUCTOR CABLE.
- 2 - PROVIDE A 20A-2P-3W-GROUNDING-250V-1Ø RECEPTACLE, CORD, AND PLUG FOR CONNECTION OF THIS UNIT. RECEPTACLE SHALL BE SIMILAR TO ARROW-HART, HART-LOCK CAT. N° 6210. PLUG SHALL BE HART-LOCK CAT. N° 6211. PROVIDE REQUIRED LENGTH OF 3 CONDUCTOR CABLE.
- 3 - VERIFY MOUNTING HEIGHT OF RECEPTACLES IN THIS ROOM WITH THE ARCHITECT BEFORE ROUGHING IN FOR SAME.
- 4 - CIRCULATING PUMP-3HP-208V-3Ø. MANUAL CONTROL - ONE IS STANDBY.
- 5 - 2#12 UP TO PRE. SEE DWG. N° E-6 FOR FAN LOCATION.

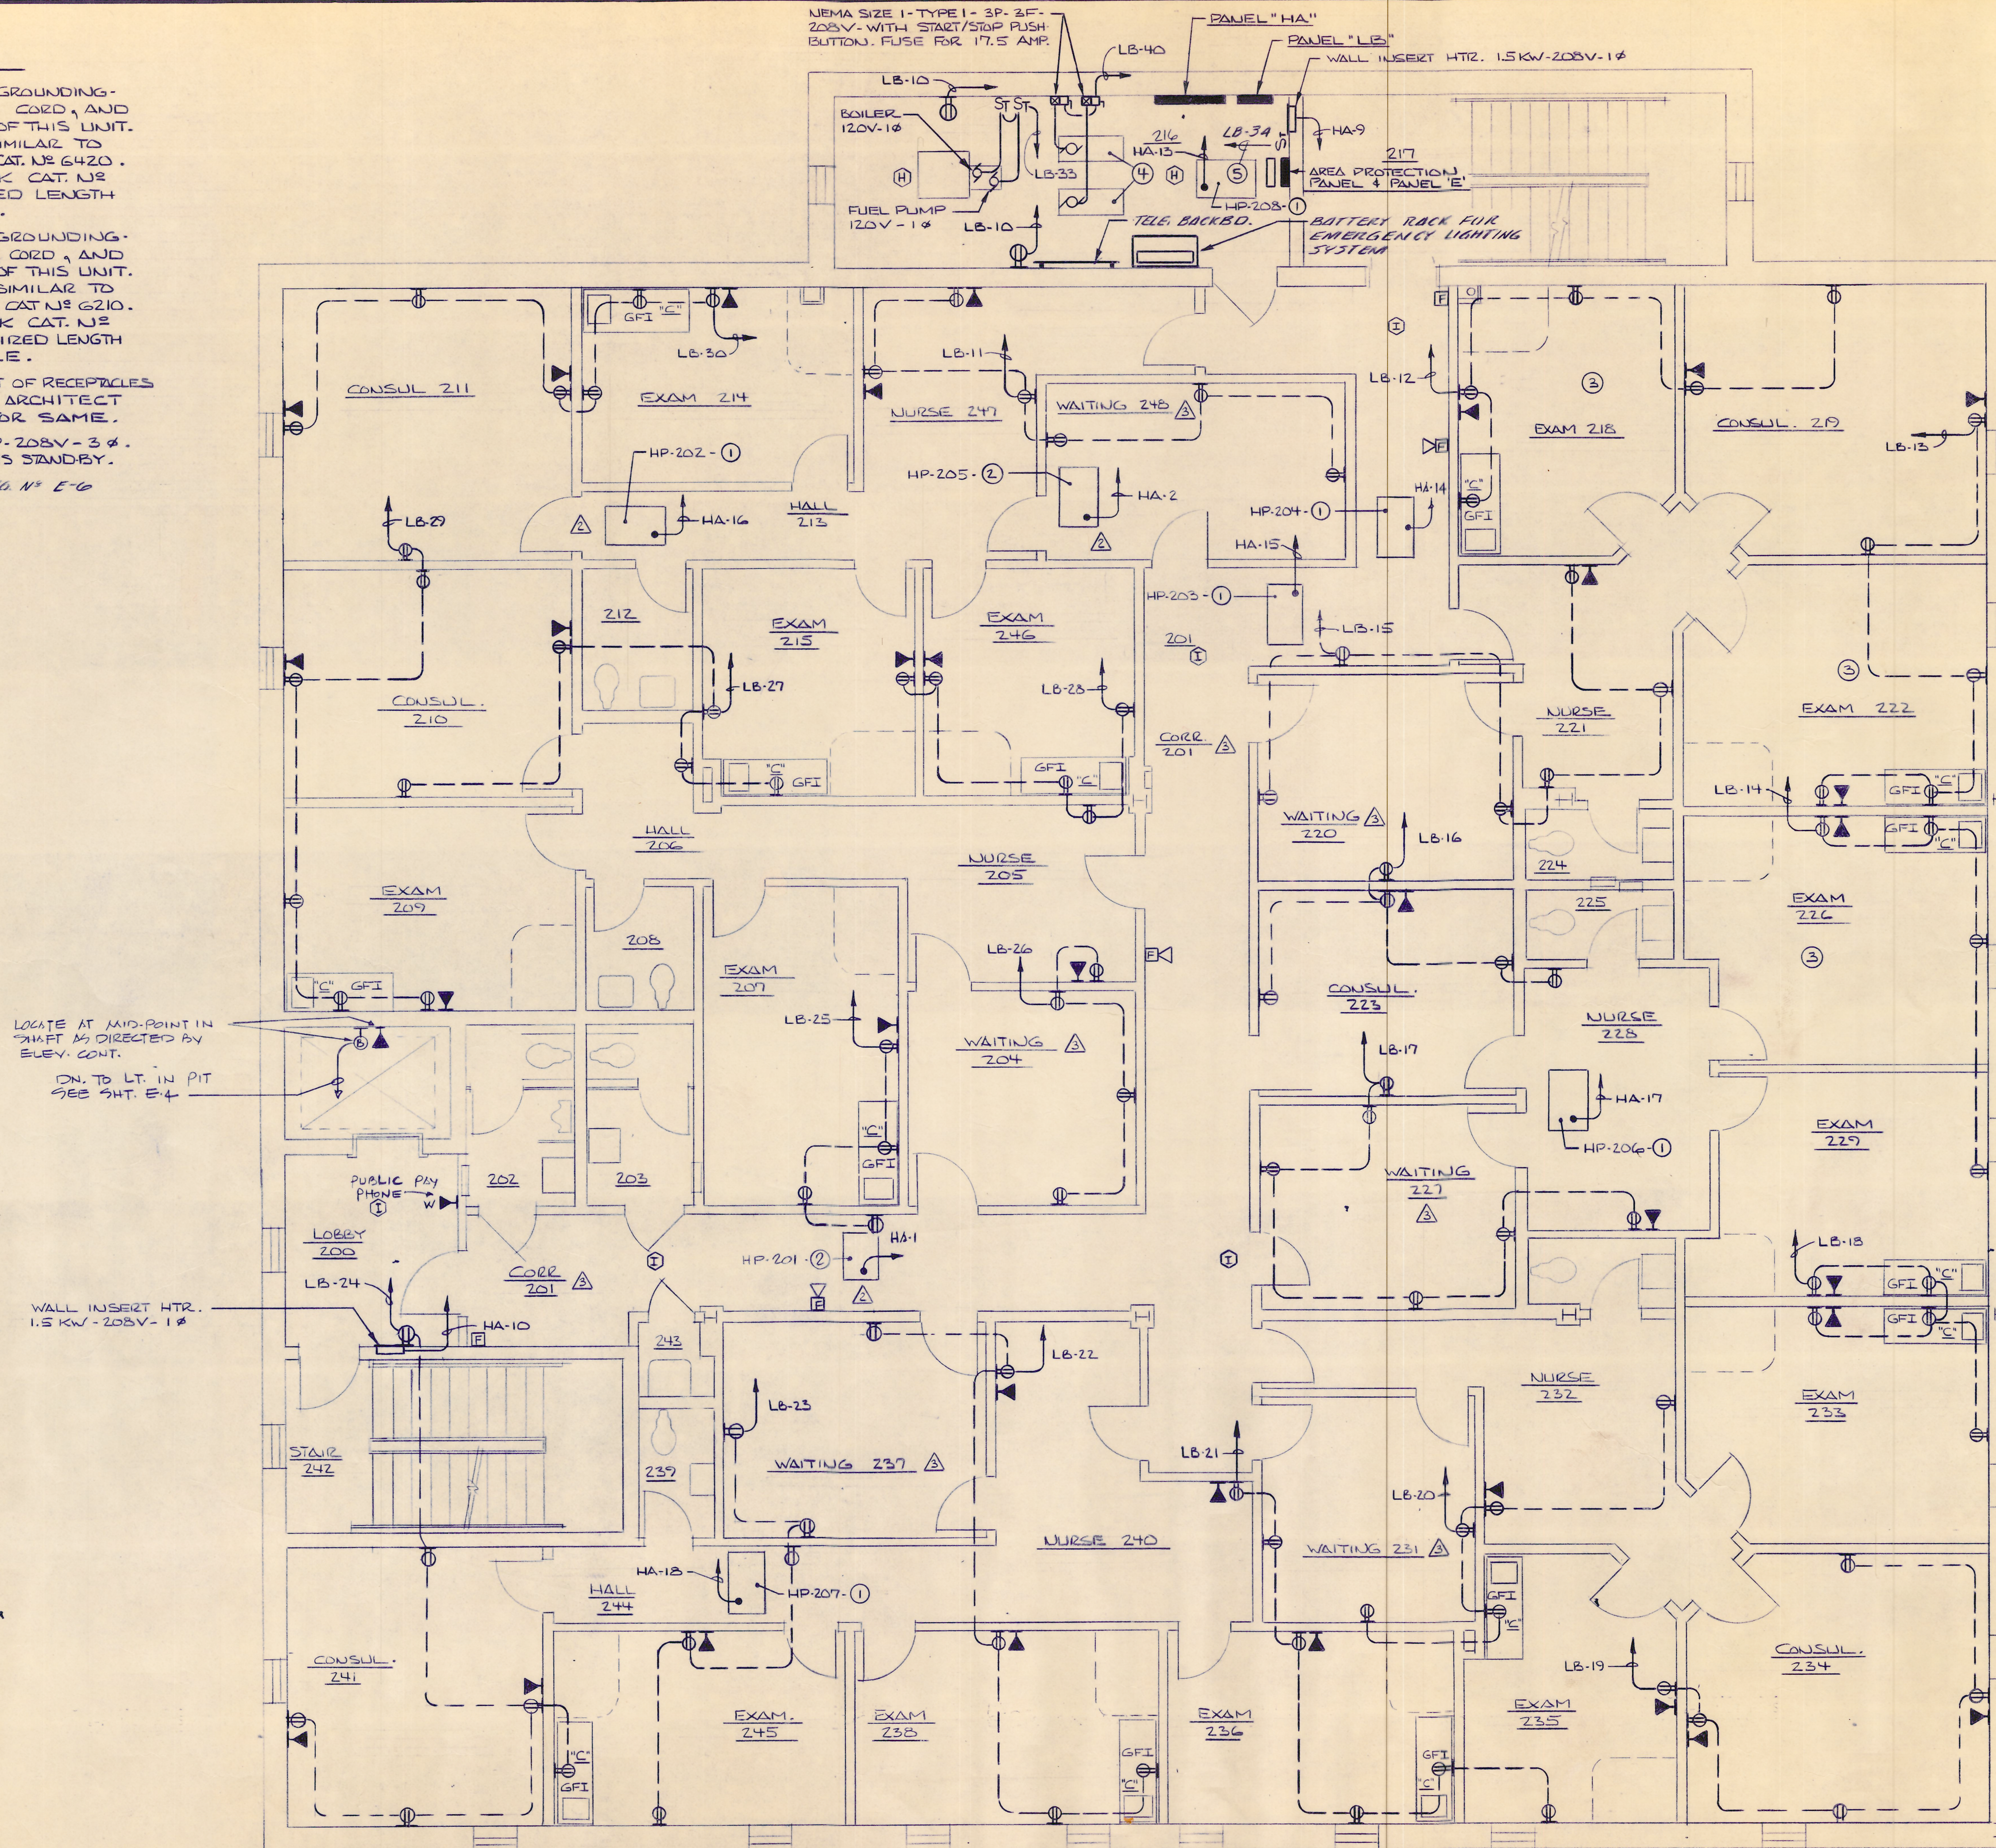

SECOND FLOOR PLAN - POWER
SCALE 1/4" = 1'-0"

MONROE MEDICAL BLDG.
1400 MONROE AVE
DUNMORE, PENNA.

DATE
12 JUL 78
SCALE
AS NOTED

DONALDSON BERGHAUSER AIA
AND JOSEPH H. YOUNG AIA
ASSOCIATED ARCHITECTS
345 JEFFERSON AVENUE, SCRANTON, PA.
SECOND FLOOR PLAN

REV. 12 JUL 78
E-5

FILSON - MINNICH & ASSOCIATES, INC.
CONSULTING ENGINEERS
2426 NORTH SECOND STREET
HARRISBURG, PA. 17110

