



- NOTES:
- RETURN AIR PLenums REQUIRE NON-COMBUSTIBLE CONSTRUCTION
 - EXTERIOR DISARGE REQUIRES SEPARATE APPROVAL AND A SEPARATE PERMIT
 - MECHANICAL, ELECTRICAL AND PLUMBING PLANS ARE UNDER A SEPARATE PERMIT AND A SEPARATE SUBMITTAL.
 - ALL FLUORESCENT FIXTURES WITH DOUBLE-ENDED LAMPS SHALL BE EQUIPPED WITH DISCONNECT MEANS PER 410.73(6) [CEC116]

- LEGENDS:
- | | |
|--|-----------------------------|
| | NEW WALL |
| | EXISTING WALL TO BE REMOVED |
| | EXISTING WALL TO REMAIN |

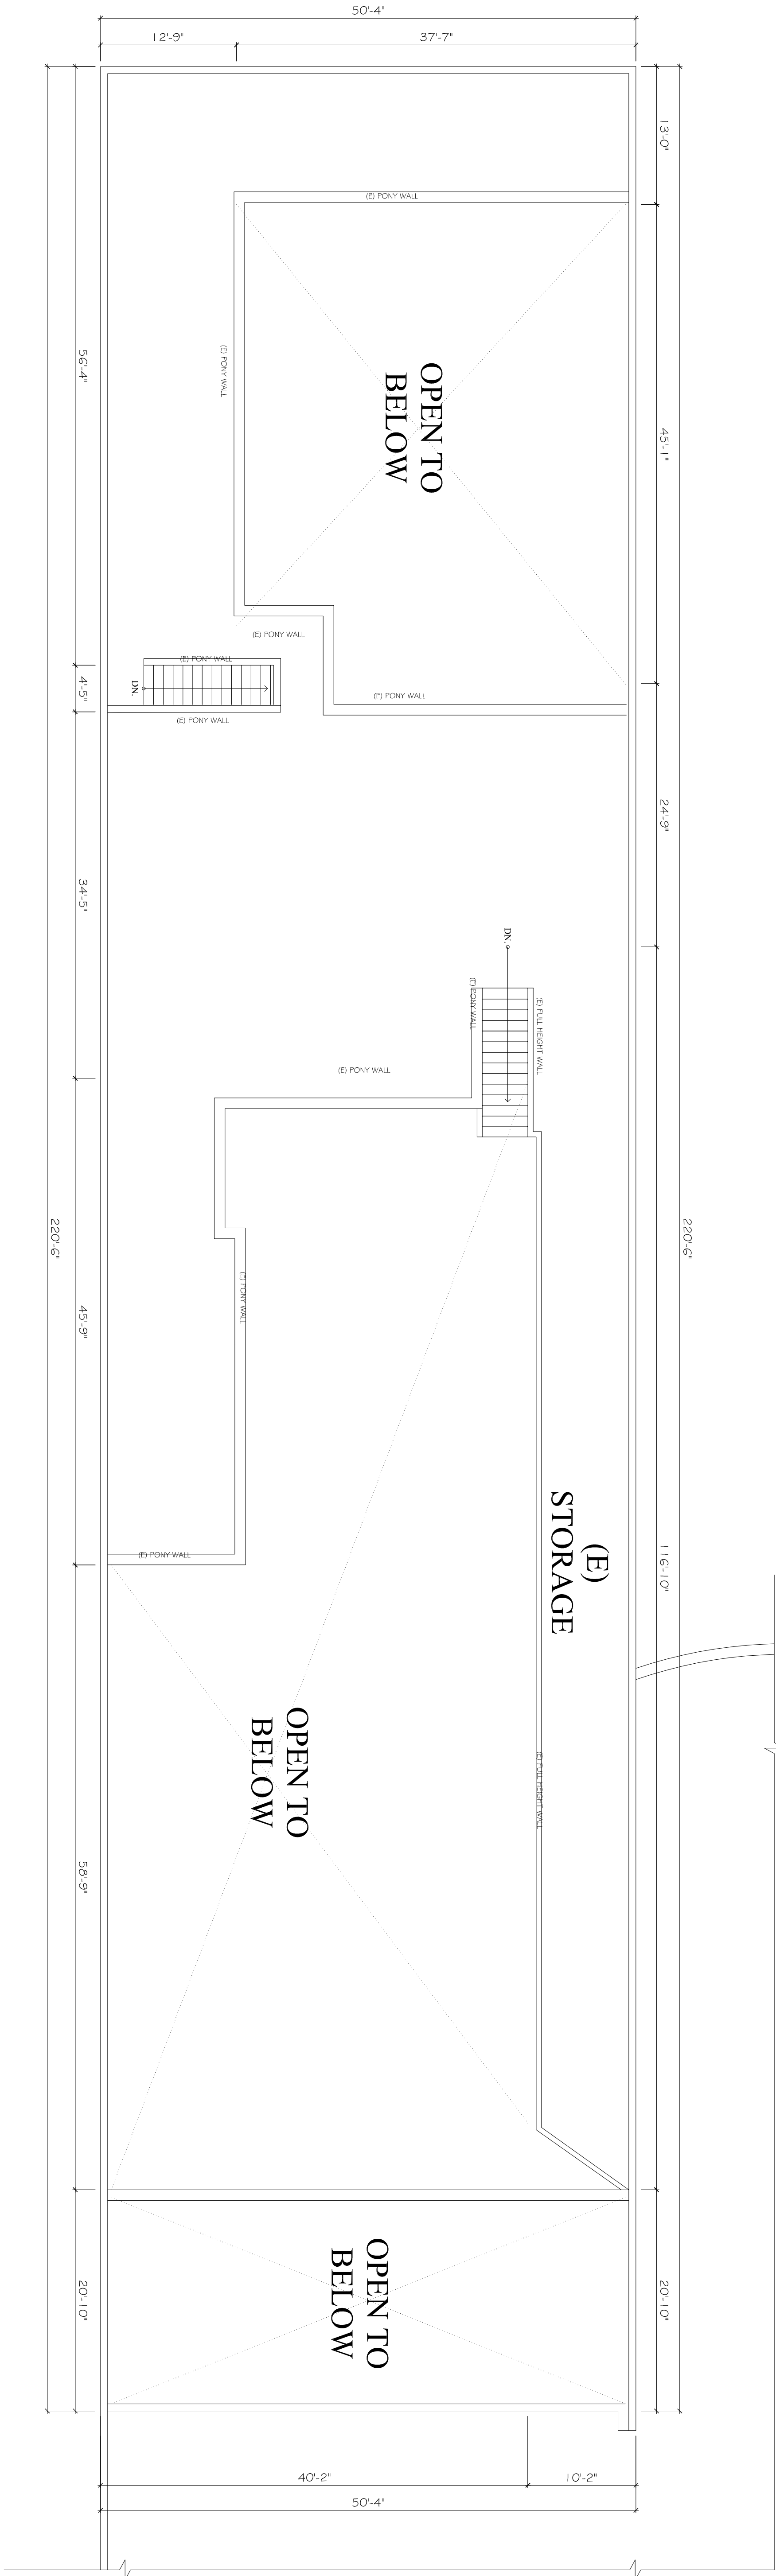

(E) MEZZANINE FLOOR PLAN

Scale: 1/8" = 1'-0"

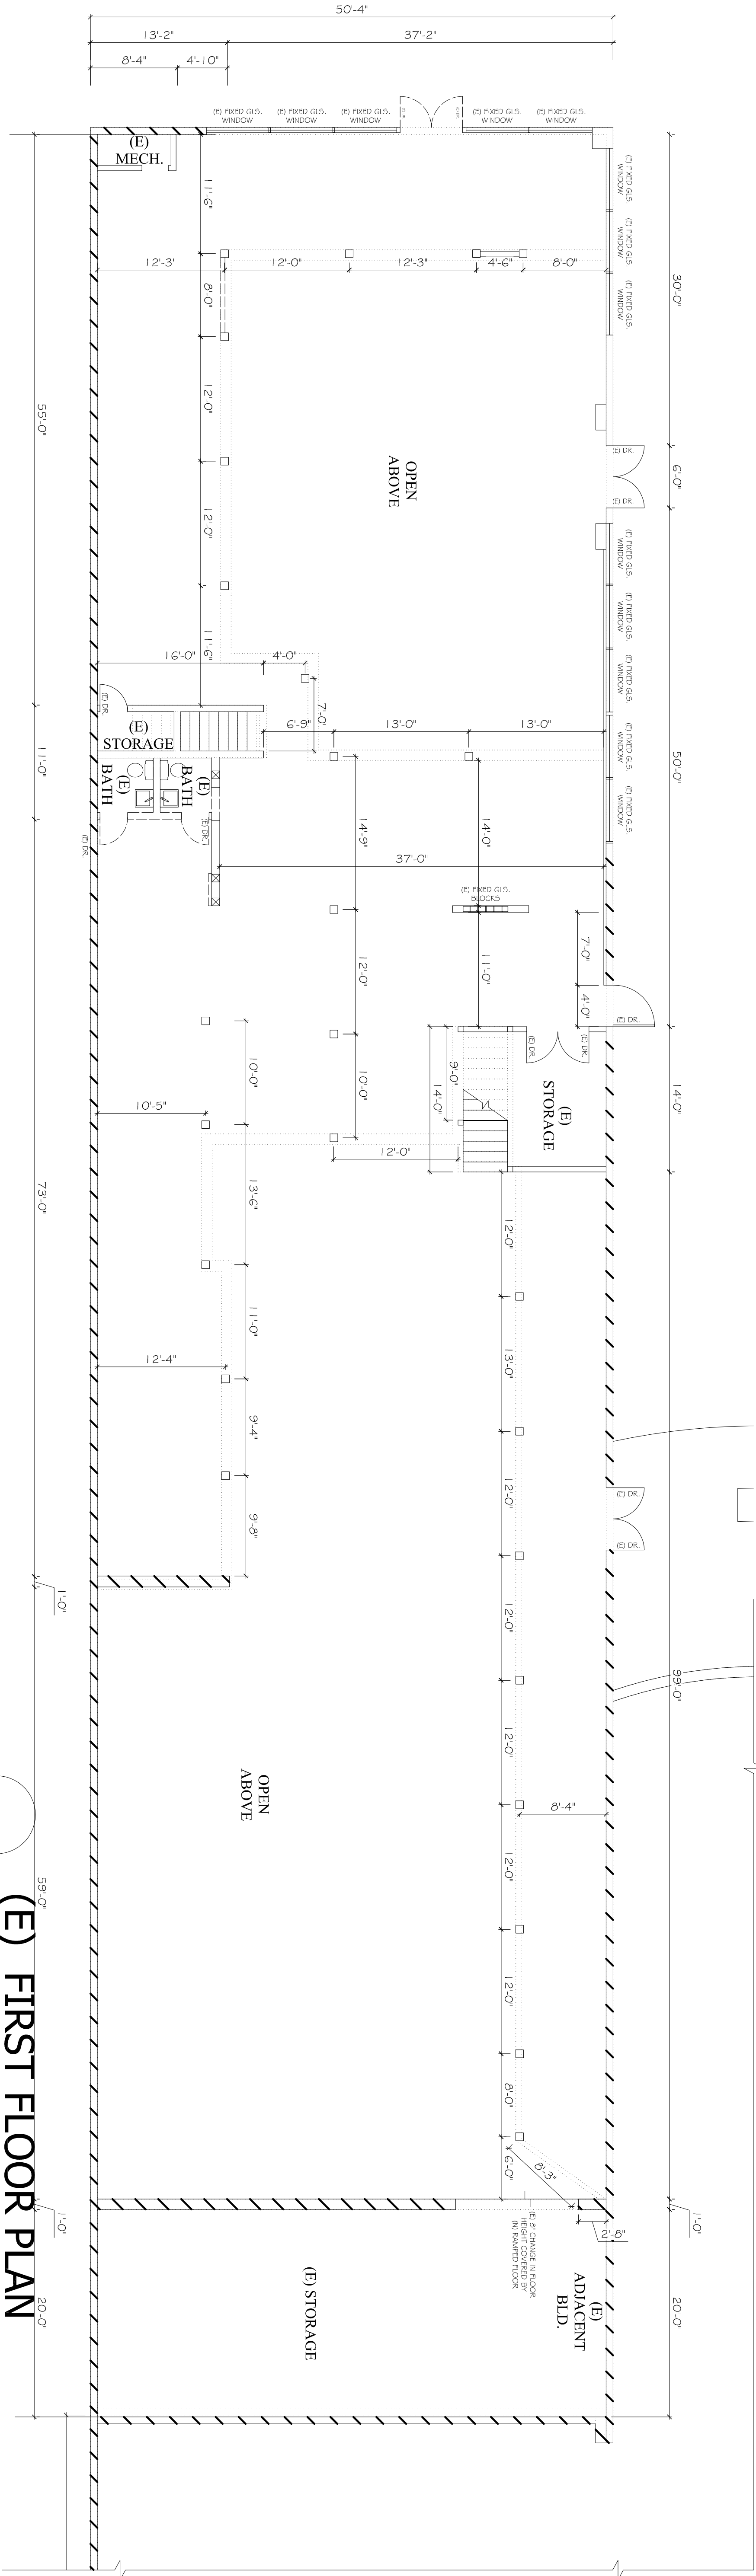

(E) FIRST FLOOR PLAN

Scale: 1/8" = 1'-0"

APPROVED PLANS BY THE BUILDING DEPT. SHALL BE CONSTRUCTED BY A LICENCED CONTRACTOR.

PLANS WITHOUT BUILDING DEPARTMENT APPROVAL STAMPS ARE NOT VALID FOR CONSTRUCTION.

PLEASE READ ALL GENERAL NOTES AND SPECIFICATIONS ON THIS SHEET. IF THERE ARE ANY MISTAKES FROM THE GENERAL CONTRACTOR, THEY ARE HIS RESPONSIBILITY.


REVISIONS	BY

These drawings, specifications, ideas and arrangements presented thereby are and shall remain the property of ASADESIGN. No part thereof shall be copied, disclosed to others or used in connection with any project other than the specific project for which they have been prepared and developed without the written consent of ASADESIGN. Visual contact with these drawings or specifications shall constitute conclusive evidence of acceptance of these restrictions.

PROJECT:

T.I.

18833 HAWTHORNE BLVD.
TORRANCE, CA 90504

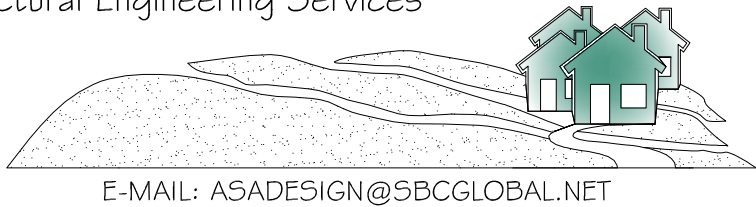

ASA Engineering Design Services
Architectural and Structural Engineering Services

6320 VAN NUYS BLVD.
VAN NUYS, CA. 91401.
TELL: (818) 997-1030
FAX: (818) 997-1063

DATE:	1/22/2018
SCALE:	AS SHOWN
DRAWN:	
CHECKED:	
JOB NO.:	ASA-17-129
INDEX:	

SHEET

A-2

OF SHEETS