


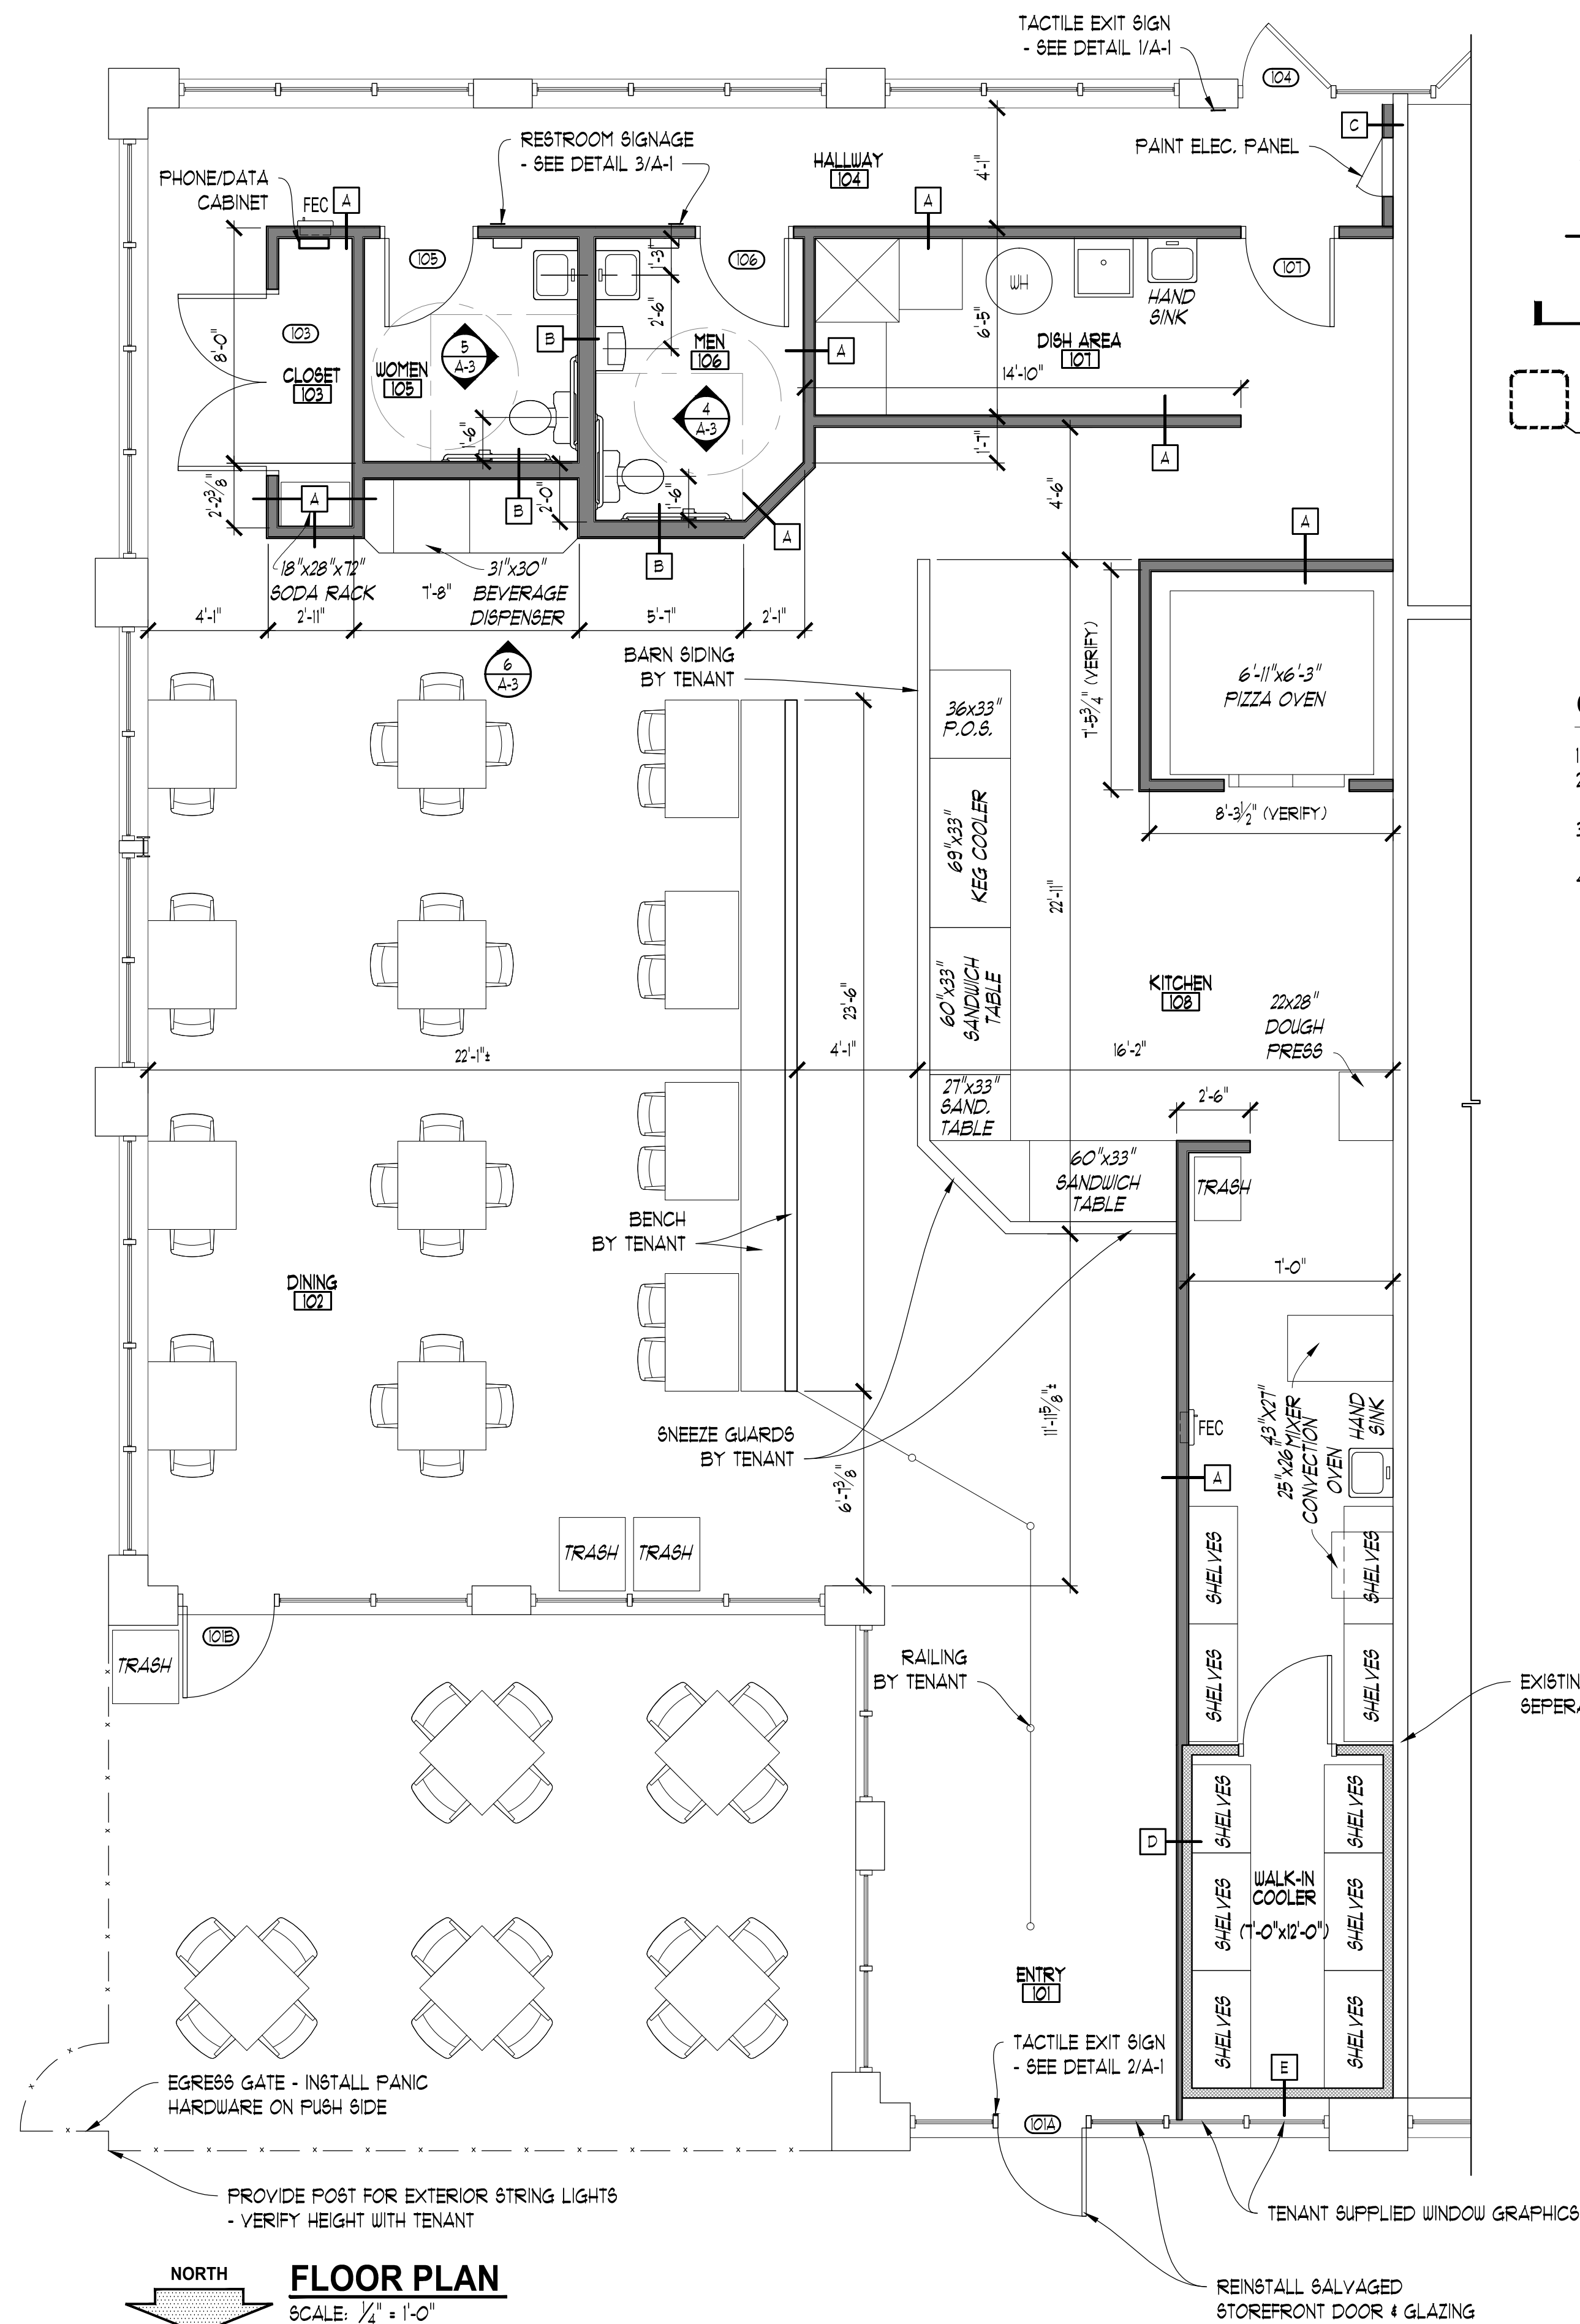


FLOOR PLAN
SCALE: 1/4" = 1'-0"

SYMBOL LEGEND


- ROOM NAME AND NUMBER
- DOOR NUMBER
- INTERIOR ELEVATION DESIGNATION
- WALL TYPES
- PARTIAL SECTION TAG
- DETAIL CALLOUT
- SEMI-RECESSED WALL MOUNTED FIRE EXTINGUISHER CABINET (5 LB. EXTINGUISHER U.N.O.)
- SURFACE MOUNTED FIRE EXTINGUISHER

GENERAL NOTES

- ALL DIMENSIONS ARE TO FACE OF STUDS UNLESS NOTED OTHERWISE.
- ALL COUNTERTOP OUTSIDE CORNERS TO HAVE A 1" RADIUS UNLESS NOTED OTHERWISE.
- ALL SHELVING, TABLES, CHAIRS & APPLIANCES TO BE PROVIDED BY THE TENANT UNLESS NOTED OTHERWISE.
- GENERAL CONTRACTOR TO PROVIDE WOOD BLOCKING FOR SHELVING, PLUMBING FIXTURES & ACCESSORIES, AND CASEWORK AS NEEDED. COORDINATE WORK WITH ALL TRADES.

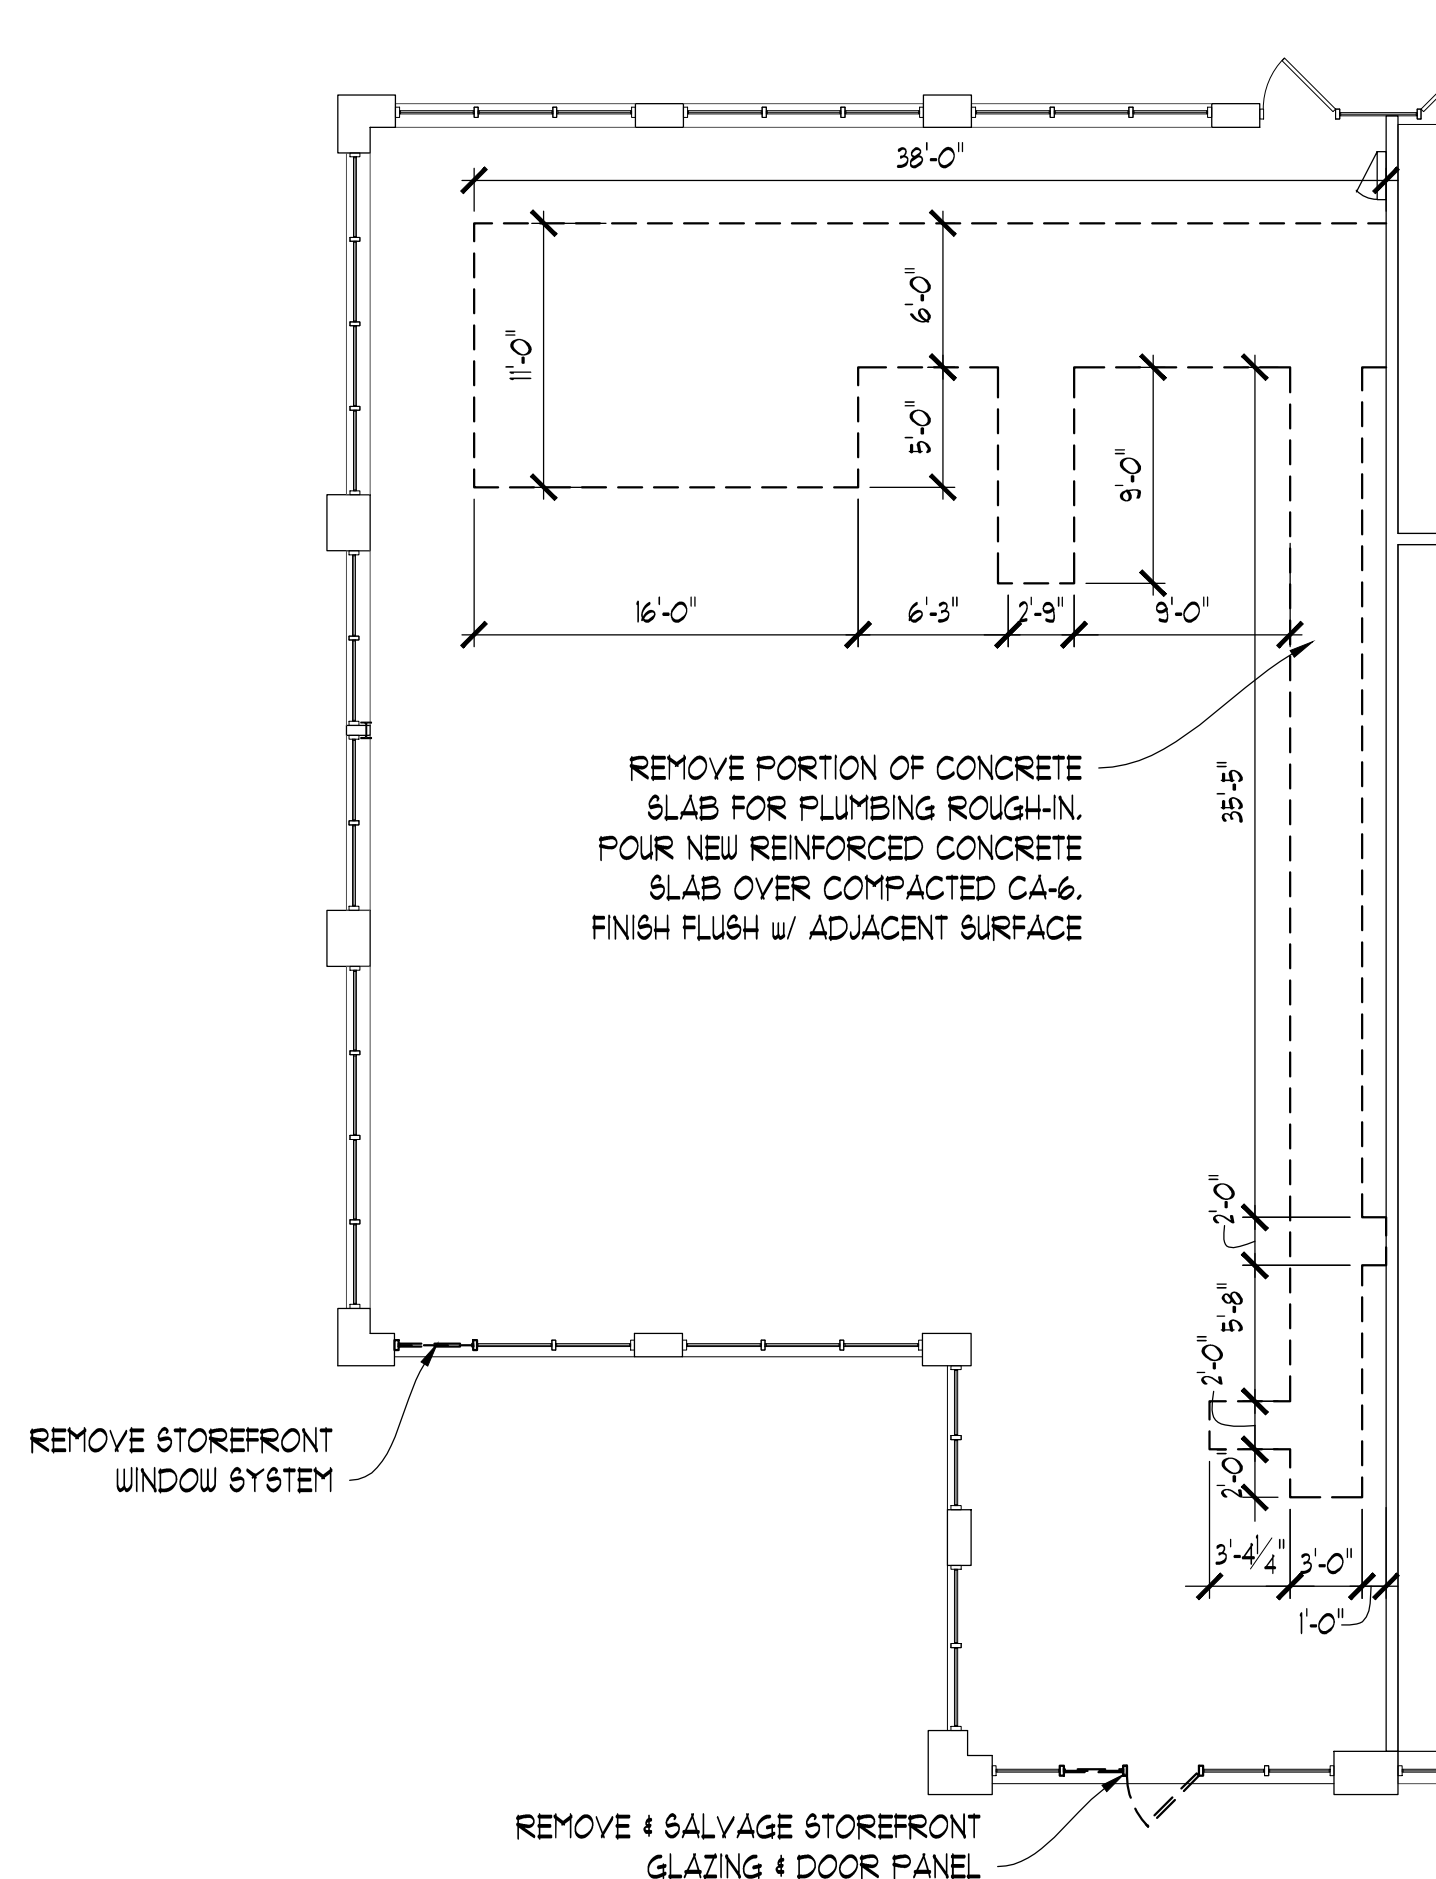


DEMOLITION PLAN
SCALE: 1/8" = 1'-0"

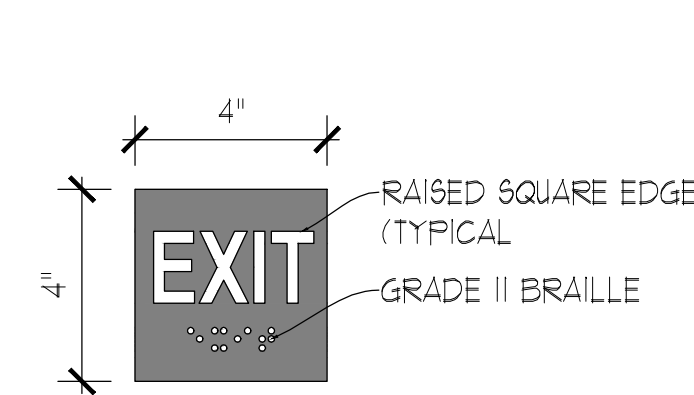


NOTE: SIGN TO BE MOUNTED AT 5'-0" AFF. TO THE CENTERLINE OF THE SIGN



1 EXIT SIGNAGE DETAIL
SCALE: N.T.S.

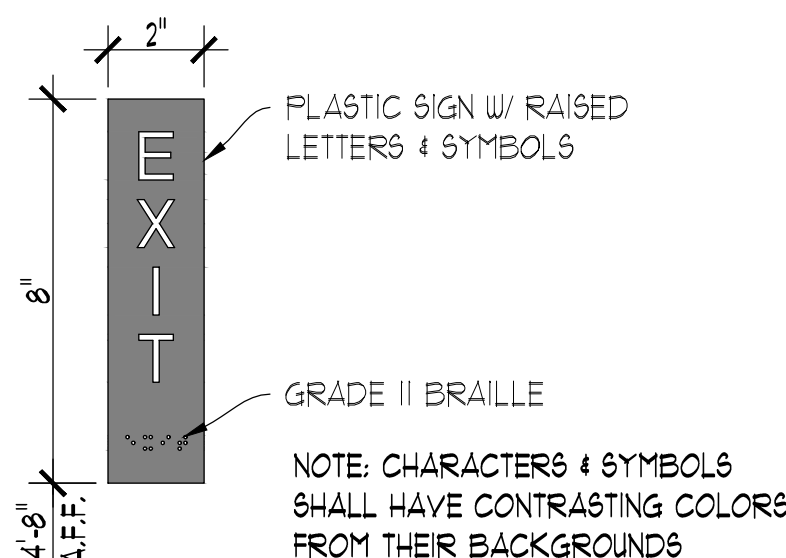

2 EXIT SIGNAGE DETAIL
SCALE: N.T.S.

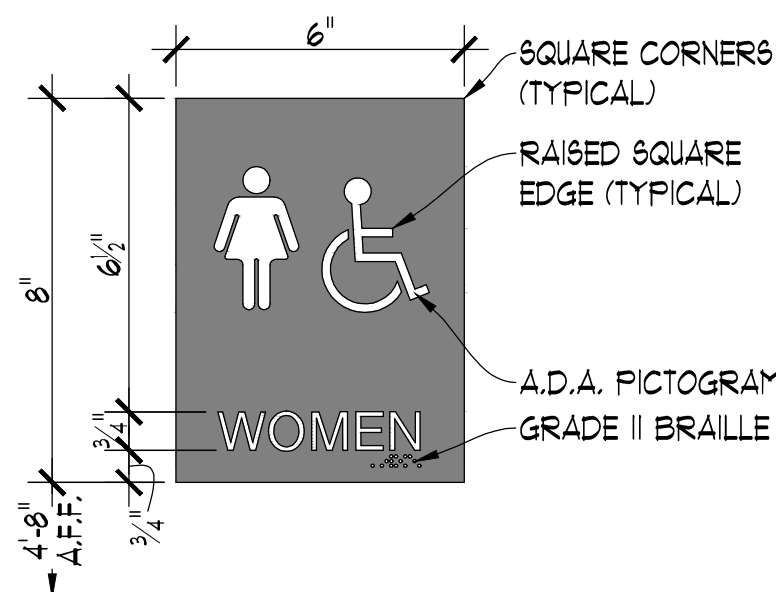

3 RESTROOM SIGNAGE DETAIL
SCALE: N.T.S.

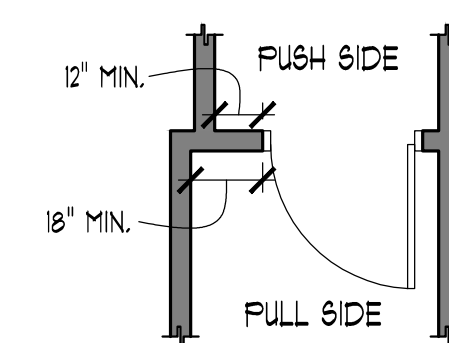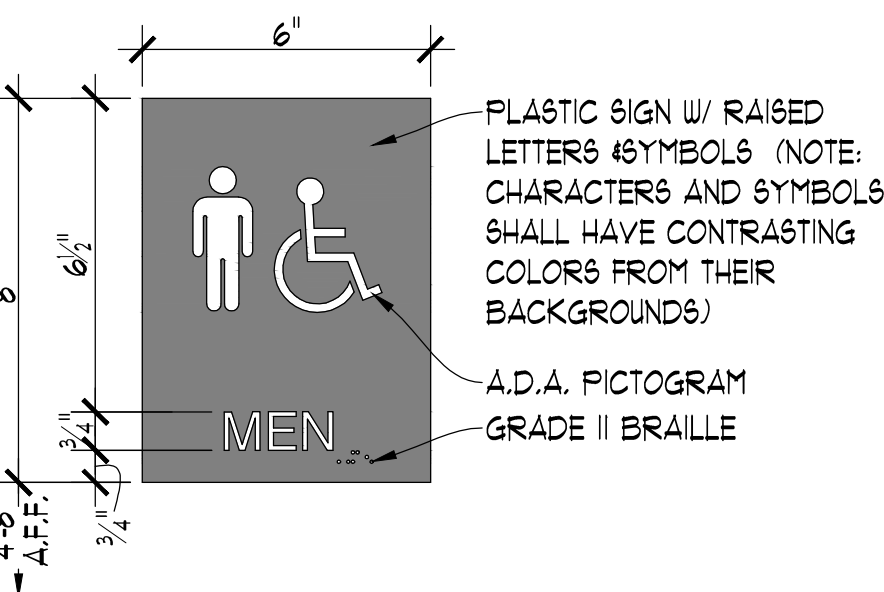

4 EXIT SIGNAGE DETAIL
SCALE: 1/4" = 1'-0"