


404 Main Street

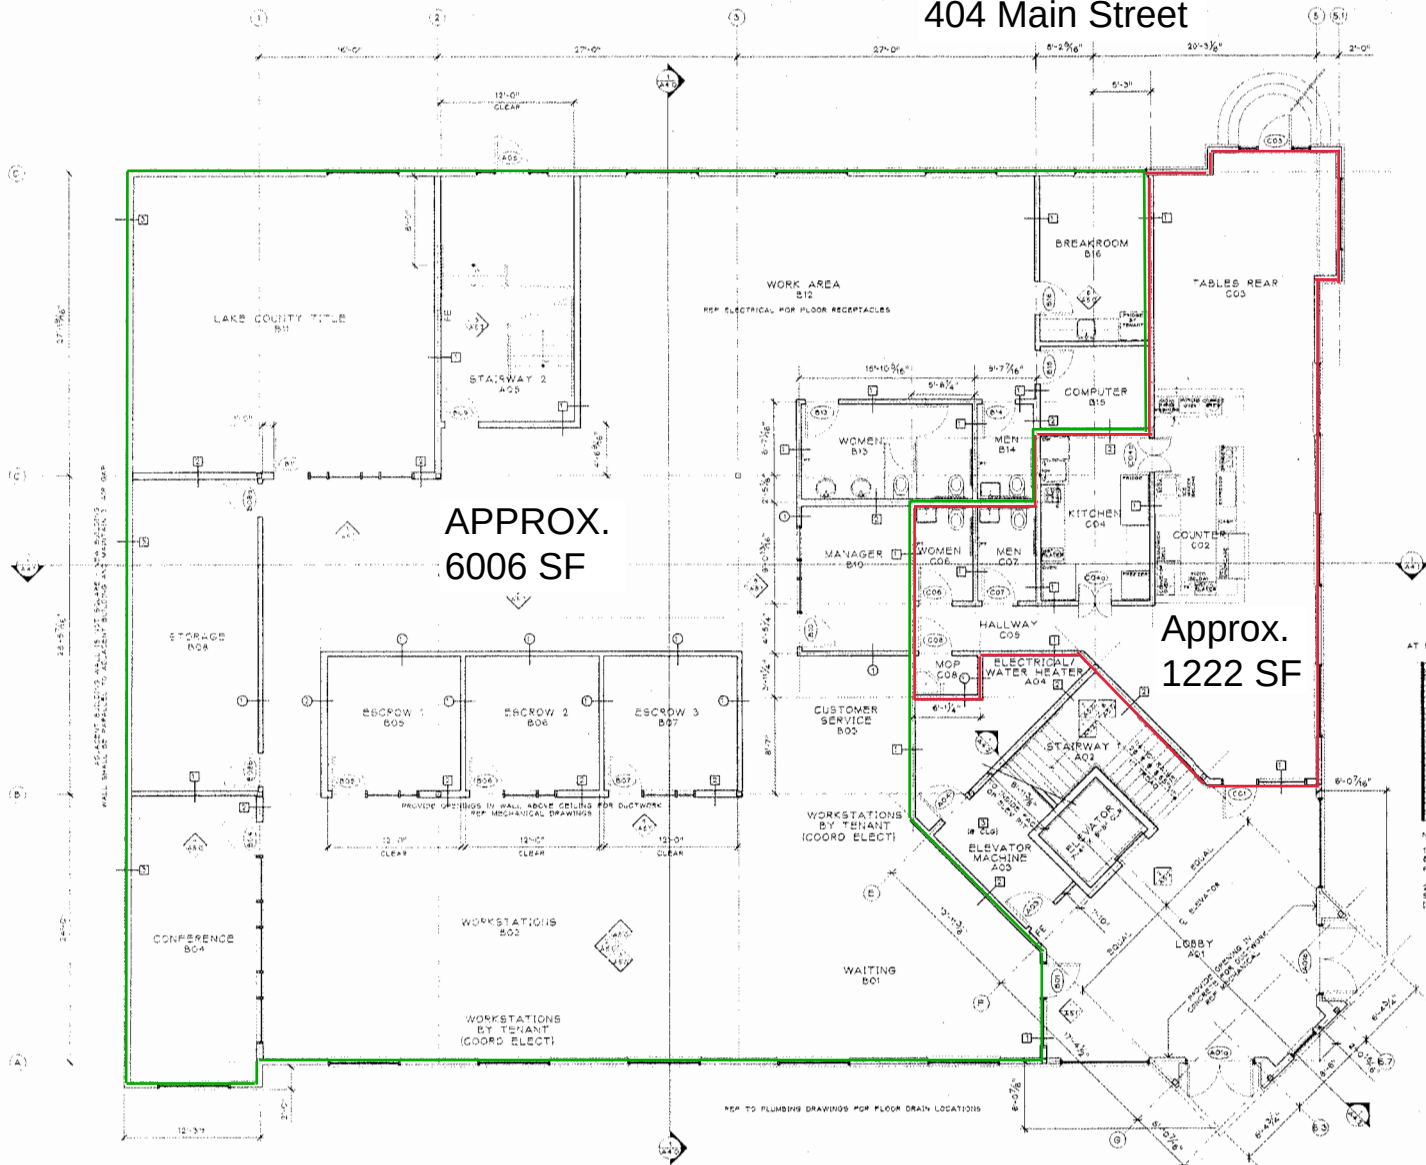

WALL TYPES

NOTES: WALL TYPES DESIGNATED WITH $\square$ SHALL EXTEND TO DECK STUDS, GYP BD AND INSULATION.

WALL TYPES DESIGNATED WITH $\square$ MAY TERMINATE 4" ABOVE SCHEDULED CEILING HEIGHT - PROVIDE 45 DEG CROSSBRACKETS TO DECK ABOVE 8" AND 4" OC OR EXTEND EVERY OTHER STUD TO DECK.

COORDINATE WALL OPENINGS ABOVE CEILING WITH MECHANICAL WORK.

ALL WALLS EXTENDED TO DECK SHALL BE INSTALLED WITH A DEFLECTOR HEAD CHANNEL. IN ADDITION TO HEAD TRACK - INSTALL AS PER MANUFACTURER.

INSTALL MOISTURE RESISTANT GYPSUM BOARD WITHIN 3'-0" OF PLUMBING FIXTURES SHOWN.

INSTALL FULL WALL OF MOISTURE RESISTANT GYPSUM BOARD AT PLUMBING WALLS & ALL KITCHEN WALLS (KITCHEN SIDE).

REFER TO NEW FINISHES SCHEDULE FOR WALL FINISHES.

PROVIDE 4" MIN UNFACED BATT INSULATION AT ALL INTERIOR PARTITIONS.

WALL TYPE 1 (NON-BEARING)

4" (ACTUAL) 20 GA METAL STUD @ 16" OC

5/8" TYPE 70 GYPSUM BOARD EACH SIDE

WALL TYPE 2 (NON-BEARING)

6" (ACTUAL) 20 GA METAL STUD @ 16" OC

5/8" TYPE 70 GYPSUM BOARD EACH SIDE

WALL TYPE 3 - 1 HOUR RATING (NON-BEARING)

6" SHUNT WALL 20 GA C-H STUDS @ 16" OC

(W/ ASSOCIATED J-P TRACKS AT ADJ WALL, DECK & FLOOR)

5" GYPSUM BOARD AT OUTER SIDE

5/8" TYPE 70 GYPSUM BOARD OVER HAT CHANNELS 16" OC VERT AT INNER SIDE

AT SEISMIC BRACING ONLY

PACK MINERAL WOOL BETWEEN TOP TRACK AND DECK FLUTES

EXTERIOR WALL CONSTRUCTION

AT STONE VENEER

- 5/8" TYPE 70 GYP BD
- 6" HTL STUDS (REF STR)
- 6" FACED BATT INSULATION
- SHEATHING (REF STR)
- GRADE D CRAFT BLDG PAPER
- COUNTY W/ DESG STANDARD 17-1 OR UL 55-A-1982
- METAL LATH PER MPR RECOMMENDATION
- SCRATCH COAT/ MORTAR BED
- STONE VENEER STYLE AND COLOR BY ARCHITECT/ MAX WEIGHT = 1 LB/SF

NOTE TO STONE VENEER

1 - STONE VENEER MANUFACTURER MUST PROVIDE EVIDENCE THAT ITS PRODUCT MEETS USC 1907 FOR FOR ADHERED VENEER.

2 - PROVIDE 1 1/2" HOT DIP GALVANIZED MASONRY TIES SECURED TO STUDS AT 4'-0" OC EA WAY, STAGGERED 12'-0" OC EA WAY AT HEIGHTS OVER 30'-0".

AT STUDS

- 5/8" TYPE 70 GYP BD
- 6" HTL STUDS (REF STR)
- 6" FACED BATT INSULATION
- SHEATHING (REF STR)
- GRADE D CRAFT BLDG PAPER
- COUNTY W/ DESG STANDARD 17-1 OR UL 55-A-1982
- 1/2" STYROFOAM
- METAL LATH PER MPR RECOMMENDATION
- 3/8" TO 1/2" WESTERN CME NOTE STUDS W/ ACETIC RUSH (PHEN) AND COLOR BY ARCHITECT

LOWER FLOOR PLAN
3/16" = 1'-0"



PEDERSEN ARCHITECTS
404 PINE STREET
KLAMATH FALLS, OREGON 97601
(541) 884-9831
NASH BUILDING
404 MAIN ST
KLAMATH FALLS, OREGON

LOWER FLOOR PLAN
FILE NO. 2215
DATE 10/24/15
DRAWING NO.
A-1.0

