

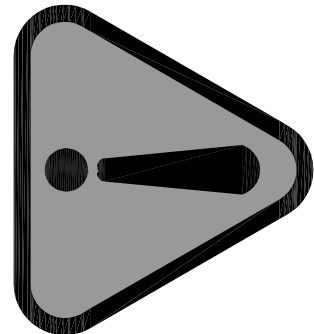
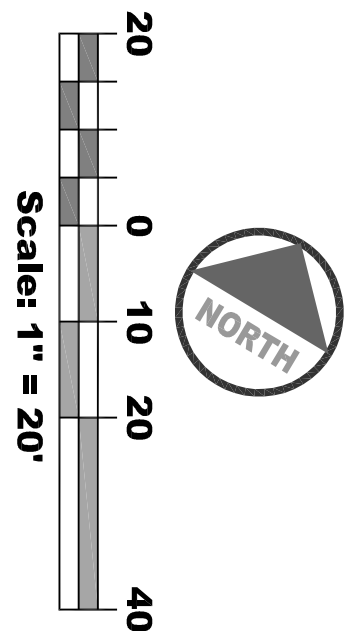
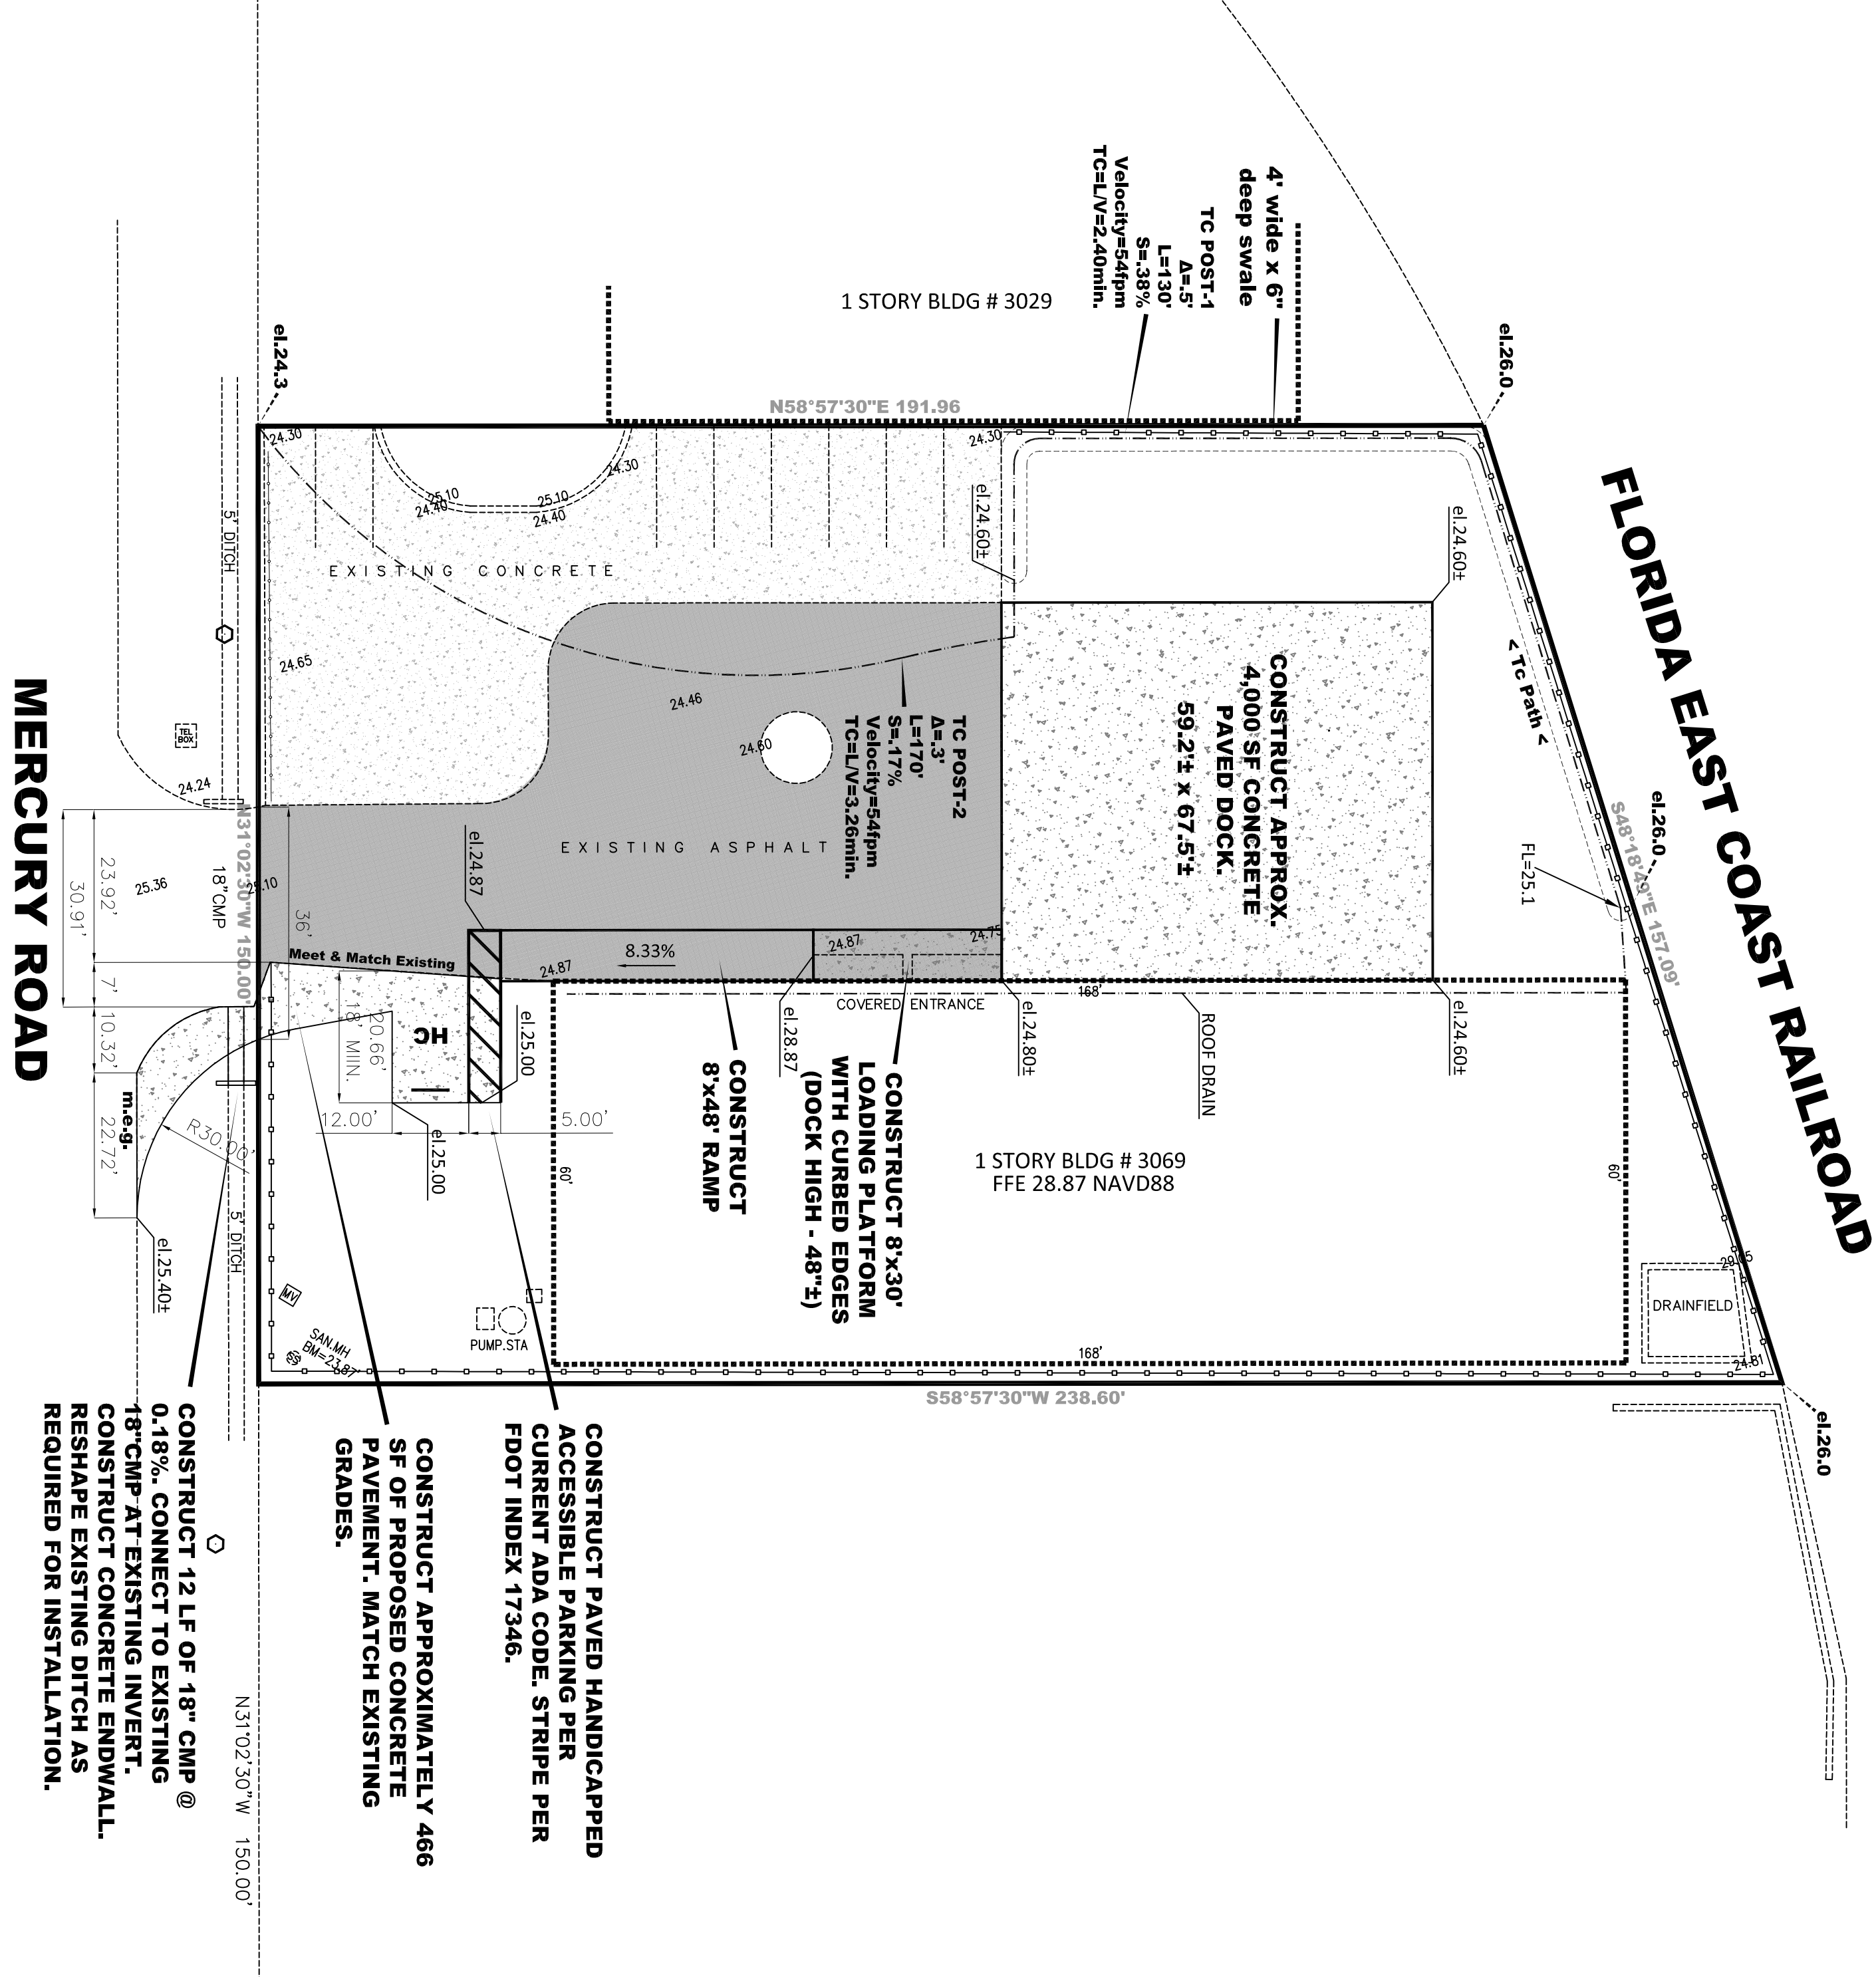


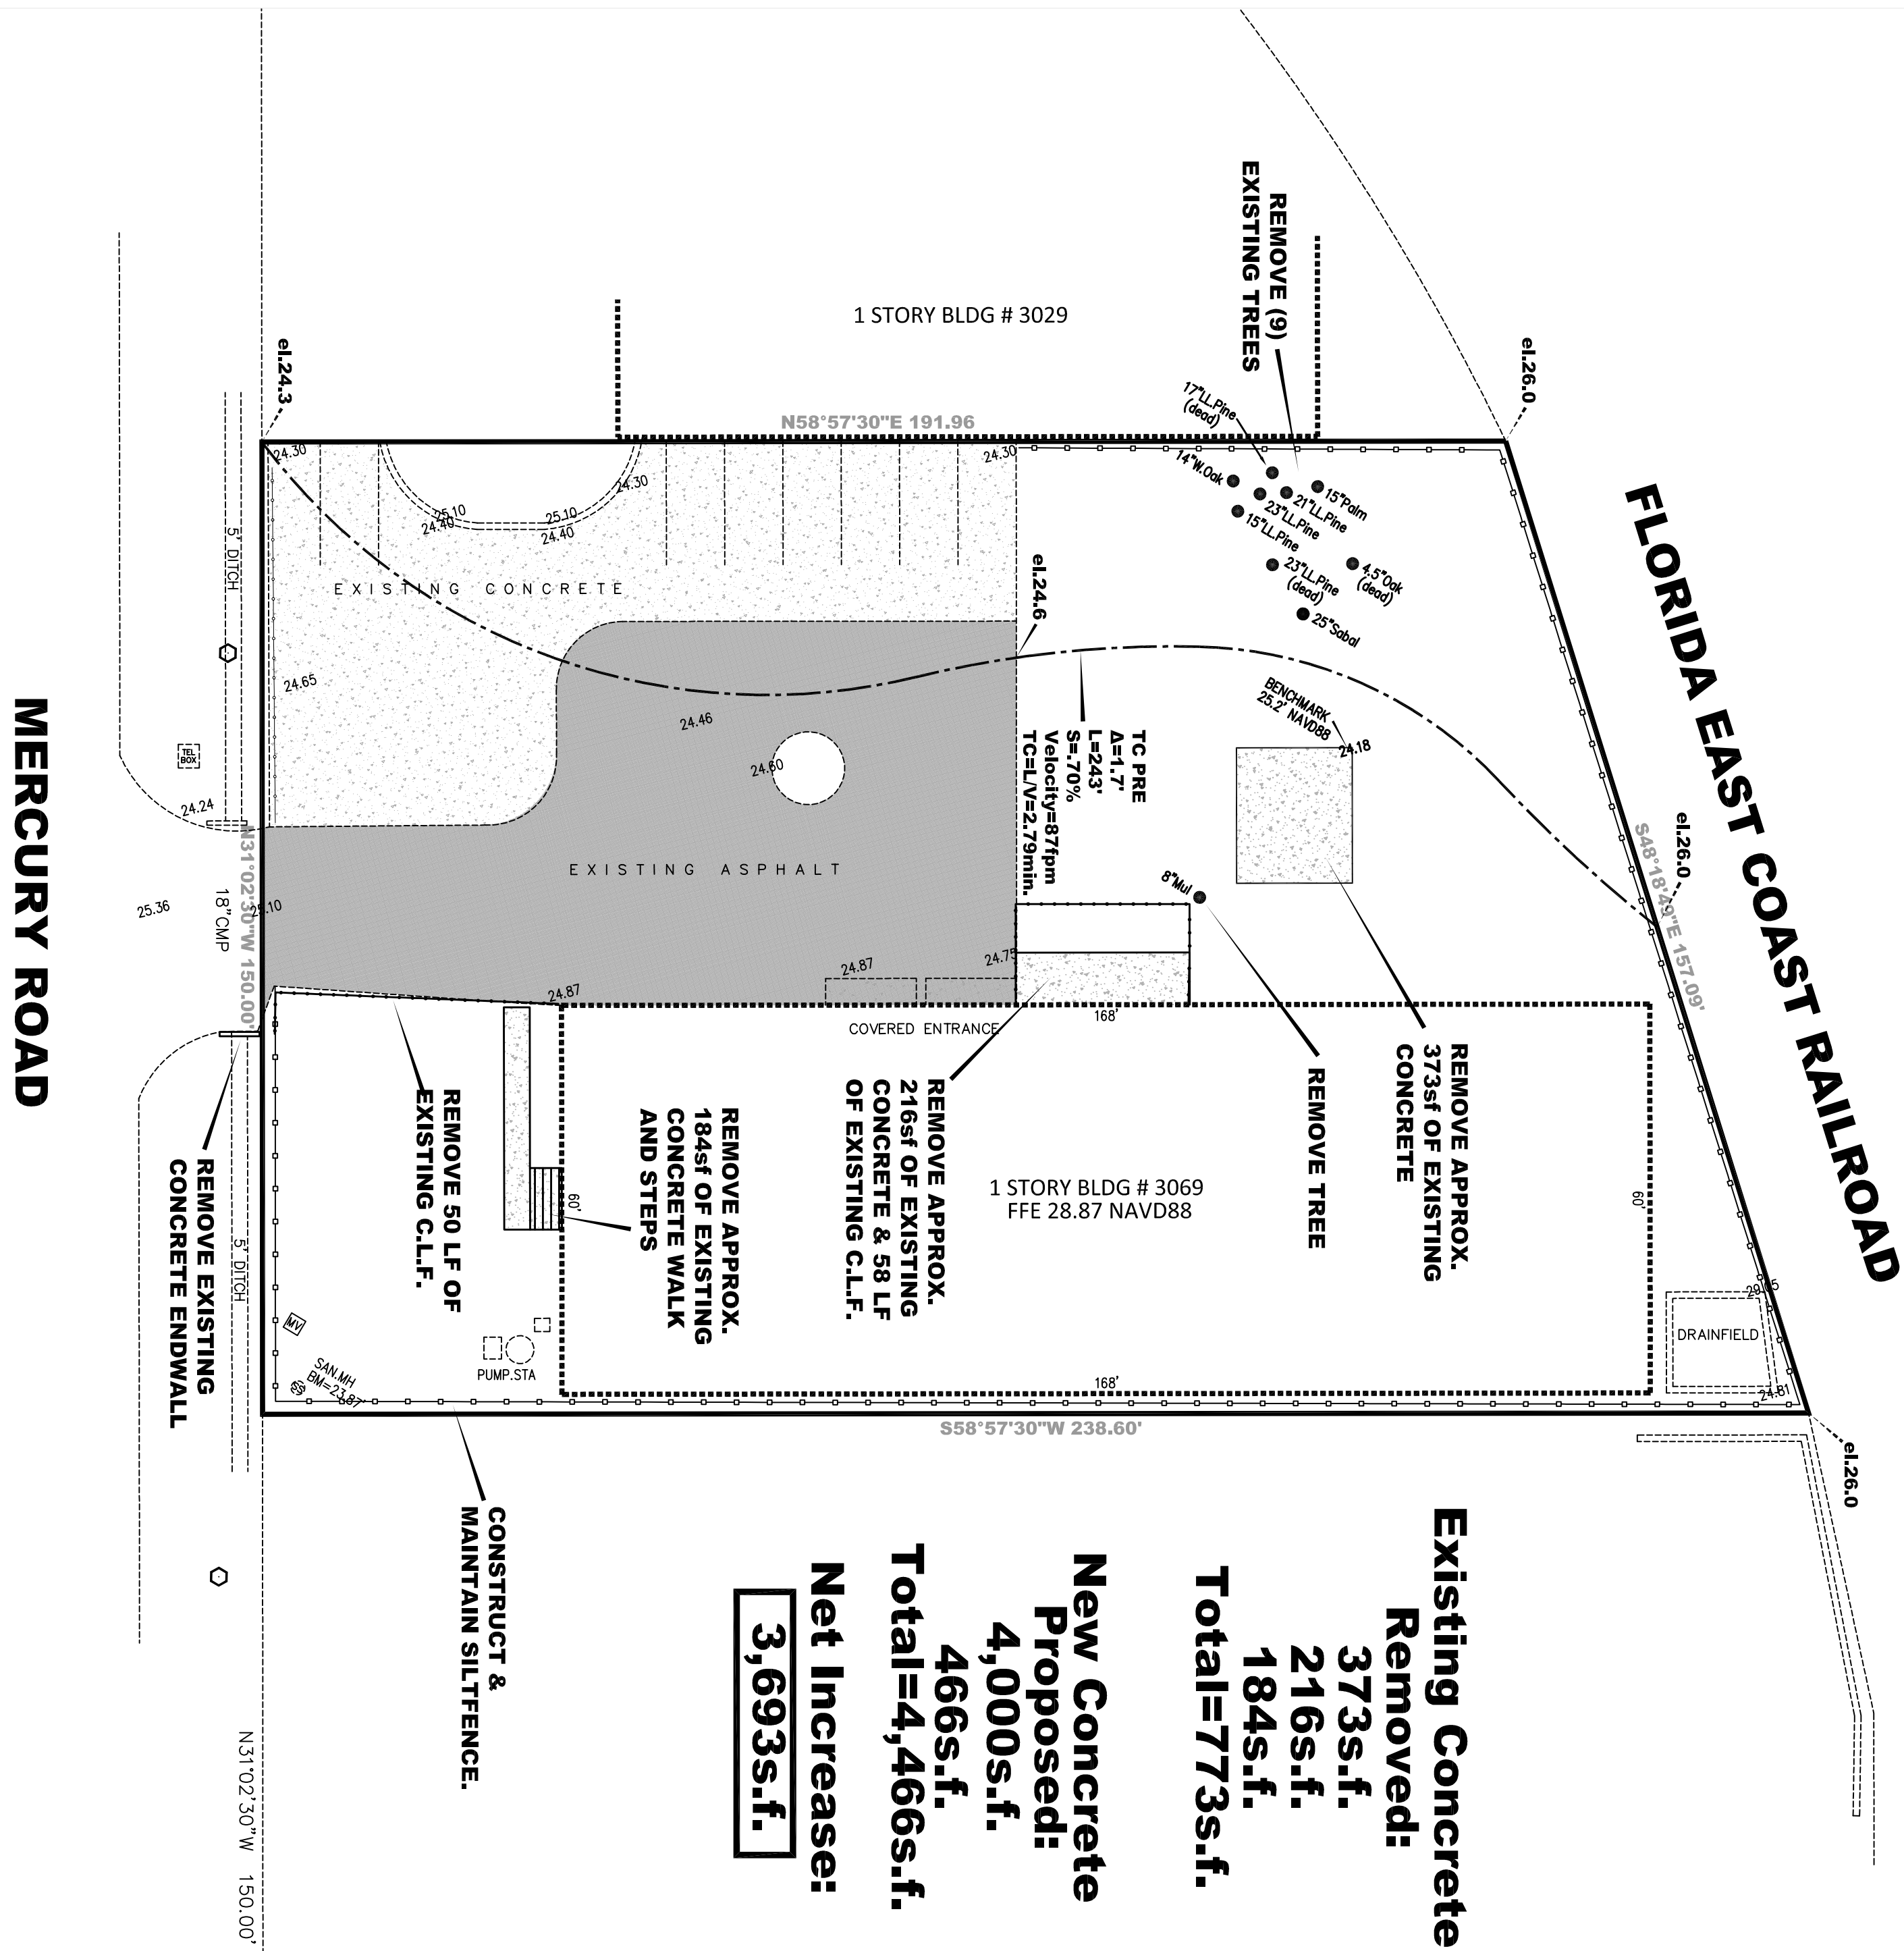

Construction in City Right of Way will require a Right of Way Permit. The Contractor is responsible for calling 255-8366 daily from 0730 am to 0830 am, when working in the City Right of Way.

SEE LANDSCAPE PLAN FOR TREES TO BE REMOVED & PROTECTED.

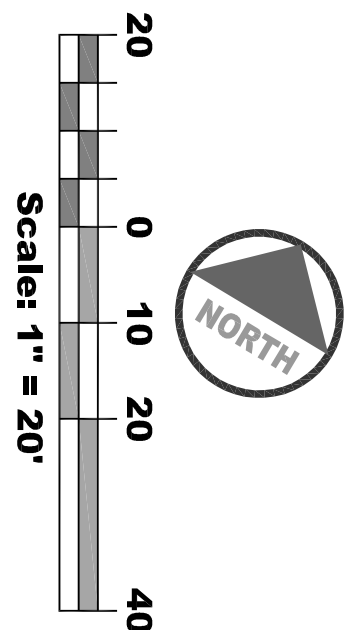

Demo Plan


Site Plan

3069 Mercury Road

Demo / Site Plan


Duval County

Florida

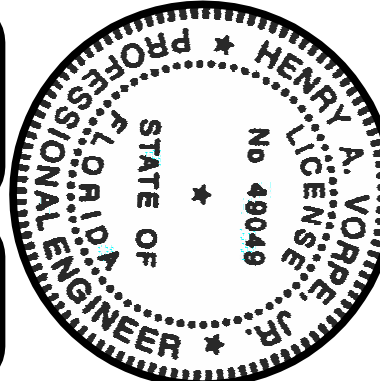

UNLESS THIS DRAWING BEARS THE EMBOSSED SEAL OF A FLORIDA REGISTERED ENGINEER ACTING AS AN AUTHORIZED AGENT FOR AVA ENGINEERS, INC., IT IS FOR INFORMATION PURPOSES ONLY AND IS NOT VALID.

THE STORMWATER SYSTEM AS SHOWN ON THESE PLANS HAS BEEN PREPARED IN ACCORDANCE WITH STANDARD, ACCEPTED ENGINEERING PRACTICE. HOWEVER, CERTAIN DESIGN CRITERIA, RULES OR LAWS THAT ARE MANDATED BY OTHERS (W. CITY, COUNTY, STATE, FEDERAL, ETC.) HAVE BEEN USED TO DETERMINE THE FINAL DESIGN FOR SUCH STORMWATER FACILITIES. THE ENGINEER DOES NOT ACCEPT RESPONSIBILITY FOR POSSIBLE FUTURE CONTAMINATION RESULTING FROM THE REQUIREMENT FOR RETENTION AND TREATMENT OF STORMWATER.

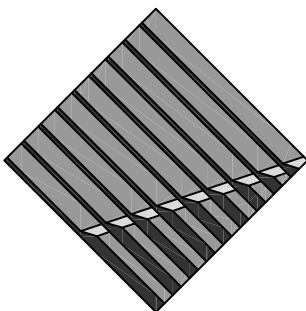

AVA ENGINEERS, INC.
Commercial | Residential | Marine
Florida Certificate No. 00008161
5701 RICHARD STREET, SUITE 4 | JACKSONVILLE, FLORIDA 32216
Ph. (904) 730-3223 | Fx. (904) 730-3226
Henry A. Vorpe Jr., No. 49049

No.	Revisions	By
1		
2		
3		
4		

Date: 10-26-17

Designer: ts

Job #: 16-032

Drawn: ts

Scale: n/a

Sheet: 2

of 4