


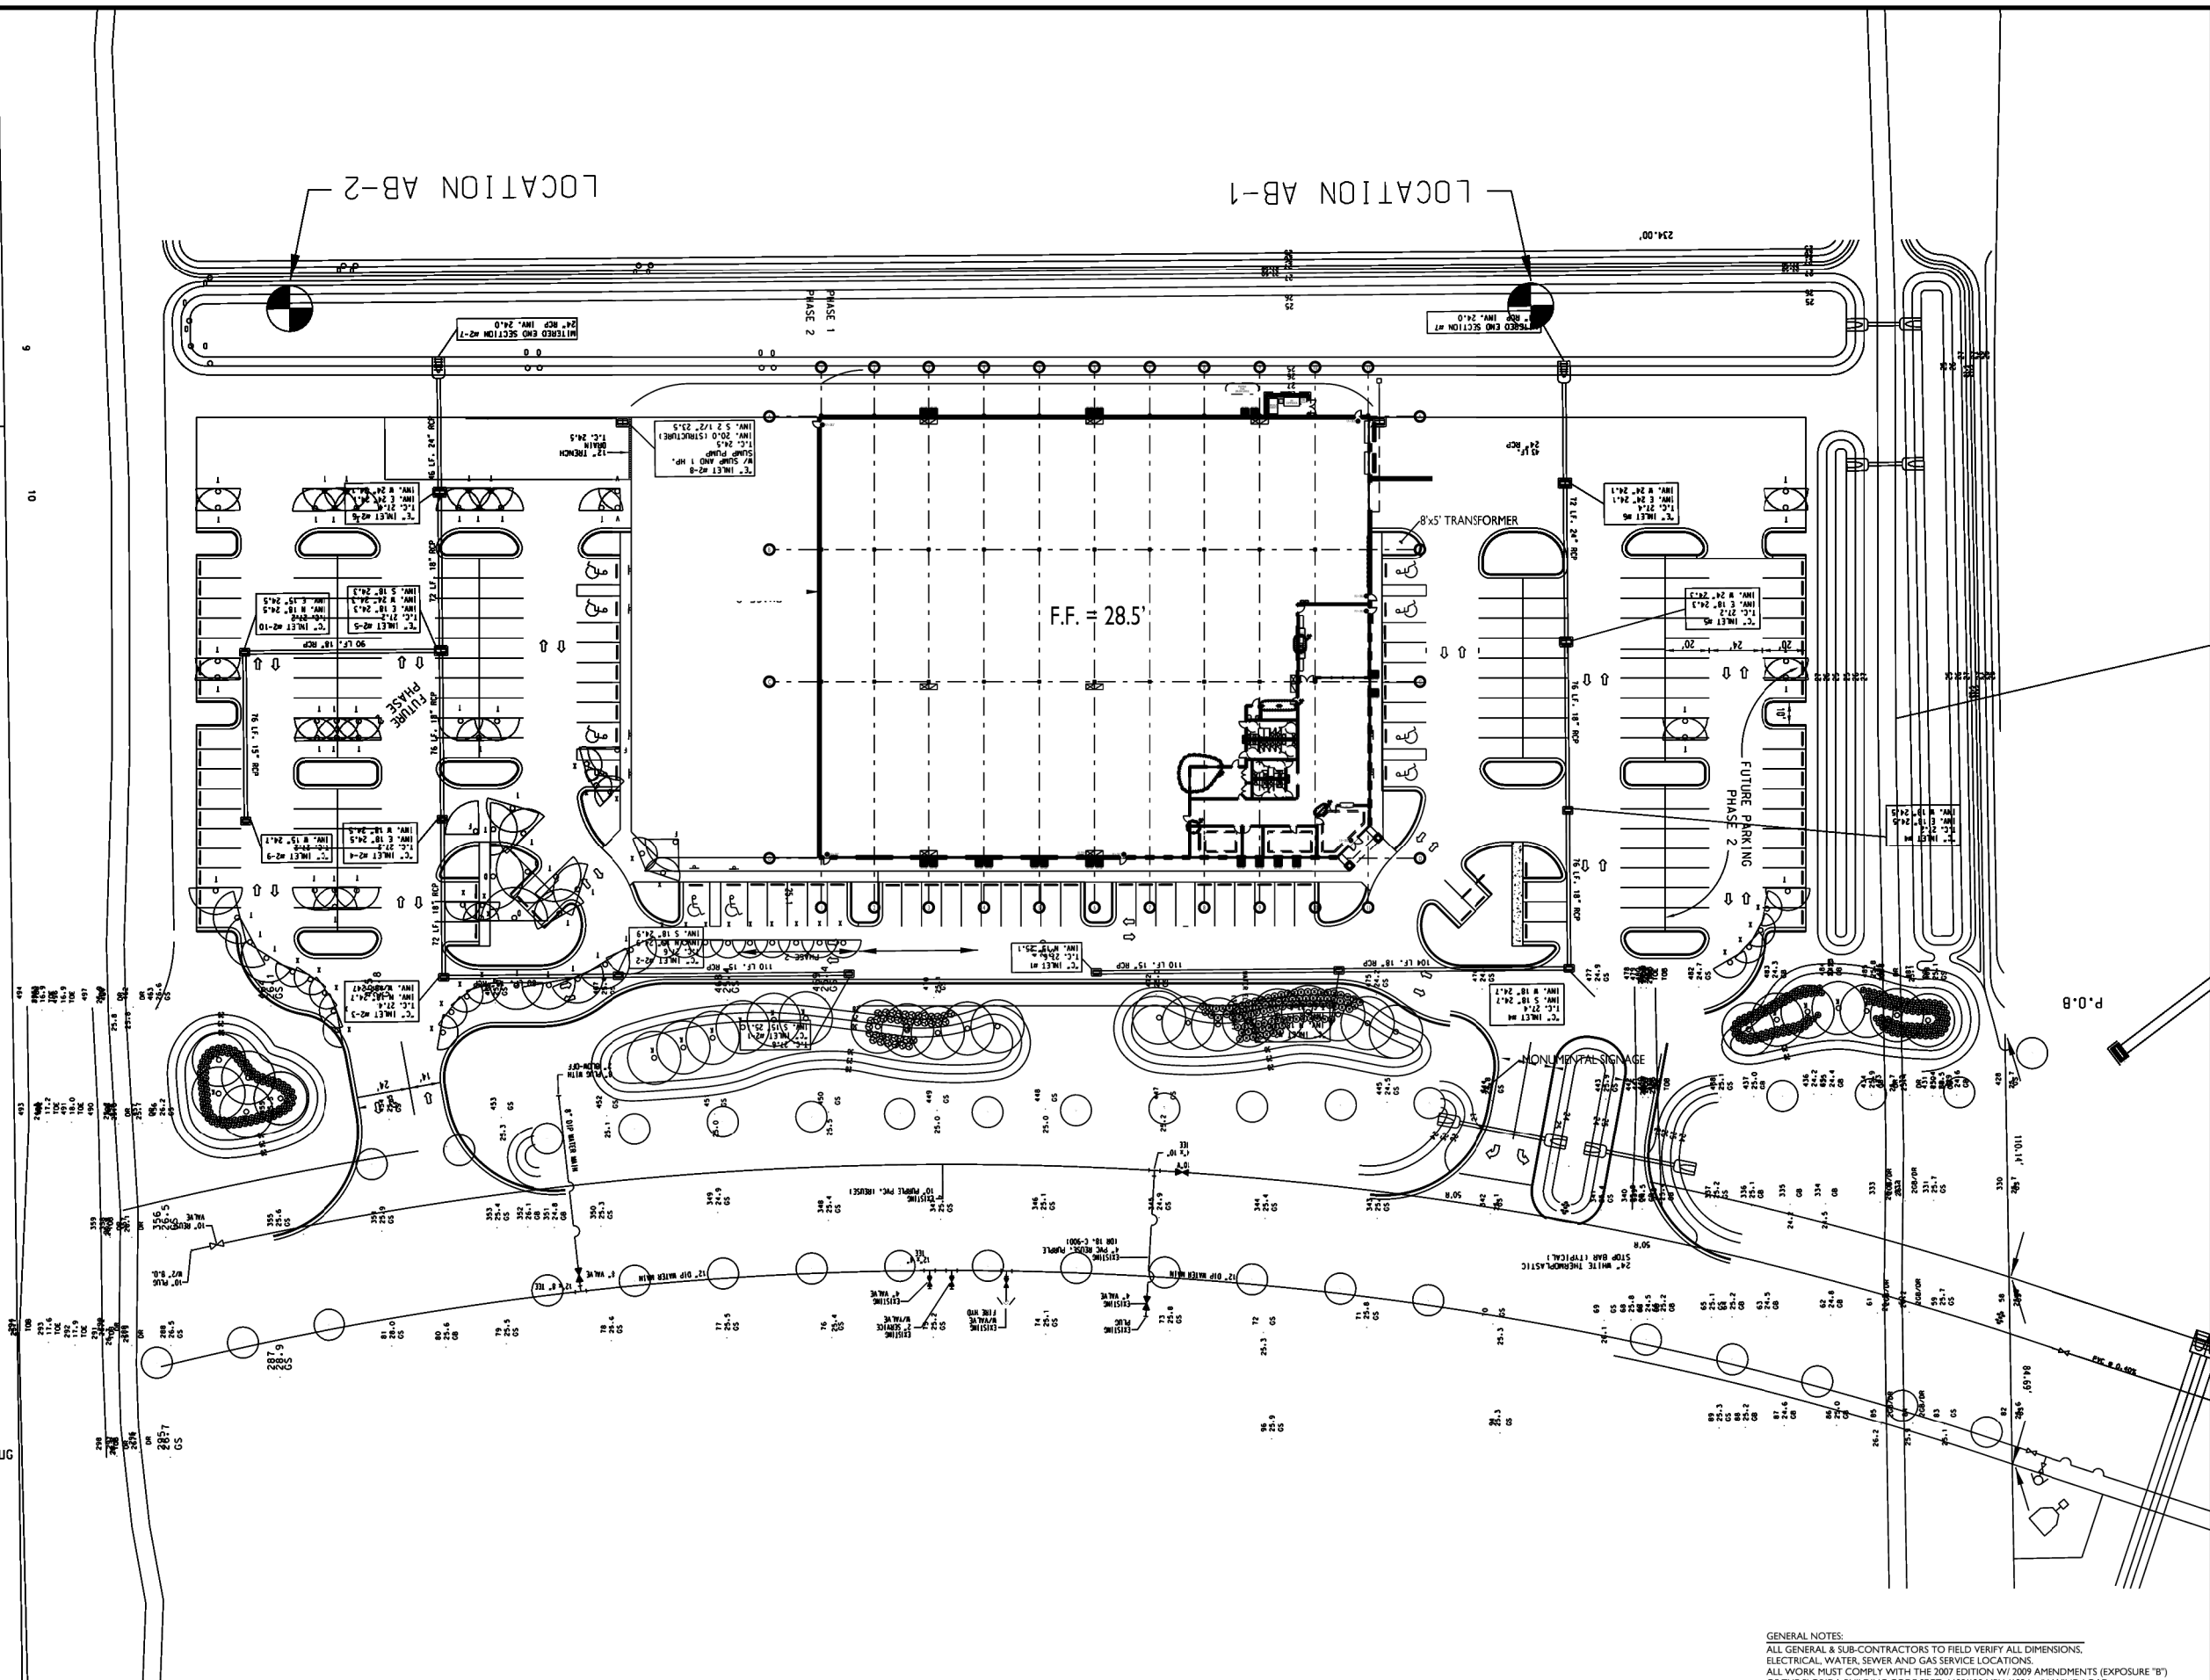

PROJECT SITE PLAN
SCALE: 1" = 40'-0"

GENERAL NOTES:
ALL GENERAL & SUB-CONTRACTORS TO FIELD VERIFY ALL DIMENSIONS.
ELECTRICAL, WATER, SEWER AND GAS SERVICE LOCATIONS.
ALL WORK MUST COMPLY WITH THE 2007 EDITION W/ 2009 AMENDMENTS (EXPOSURE "B")
OF THE FLORIDA BUILDING CODE SECT. 1609/120 MPH (193 km/h) WIND LOAD
AND THE FLORIDA ACCESSIBILITY CODE FOR BUILDING CONSTRUCTION
ALL DOOR & WINDOW OPENINGS TO MEET OR EXCEED DESIGN PRESSURE RANGE
OF 20-40 +/- PSF FOR DOORS AND 20-40 +/- PSF FOR WINDOWS
WIND IMPORTANCE FACTOR IS "1.0" AND THE BUILDING CATEGORY IS "ENCLOSED"
INTERNAL PRESSURE COEFFICIENT IS ".18" IN ACCORDANCE WITH ASCE 7-02
WILL ENGINEER AS A ENCLOSED BUILDING
EACH TENANT IS RESPONSIBLE UNDER SEPARATE PERMIT FOR COST INVOLVED WITH
INTERIOR BUILDOUT, TOILET ROOMS, CEILING, AND ALL FURNITURE, EQUIPMENT
INCLUDING BUILDING & MONUMENTAL SIGNAGE.

REVISIONS	
▲ FEB. 23, 2011	INTERIOR REVISIONS
▲ SEPT. 30, 2011	INTERIOR REVISIONS
▲ DEC. 23 2011	FIRE EXTINGUISHERS

ARK DAYTONA, INC.

OWNER/DEVELOPER: ALMIC LLC, AL KABESHITA, CHAIRMAN 3655 OHIO AVENUE, ST. CHARLES, IL 60174 PH: 630/377-8855 FAX: 630/377-0660
PROJECT LOCATION: 252 MASON AVENUE, DAYTONA BEACH, FL 32114
GENERAL CONTRACTOR: ML UNDERWOOD CONSTRUCTION, INC., MIKE UNDERWOOD, CGC 1504216, 310 WILMETTE AVENUE, SUITE 5,
ORLAND BEACH, FL 32174 PH: 386/672-6651 FX: 386/672-1793

BPF
DESIGN INCORPORATED
ARCHITECTURE, DESIGN, & DRAWING SERVICES
#AA 26001108
BRIAN P. FREDLEY, ASSOC. AIA, PROJECT MANAGER
DALLAS B. PEACOCK, AIA, ARCHITECT
#AR 0009706
207 FAIRVIEW AVENUE, DAYTONA BEACH, FL 32114
PH: (386) 257-0502 FX: (386) 257-1050
E-MAIL: bpfdesign@att.net WEBSITE: bpfdesign.net

DATE: DECEMBER 23, 2011 SCALE: 1" = 40'-0"

PROJECT SITE PLAN

SHT NO. C1