




SOFFIT DETAILS:

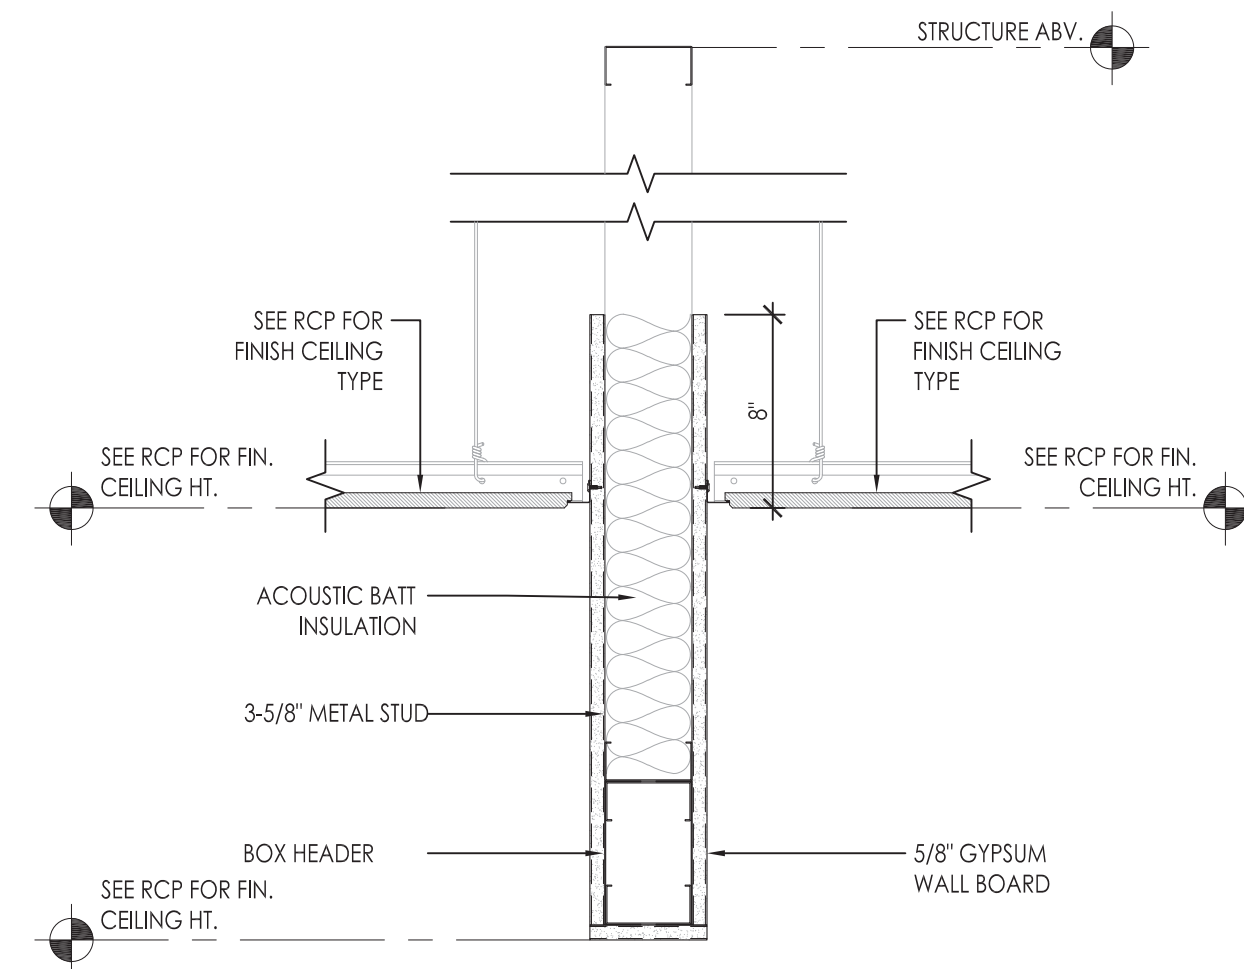

4 SOFFIT DETAIL
SCALE: 1-1/2" = 1'-0"

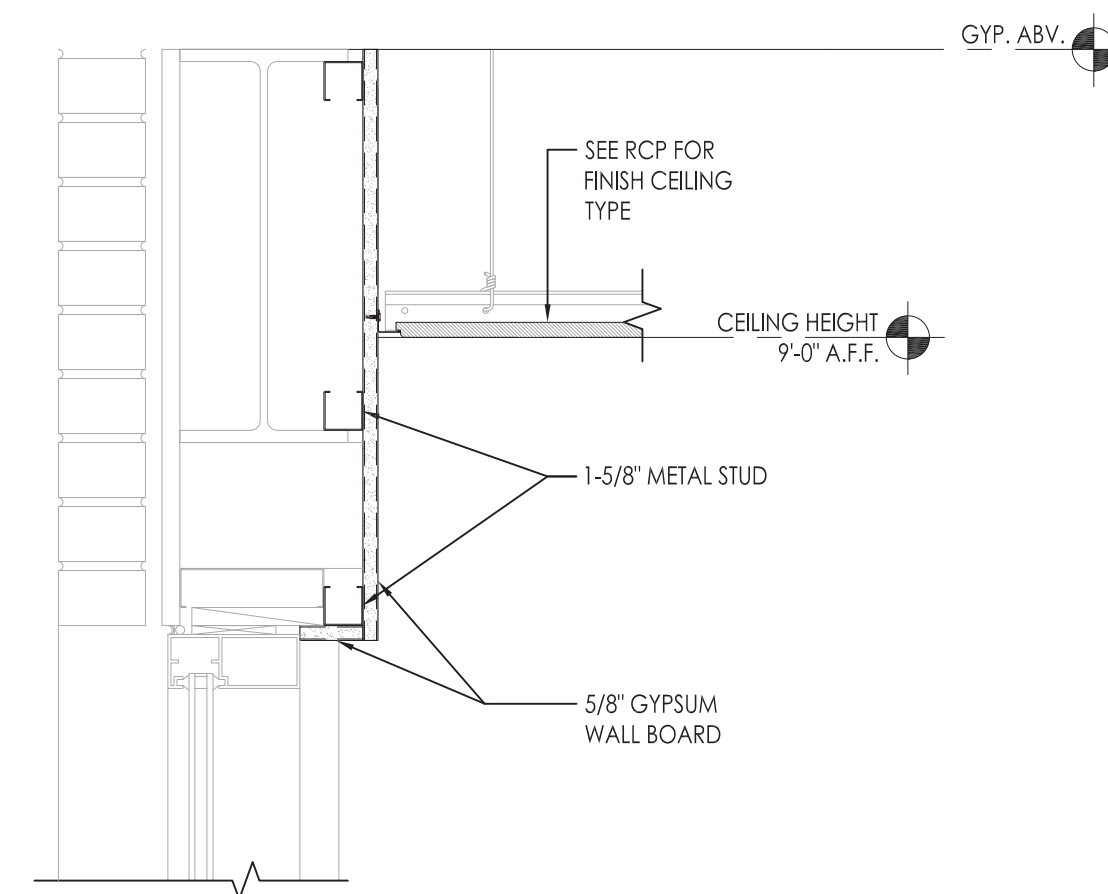


3 SOFFIT DETAIL
SCALE: 1-1/2" - 1'-0"

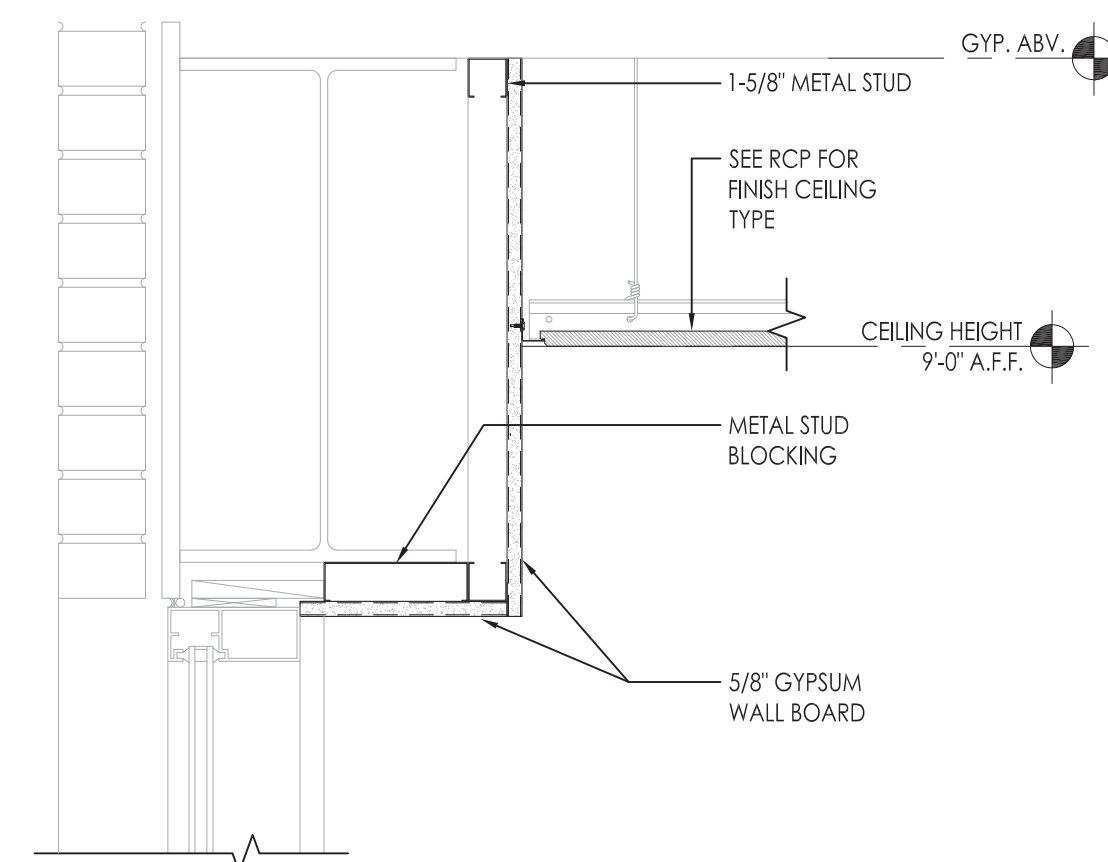

2 SOFFIT DETAIL
SCALE: 1-1/2" = 1'-0"

REFLECTED CEILING PLAN LEGEND:

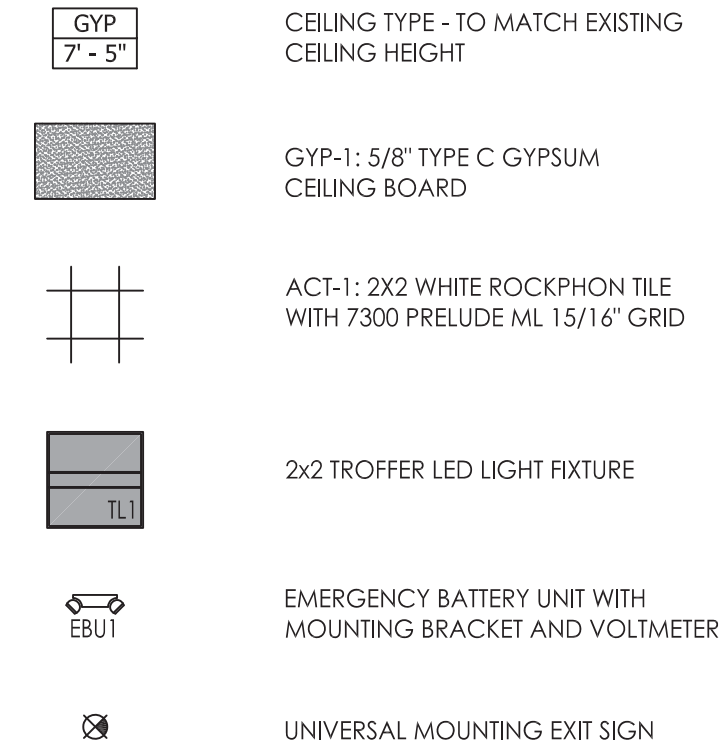

CEILING GENERAL NOTES:

1. PROVIDE GYPSUM CEILING BOARD AT LOCATIONS INDICATED
2. CENTER CEILING LIGHTS IN ROOMS UNLESS OTHERWISE NOTED
3. ALL EMERGENCY LIGHTING, FIRE ALARMS, SMOKE DETECTORS, ETC. TO BE INSTALLED BY SUBCONTRACTOR IN ACCORDANCE WITH CODE REQUIREMENTS. SYMBOLS ARE SHOWN ONLY FOR INTENT.
4. PATCH AND REPAIR ANY SURFACES PRIOR TO INSTALLATION OF NEW FINISH



architectural

PORTONE ARCHITECTS

959 Islington Street
Portsmouth, NH 03801

603.436.8891
info@portonearchitects.com

COPYRIGHT © 2022 BY PORTONE ARCHITECTS, INC.
NO REUSE WITHOUT PERMISSION


Fire Protection

lumbering

IVAC

Electrical

real

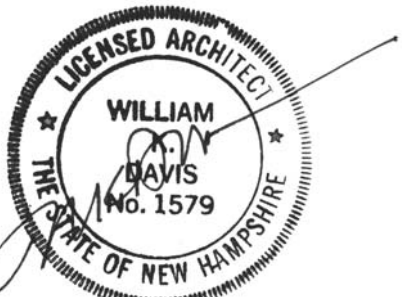[illegible][illegible]

Rev. No.

GARRISON CITY
SPEECH
SUITE #310
INTERIOR FIT-UP

51 WEBB PLACE
DOVER, NH

Phase
PERMIT DOCUMENTS

Project No.	Date
	AUG 24, 2022

cale	Drawn By: EM
As Noted	Reviewed By: WD

UNIT REFLECTED CEILING PLAN & SOFFIT DETAILS

Sheet No. _____

A1.1A

AS-BUILT DRAWING

1 UNIT REFLECTED CEILING PLAN
SCALE: 1/4" = 1'-0"

DOOR SCHEDULE:												
NO.	FROM ROOM	TO ROOM	DOOR					FRAME		HDWR	NOTES	
			WIDTH	HEIGHT	THICK.	MATL.	TYPE	MATL.	TYPE			
101-1	RECEPTION 101	CORRIDOR C101	3'-0"	7'-0"	1-3/4"	WD.	A	HM	1	SET 1	PAINT - TBD	
102-1	CORRIDOR C101	OFFICE 102	3'-0"	7'-0"	1-3/4"	WD.	A	HM	1	SET 2	PAINT PT-2 / PROVIDE GASKET ON FRAME	
103-1	CORRIDOR C101	OFFICE 103	3'-0"	7'-0"	1-3/4"	WD.	A	HM	1	SET 2	PAINT PT-2 / PROVIDE GASKET ON FRAME	
104-1	CORRIDOR C101	OFFICE 104	3'-0"	7'-0"	1-3/4"	WD.	A	HM	1	SET 2	PAINT PT-2 / PROVIDE GASKET ON FRAME	
105-1	CORRIDOR C101	OFFICE 105	3'-0"	7'-0"	1-3/4"	WD.	A	HM	1	SET 2	PAINT PT-2 / PROVIDE GASKET ON FRAME	
106-1	CORRIDOR C101	OFFICE 106	3'-0"	7'-0"	1-3/4"	WD.	A	HM	1	SET 2	PAINT PT-2 / PROVIDE GASKET ON FRAME	
107-1	CORRIDOR C101	OFFICE 107	3'-0"	7'-0"	1-3/4"	WD.	A	HM	1	SET 2	PAINT PT-2 / PROVIDE GASKET ON FRAME	
108-1	CORRIDOR C101	OFFICE 108	3'-0"	7'-0"	1-3/4"	WD.	A	HM	1	SET 2	PAINT PT-2 / PROVIDE GASKET ON FRAME	
109-1	CORRIDOR C101	OFFICE 109	3'-0"	7'-0"	1-3/4"	WD.	A	HM	1	SET 2	PAINT PT-2 / PROVIDE GASKET ON FRAME	
110-1	CORRIDOR C101	OFFICE 110	3'-0"	7'-0"	1-3/4"	WD.	A	HM	1	SET 2	PAINT PT-2 / PROVIDE GASKET ON FRAME	
111-1	CORRIDOR C101	ACTIVITY 111	3'-0"	7'-0"	1-3/4"	WD.	A	HM	1	SET 2	PAINT PT-2	
112-1	CORRIDOR C101	MATERIALS RM. 112	3'-0"	7'-0"	1-3/4"	WD.	A	HM	1	SET 3	PAINT PT-2	
113-1	CORRIDOR C101	STAFF 113	3'-0"	7'-0"	1-3/4"	WD.	A	HM	2	SET 1	PAINT PT-2	
113-2	COMMON CORRIDOR	STAFF 113	3'-0"	7'-0"	1-3/4"	WD.	A	HM	4	SET 4	20 MIN RATED DOOR/FRAME ASSEMBLY	

DOOR TYPES:	FRAME TYPES:
DOOR TYPE A FLUSH WOOD VENEER DOOR UNFINISHED (PAINT/STAIN GRADE)	FRAME TYPE 1 HOLLOW METAL DOOR FRAME

HARDWARE SCHEDULE:					
SET #	QTY.	FUNCTION	MANUFACTURER	MODEL	FINISH
SET 1	3	HINGES	HAGER	BB1279 4 1/2" x 4 1/2"	622
	1	PASSAGE LATCH	SCHLAGE	AL10S-JUP	622
	1	ANSI STRIKE - STANDARD	SCHLAGE	10-025	622
	1	FLOOR STOP	HAGER	241F	622
	3	SILENCER CLOSER	HAGER	307D	GRAY 622
SET 2	3	HINGES	HAGER	BB1279 4 1/2" x 4 1/2"	622
	1	OFFICE LOCK	SCHLAGE	AL50-JUP	622
	1	ANSI STRIKE - STANDARD	SCHLAGE	10-025	622
	1	FLOOR STOP	HAGER	241F	622
	3	SILENCER	HAGER	307D	GRAY 622
SET 3	3	HINGE	HAGER	BB1279 4 1/2" x 4 1/2"	622
	1	STORE ROOM LOCKSET	SCHLAGE	AL80PD-JUP	622
	1	ANSI STRIKE - STANDARD	SCHLAGE	10-025	622
	1	FLOOR STOP	HAGER	241F	622
	3	SILENCER	HAGER	307D	GRAY 622
SET4	3	HINGE	HAGER	BB1279 4 1/2" x 4 1/2"	622
	1	ENTRY LOCKSET	MATCH EXIST	MATCH EXIST	622
	1	ANSI STRIKE - STANDARD	SCHLAGE	10-025	GRAY 622
	3	SILENCER	HAGER	307D	GRAY 622
	1	CLOSER	YALE	4420	622

DOOR & HARDWARE GENERAL NOTES:					
1. PROVIDE SHOP DRAWINGS FOR ARCHITECT'S REVIEW PRIOR TO DOOR ORDER. 2. PROVIDE JAMB EXTENSIONS AS REQUIRED. 3. ALL KEYING SHALL BE BY GENERAL CONTRACTOR. VERIFY THE NUMBER OF KEYS REQUIRED FOR THIS PROJECT WITH THE OWNER. 4. ALL DOOR SWINGS AND OPERATIONS SHALL BE SHOWN ON PLANS AND ELEVATIONS. 5. AT HOLLOW METAL FRAMES, CAULK THE JOINT BETWEEN THE FRAME AND WALL, ALL SIDES, WITH PAINTABLE WHITE LATEX CAULK, G.C. TO PROTECT PREFINISHED DOORS AND FRAMES THROUGH THE CONSTRUCTION PERIOD. DOORS THAT ARE DAMAGED AS A RESULT OF THE G.C. OR THEIR SUBCONTRACTOR'S WORK DURING THIS PERIOD SHALL BE REPAIRED OR REPLACED BY THE G.C. 6. ALL DOOR HARDWARE SHALL BE A.D.A. ACCESSIBLE. ALL DOORS SHALL COMPLY WITH THE ICC/ANSI 404 AND SHALL HAVE LEVER OR EQUAL HARDWARE. 7. HARDWARE SCHEDULE PROVIDED AS BASIS OF DESIGN ONLY. FINAL HARDWARE SETS SHALL BE APPROVED BY ARCHITECT THROUGH SHOP DRAWINGS. 8. ALL H.M. DOORS AND FRAMES PAINTED TO MATCH PT-2, U.N.O. 10. PROVIDE GASKETING AROUND FRAME ON OFFICE DOORS.					
PLUMBING FIXTURE SCHEDULE:					
TYPE	MFR.	MODEL	DESIGNATION	MOUNT	NOTES
SINK	MOEN (OR EQUAL)	GS18191	PF-1	UNDER-MOUNT	
SINK FAUCET	MOEN	7585SR5	PF-2	SINGLE HOLE	SPOT RESISTANT STAINLESS FINISH


INTERIOR ELEVATIONS	
1 INT. ELEVATION @ OFFICE 102 SCALE: 1/2" = 1'-0"	2 INT. ELEVATION @ STAFF 113 SCALE: 1/2" = 1'-0"


DETAILS:	
3 TYP. MILLWORK DETAIL SCALE: 1-1/2" = 1'-0"	4 TYP. MILLWORK DETAIL SCALE: 1-1/2" = 1'-0"

6 TYP. DOOR HEAD DETAIL SCALE: 3" = 1'-0"	7 TYP. DOOR JAMB DETAIL SCALE: 3" = 1'-0"
--	--

CARENO CONSTRUCTION CO.	
Architectural PORT ONE ARCHITECTS 959 Islington Street Portsmouth, NH 03801 603.436.8891 info@portonearchitects.com COPYRIGHT © 2022 BY PORT ONE ARCHITECTS, INC. NO REUSE WITHOUT PERMISSION	
Structural	
Fire Protection	
Plumbing	
HVAC	
Electrical	
Seal	
LICENSED ARCHITECT WILLIAM DAVIS NO. 1579 STATE OF NEW HAMPSHIRE	
Date	
Description	
Rev. No.	
Project	GARRISON CITY SPEECH SUITE #310 INTERIOR FIT-UP 51 WEBB PLACE DOVER, NH
Phase	PERMIT DOCUMENTS
Project No.	Date AUG 24, 2022
Scale As Noted	Drawn By: EM Reviewed By: WD
Sheet Contents SCHEDULES, DOOR & FRAME TYPES, INTERIOR ELEVATIONS & DETAILS	
Sheet No.	A6.1

AS-BUILT DRAWING

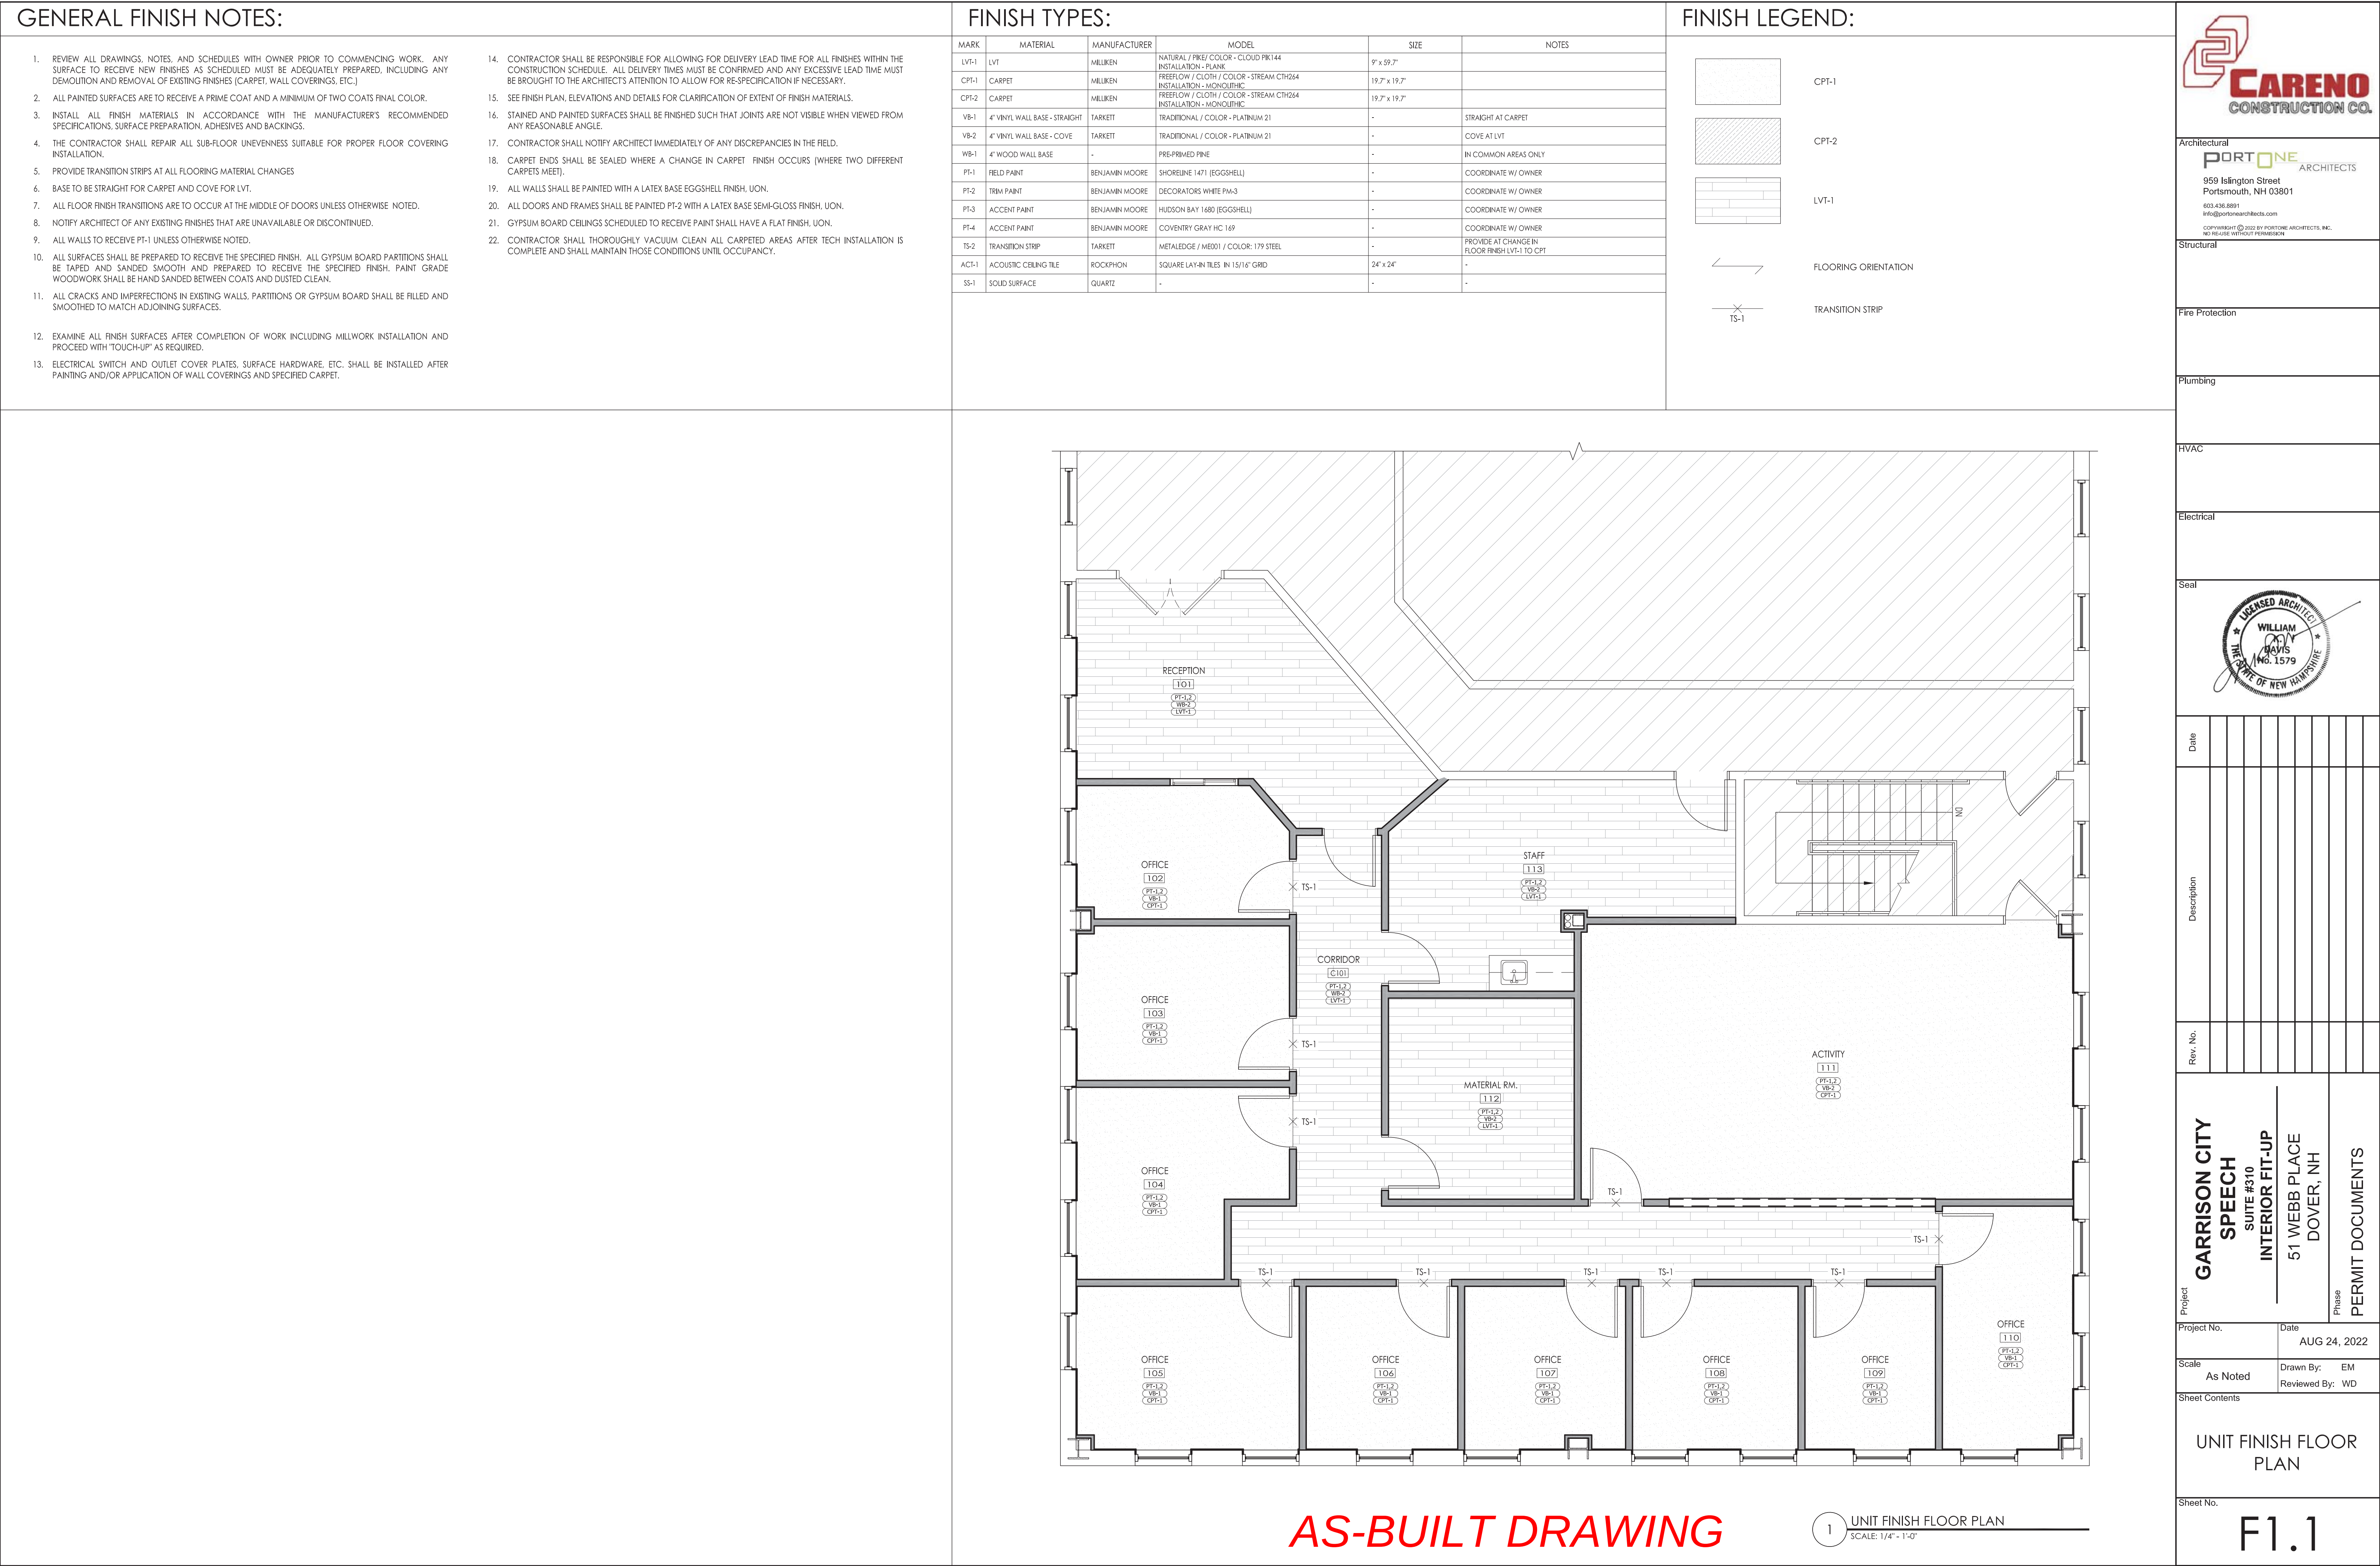


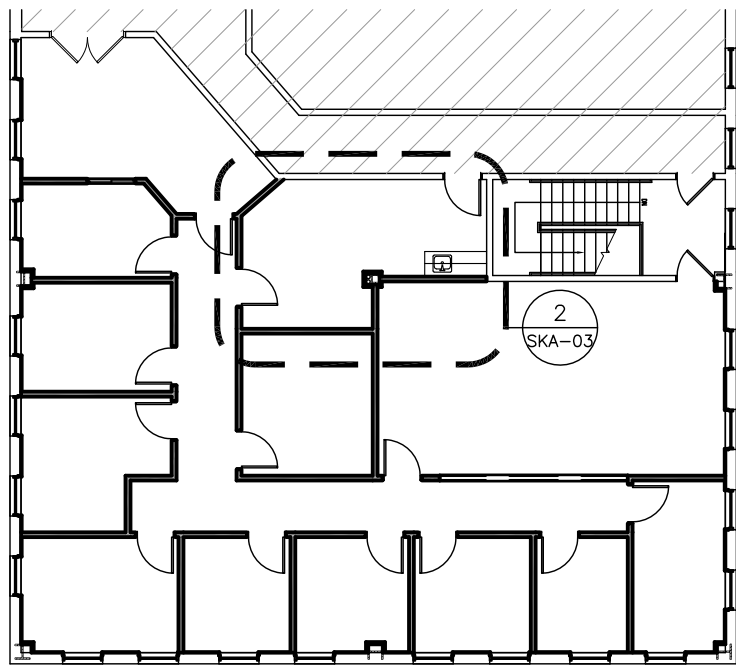

1

BUILDING KEY PLAN


SCALE: 1/16" - 1'-0"

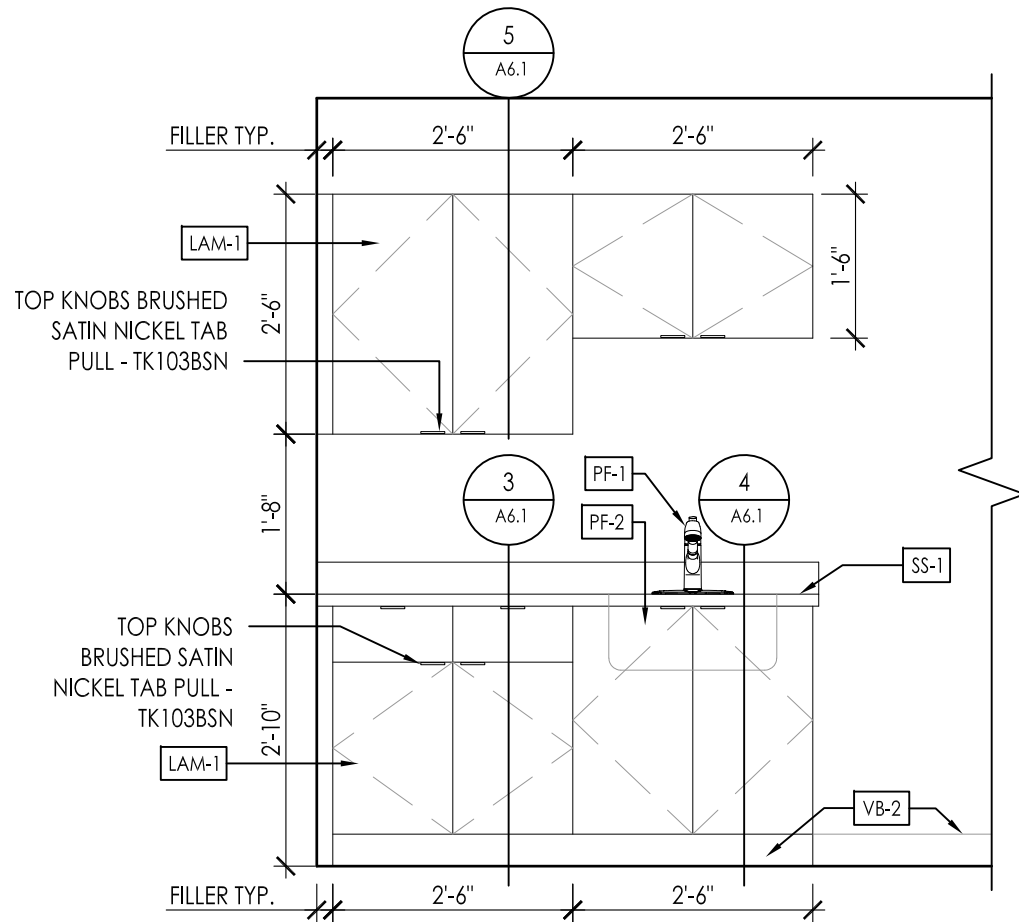

2

INTERIOR ELEVATION

SCALE: 1/2" - 1'-0"

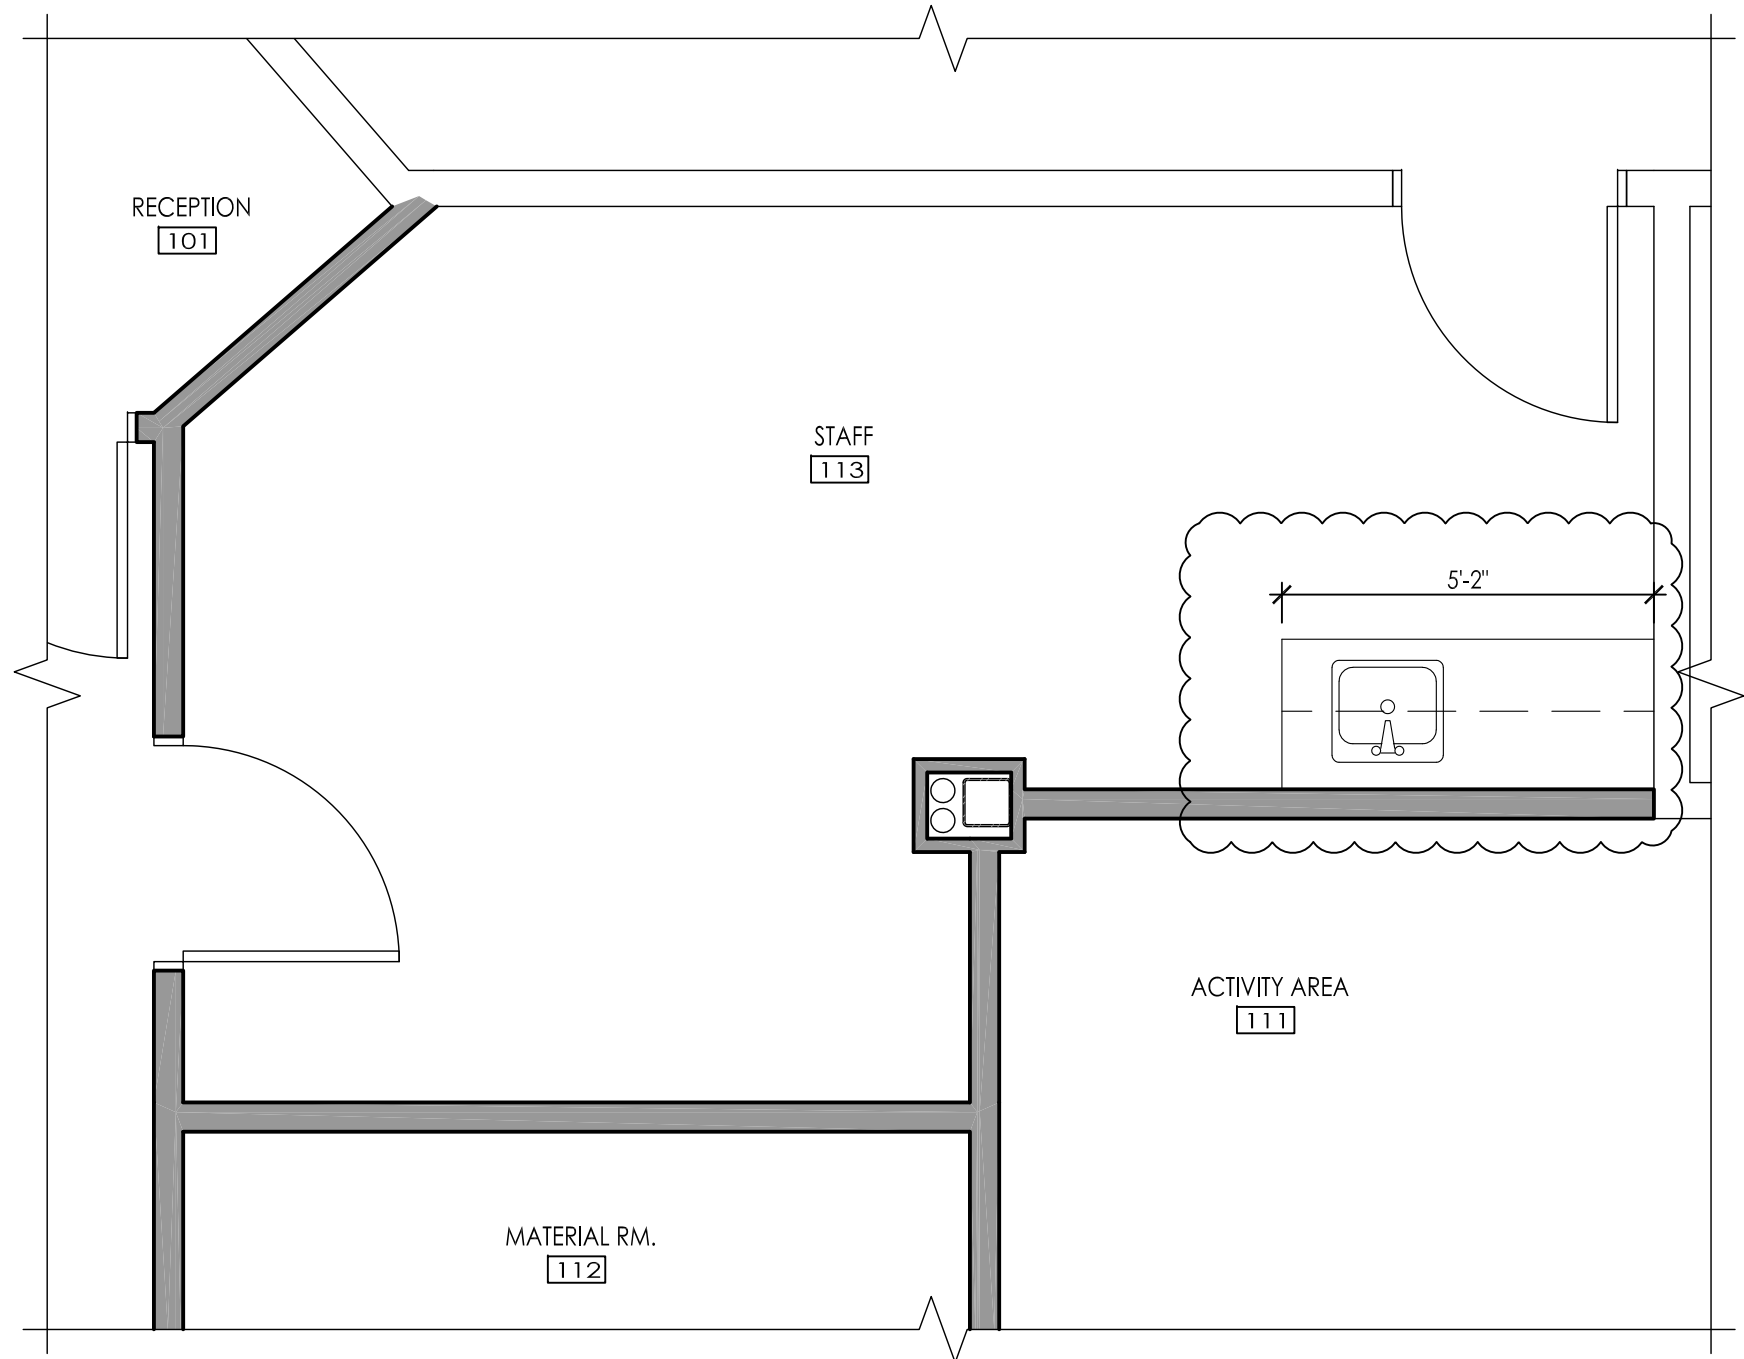


3

ENLARGED FLOOR PLAN @ STAFF 113


SCALE: 3/8" - 1'-0"

AS-BUILT DRAWING

SKA-01

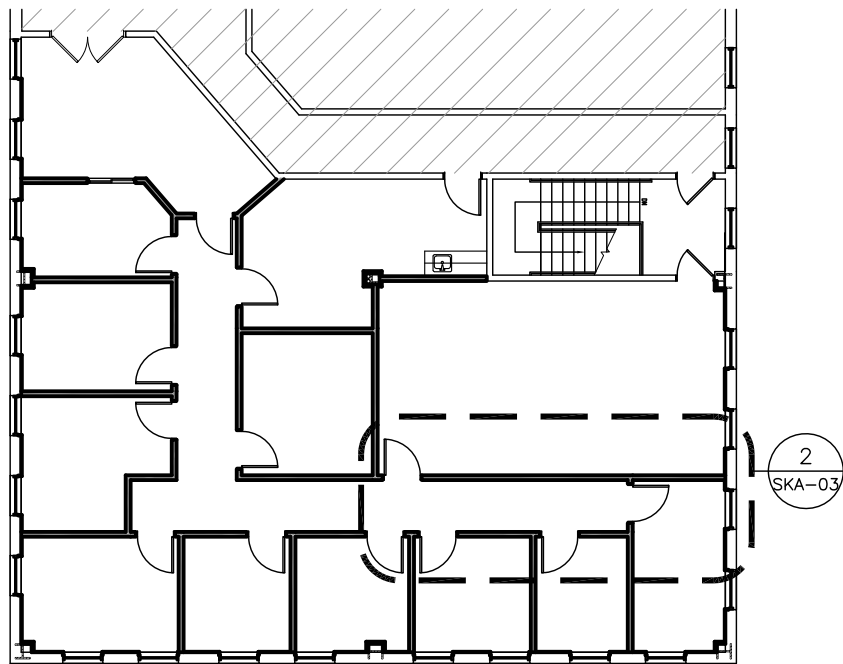

1 BUILDING KEY PLAN
SCALE: 1/16" - 1'-0"

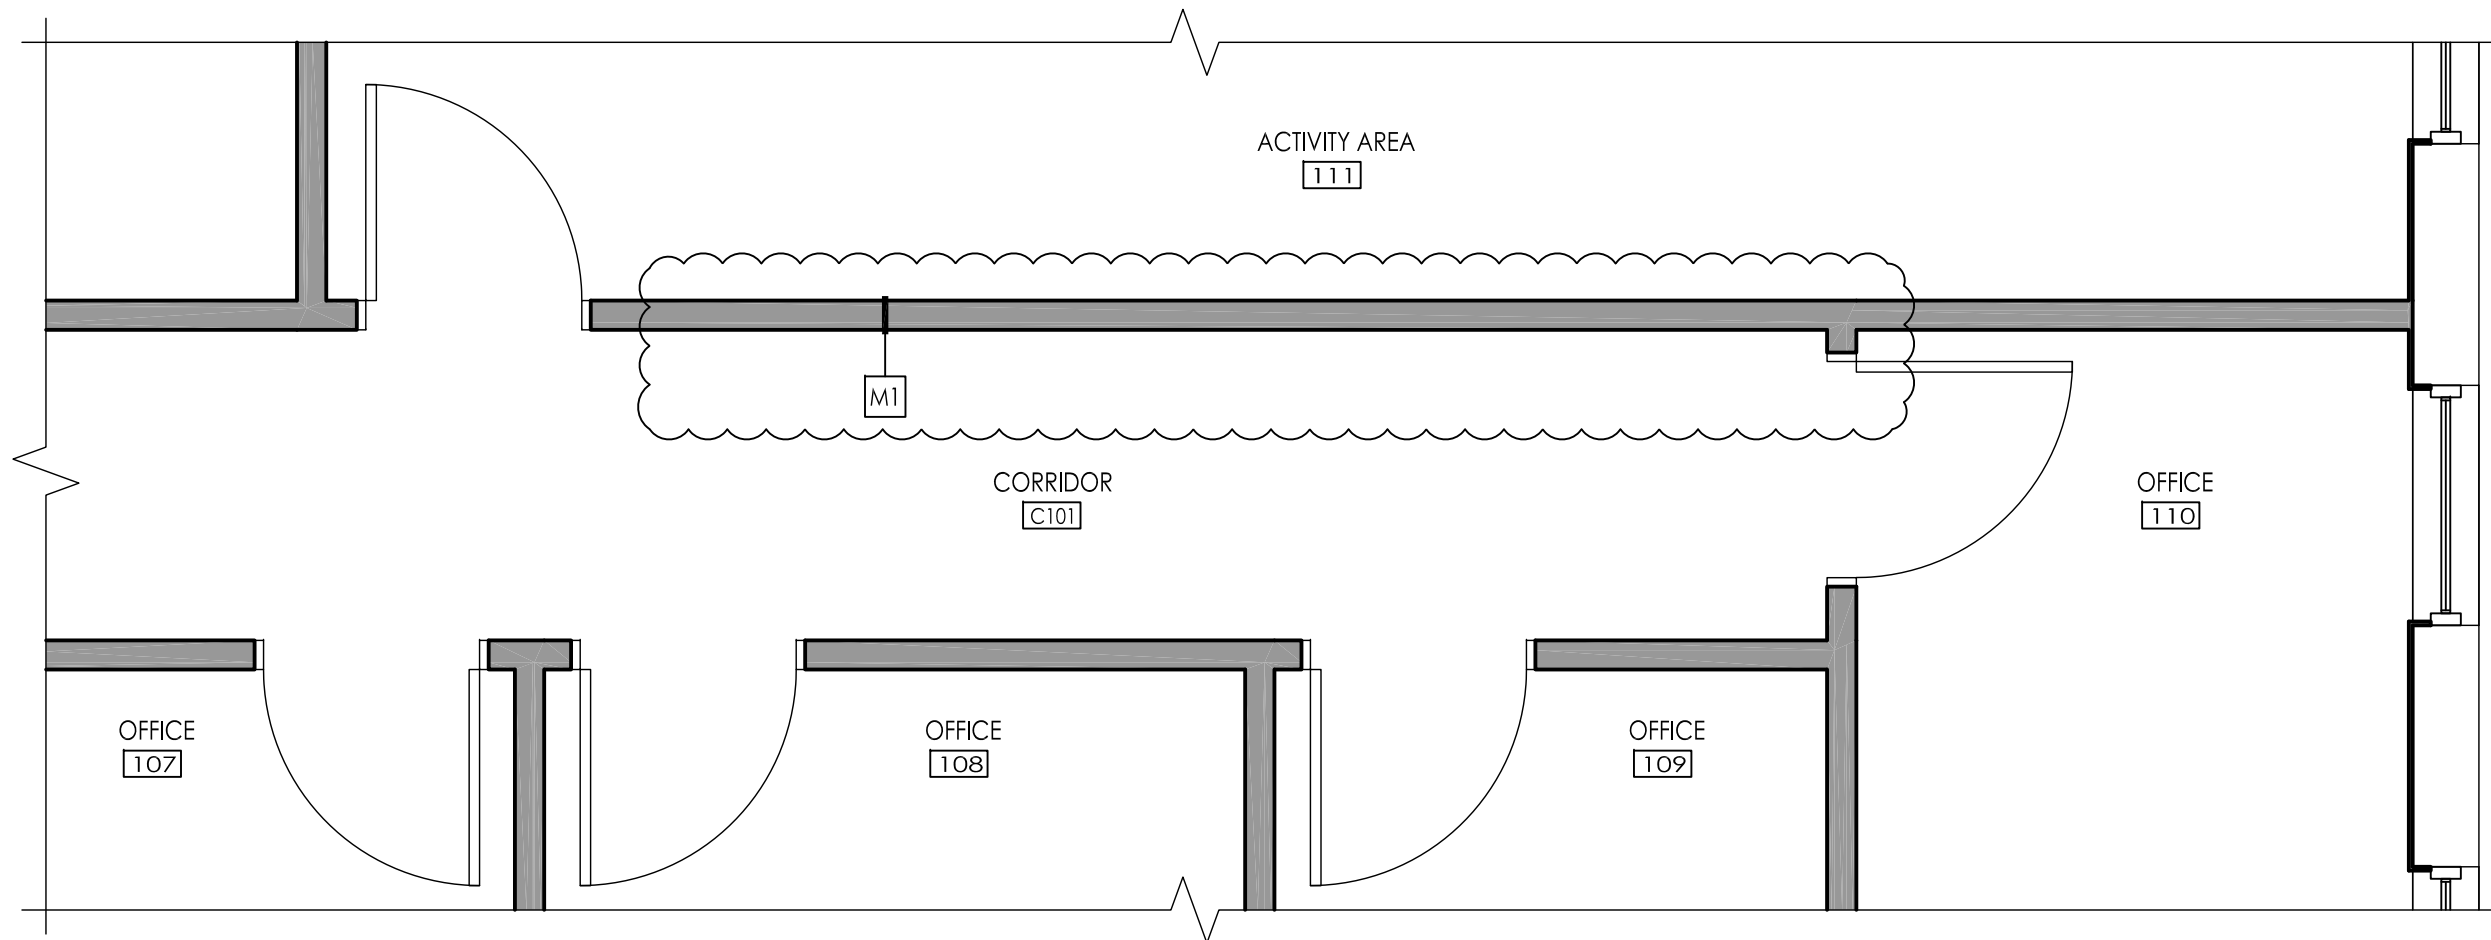

2 ENLARGED FLOOR PLAN @ ACTIVITY 111
SCALE: 3/8" - 1'-0"

AS-BUILT DRAWING



PORTONE ARCHITECTS

959 Islington Street
Portsmouth, NH 03801

603.436.8891
info@portonearchitects.com


GARRISON CITY
SPEECH
SUITE #310
INTERIOR FIT-UP

51 WEBB PLACE
DOVER, NH


REMOVAL OF
HALF-WALL @
ACTIVITY 111 AND
CORRIDOR C101

SCALE: AS NOTED
DATE: 10/05/2022


SKA-02

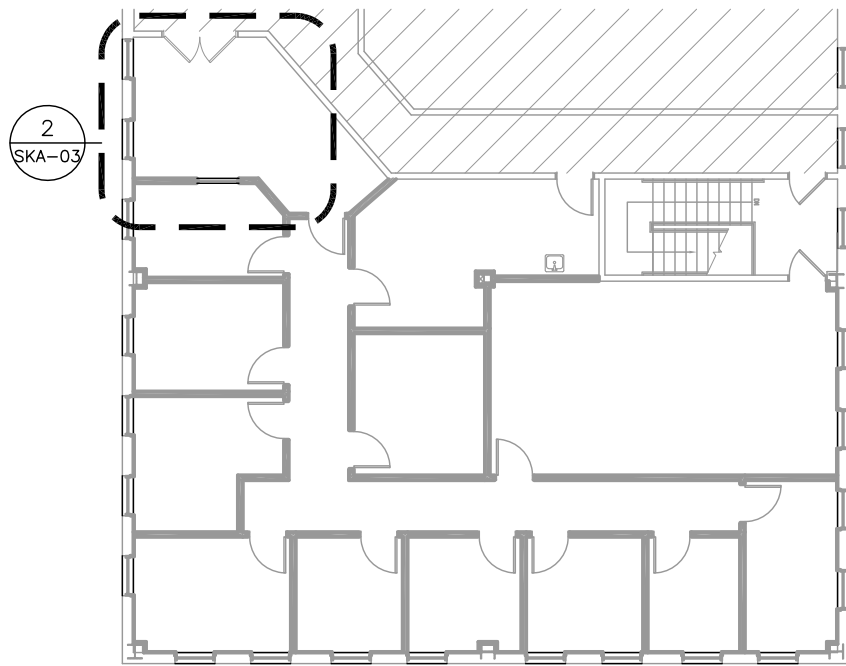


1 BUILDING KEY PLAN
SCALE: 1/16" - 1'-0"

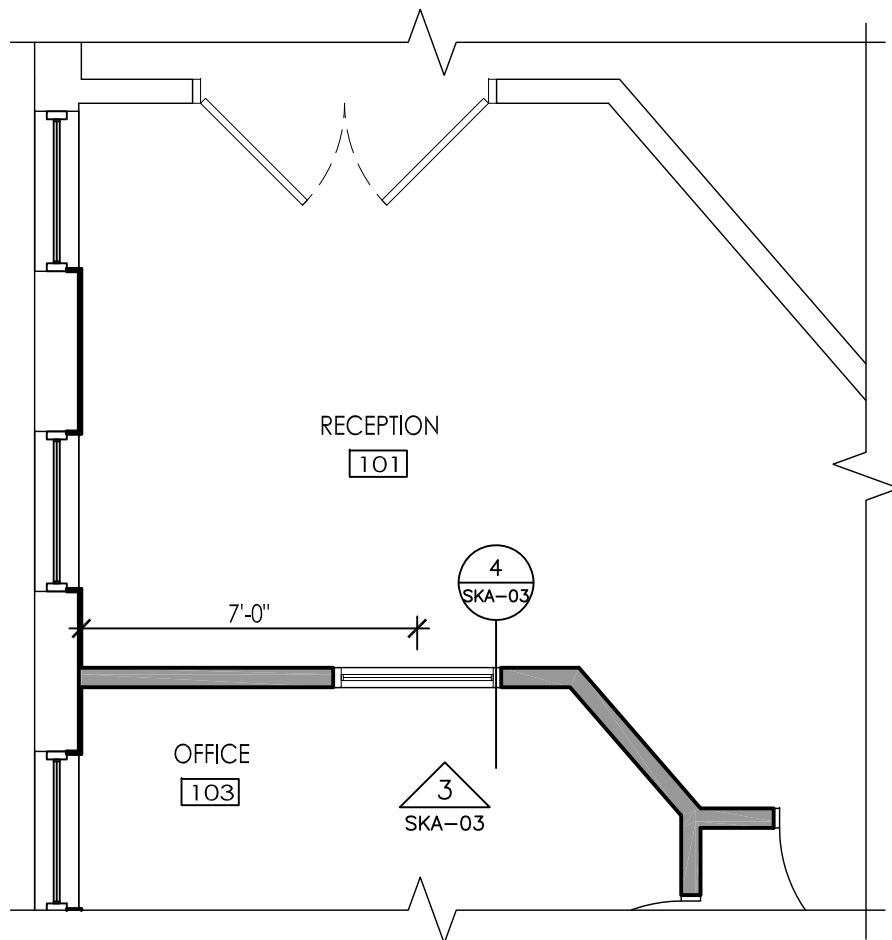

2 ENLARGED FLOOR PLAN @ ACTIVITY 111
SCALE: 1/4" - 1'-0"

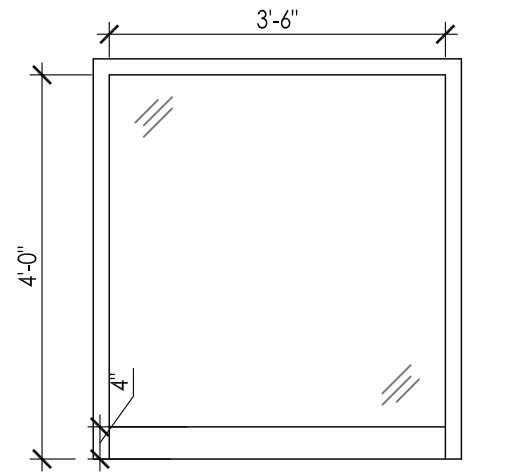


RECEPTION WINDOW - TYPE A
3-SIDED HOLLOW METAL FRAMED
SERVICE WINDOW

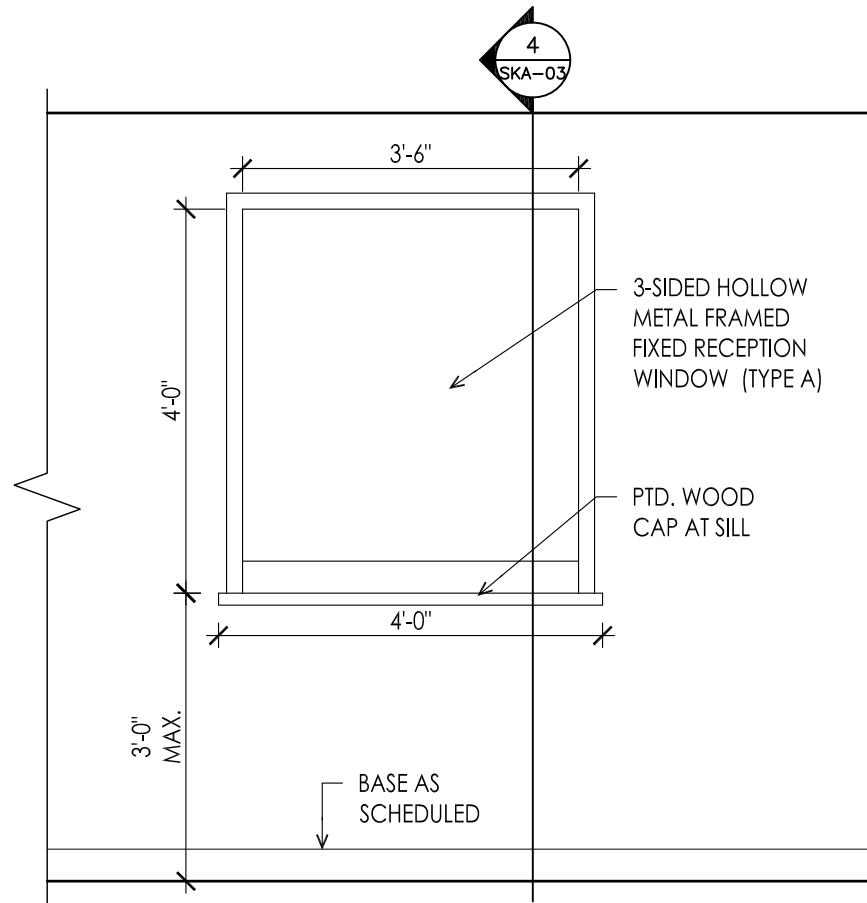

3 INTERIOR ELEVATION
SCALE: 1/2" - 1'-0"

AS-BUILT DRAWING

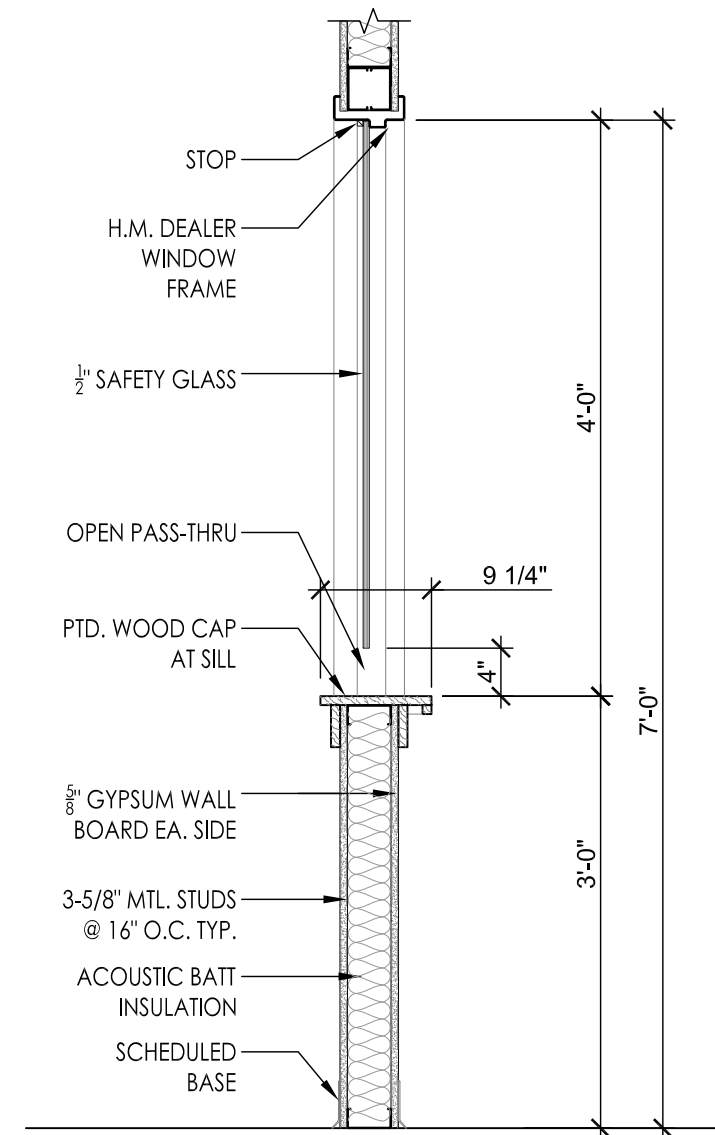

4 SERVICE WINDOW SECTION
SCALE: 3/4" - 1'-0"



PORT ONE ARCHITECTS

959 Islington Street
Portsmouth, NH 03801

603.436.8891
info@portonearchitects.com

GARRISON CITY
SPEECH
SUITE #310
INTERIOR FIT-UP

51 WEBB PLACE
DOVER, NH

RECEPTION 101
WINDOW

SCALE: AS NOTED
DATE: 10/05/2022

SKA-03

AS-BUILT DRAWING



PORTONE ARCHITECTS

959 Islington Street
Portsmouth, NH 03801

603.436.8891
info@portonearchitects.com


GARRISON CITY
SPEECH
SUITE #310
INTERIOR FIT-UP

51 WEBB PLACE
DOVER, NH

ACTIVITY AREA 111
CEILING & LIGHTING
ADJUSTMENT

SCALE: AS NOTED
DATE: 10/05/2022


SKA-04

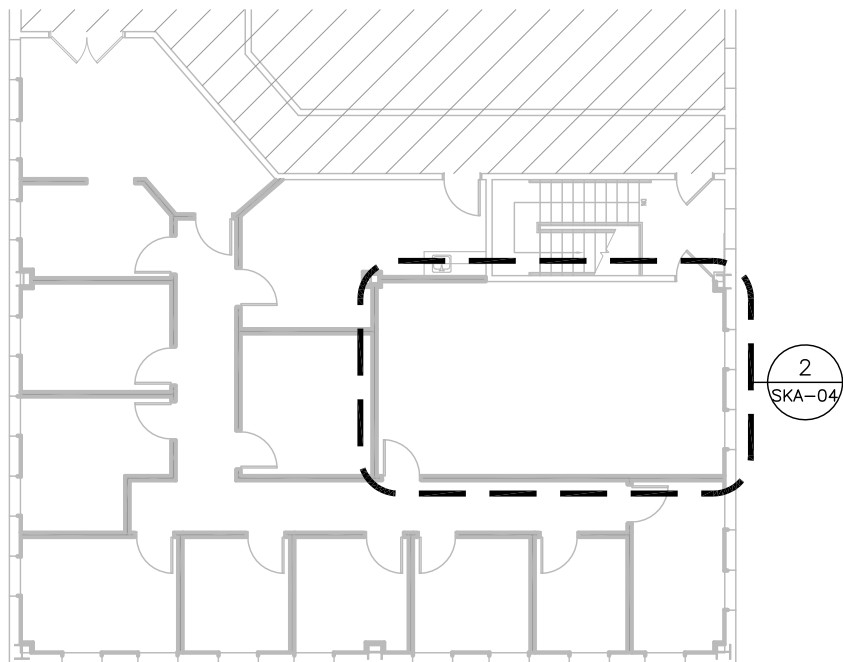



1 BUILDING KEY PLAN
SCALE: 1/16" - 1'-0"

REFLECTED CEILING LEGEND:

- | | |
|--|--|
| | CEILING TYPE - TO MATCH EXISTING
CEILING HEIGHT |
| | GYP-1: 5/8" TYPE C GYPSUM
CEILING BOARD |
| | ACT-1: 2X2 WHITE ROCKPHON TILE
WITH 7300 PRELUDE ML 15/16" GRID |
| | 2x2 TROFFER LED LIGHT FIXTURE |
| | LITHONIA BLWP4 SUSPENDED WRAP-
AROUND LIGHT FIXTURE |
| | EMERGENCY BATTERY UNIT WITH
MOUNTING BRACKET AND VOLTMETER |
| | UNIVERSAL MOUNTING EXIT SIGN |

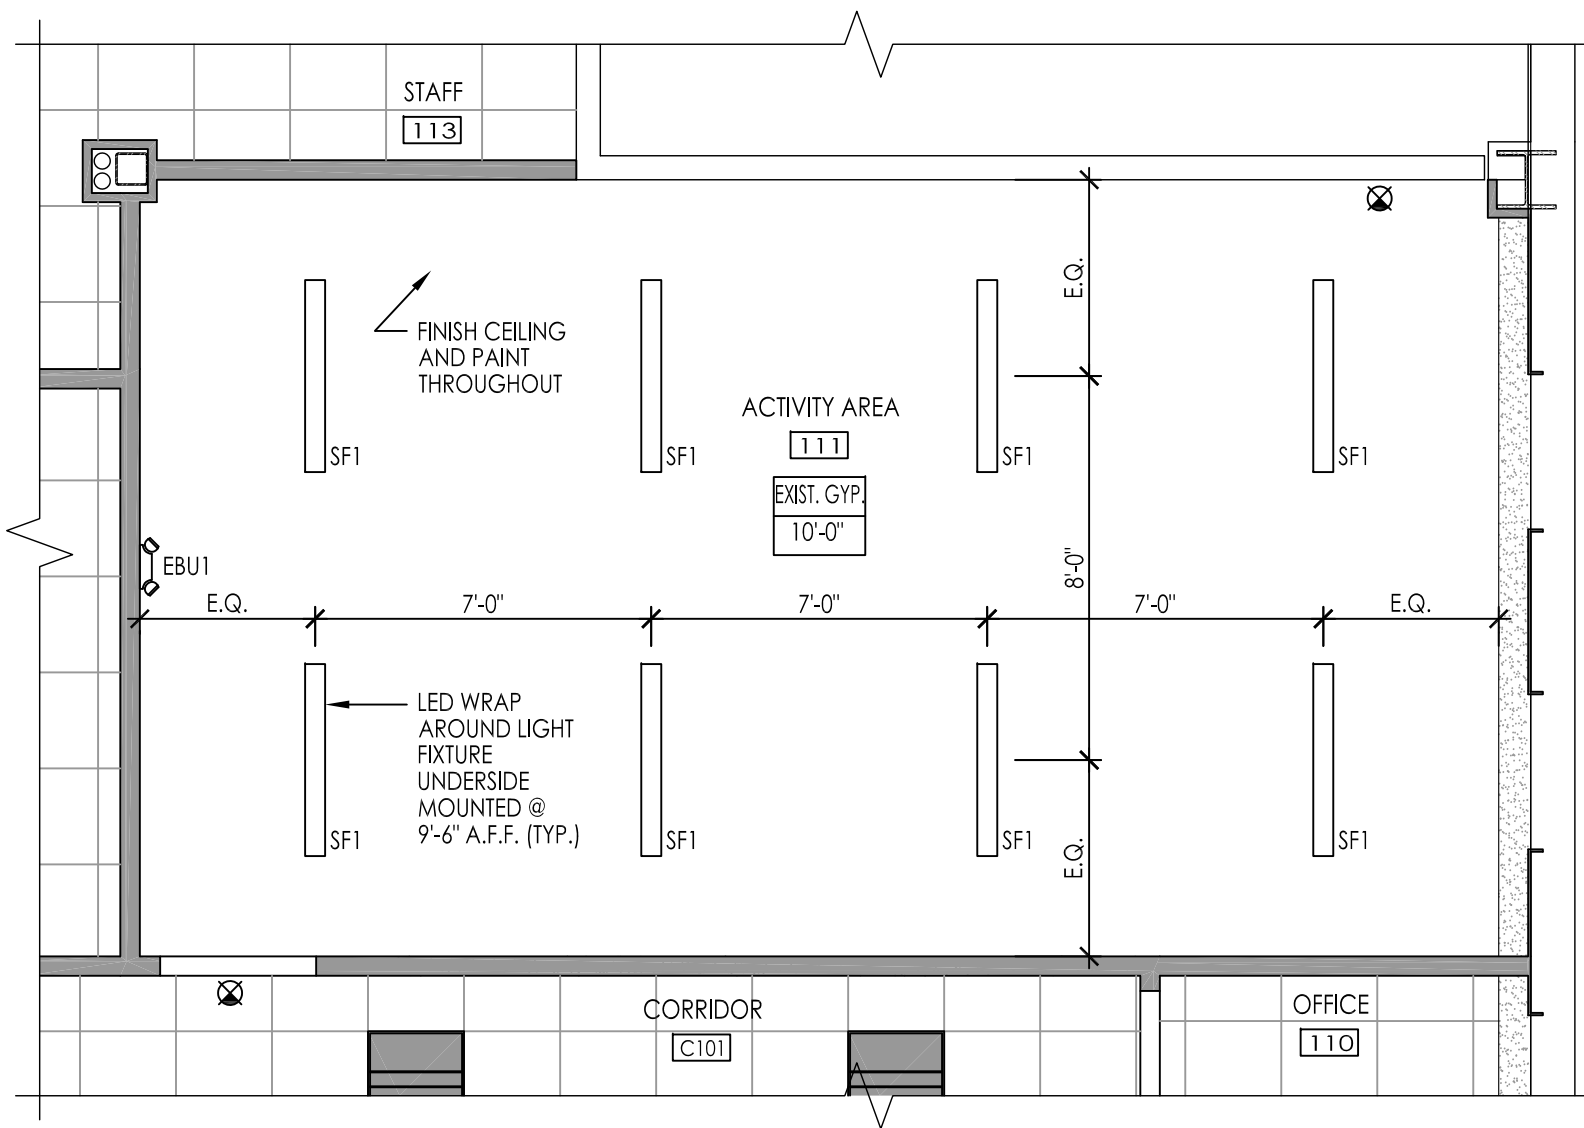

2 ENLARGED REFLECTED CEILING PLAN @ ACTIVITY AREA 111
SCALE: 1/4" - 1'-0"

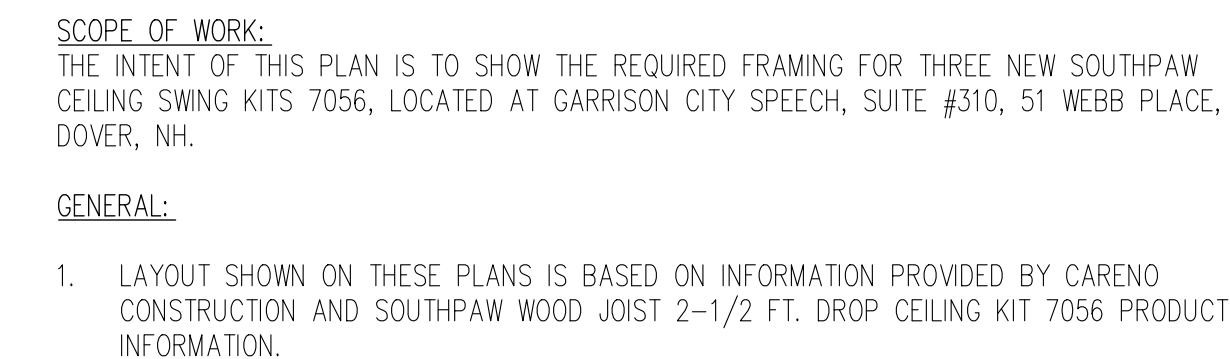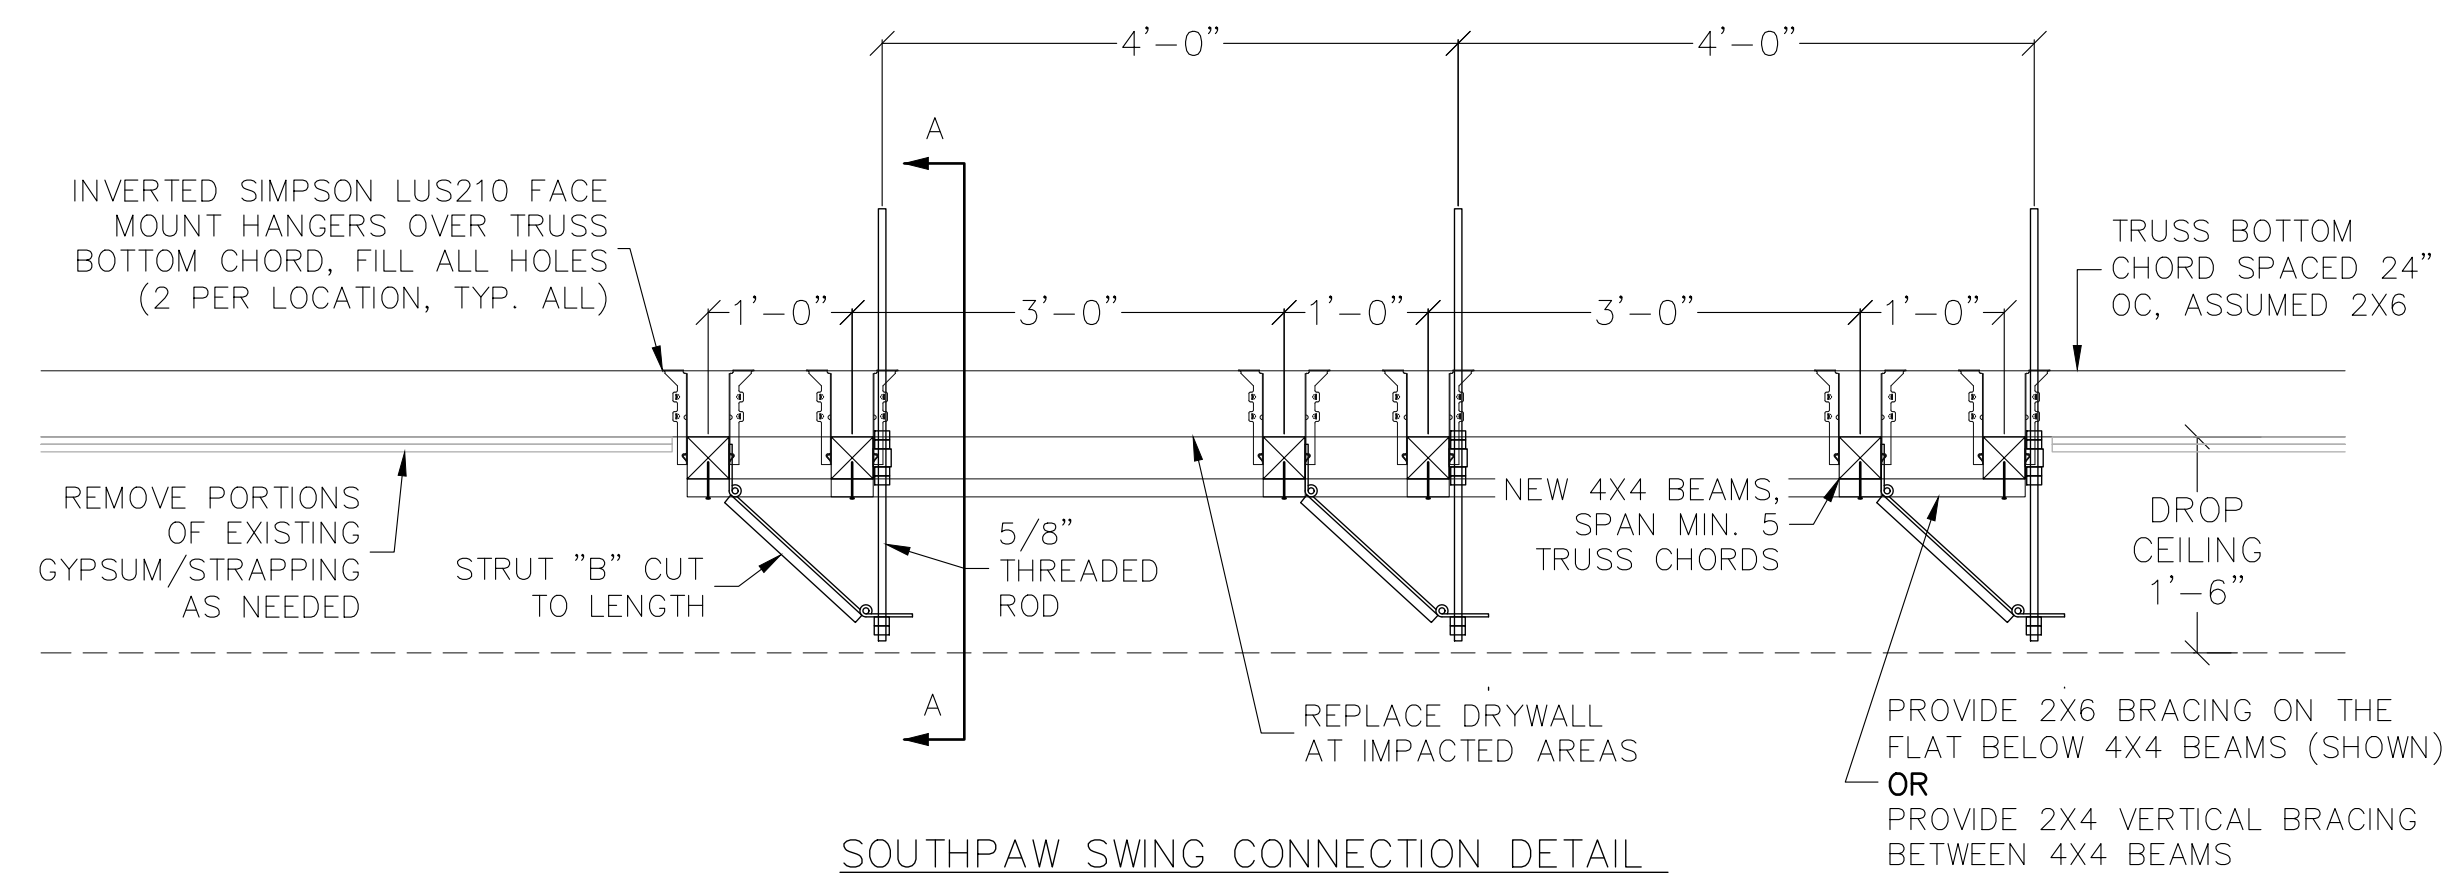

2. STRUCTURAL WORK SHALL CONFORM TO THE REQUIREMENTS OF THE INTERNATIONAL BUILDING CODE, 2015 EDITION.
3. EXAMINE OTHER TRADE DRAWINGS FOR VERIFICATION OF LOCATION AND DIMENSIONS OF CHASES, INSERTS, OPENINGS, SLEEVES, WASHES, DRIPS, REVEALS, DEPRESSIONS, AND OTHER PROJECT REQUIREMENTS NOT SHOWN ON STRUCTURAL DRAWINGS.
4. THE GENERAL CONTRACTOR SHALL VERIFY ALL EXISTING CONDITIONS AND DIMENSIONS AND SHALL REPORT ANY DISCREPANCIES TO THE ENGINEER IN WRITING. THE GENERAL CONTRACTOR SHALL PROCEED WITH THE WORK ONLY AFTER THE DISCREPANCY HAS BEEN RESOLVED TO THE SATISFACTION OF THE OWNER AND THE ENGINEER.
5. SHOP DRAWINGS FOR REINFORCING STEEL, CONCRETE MIX AND POUR SCHEDULES SHALL BE SUBMITTED TO THE ENGINEER AND A STAMPED APPROVAL RECEIVED BEFORE FABRICATION CAN PROCEED. CONSTRUCTION SHALL BE FROM APPROVED SHOP DRAWINGS ONLY.
6. DETAILS SHOWN ON ANY DRAWINGS ARE TO BE CONSIDERED TYPICAL FOR ALL SIMILAR CONDITIONS, UNLESS OTHERWISE NOTED.
7. WORK FROM GIVEN DIMENSIONS ONLY. SCALE IS INDICATED ON THE DRAWINGS FOR CONVENIENCE ONLY. IT IS NOT INTENDED THAT INFORMATION BE DETERMINED BY SCALING THE DRAWING, SOME ITEMS MAY NOT BE TO THE SCALE SHOWN DUE TO CHANGES.

LIGHT FRAME WOOD CONSTRUCTION NOTES:

1. STRUCTURAL WORK SHALL CONFORM TO THE REQUIREMENTS OF THE INTERNATIONAL BUILDING CODE, 2015 EDITION. A CONTINUOUS LOAD PATH SHALL BE PROVIDED FOR ALL ELEMENTS OF THE FRAMING MEMBERS.
2. DO NOT MIX HOT DIPPED GALVANIZED METAL WITH STAINLESS STEEL.
3. ALL ENGINEERED LUMBER SHALL BE AS SPECIFIED ON THE STRUCTURAL DRAWINGS. ANY DEVIATION WILL REQUIRE REVIEW BY CIVIL CONSULTANTS
4. MINIMUM WALL SHEATHING THICKNESS SHALL BE 1/2" UNLESS INDICATED ON THE STRUCTURAL DRAWINGS.
5. MINIMUM NAILING REQUIREMENTS ARE GIVEN IN 2015 IBC TABLE 2304.10.1.
6. MECHANICAL ANCHORAGE FASTENERS SHALL BE THOSE REQUIRED BY THE MANUFACTURER. DO NOT SUBSTITUTE OTHER FASTENERS UNLESS AUTHORIZED. CARE MUST BE MADE TO VERIFY THE CORRECT NAIL LENGTH AND THICKNESS.
7. CIVIL CONSULTANTS SHALL VISIT SITE AT THE REQUEST OF THE CONTRACTOR PRIOR TO INSTALLATION OF INSULATION AND OR DRYWALL TO INSPECT THE FOLLOWING:
 - INSTALLATION OF ANCHOR / SILL BOLTS
 - INSTALLATION OF MECHANICAL TIE DOWNS AND CONNECTORS SUCH AS STRAPS, JOIST HANGERS, HURRICANE TIES.
 - INSTALLATION OF BRACED WALLS AND STRUCTURAL MEMBERS
8. DEFECTIVE WORK NOT MEETING THE MINIMUM STANDARDS OF THE CODE OR STRUCTURAL DRAWINGS SHALL BE REMOVED AND OR RETROFIT AT THE CONTRACTORS EXPENSE.
9. SIMPSON STRONG TIE CONNECTORS ARE SPECIFICALLY REQUIRED TO MEET THE STRUCTURAL LOAD REQUIREMENTS. PRIOR TO SUBMITTING ANOTHER BRAND, VERIFY LOAD CAPACITY AND USE. PROVIDE CIVIL CONSULTANTS THIS INFORMATION. IF SUBSTITUTION IS GRANTED, CIVIL CONSULTANTS WILL PROVIDE WRITTEN APPROVAL OF SUBSTITUTION.

DESIGN LOADS (PER ASCE 7-10):

DROP CEILING KIT HAS 500 LB WORKING LOAD

AS-BUILT DRAWING

 **CIVIL CONSULTANTS**
*Engineers
Planners
Surveyors*
*P.O. Box 100
South Berwick
Maine
03908*
*207-384-2550
www.civcon.com*

NO.	REVISIONS	INT.	DATE

RECORD OWNER:

OWNER ADDRESS:

STRUCTURAL PLANS
GARRISON CITY SPEECH
1 WEBB PLACE, SUITE #310
DOVER, NEW HAMPSHIRE

PREPARED FOR:

TODD HARRINGTON
270 WEST ROAD, PORTSMOUTH, NH 03801

CLIENT ADDRESS:



DATE: 01/05/2023
DRAWN BY: DRC
CHECKED BY: GRA
APPROVED BY: GRA

CEILING FRAMING DETAILS

PROJECT NO: 22-293.00


SR1

SHEET: 1 OF 1

As-Built


1/19/23

FLOOR PLAN LEGEND

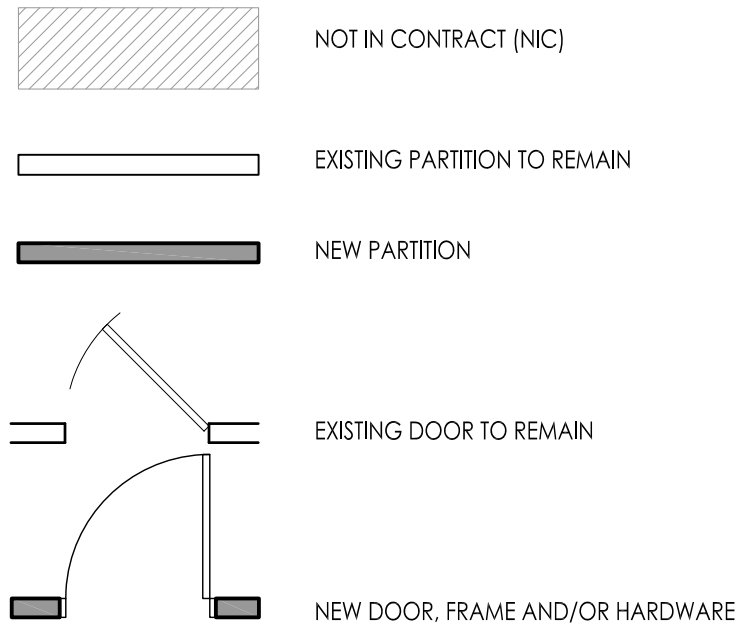


GARRISON


1	OFFICE 4/5 OUTLETS	2	COUNTER GFCI OUTLET
3	OFFICE 6/7 + HALL OUTLETS	4	FRIDGE OUTLET
5	OFFICE 2/3 OUTLETS	6	GYM OUTLETS
7	OFFICE 8/9 OUTLETS	8	STAFF RM + MENS RM OUTLETS
9	RECEPTION OFFICE #1	10	LIGHTS
11	LIGHTS	12	AIR HANDLER
13	LIGHTS	14	PANEL GFCI OUTLET
15	HALL + LOBBY OUTLETS	18	SPACE
17	PANEL OUTLET	20	SPACE
19	SPACE	22	SPACE
21	SPACE	24	SPACE
23	SPACE	26	SPACE
25	SPACE	28	SPACE
27	SPACE	30	SPACE
29	SPACE	32	SPACE
31	SPACE		

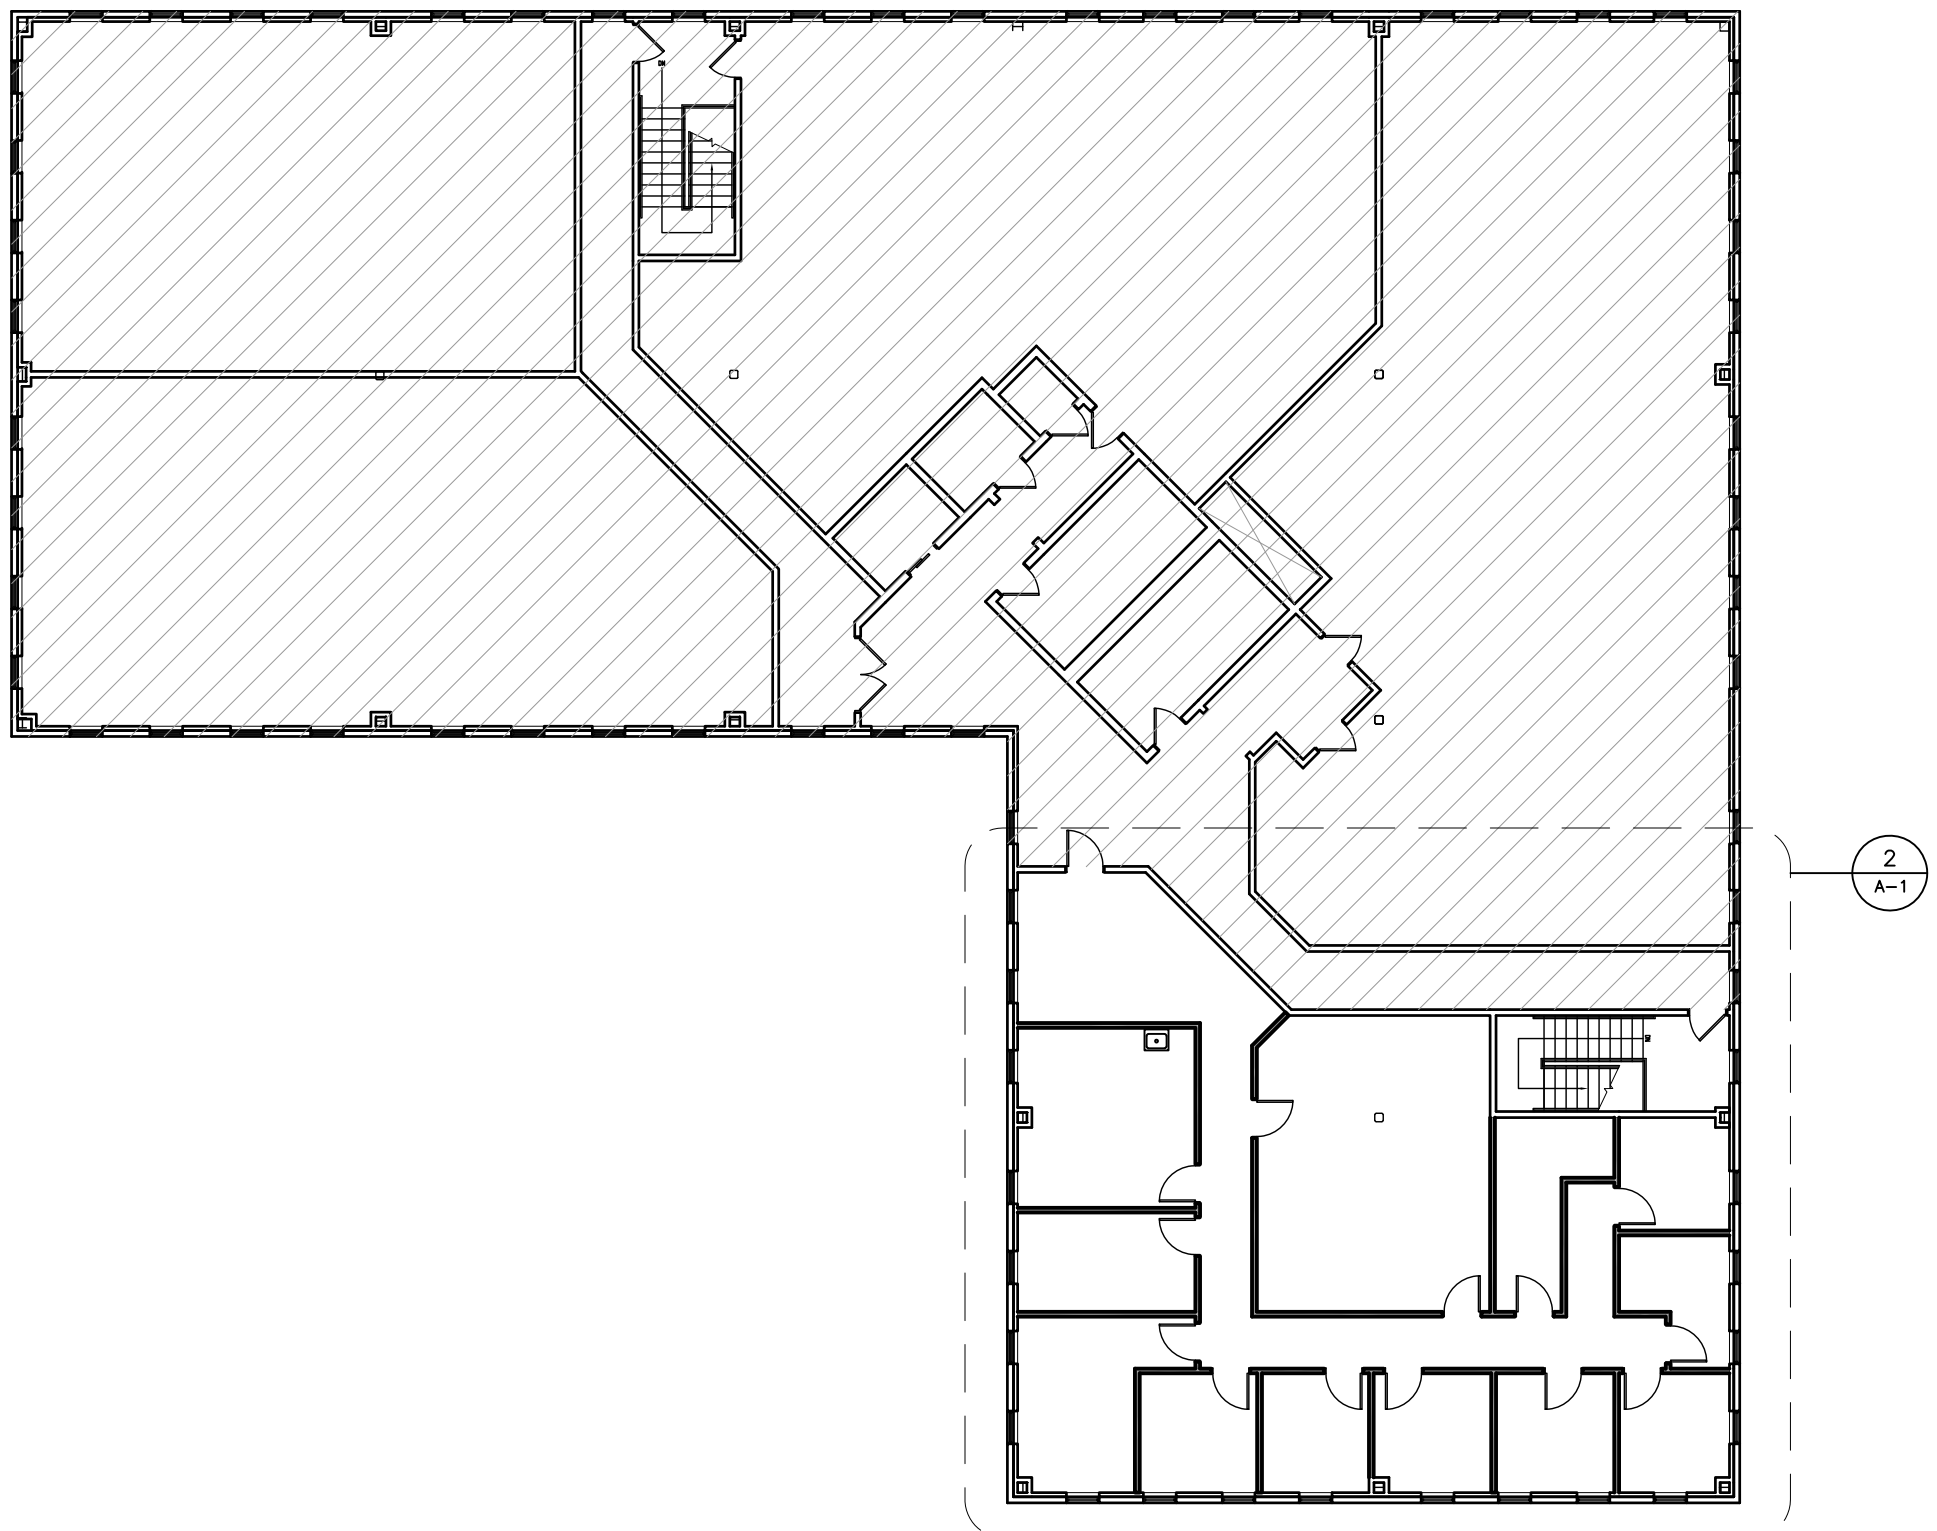

1 THIRD FLOOR KEY PLAN
1/16" = 1'-0"

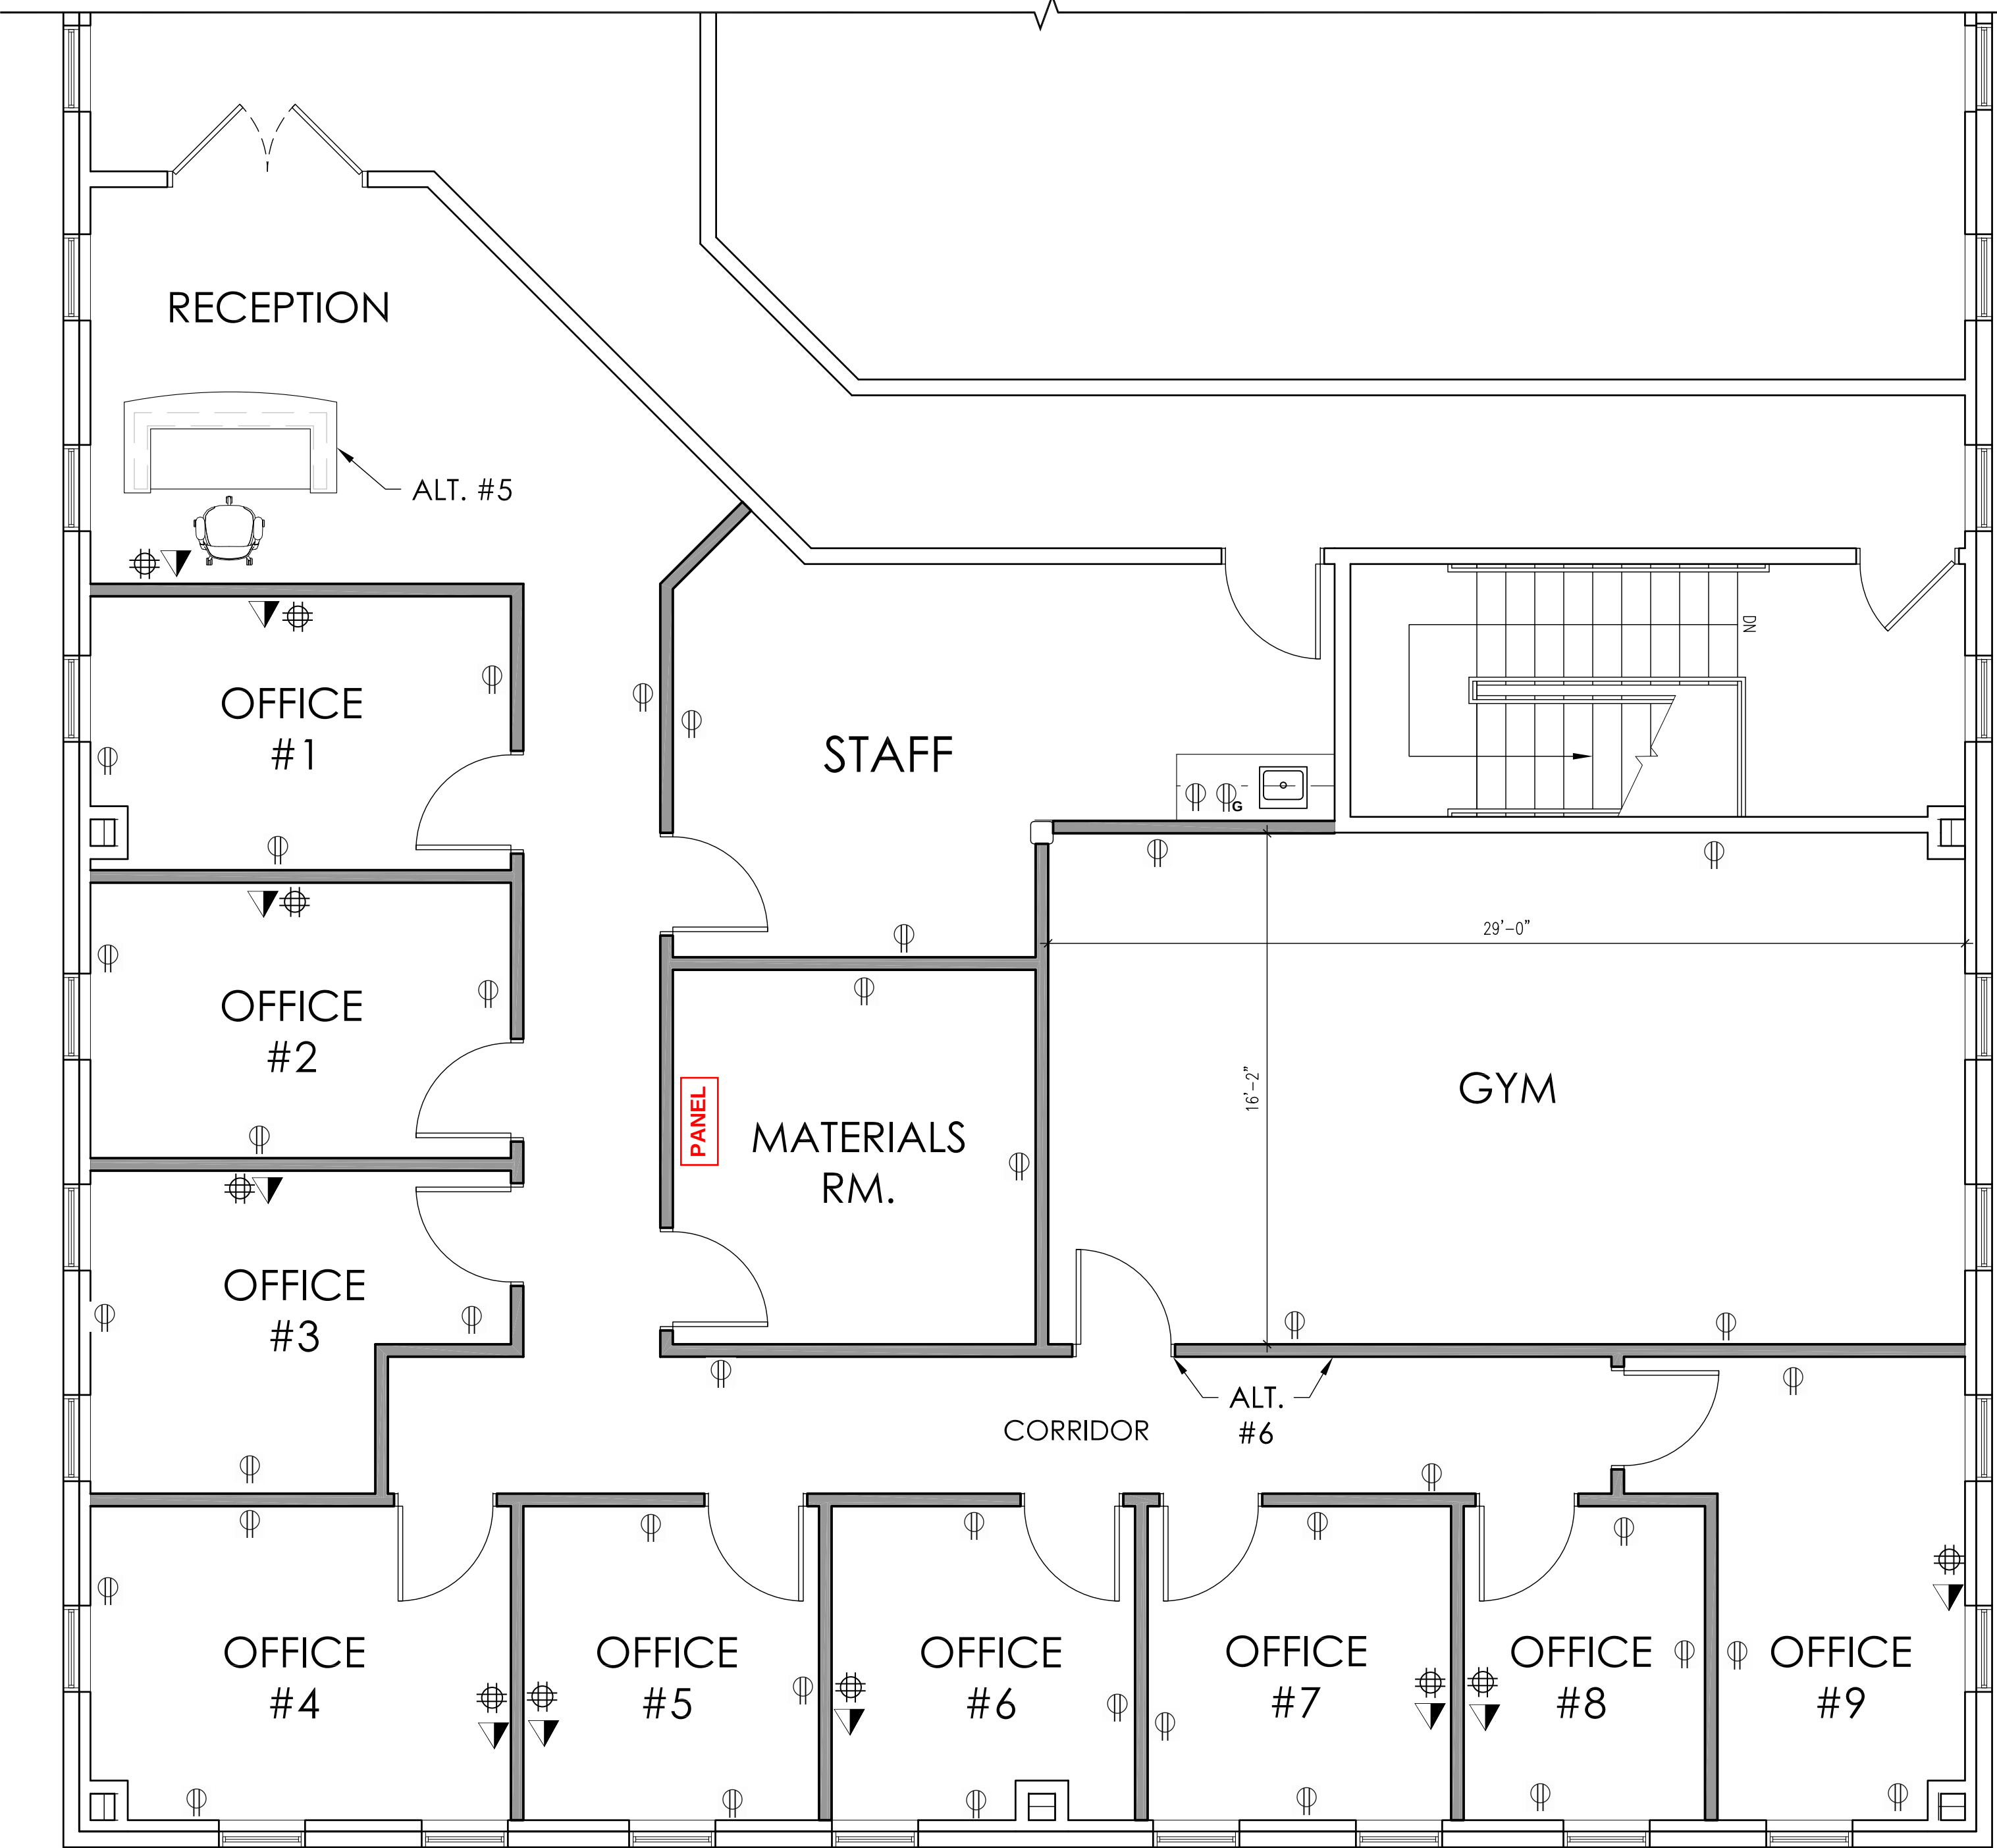


2 THIRD FLOOR PLAN (SUITE 310)
1/4" = 1'-0"

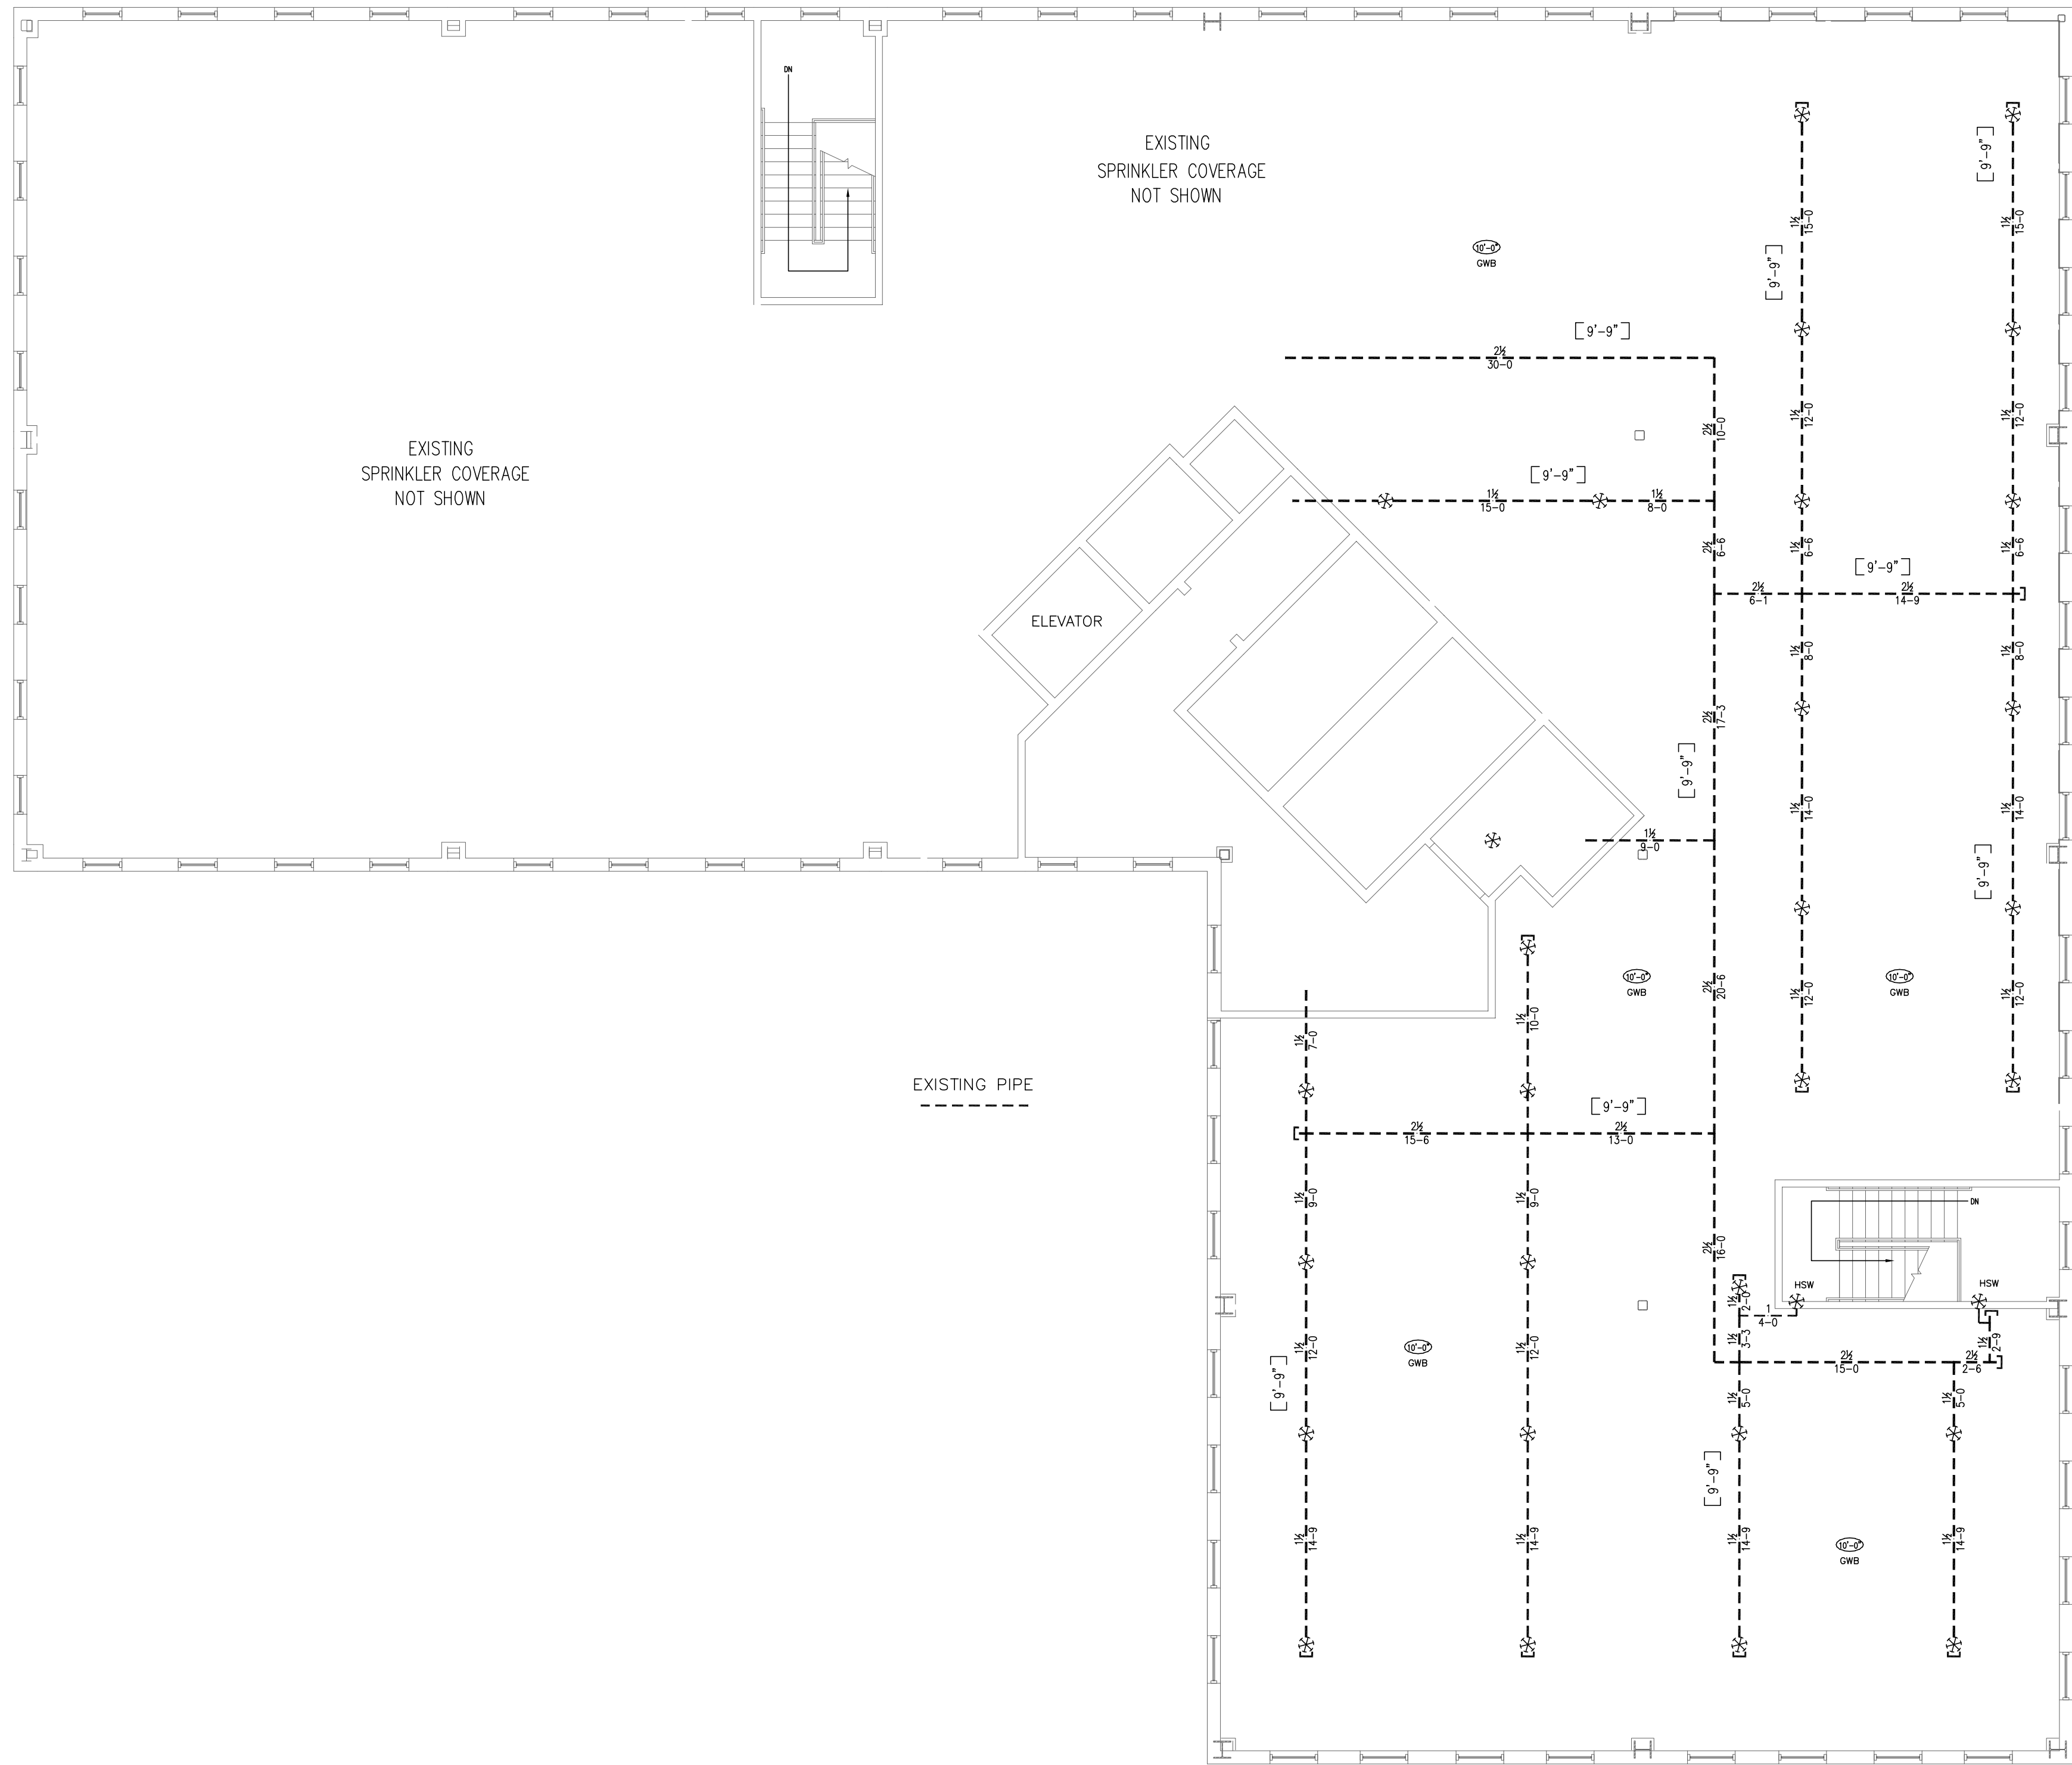

AS-BUILT DRAWING



BRIAN CARTER
DESIGNER
NICET #127646
AUTOMATIC SPRINKLER DESIGN, LEVEL IV

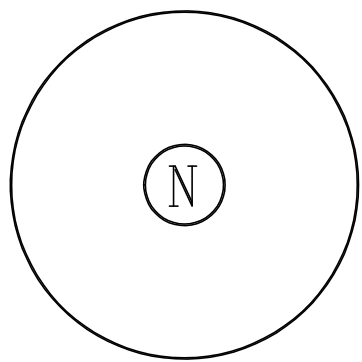

JOHN L. CARTER SPRINKLER CO. INC.
9 DUNKLEE ROAD
BOW, NH 03304
(603) 224-5438

General Notes	
1. All Pipe Locations are to be Field Measured Prior to Fabrication and Installation by Sprinkler Contractor.	
2. All Dimensions Shown are Center to Center.	
3. High Temperature Heads are to be Field Located Where Required.	
4. All Pipes and Hangers are to be Installed per NFPA #13.	
5. Hangers are to be U.L. Listed and F.M. Approved.	

Symbols		Number of Sprinklers	
Symbol	Description	Total This Sheet XX	Total This Job 51
	Hydraulic Reference Points		
	Elev. Below Top of Steel		EXISTING OR PENDENT SPRINKLER CHROME
	Elev. Above Finished Floor		
	Elev. of Top of Steel		
	Ceiling Height		
	Denotes Hanger Location		
	Rise up or down		

Drawing Title SPRINKLER PLAN 3RD FLOOR EXISTING		
Contract No.	22044	Revisions:
Drawn By	BC	Date:
Scale	1/8" = 1'-0"	
Date	10-04-2022	
Approval By		

Job:	51 WEBB PLACE 51 WEBB PLACE DOVER, NH
Contractor:	CARENO CONST. CO 270 WEST RD SUITE 4 PORTSMOUTH, NH

