


Date Issued:

11/14/2014  
04/20/2015  
05/11/2015

SD Issue  
FOR REVIEW  
PERMIT/ADA REVIEW

Project Number: 14008

**Offices at 111 Nugent**  
111 North Nugent Avenue  
Johnson City, Texas 78636

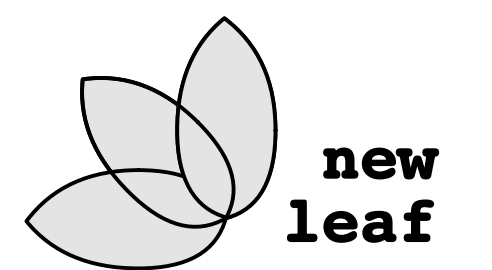

new leaf design  
po box 1826, johnson city, tx 78636  
kimberly@new-leaf.us 830/469-9677

**PERMIT/ADA**

 
**MEP & Structural**

**M&S Engineering**  
376 Landa Street  
New Braunfels, TX 78130  
(830) 629-2988

Sheet Content:

RCP  
RCP Details

Scale: As Noted




File Name: 14008-A4.0 RCP & Details.vwx

Drawn By: KNR

Checked By: KNR

Plot Date: May 15, 2015

**A4.0**

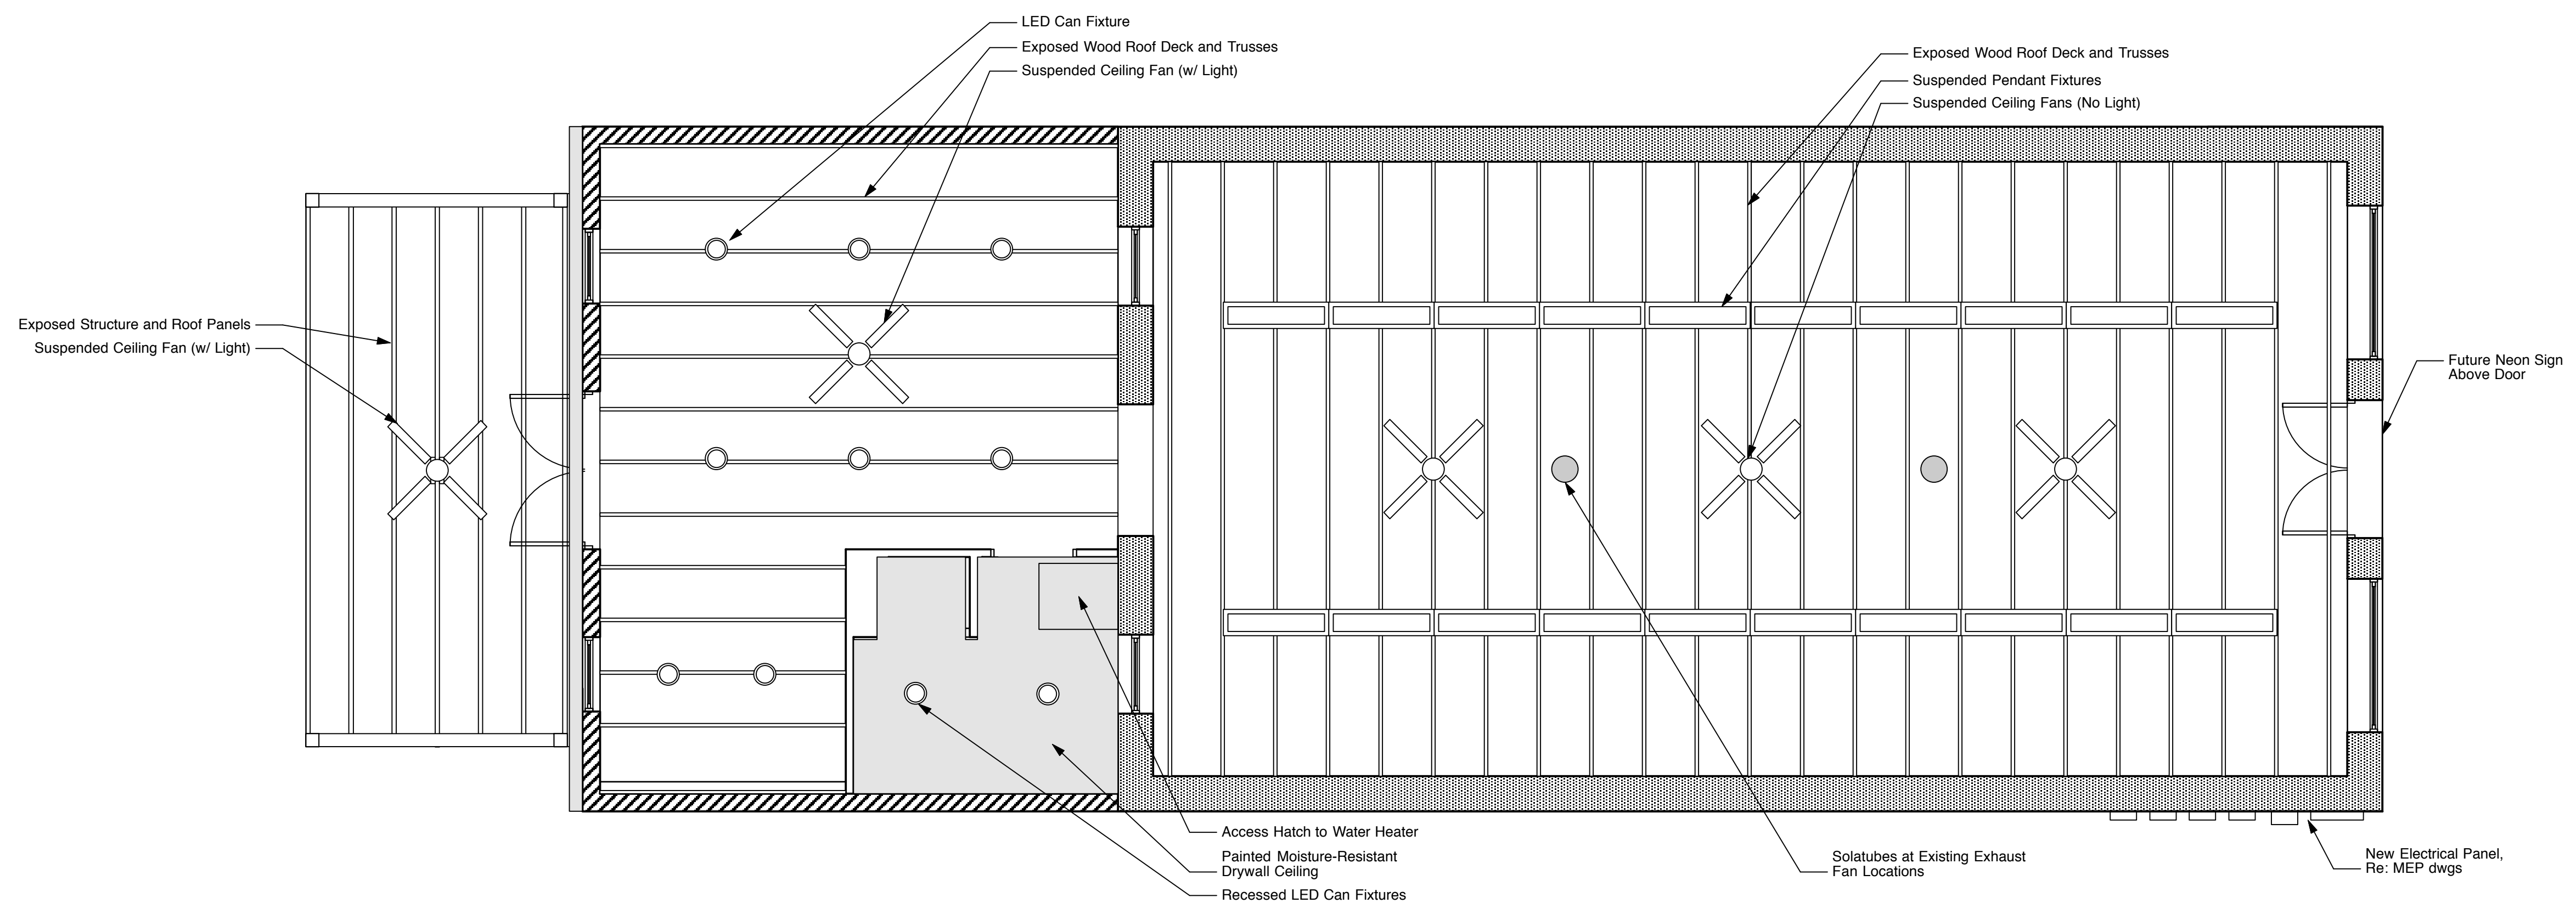

**01 Reflected Ceiling Plan (RCP)**  
Scale: 1/4" = 1'-0"