


A
A-1

OVERALL FLOOR PLAN
SCALE: 1/16" = 1'-0"


NORTH

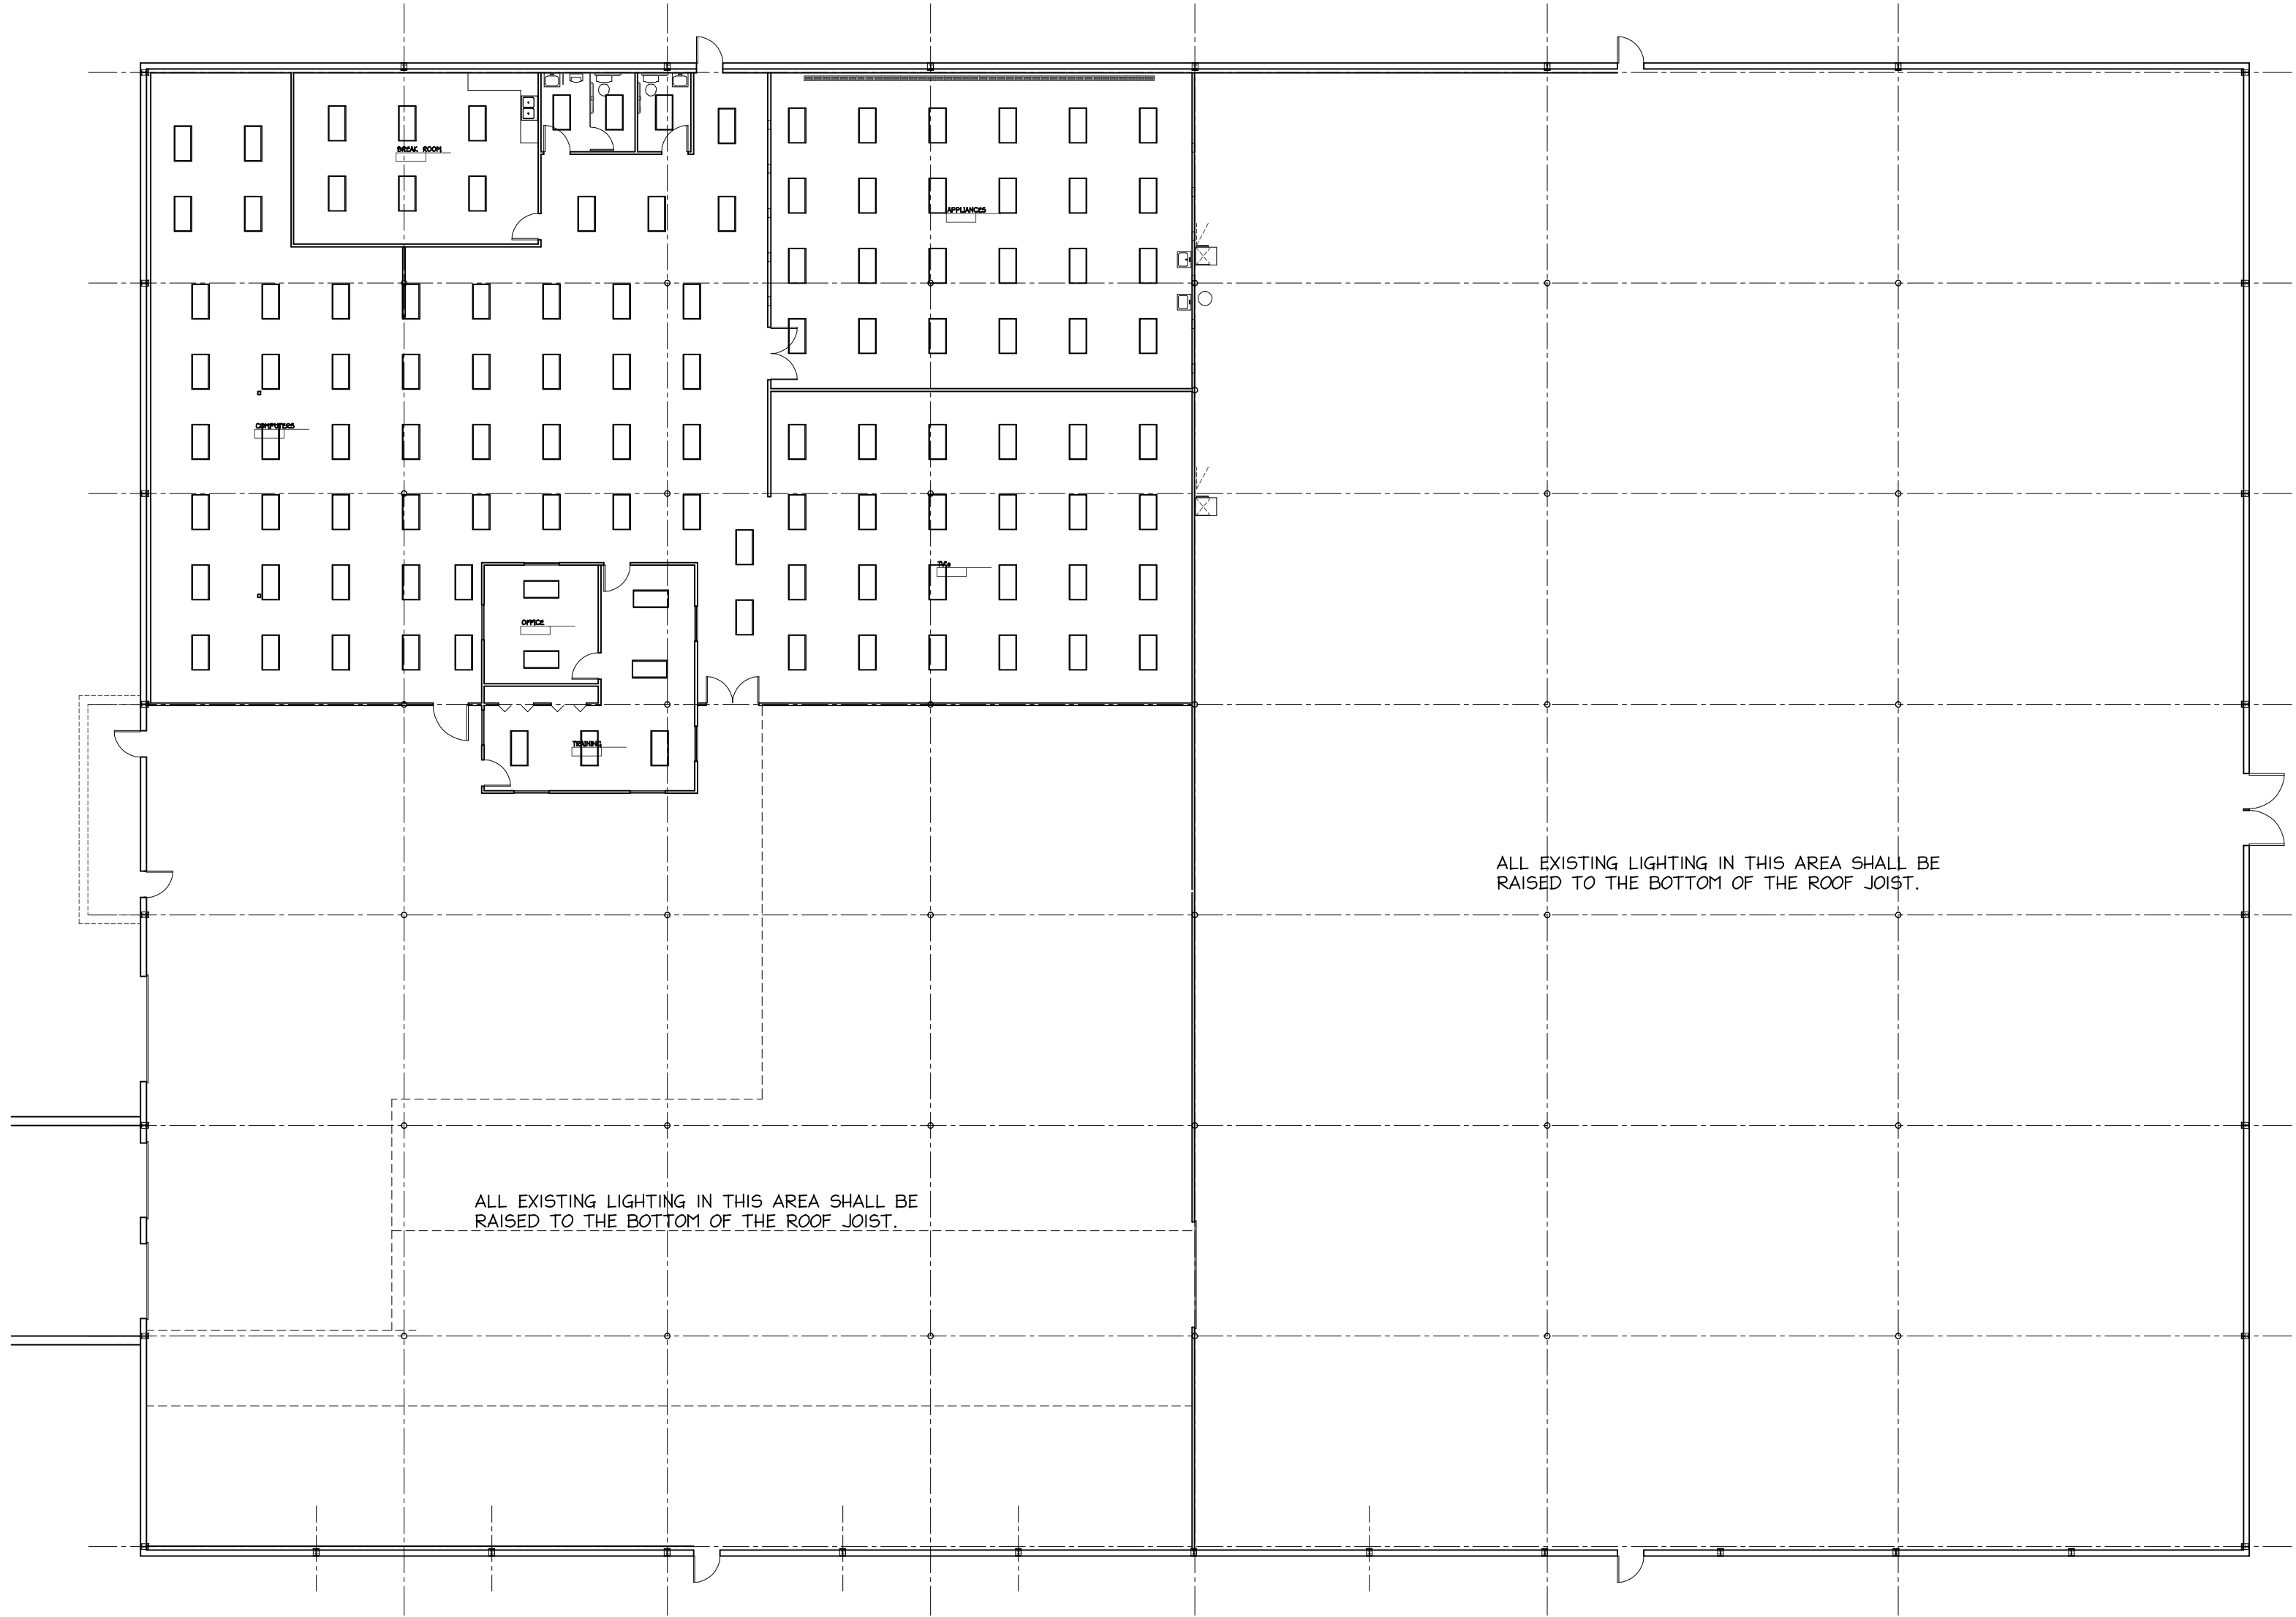

ELECTRICAL SYMBOLS LEGEND

- 












FLUORESCENT LIGHT FIXTURE AS SCHEDULED

FLUORESCENT LIGHT FIXTURE AS SCHEDULED

FLUORESCENT LIGHT FIXTURE AS SCHEDULED

CEILING PENDANT INCANDESCENT LIGHT FIXTURE AS SCHEDULED

SURFACE MTD. OR RECESSED INCANDESCENT LIGHT FIXTURE AS SCHEDULED

EXTERIOR SURFACE MOUNTED INCANDESCENT LIGHT AS SCHEDULED

WALL OR CLG MTD. EXIT LIGHT AS SCHEDULED

POWER PANEL (PP)

THREE-WAY LIGHT SWITCH - + 54" A.F.F.

SINGLE POLE LIGHT SWITCH - TOP @ + 54" A.F.F.

A.F.F.

A.C.

W.P.

G.F.I.















ABOVE FINISH FLOOR

ABOVE COUNTER

WEATHERPROOF

GROUND FAULT INTERRUPTING TYPE CIRCUIT

BATTERY OPERATED EMERGENCY LIGHT UNIT

MANUAL MOTOR STARTER

MOTOR OUTLET

DISCONNECT SWITCH


WALL MTD. 120V. QUADPLEX CONVENIENCE OUTLET - 6 44" A.F.F. UNLESS NOTED OTHERWISE

WALL MTD. 120V. DUPLEX CONVENIENCE OUTLET - 6 12" A.F.F. UNLESS NOTED OTHERWISE

WALL MTD. 220V. 30A OUTLET - 6 24" A.F.F. UNLESS NOTED OTHERWISE

JOB NAME: RENOVATIONS TO EXISTING BUILDING FOR:
RENT ONE

DRAWING TITLE: OVERALL LIGHTING PLAN			
PLOT SCALE: 1:1	DWN BY: JM	FILE NAME: 1091680	
DATE: November 2, 2009	APP. BY: KLP	JOB NUMBER: 1091680	ILLINOIS PROFESSIONAL DESIGN FIRM NUMBER: 164001614

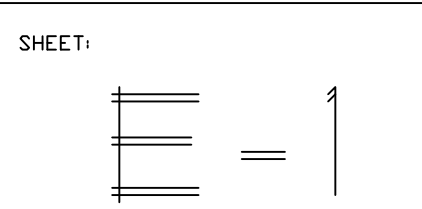

Round Table Design INC.
ARCHITECTURE – PROFESSIONAL ENGINEERING – LAND SURVEYING
1020 MAIN STREET MT.VERNON ILLINOIS (618) 244-7819